
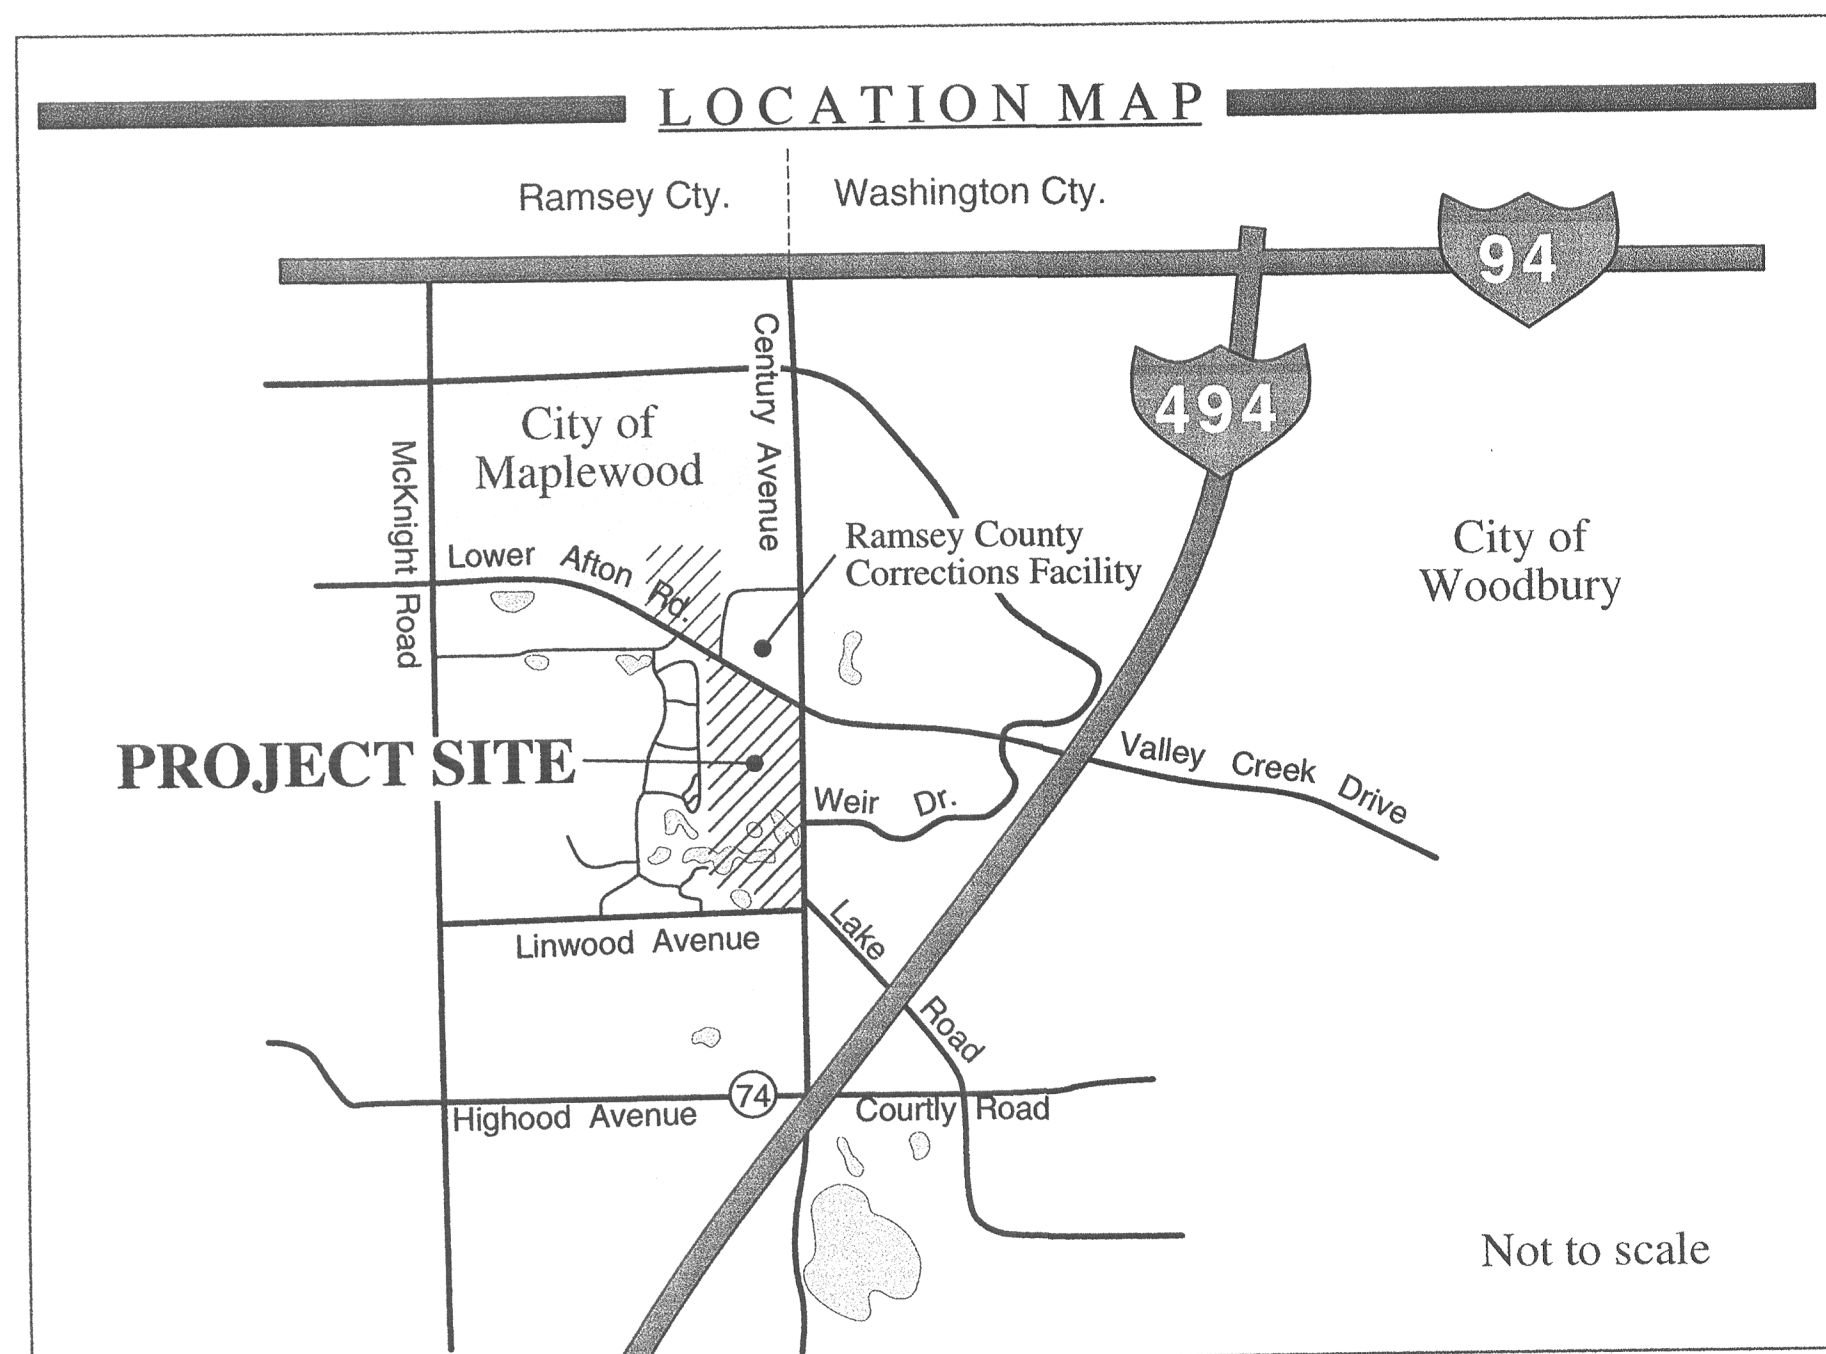


Ramsey County through its Parks and Recreation and Community Corrections Departments  
 2015 North Van Dyke Street, Maplewood, MN 55109-3796

# The Ponds at Battle Creek

## Card of the Course

Hole	Black	Blue	Par	Gold	Green	Red
1	383	355	4	337	303	232
2	190	160	3	145	130	90
3	537	512	5	492	439	121
4	210	185	3	175	150	130
5	493	475	5	438	410	290
6	160	140	3	124	100	87
7	465	443	5	422	402	270
8	159	146	3	114	98	75
9	420	395	4	363	301	263
<b>Total</b>	<b>3,017</b>	<b>2,811</b>	<b>35</b>	<b>2,610</b>	<b>2,333</b>	<b>1,558</b>

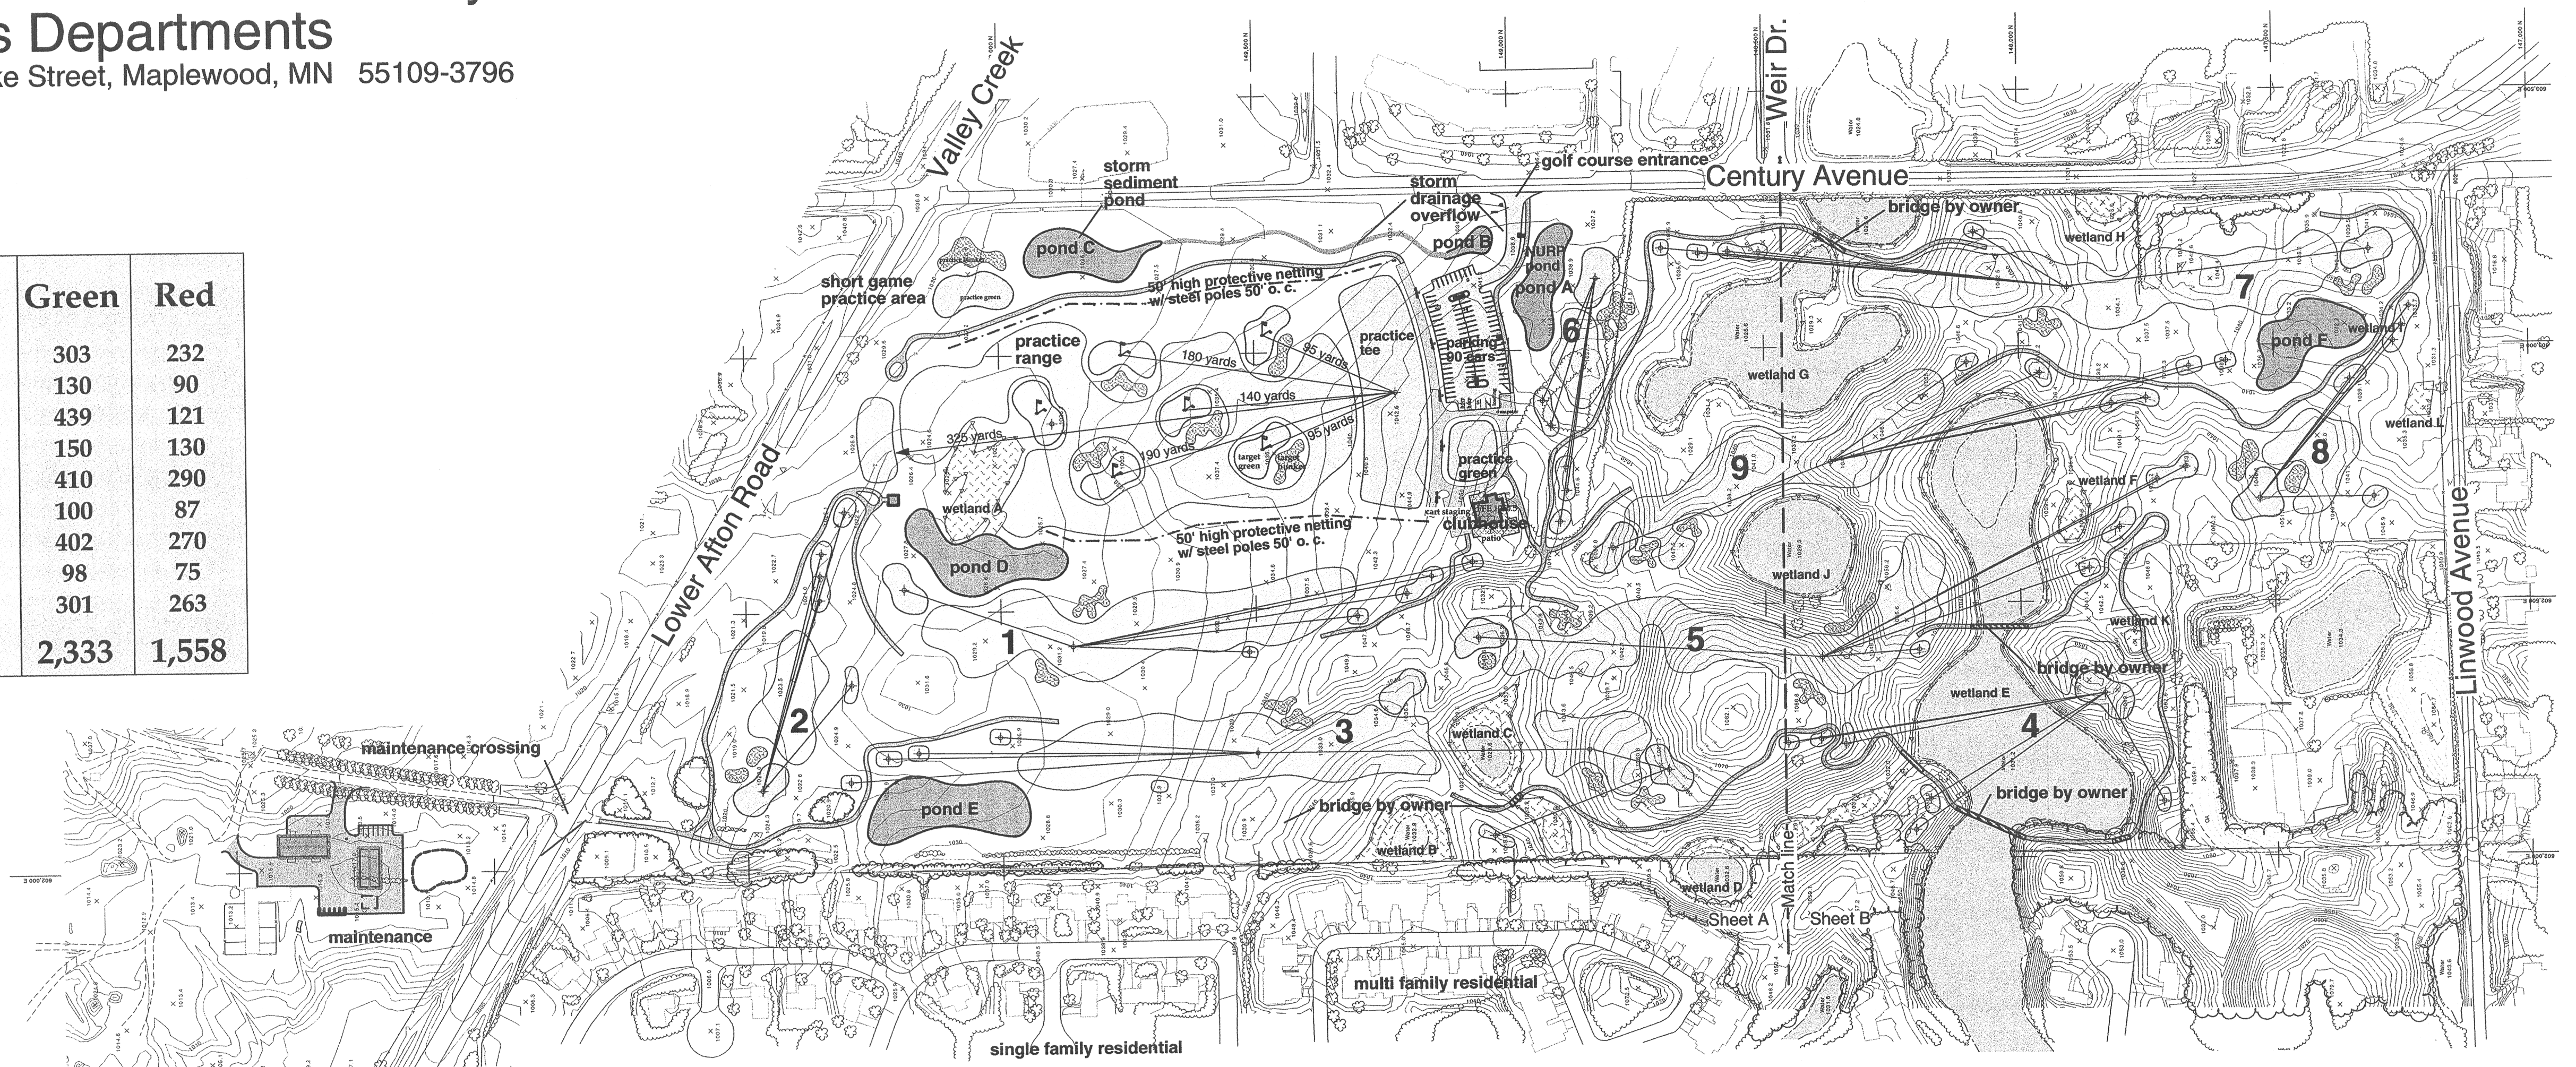

### SHEET TITLE

CS1	COVER SHEET (200 scale)
GD1	GRADING, DRAINAGE, & EROSION CONTROL PLAN A
GD2	GRADING, DRAINAGE, & EROSION CONTROL PLAN B

### PROJECT DIRECTORY

**AUTHORIZED REPRESENTATIVE:**  
 Mr. Kevin Finley  
 Director of Administration and Golf Operations  
 Ramsey County Parks and Recreation Department  
 2015 North Van Dyke Street  
 Maplewood, MN 55109-3796  
 phone: 651.748.2500 ext.328  
 fax: 651.748.2502

**GOLF COURSE ARCHITECT:**  
 GILL MILLER  
 Golf Course Architects  
 122 North 2nd Street  
 River Falls, WI 54022  
 Phone: 715-425-9511  
 Facsimile: 715-425-2962

**CLUBHOUSE ARCHITECT:**  
 Hagen Christensen & McLwain  
 Architects P.A.  
 212 Third Avenue North, Suite 550  
 Minneapolis, MN 55401  
 Phone: 612.904.1332  
 fax: 612.904.7366

**ENGINEERING CONSULTANT:**  
 LOUCKS ASSOCIATES  
 Loucks Associates  
 7200 Hemlock Lane  
 Suite 300  
 Minneapolis, MN 55369  
 763.424.5505

**ENVIRONMENTAL CONSULTANT:**  
 GES  
 Graham Environmental Services, Inc.  
 P.O. Box 189  
 Ellsworth, WI 54011  
 phone: 715.647.5110 or  
 888.279.2070  
 fax: 715.647.5209

**IRRIGATION CONSULTANT:**  
 Site Design & Associates Inc.  
 Certified Irrigation Design  
 26 Roberts Street  
 Suite 115  
 Fargo, ND 58102  
 ph: 701.232.8440  
 fax: 701.232.0644

**ELECTRICAL ENGINEERING CONSULTANT:**  
 Paulson & Clark Engineering, Inc.  
 2352 East County Road J.  
 White Bear Lak, MN  
 phone 651.407.6056  
 fax 651.407.6476

February 12, 2002