
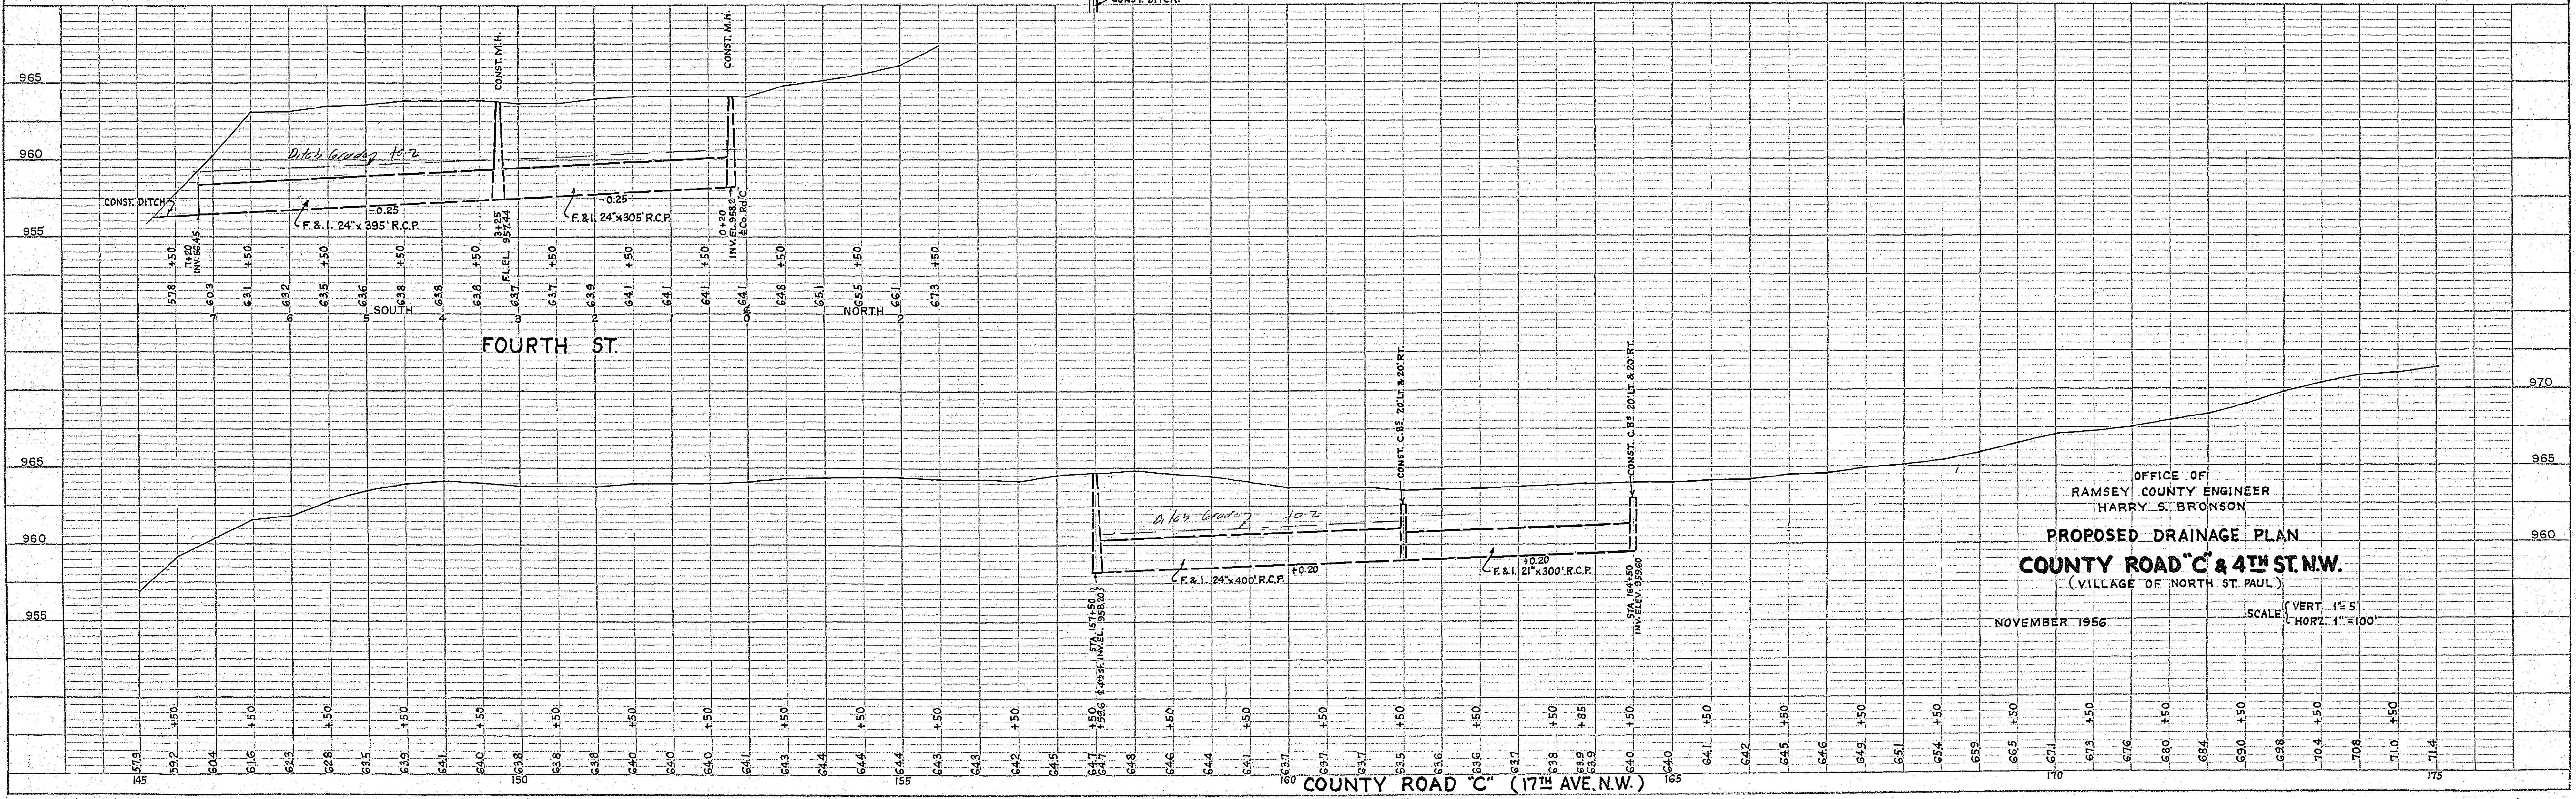


PLAN	SURVEYED	BY	DATE
	PLOTTED		
	ALIGNED		
	CHECKED		
	BY		
	DATE		

PROFILE	SURVEYED	BY	DATE
	PLOTTED		
	ALIGNED		
	CHECKED		
	BY		
	DATE		

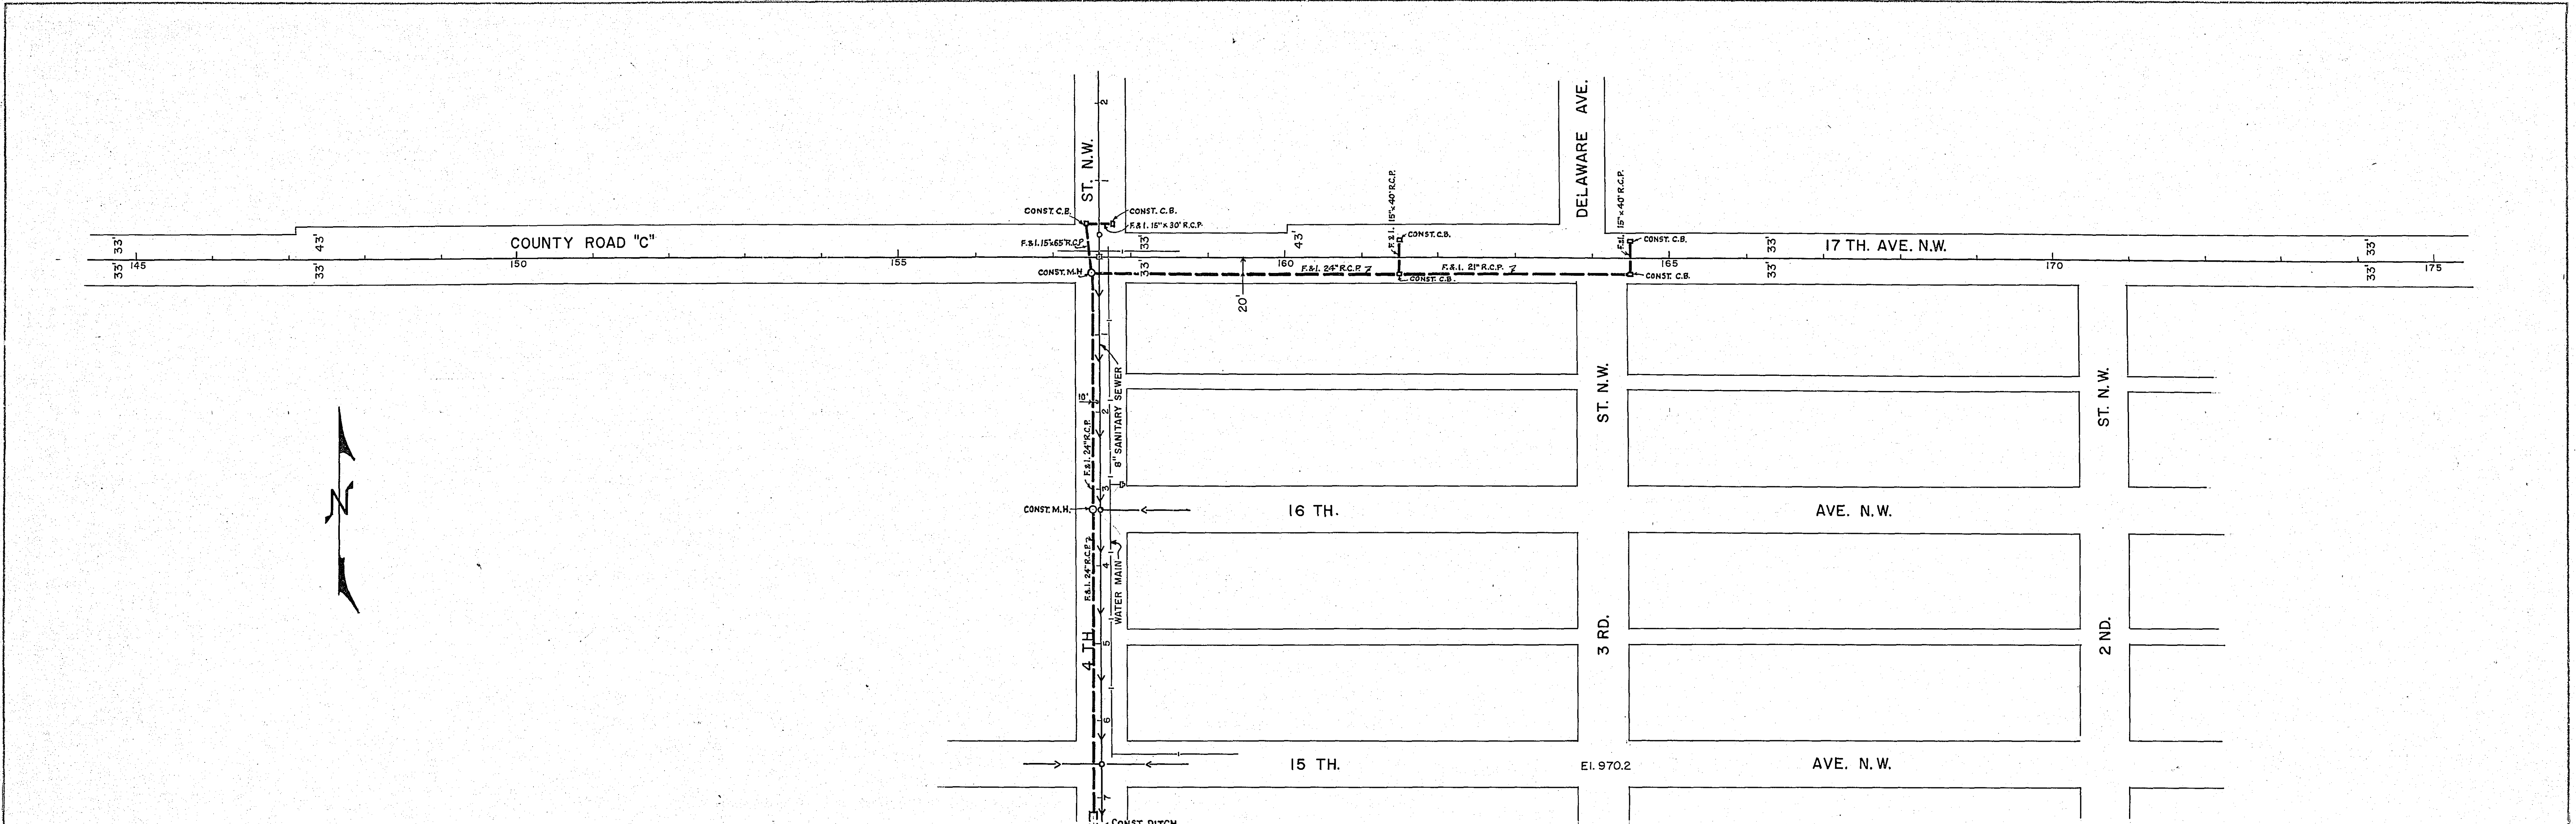

OFFICE OF
 RAMSEY COUNTY ENGINEER
 HARRY S. BRONSON
PROPOSED DRAINAGE PLAN
COUNTY ROAD "C" & 4TH ST. N.W.
 (VILLAGE OF NORTH ST. PAUL)
 NOVEMBER 1956
 SCALE: VERT. 1"=5'
 HORIZ. 1"=100'

6523