


LOAD CENTER CABINET


FUSE 200 AMP.
3 Ø

FUSE 200 AMP.
3 Ø

I 400 AMP.
MAIN

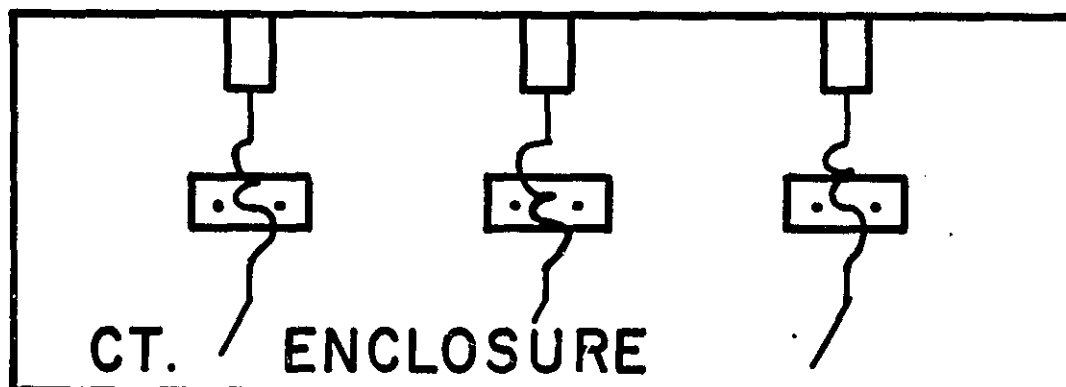

MICROFILMED
RAMSEY CO. ENGR.

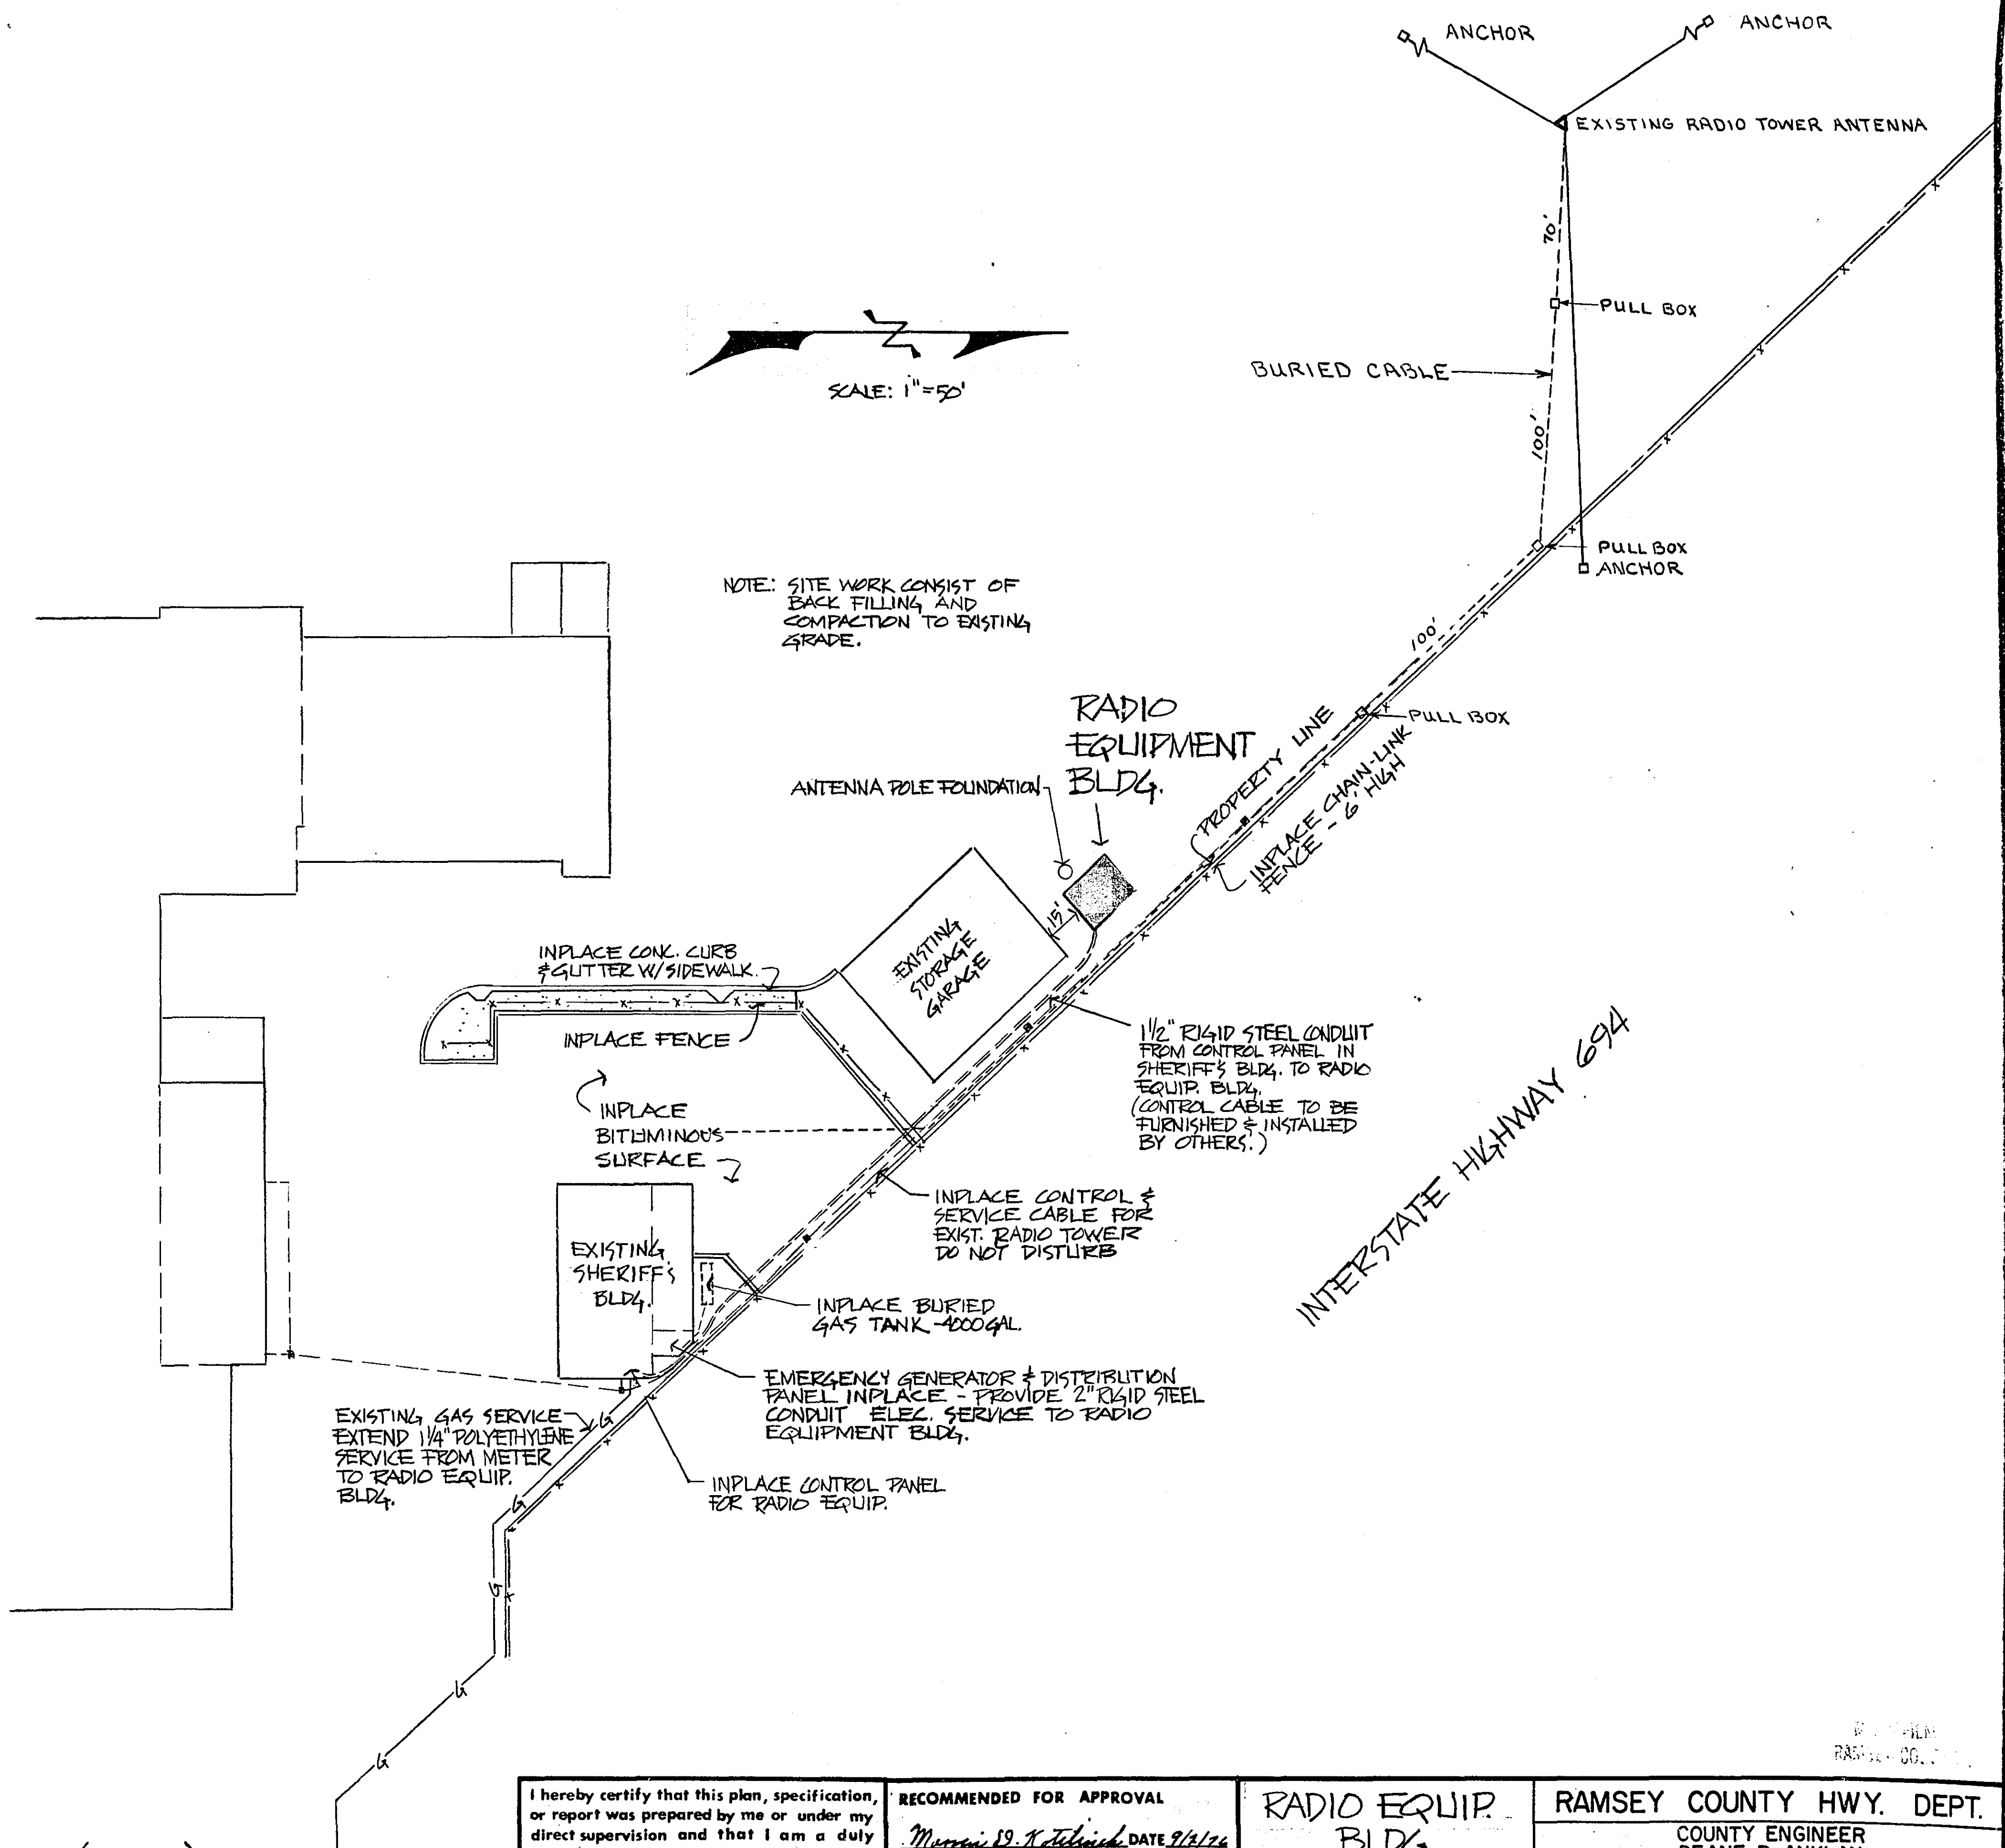

I hereby certify that this plan, specification, or report was prepared by me or under my direct supervision and that I am a duly Registered Professional Engineer under the laws of the State of Minnesota.

Wayne R. Leonard

Date Sept. 2, 1976 Reg. No. 5782

RECOMMENDED FOR APPROVAL

Murray S. K. Teltchick DATE 9/2/76

APPROVED *George H. Vickers*

Donald K. Gorkham DATE 9/2/76

RADIO EQUIP. BLDG.


SITE PLAN

RAMSEY COUNTY HWY. DEPT.


COUNTY ENGINEER DEANE R. ANKLAN

DESIGNED	DRAWN RWW
DATE 5-12-76	CHECKED


SHEET NO. 1 OF 4 SHEETS

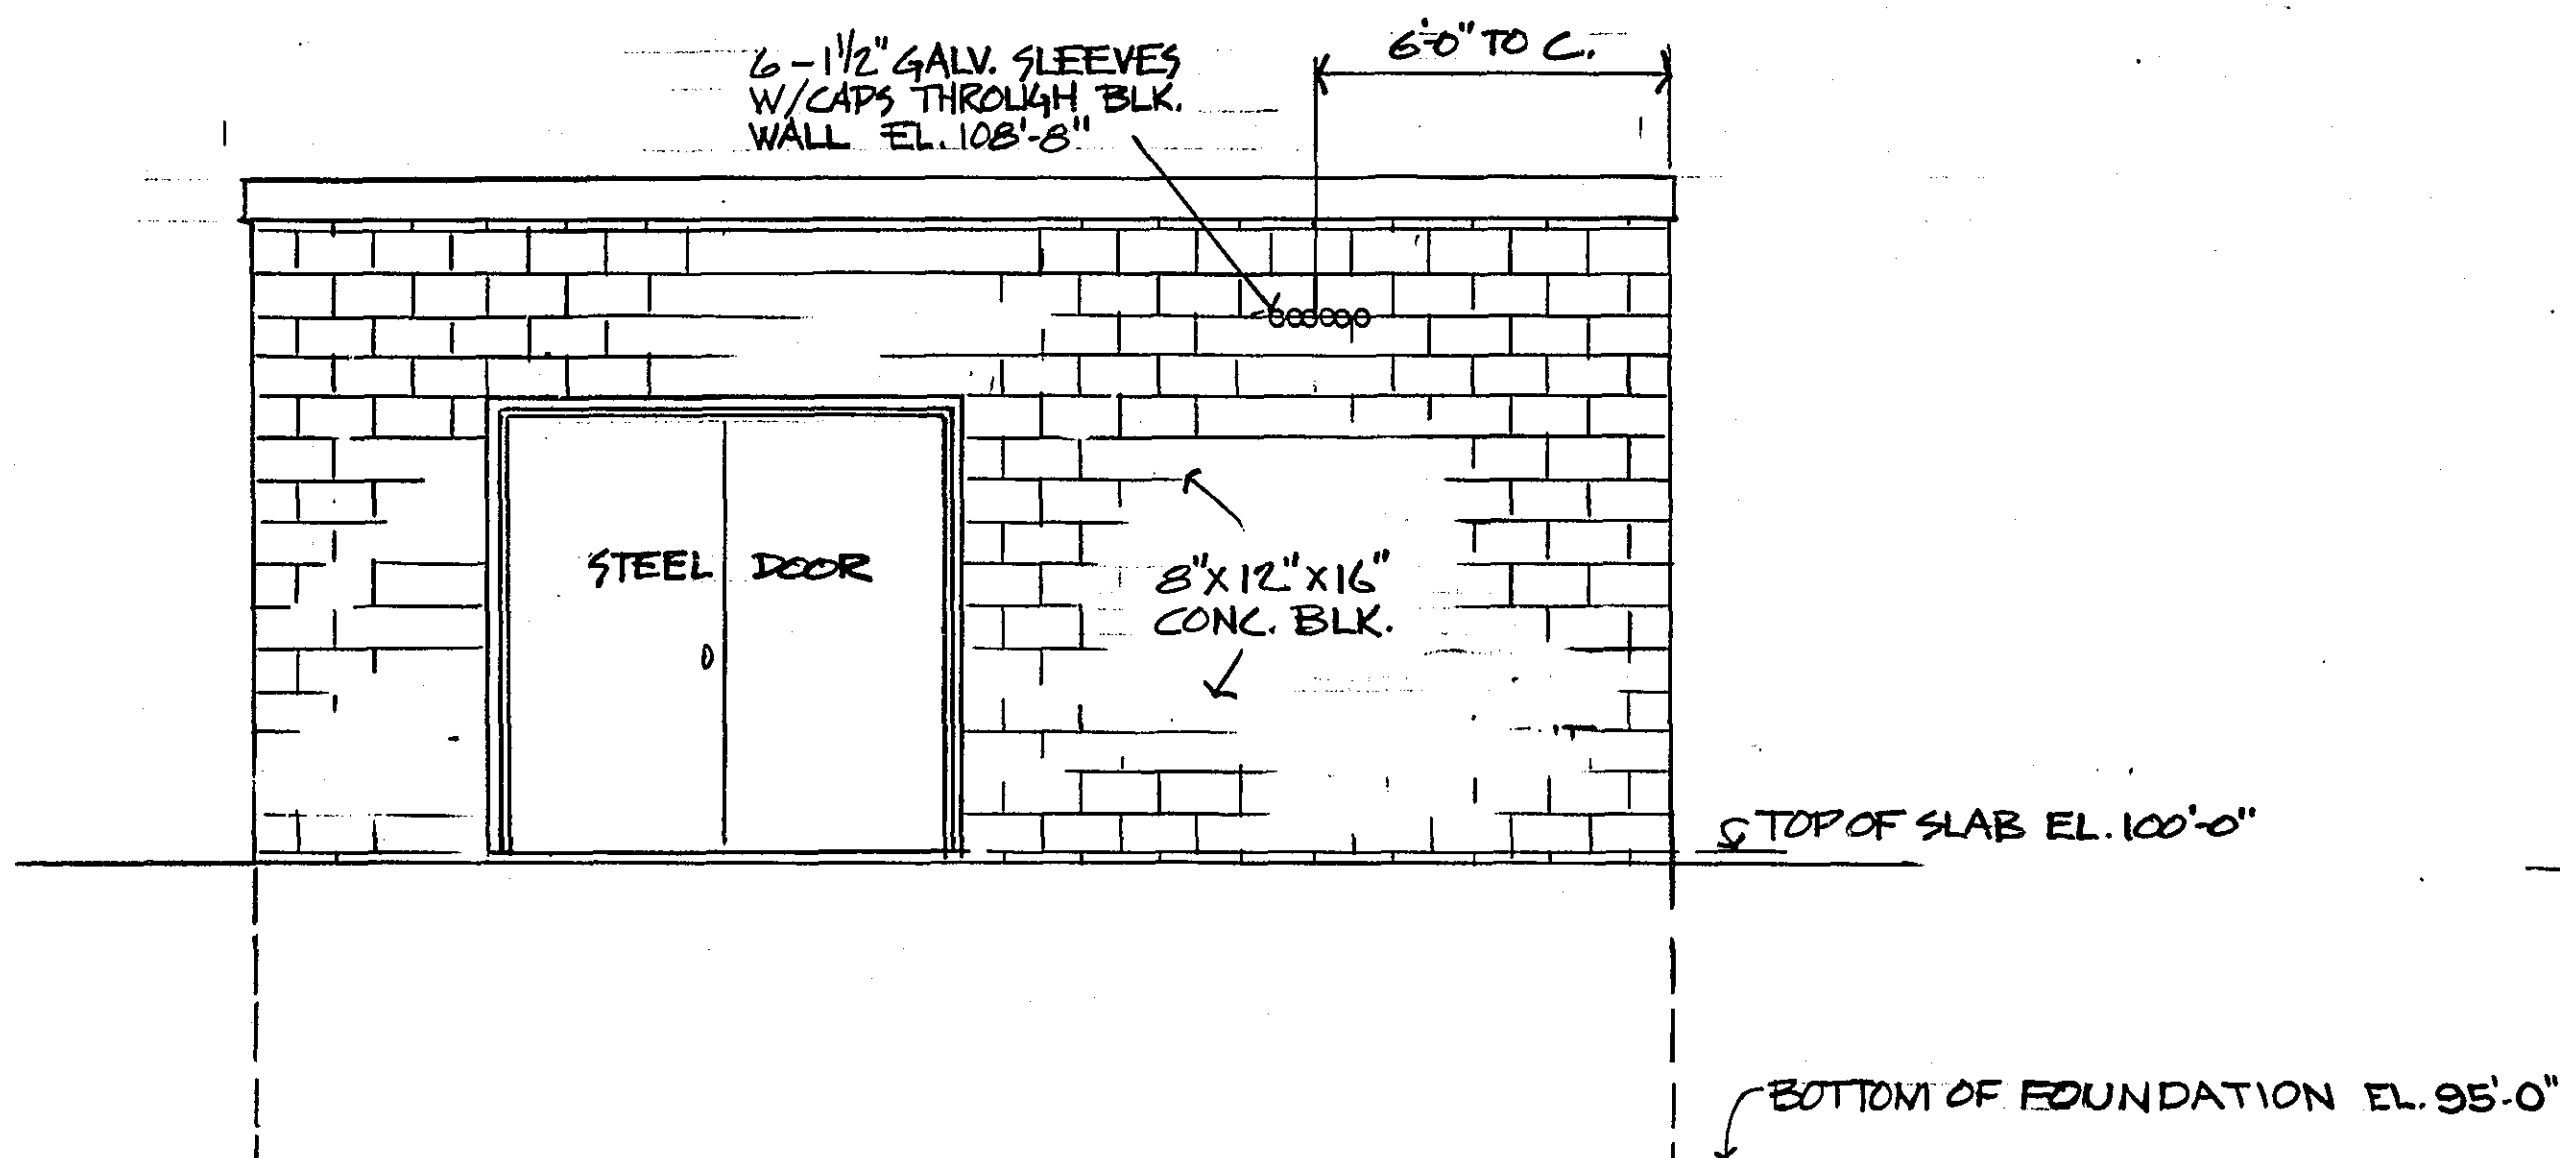


SOUTHWEST ELEV.
SCALE 1/4" = 1'-0"

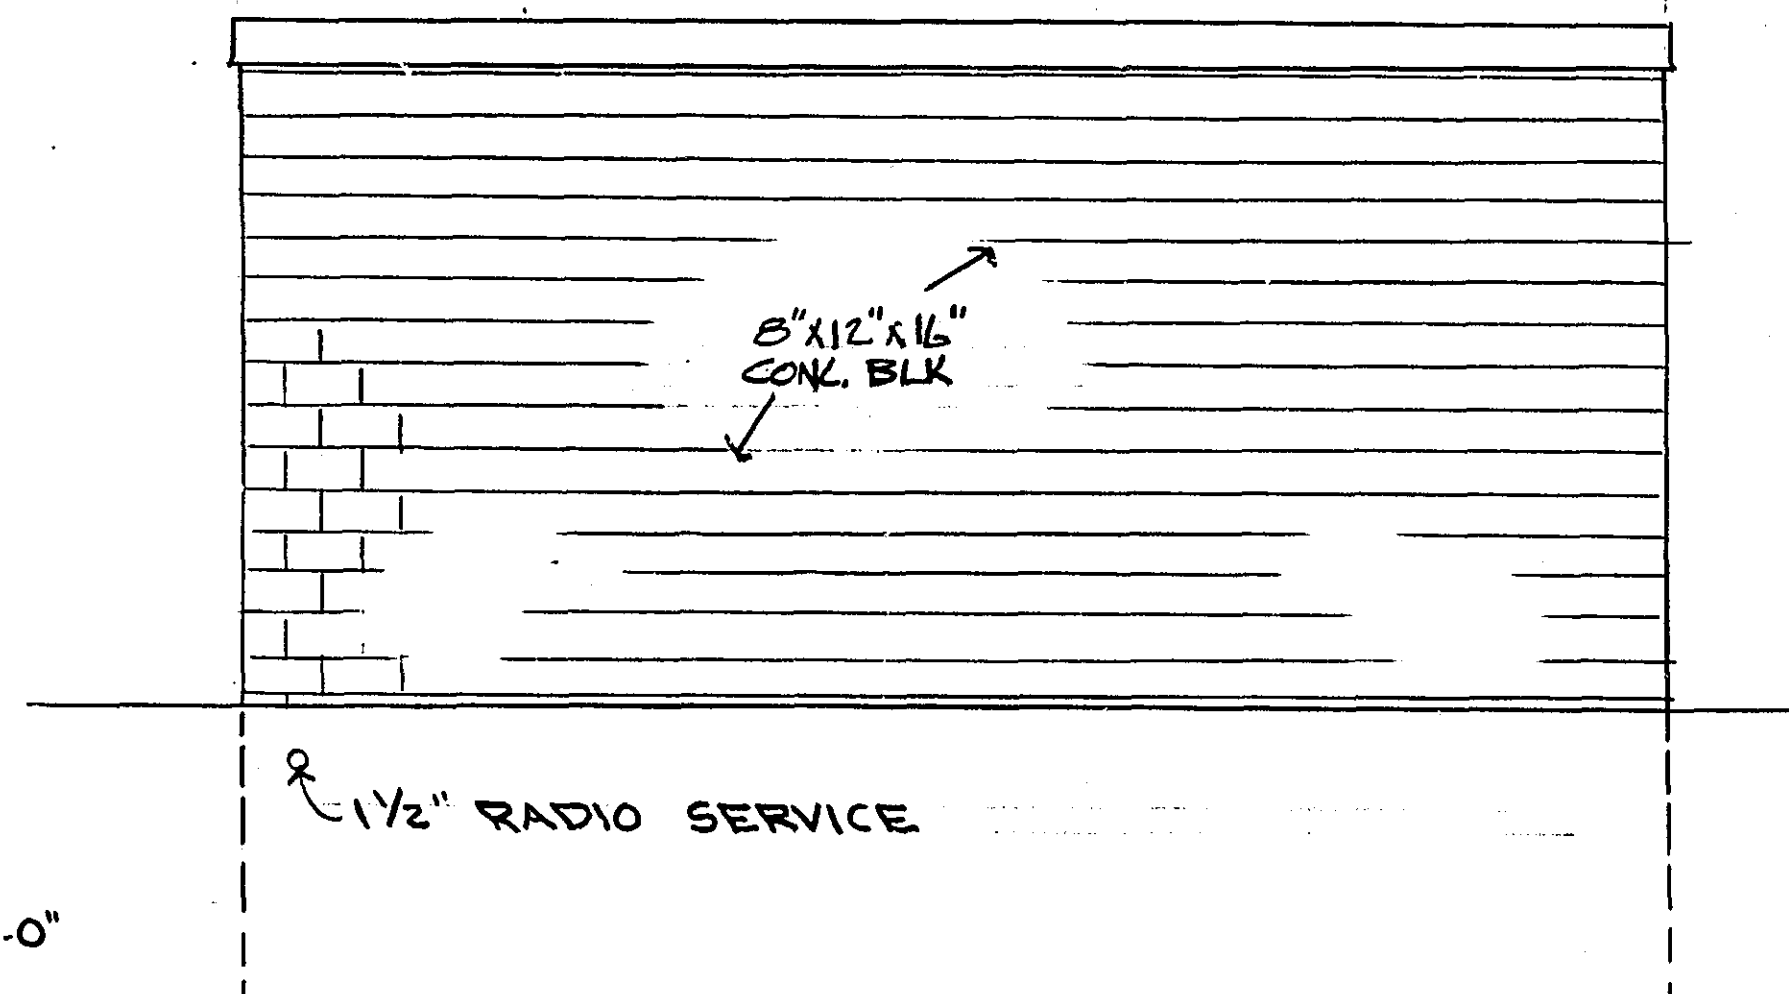

NORTHEAST ELEV.
SCALE 1/4" = 1'-0"

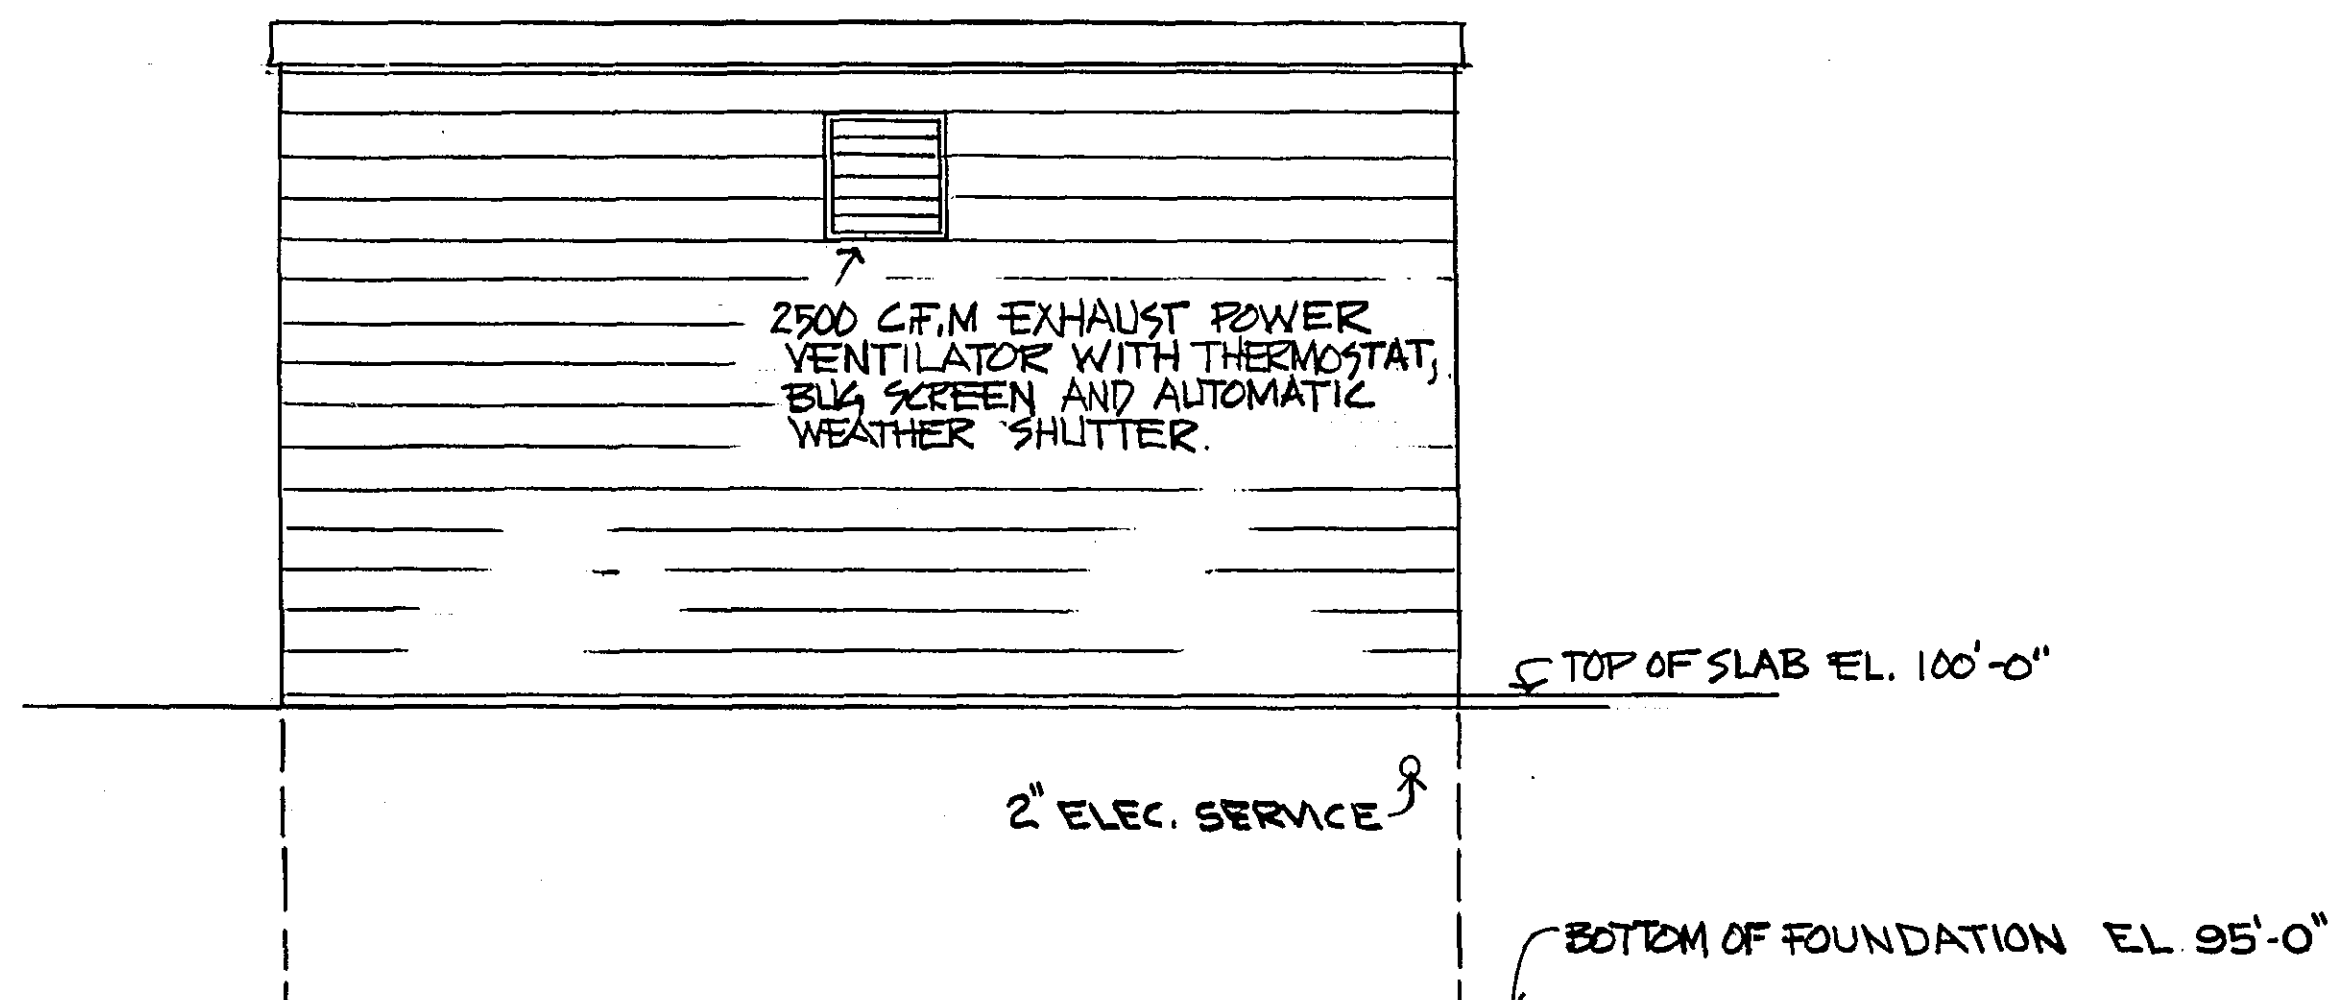



SOUTHEAST ELEV.
SCALE 1/4" = 1'-0"

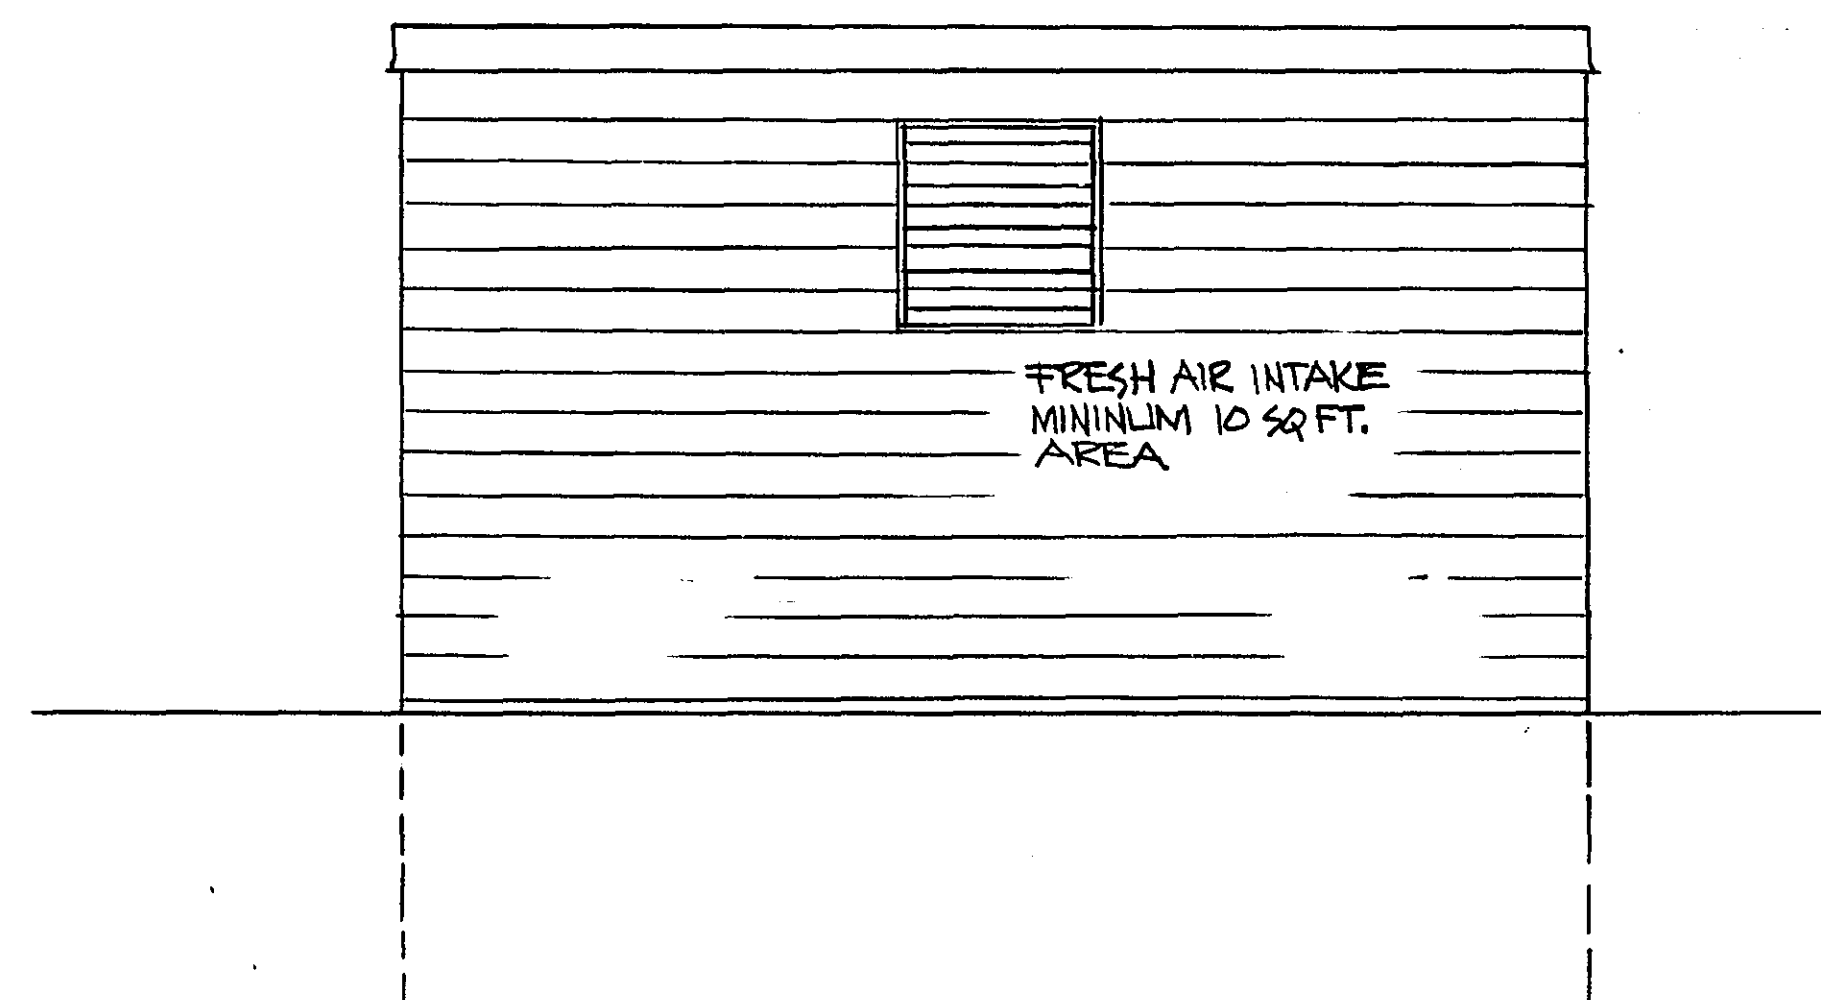

NORTHWEST ELEV.
SCALE 1/4" = 1'-0"

MICROFILMED
RAMSEY CO. ENGR.

I hereby certify that this plan, specification, or report was prepared by me or under my direct supervision and that I am a duly Registered Professional Engineer under the laws of the State of Minnesota. <u>Wayne R. Leonard</u> Date <u>Sept. 2, 1976</u> Reg. No. <u>5782</u>	RECOMMENDED FOR APPROVAL <u>Marion D. Kottelink</u> DATE <u>9/2/76</u>	RADIO EQUIP. BLDG. ELEVATIONS	RAMSEY COUNTY HWY. DEPT.	
	APPROVED <u>James J. Hickey</u> <u>James J. Hickey</u> DATE <u>9/2/76</u>		COUNTY ENGINEER DEANE R. ANKLAN	
			DESIGNED DATE <u>5-12-76</u>	DRAWN <u>RWW</u> CHECKED
	SHEET NO. 2 OF 4 SHEETS			

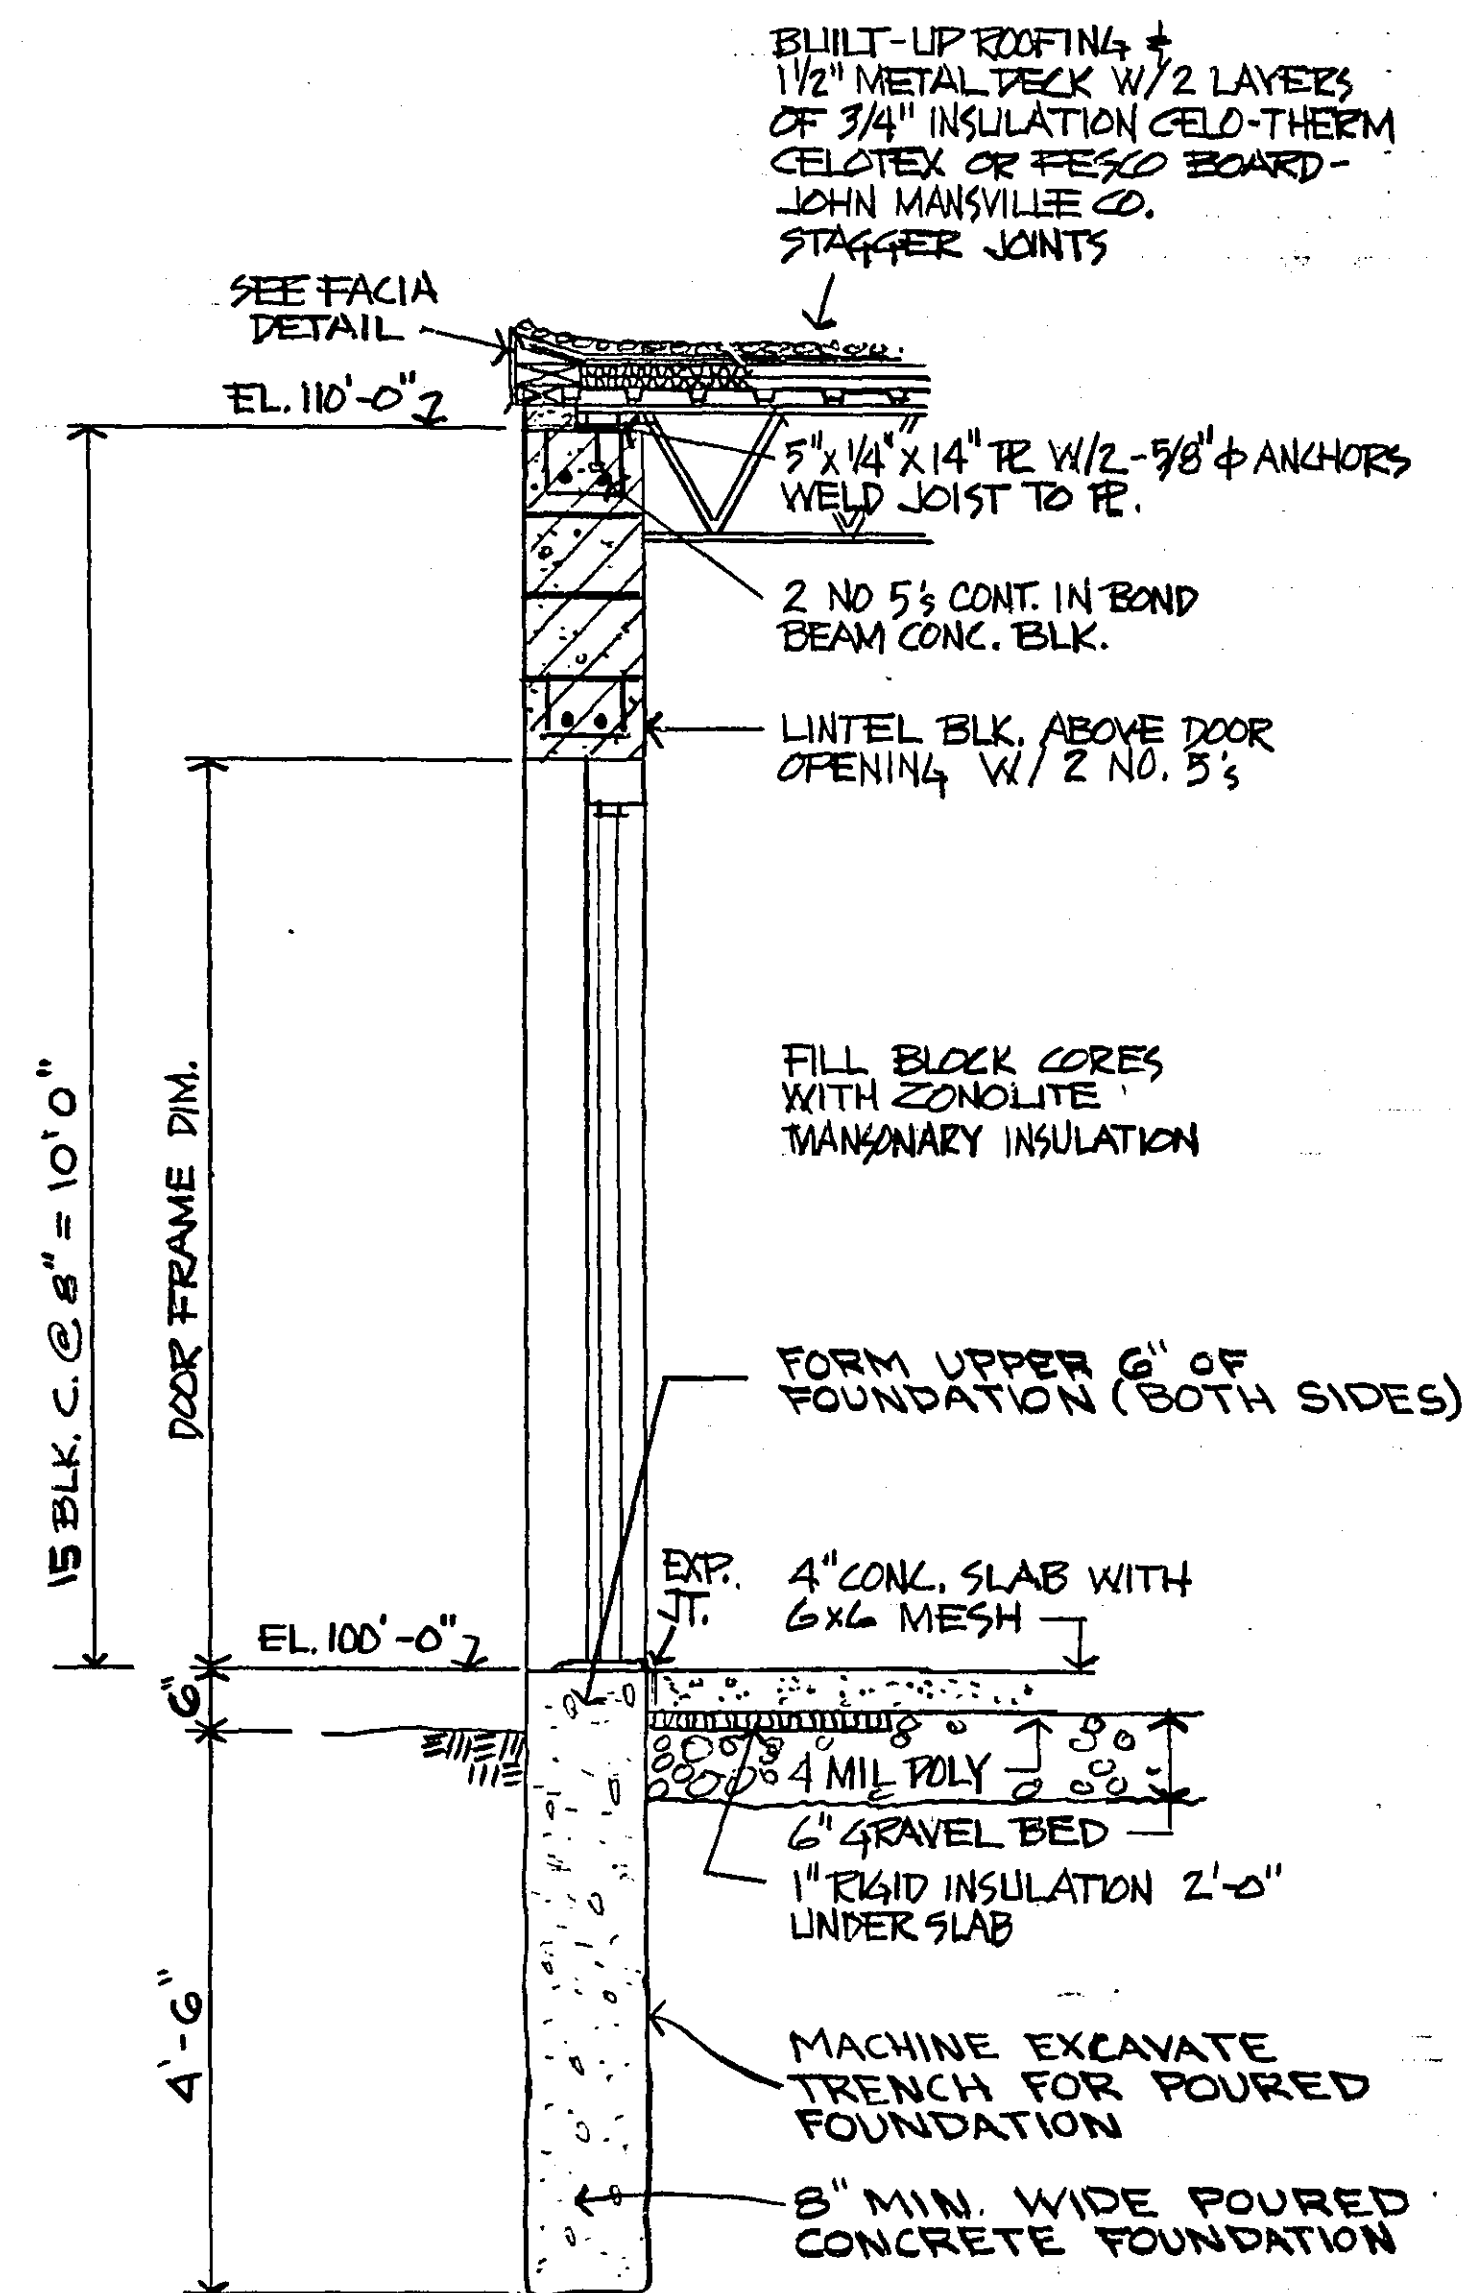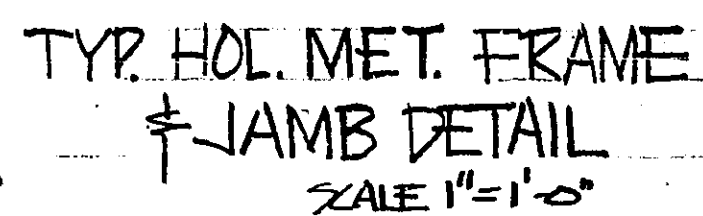

TYPICAL SECTION
SCALE 1/2"=1'-0"



WORK BENCH DETAILS

Wayne R. Leonard
Date Sept. 2, '76 Reg. No. 5782


DATE 9/2/77

FLOOR PLAN & DETAILS

SHEET NO. 3 OF 4 SHEETS

MICROFILMED
RAMSEY CO. ENGR.


- Ⓣ - THERMOSTAT
 □ DISCONNECT SWITCH

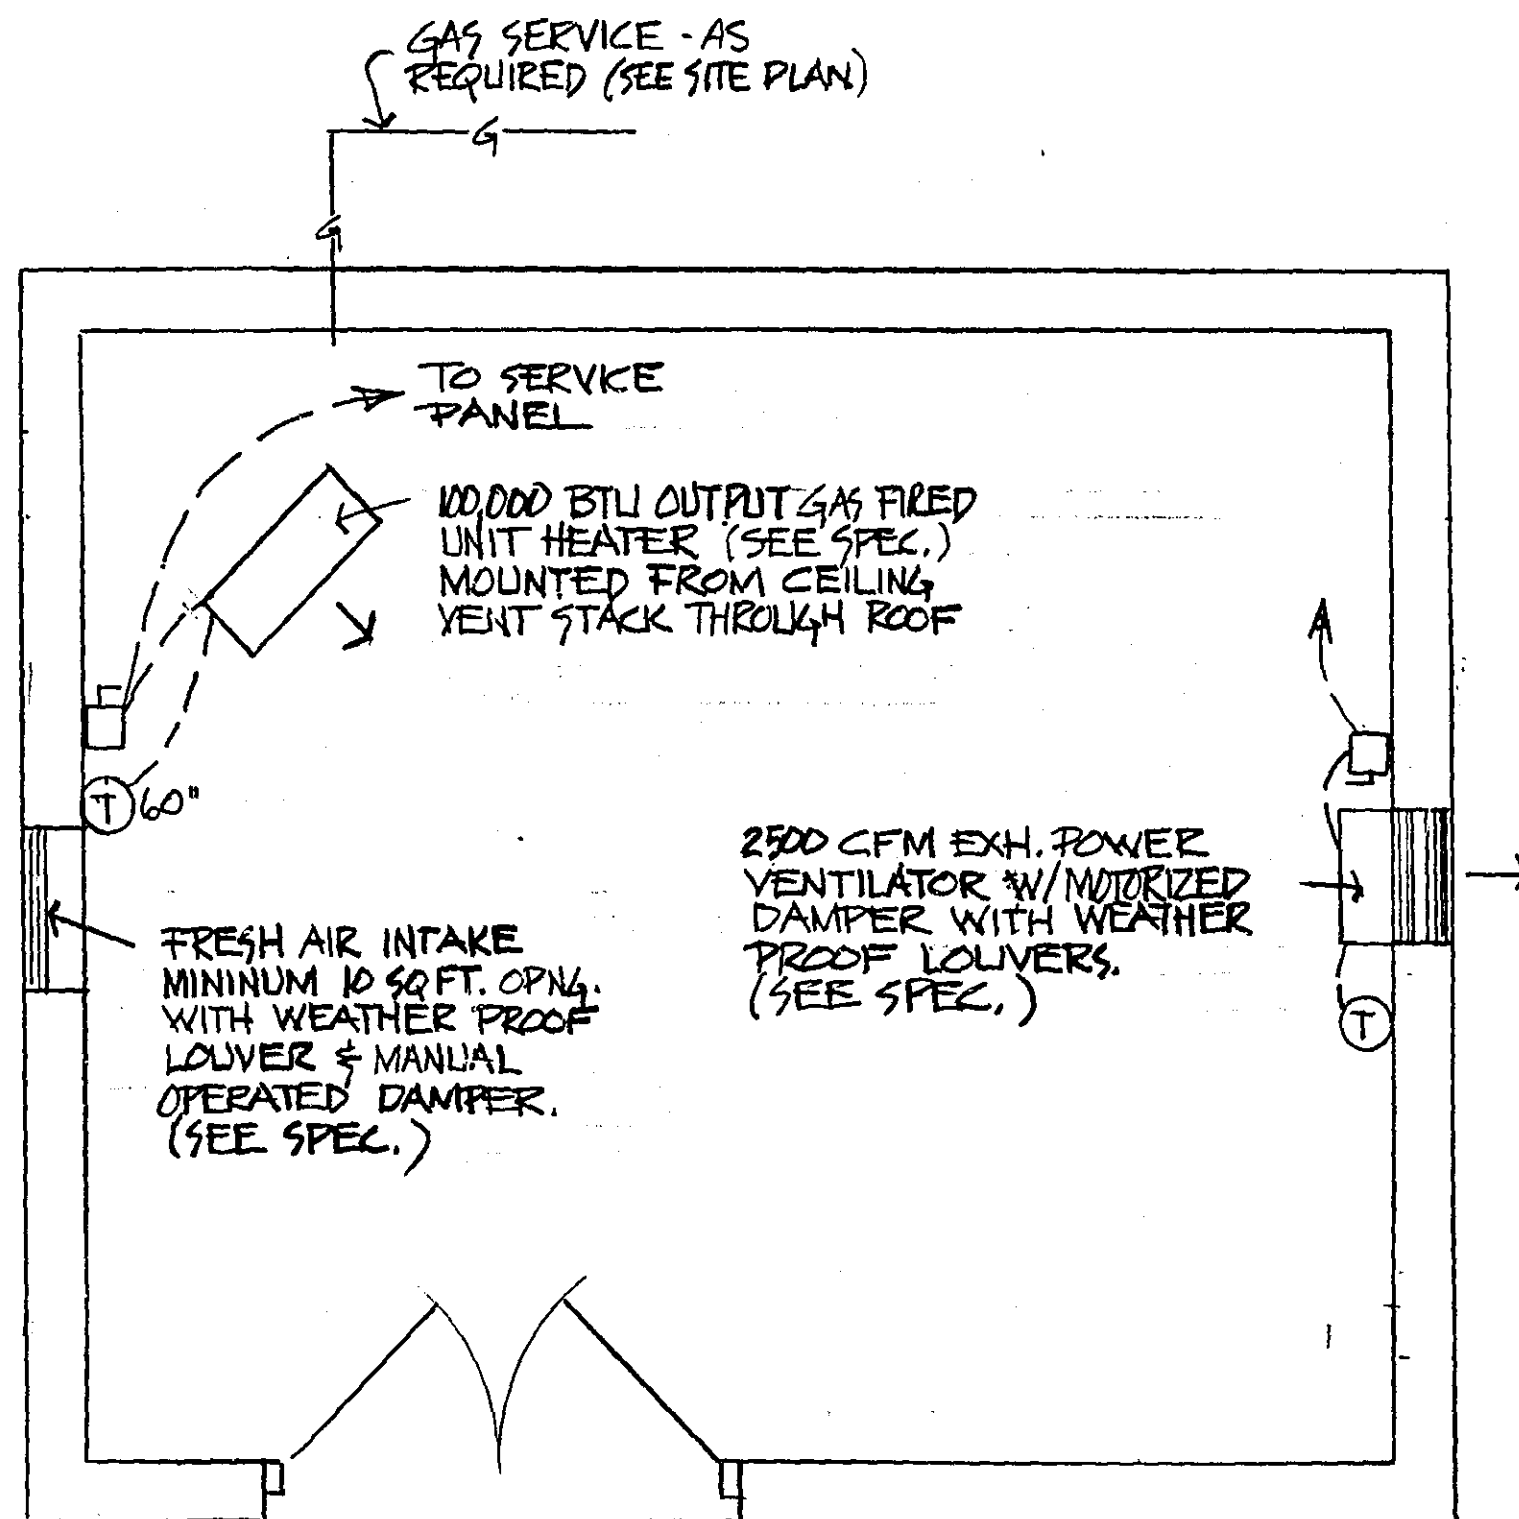

HEATING & VENTILATION PLAN
 SCALE: 1/4" = 1'-0"

- 4"x4" ELEC. BOX MTD. BOTTOM OF JOIST
 ⊕ QUADPLEX RECEPTACLE 48" HGT.
 -15 SWITCH

8' TWO LIGHT FLUORESCENT FIXTURES SHALL BE MOUNTED BOTTOM OF BAR JOIST UNLESS OTHERWISE NOTED.

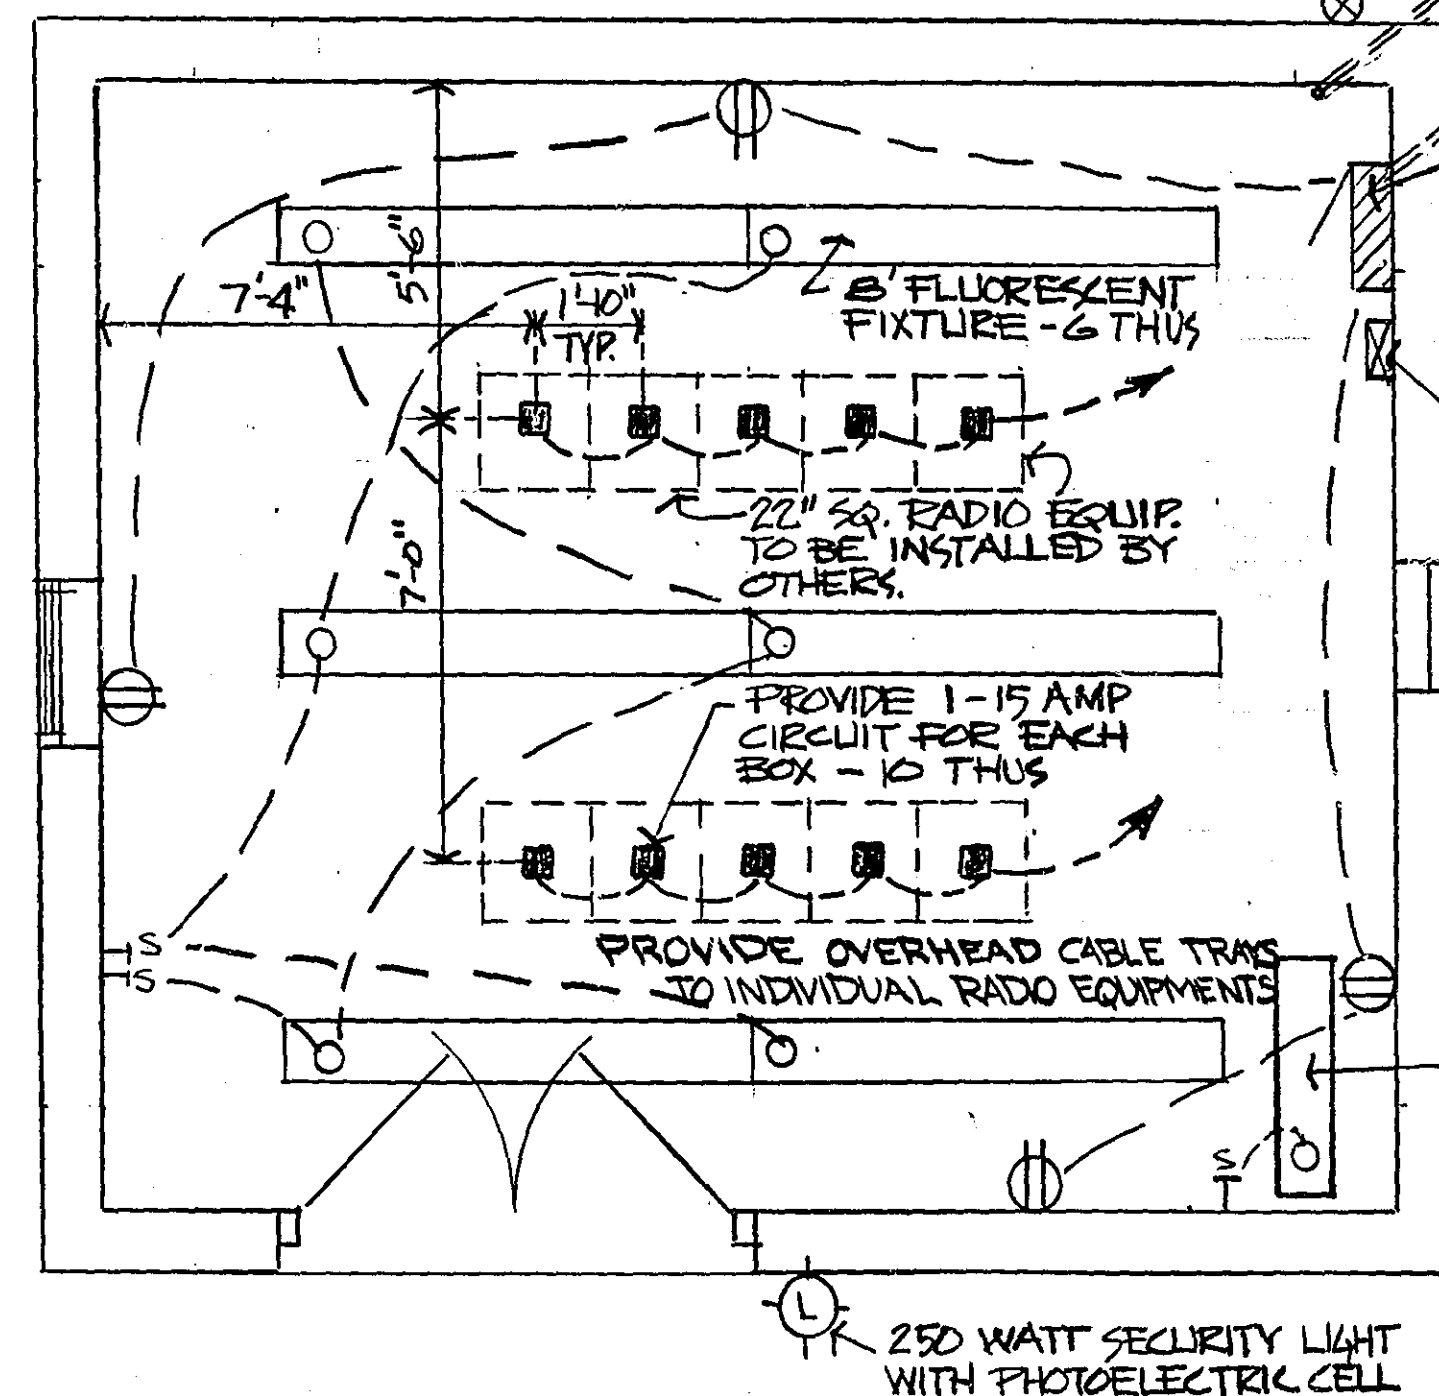

ELECTRICAL PLAN
 SCALE: 1/4" = 1'-0"

I hereby certify that this plan, specification, or report was prepared by me or under my direct supervision and that I am a duly Registered Professional Engineer under the laws of the State of Minnesota.
Wayne R. Leonard
 Date Sept. 2, '76 Reg. No. 5282

RECOMMENDED FOR APPROVAL
Marvin D. Kobilinski DATE 9/2/76
 APPROVED *James H. Hedberg*
James H. Hedberg DATE 9/2/76

RADIO EQUIP. BLDG.
 MECHANICAL & ELECTRICAL

RAMSEY COUNTY HWY. DEPT.
 COUNTY ENGINEER
 DEANE R. ANKLAN
 DESIGNED
 DATE 5-12-76
 DRAWN RWW
 CHECKED
 SHEET NO. 4 OF 4 SHEETS

MICROFILMED
 RAMSEY CO. ENGR.