


SYMBOL CODE

EXISTING CONTOUR 36
NEW CONTOUR 36
PROPERTY LINE
SOIL TEST BORING 3

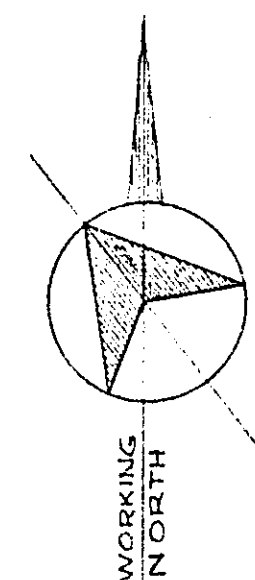


SITE PLAN

SCALE: 1/16" = 1'-0"

BENCH MARK TOP OF HYDRANT EL. 24.22

EAGLE STREET

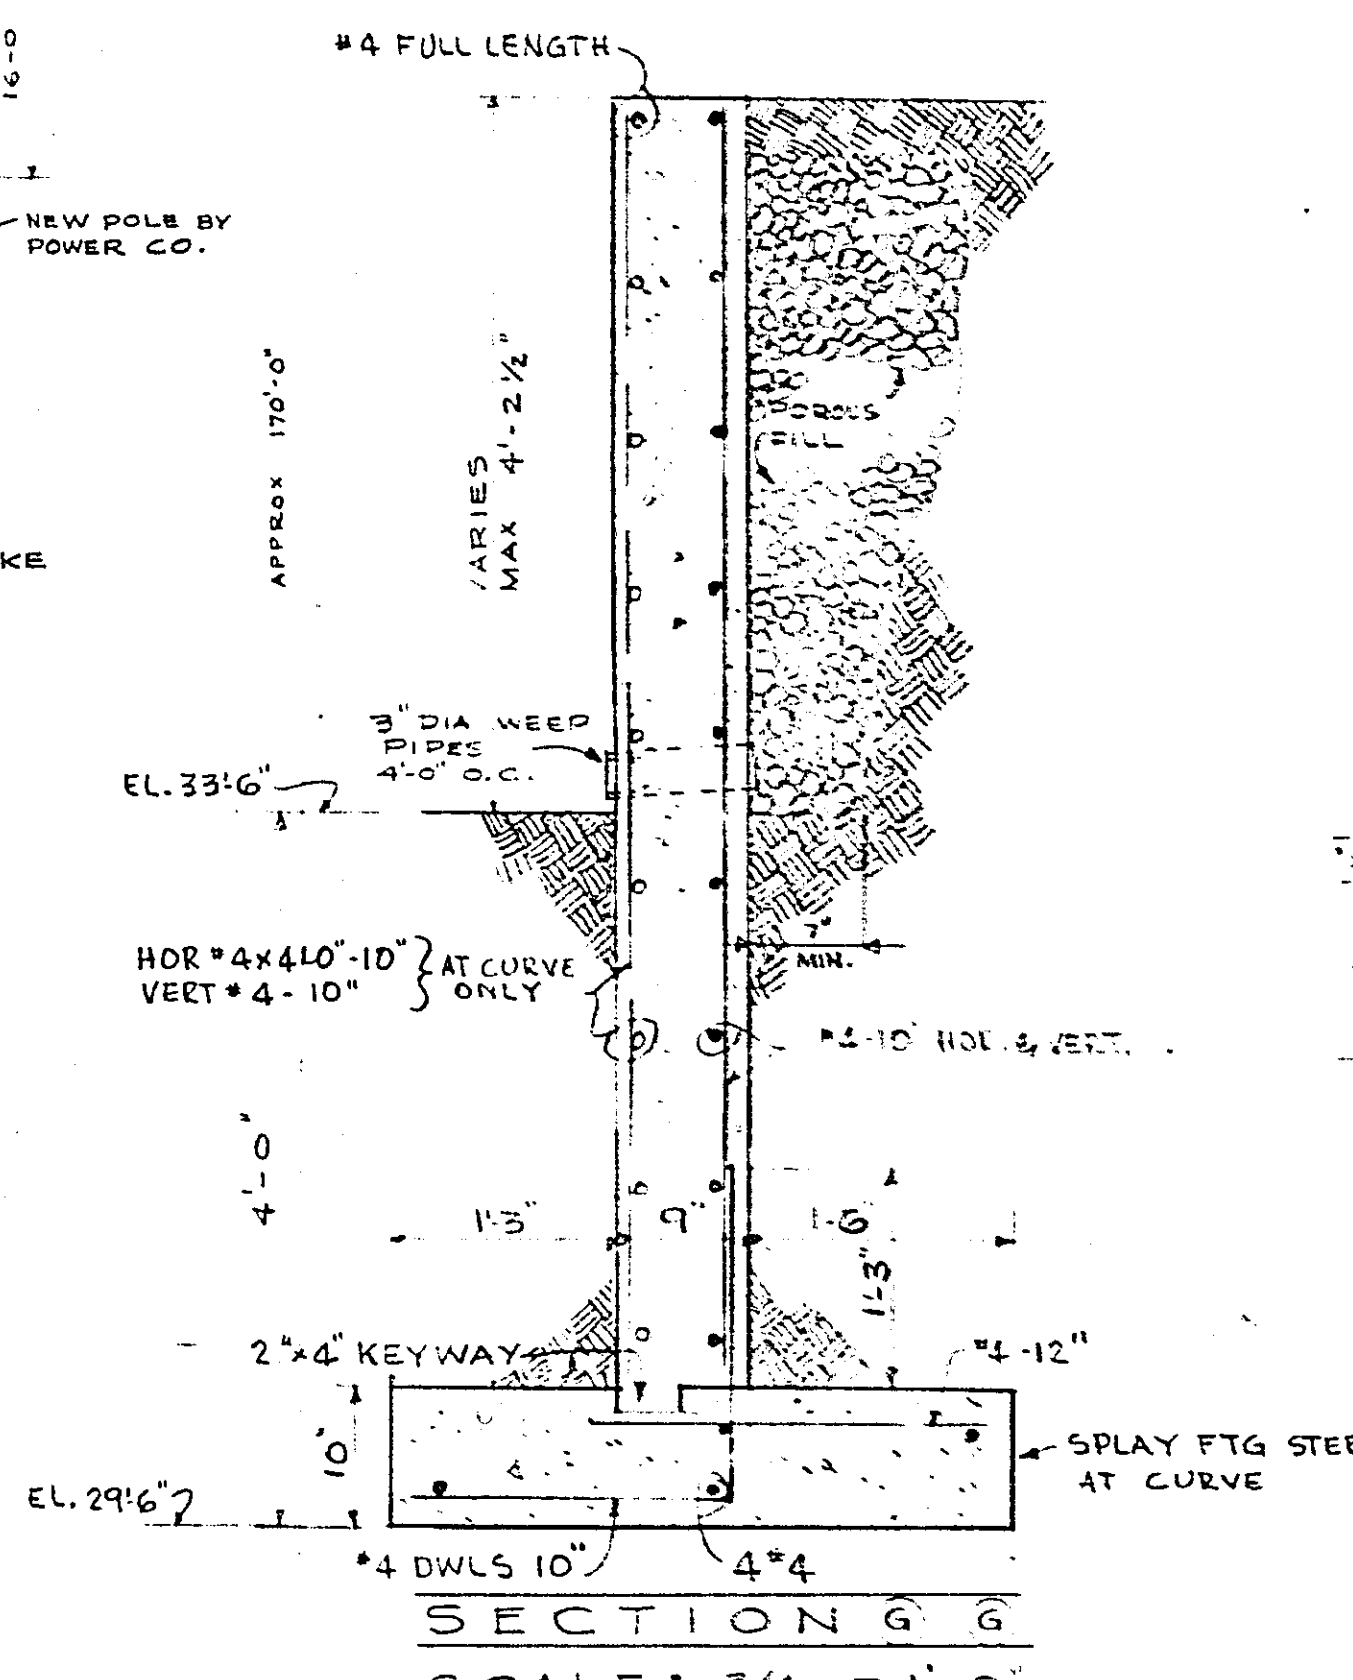


SECTION F F

SCALE: 1/2" = 1'-0"

SECTION THRU STEPPING BLOCKS - WEST ENTRANCE

SCALE: 3/8" = 1'-0"

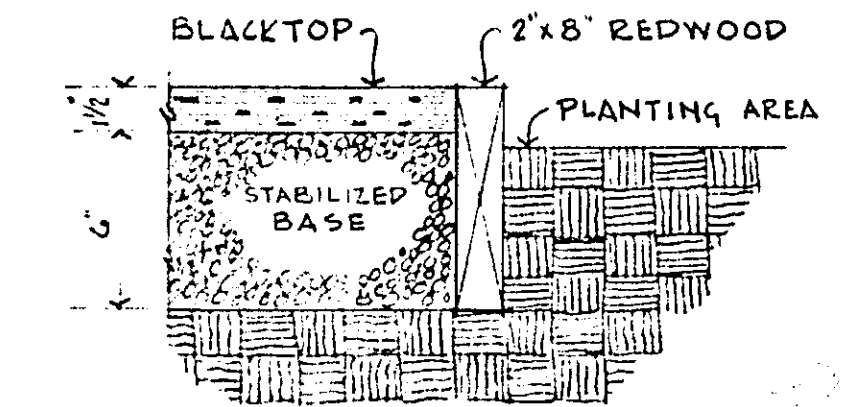

REDWOOD STRIP DETAIL

SCALE: 1/2" = 1'-0"

SHEET SCHEDULE	
NUMBER	TITLE
A-1	PLOT PLAN
A-2	FLOOR PLANS
A-3	ELEVATIONS
A-4	WALL SECTIONS
A-5	STAIR DETAILS
A-6	ENTRANCE DETAILS
A-7	DOORS & MILLWORK
A-8	PENTHOUSE & MISC. DETAILS

PLOT PLAN


RAMSEY COUNTY CORONERS OFFICE

ST. PAUL, MINNESOTA


TOLTZ, KING, DUVALL, ANDERSON AND ASSOCIATES, INC.
ST. PAUL, MINNESOTA
ENGINEERS AND ARCHITECTS

DESIGNED: I hereby certify that this plan was prepared by me or under my direct supervision and that I am a duly registered ARCHITECT under the laws of the State of Minnesota.
DRAWN: *Shirley A. Anderson*
CHECKED: *Shirley A. Anderson*
Date: OCTOBER 7, 1963 Reg. No. 685


COM. 4603 DRG. A-1

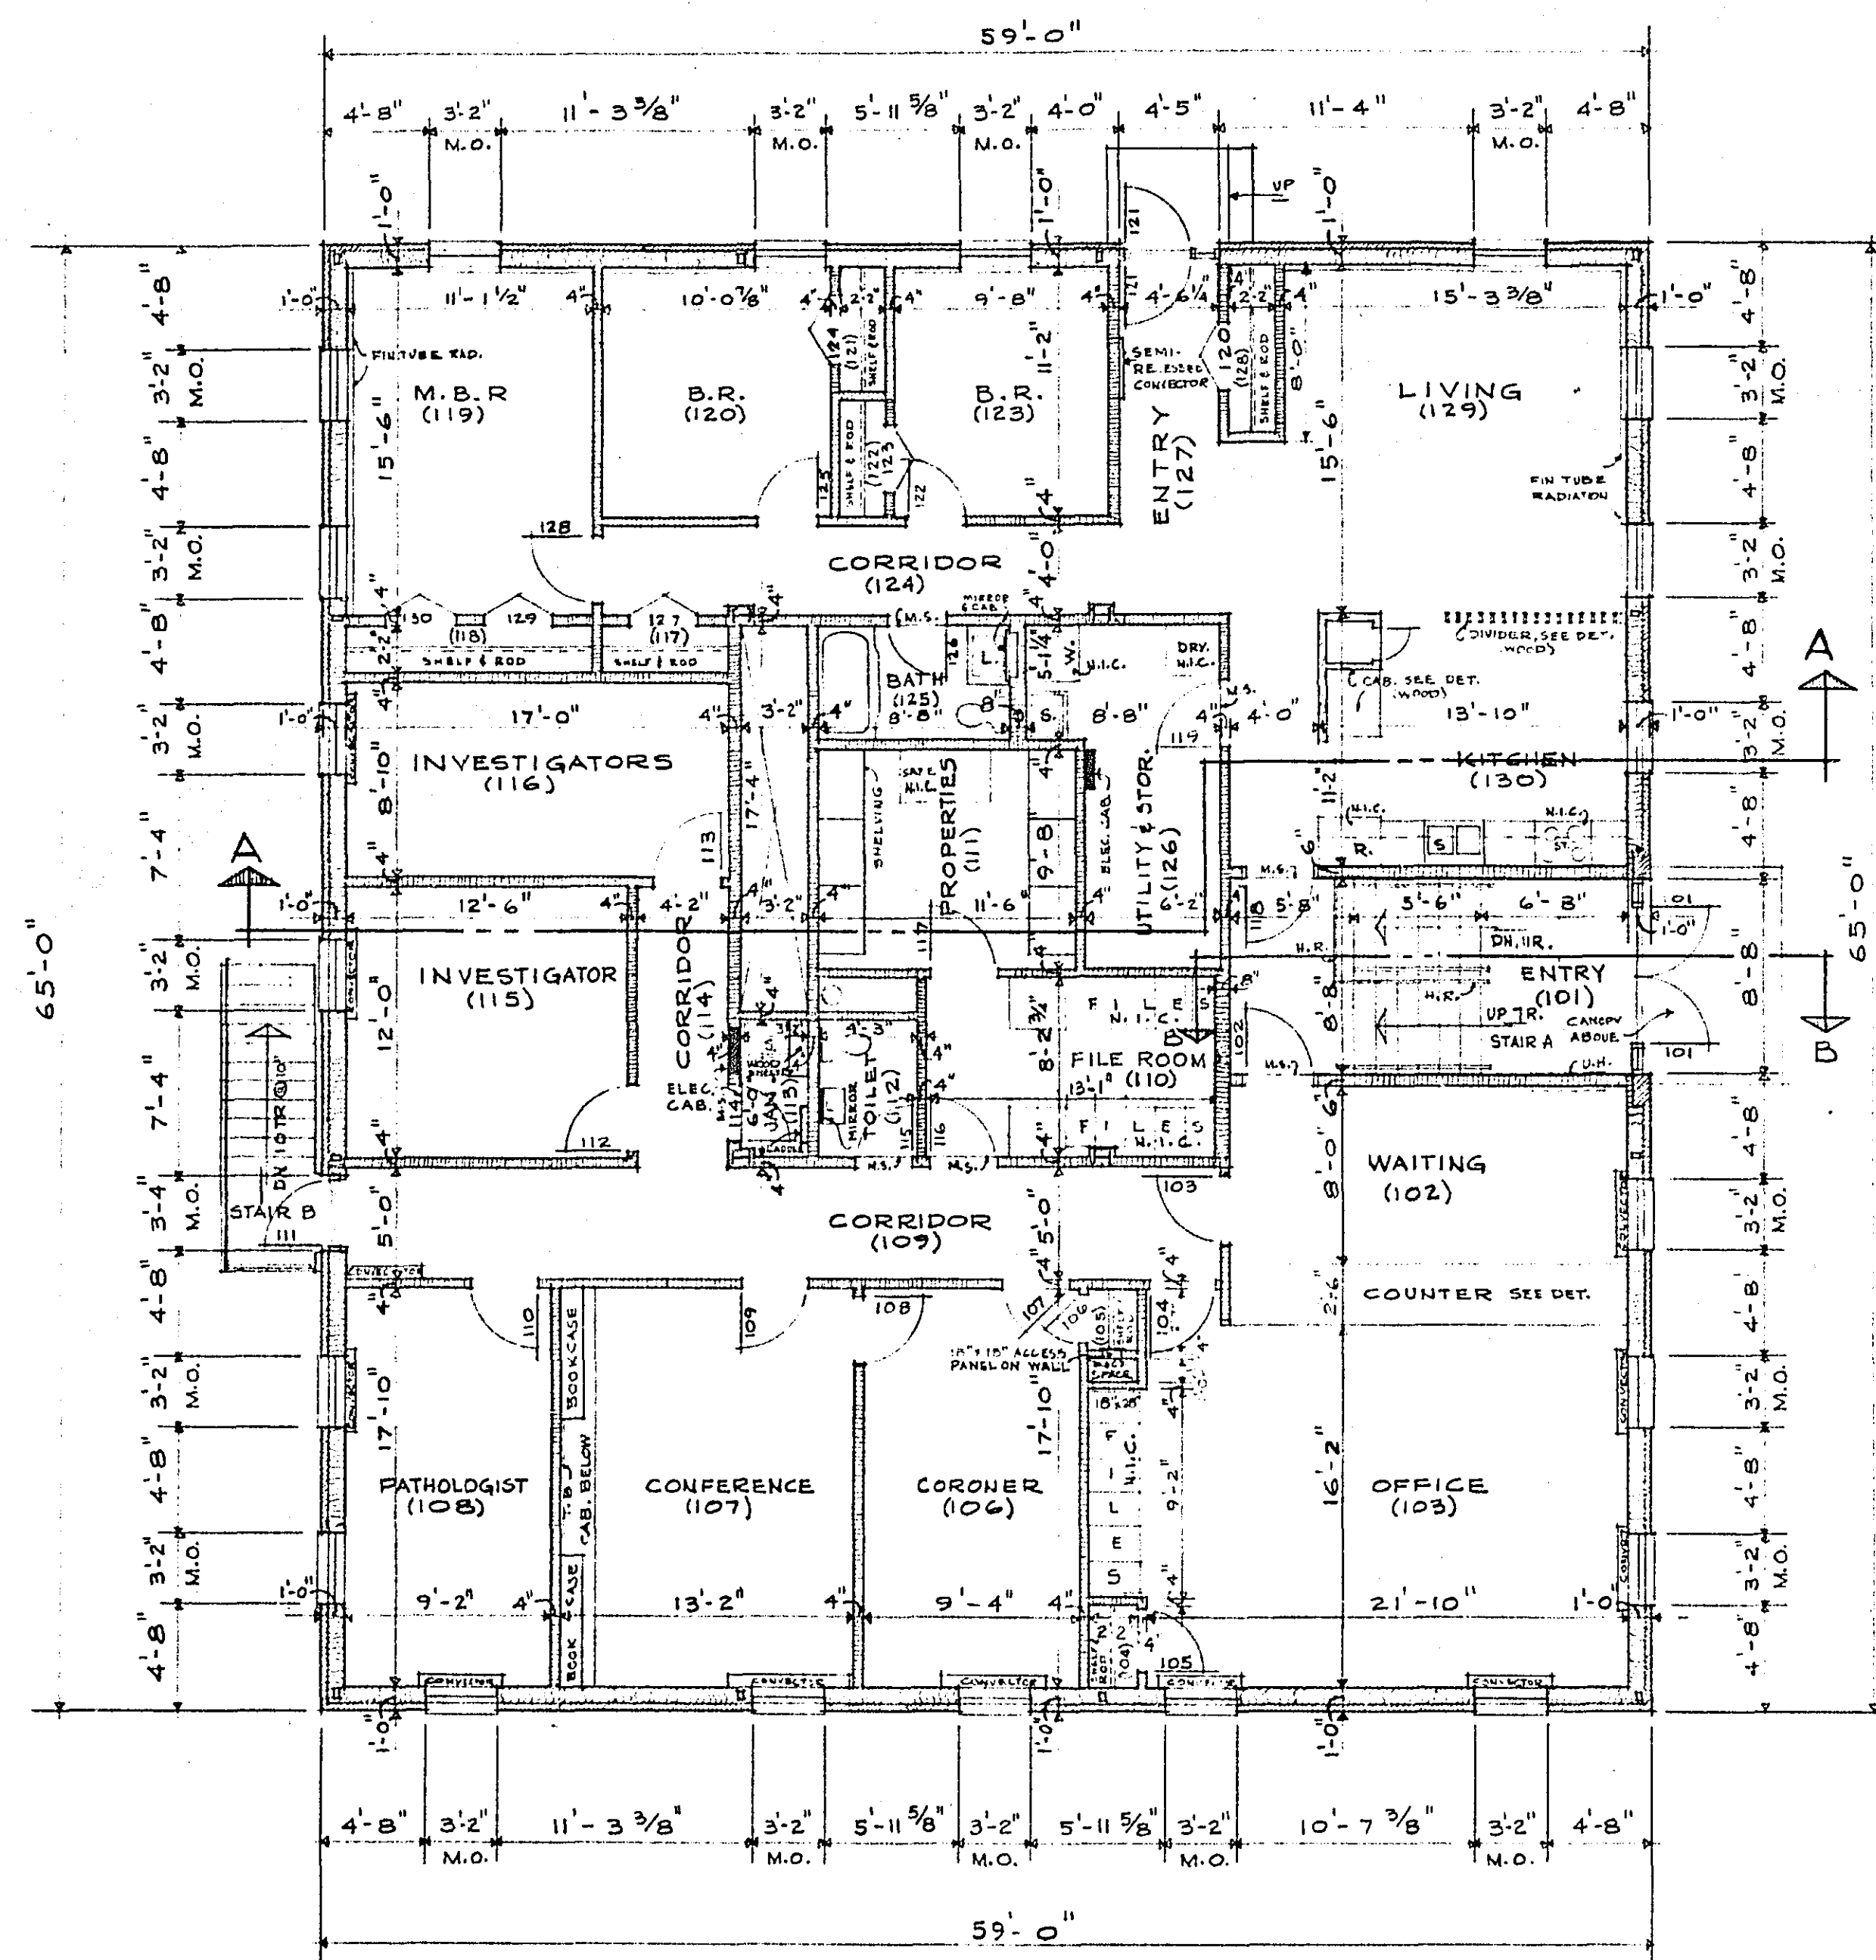

FIRST FLOOR PLAN
SCALE: 1/8" = 1'-0"

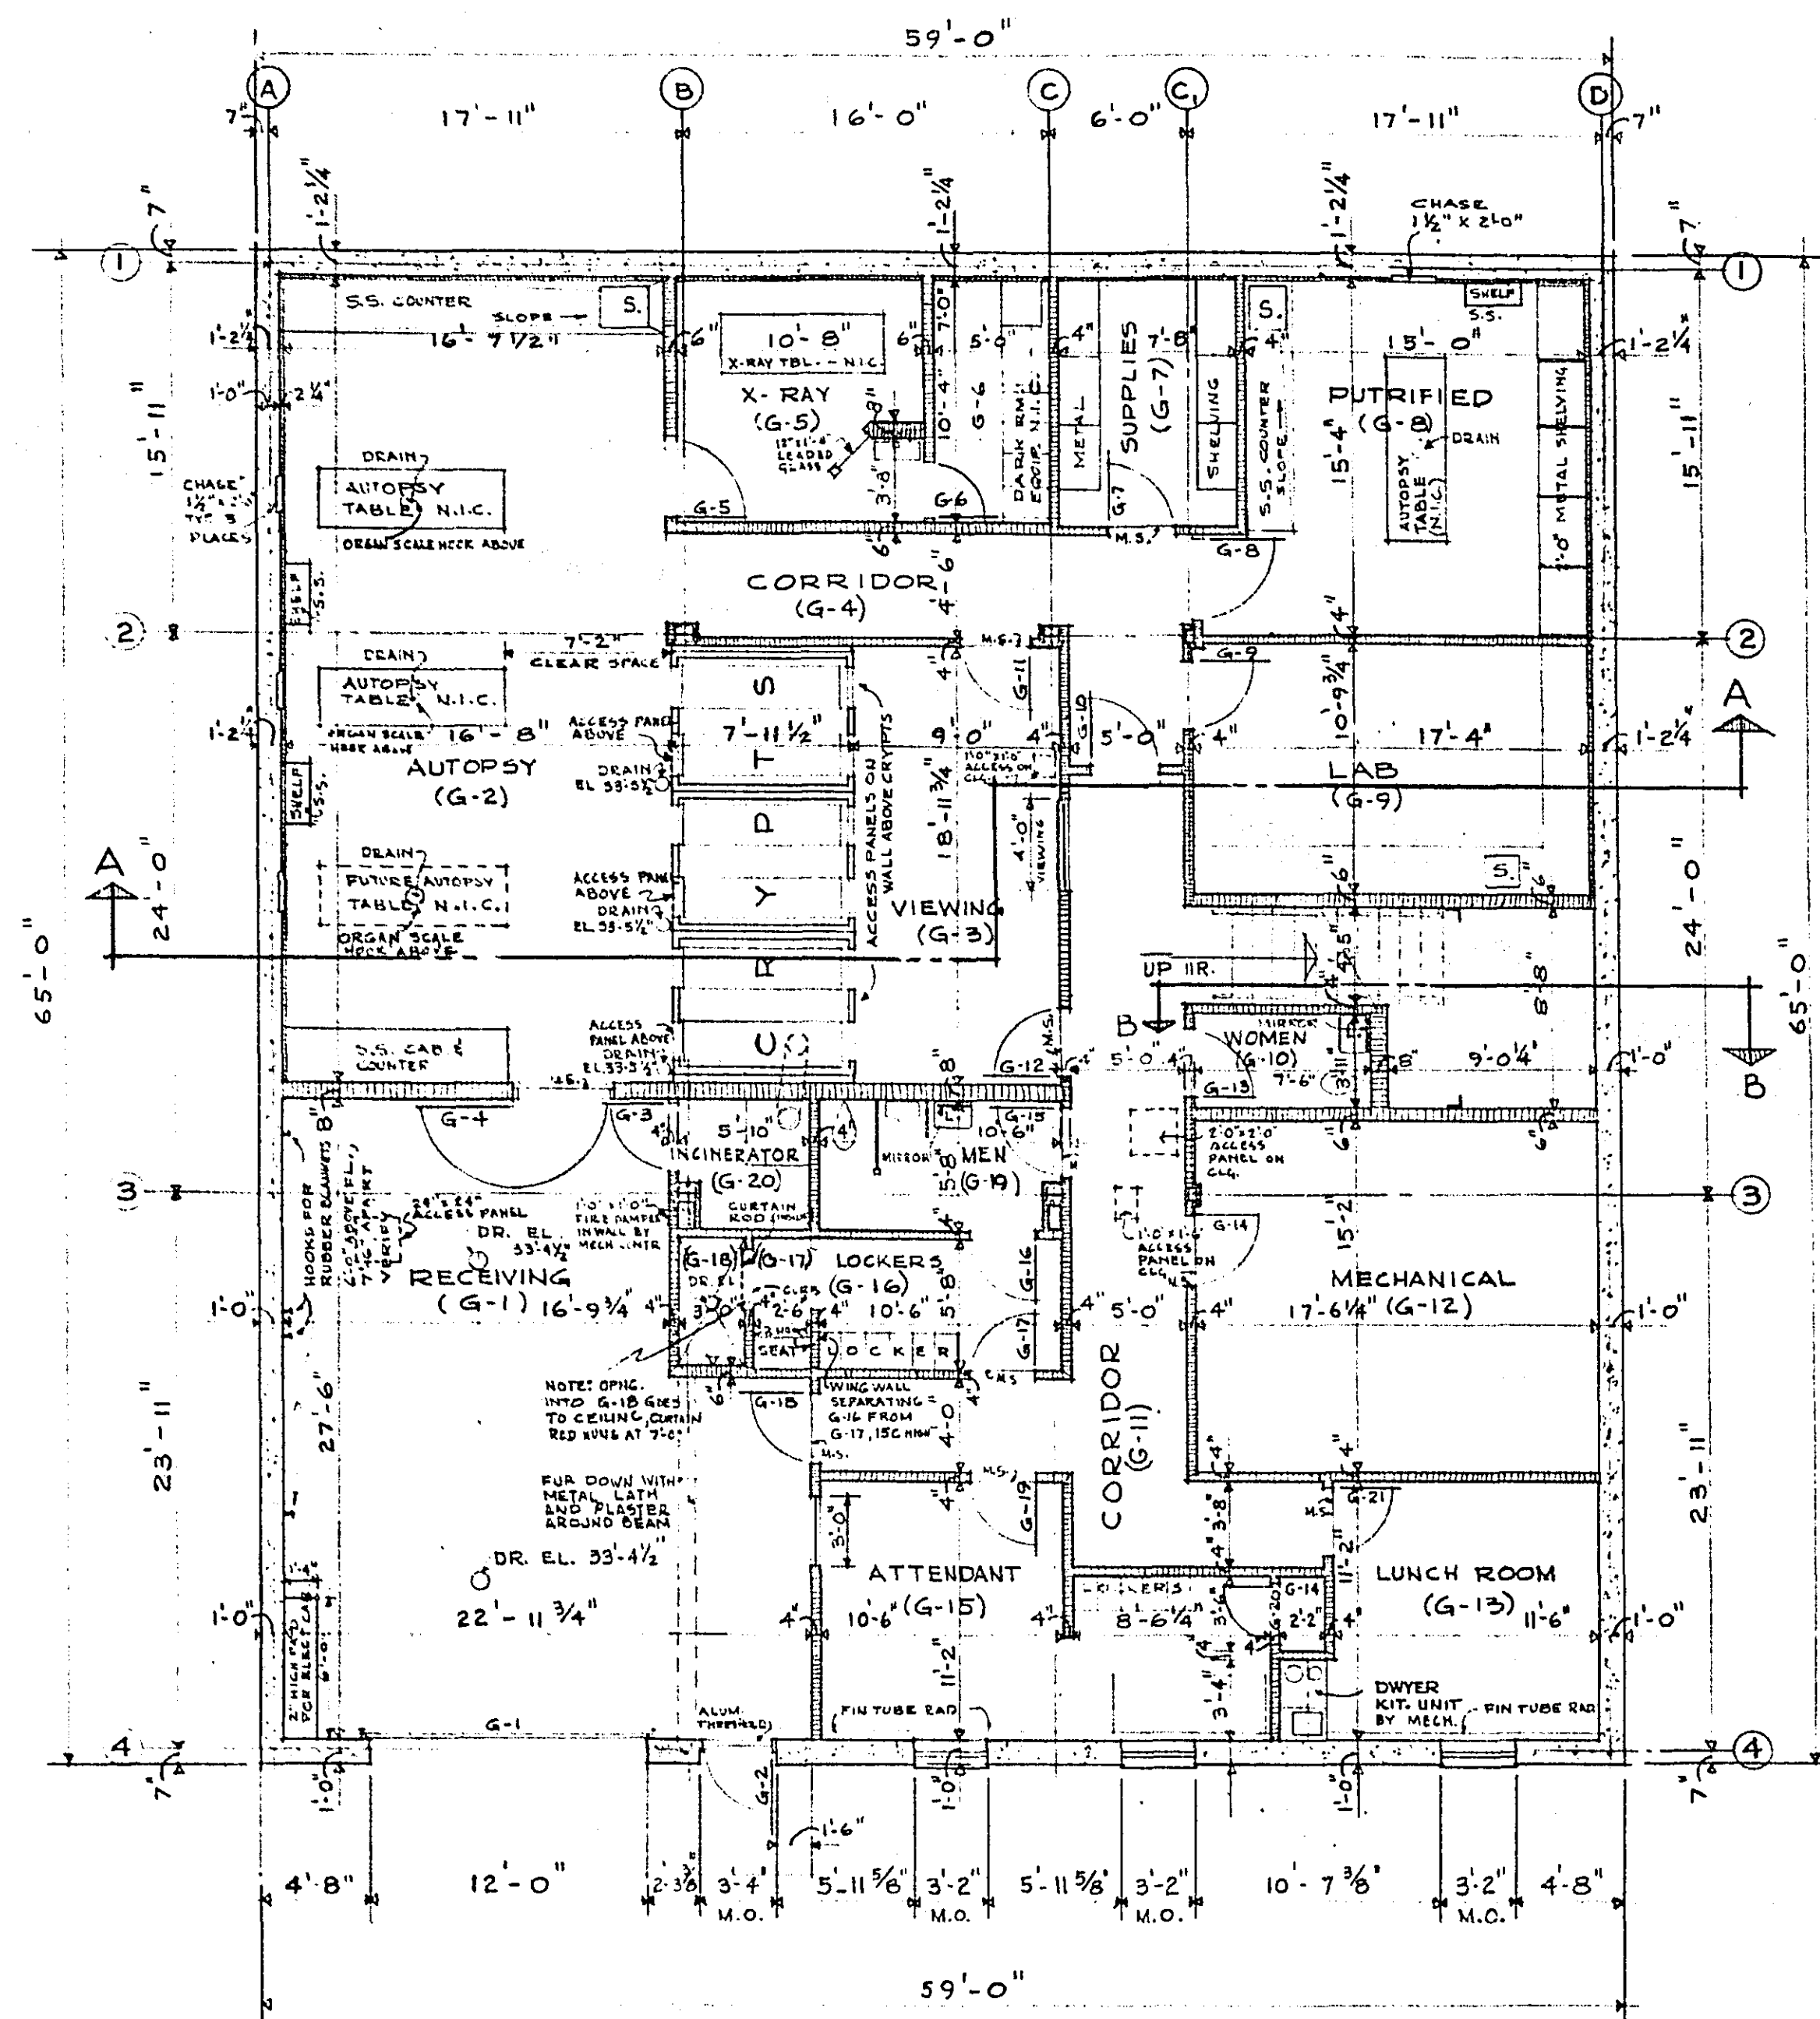

GROUND FLOOR PLAN
SCALE: 1/8" = 1'-0"

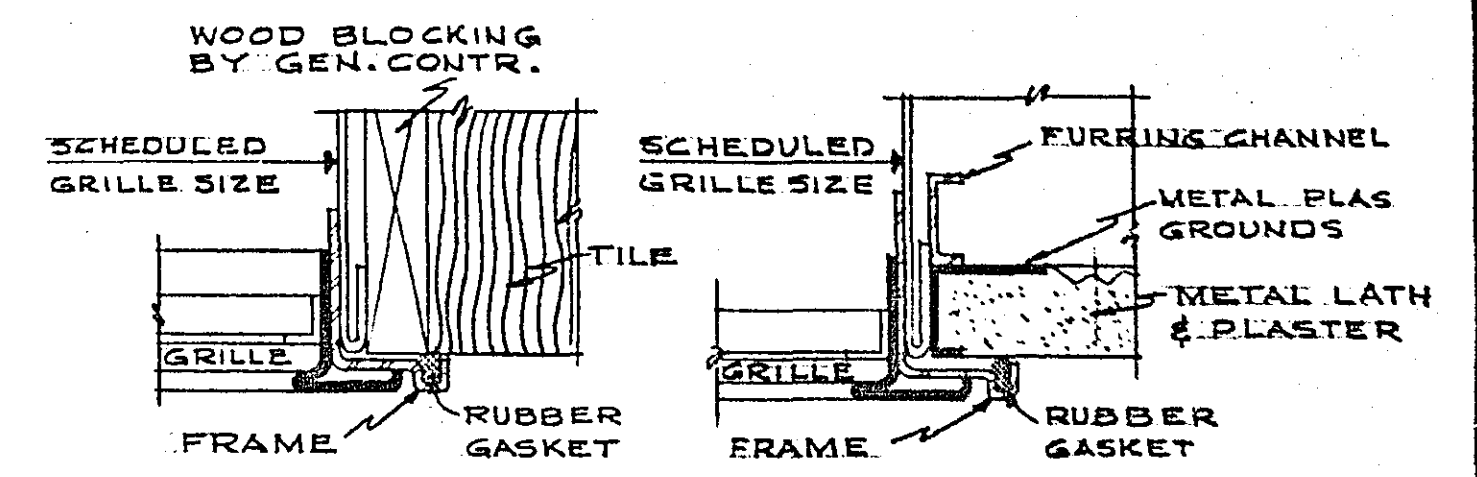

TYPE G-1 (WALL) TYPE G-4 (CEILING)

AIR DIFFUSER PLASTER RINGS FURNISHED BY MECHANICAL CONTRACTOR SET BY GENERAL CONTRACTOR.

TYPE G-6

ROOM	REGISTER	AIR DIFF.	NUMBER	TYPE
	SIZE	NECK DIA.	OF UNITS	
G-1	12" X 12"		1	G-1
G-2	8" X 10"		5	G-4
G-3	8" X 20"		4	G-4
G-4	8" X 12"		1	G-4
G-5	6" X 8"		1	G-4
G-6	6" X 10"		1	G-4
G-7	6" X 8"		1	G-4
G-8	10" X 10"		3	G-4
G-9	8" X 16"		1	G-4
G-10	6" X 6"		1	G-4
G-13	16" X 16"		1	G-4
G-13		10"	1	G-6
G-17	6" X 8"		1	G-4
G-19	6" X 8"		1	G-4
G-20	12" X 12"		1	G-1
102		10"	3	G-6
106		10"	1	G-6
107		10"	1	G-6
108		8"	2	G-6
109	24" X 48"		2	G-4
110		6"	1	G-6
111	8" X 10"		1	G-4
112	6" X 6"		1	G-4
113	6" X 6"		1	G-4
115		8"	1	G-6
116		8"	1	G-6
125	4" X 10"		1	G-4
126	8" X 10"		1	G-4

NOTE: ALL GRILLES IN PANELS ABOVE DOORS ARE CALLED OUT IN DOOR SCHEDULE REMARKS

NO.	NAME	TYPE	JAMB	THRES.	ELEV.	REMARKS
101	RECEIVING	DOOR	SEE SHT. 10	SEE SHT. 10	SEE SHT. 10	GRILLE ABOVE DOOR
102	WAITING	DOOR	SEE SHT. 10	SEE SHT. 10	SEE SHT. 10	GRILLE ABOVE DOOR
103	OFFICE	DOOR	SEE SHT. 10	SEE SHT. 10	SEE SHT. 10	GRILLE ABOVE DOOR
104	CONFERENCE	DOOR	SEE SHT. 10	SEE SHT. 10	SEE SHT. 10	GRILLE ABOVE DOOR
105	PATHOLOGIST	DOOR	SEE SHT. 10	SEE SHT. 10	SEE SHT. 10	GRILLE ABOVE DOOR
106	CORRIDOR	DOOR	SEE SHT. 10	SEE SHT. 10	SEE SHT. 10	GRILLE ABOVE DOOR
107	LAB	DOOR	SEE SHT. 10	SEE SHT. 10	SEE SHT. 10	GRILLE ABOVE DOOR
108	MECHANICAL	DOOR	SEE SHT. 10	SEE SHT. 10	SEE SHT. 10	GRILLE ABOVE DOOR
109	LUNCH ROOM	DOOR	SEE SHT. 10	SEE SHT. 10	SEE SHT. 10	GRILLE ABOVE DOOR
110	VIEWING	DOOR	SEE SHT. 10	SEE SHT. 10	SEE SHT. 10	GRILLE ABOVE DOOR
111	LAB	DOOR	SEE SHT. 10	SEE SHT. 10	SEE SHT. 10	GRILLE ABOVE DOOR
112	LAB	DOOR	SEE SHT. 10	SEE SHT. 10	SEE SHT. 10	GRILLE ABOVE DOOR
113	LAB	DOOR	SEE SHT. 10	SEE SHT. 10	SEE SHT. 10	GRILLE ABOVE DOOR
114	LAB	DOOR	SEE SHT. 10	SEE SHT. 10	SEE SHT. 10	GRILLE ABOVE DOOR
115	LAB	DOOR	SEE SHT. 10	SEE SHT. 10	SEE SHT. 10	GRILLE ABOVE DOOR
116	LAB	DOOR	SEE SHT. 10	SEE SHT. 10	SEE SHT. 10	GRILLE ABOVE DOOR
117	LAB	DOOR	SEE SHT. 10	SEE SHT. 10	SEE SHT. 10	GRILLE ABOVE DOOR
118	LAB	DOOR	SEE SHT. 10	SEE SHT. 10	SEE SHT. 10	GRILLE ABOVE DOOR
119	LAB	DOOR	SEE SHT. 10	SEE SHT. 10	SEE SHT. 10	GRILLE ABOVE DOOR
120	LAB	DOOR	SEE SHT. 10	SEE SHT. 10	SEE SHT. 10	GRILLE ABOVE DOOR
121	LAB	DOOR	SEE SHT. 10	SEE SHT. 10	SEE SHT. 10	GRILLE ABOVE DOOR
122	LAB	DOOR	SEE SHT. 10	SEE SHT. 10	SEE SHT. 10	GRILLE ABOVE DOOR
123	LAB	DOOR	SEE SHT. 10	SEE SHT. 10	SEE SHT. 10	GRILLE ABOVE DOOR
124	LAB	DOOR	SEE SHT. 10	SEE SHT. 10	SEE SHT. 10	GRILLE ABOVE DOOR
125	LAB	DOOR	SEE SHT. 10	SEE SHT. 10	SEE SHT. 10	GRILLE ABOVE DOOR
126	LAB	DOOR	SEE SHT. 10	SEE SHT. 10	SEE SHT. 10	GRILLE ABOVE DOOR
127	LAB	DOOR	SEE SHT. 10	SEE SHT. 10	SEE SHT. 10	GRILLE ABOVE DOOR
128	LAB	DOOR	SEE SHT. 10	SEE SHT. 10	SEE SHT. 10	GRILLE ABOVE DOOR
129	LAB	DOOR	SEE SHT. 10	SEE SHT. 10	SEE SHT. 10	GRILLE ABOVE DOOR
130	LAB	DOOR	SEE SHT. 10	SEE SHT. 10	SEE SHT. 10	GRILLE ABOVE DOOR

GENERAL NOTES

- VERIFY LOCATION OF ALL ACCESS PANELS WITH MECHANICAL CONTRACTOR.
- OMIT RUBBER BASE ON ALL WALLS WITH FIN TUBE RADIATION IN ROOMS 119, 120, 123, 129 AND 130. PLASTER IS COVERED BY RADIATION COVER.
- FILL VOIDS IN TILE WITH CONCRETE IN PARTITIONS ENCLOSING THE X-RAY ROOM AND THE SCREEN IN THE X-RAY ROOM.

FLOOR PLANS

RAMSEY COUNTY CORONERS OFFICE

ST. PAUL, MINNESOTA

TOLTZ, KING, DUVALL, ANDERSON AND ASSOCIATES, INC.

ENGINEERS AND ARCHITECTS

ST. PAUL, MINNESOTA

Microfilmed
RAMSEY CO. ENGR.





DESIGNED: R.L.L.
DRAWN: R.L.L.
CHECKED: R.L.L.

I hereby certify that this plan was prepared by me or under my direct supervision and that I am a duly Registered ARCHITECT under the laws of the State of Minnesota.

Sealed A. Anderson

Date: OCTOBER 7, 1963 Reg. No. 685

COM. 4603
DRG. A-2

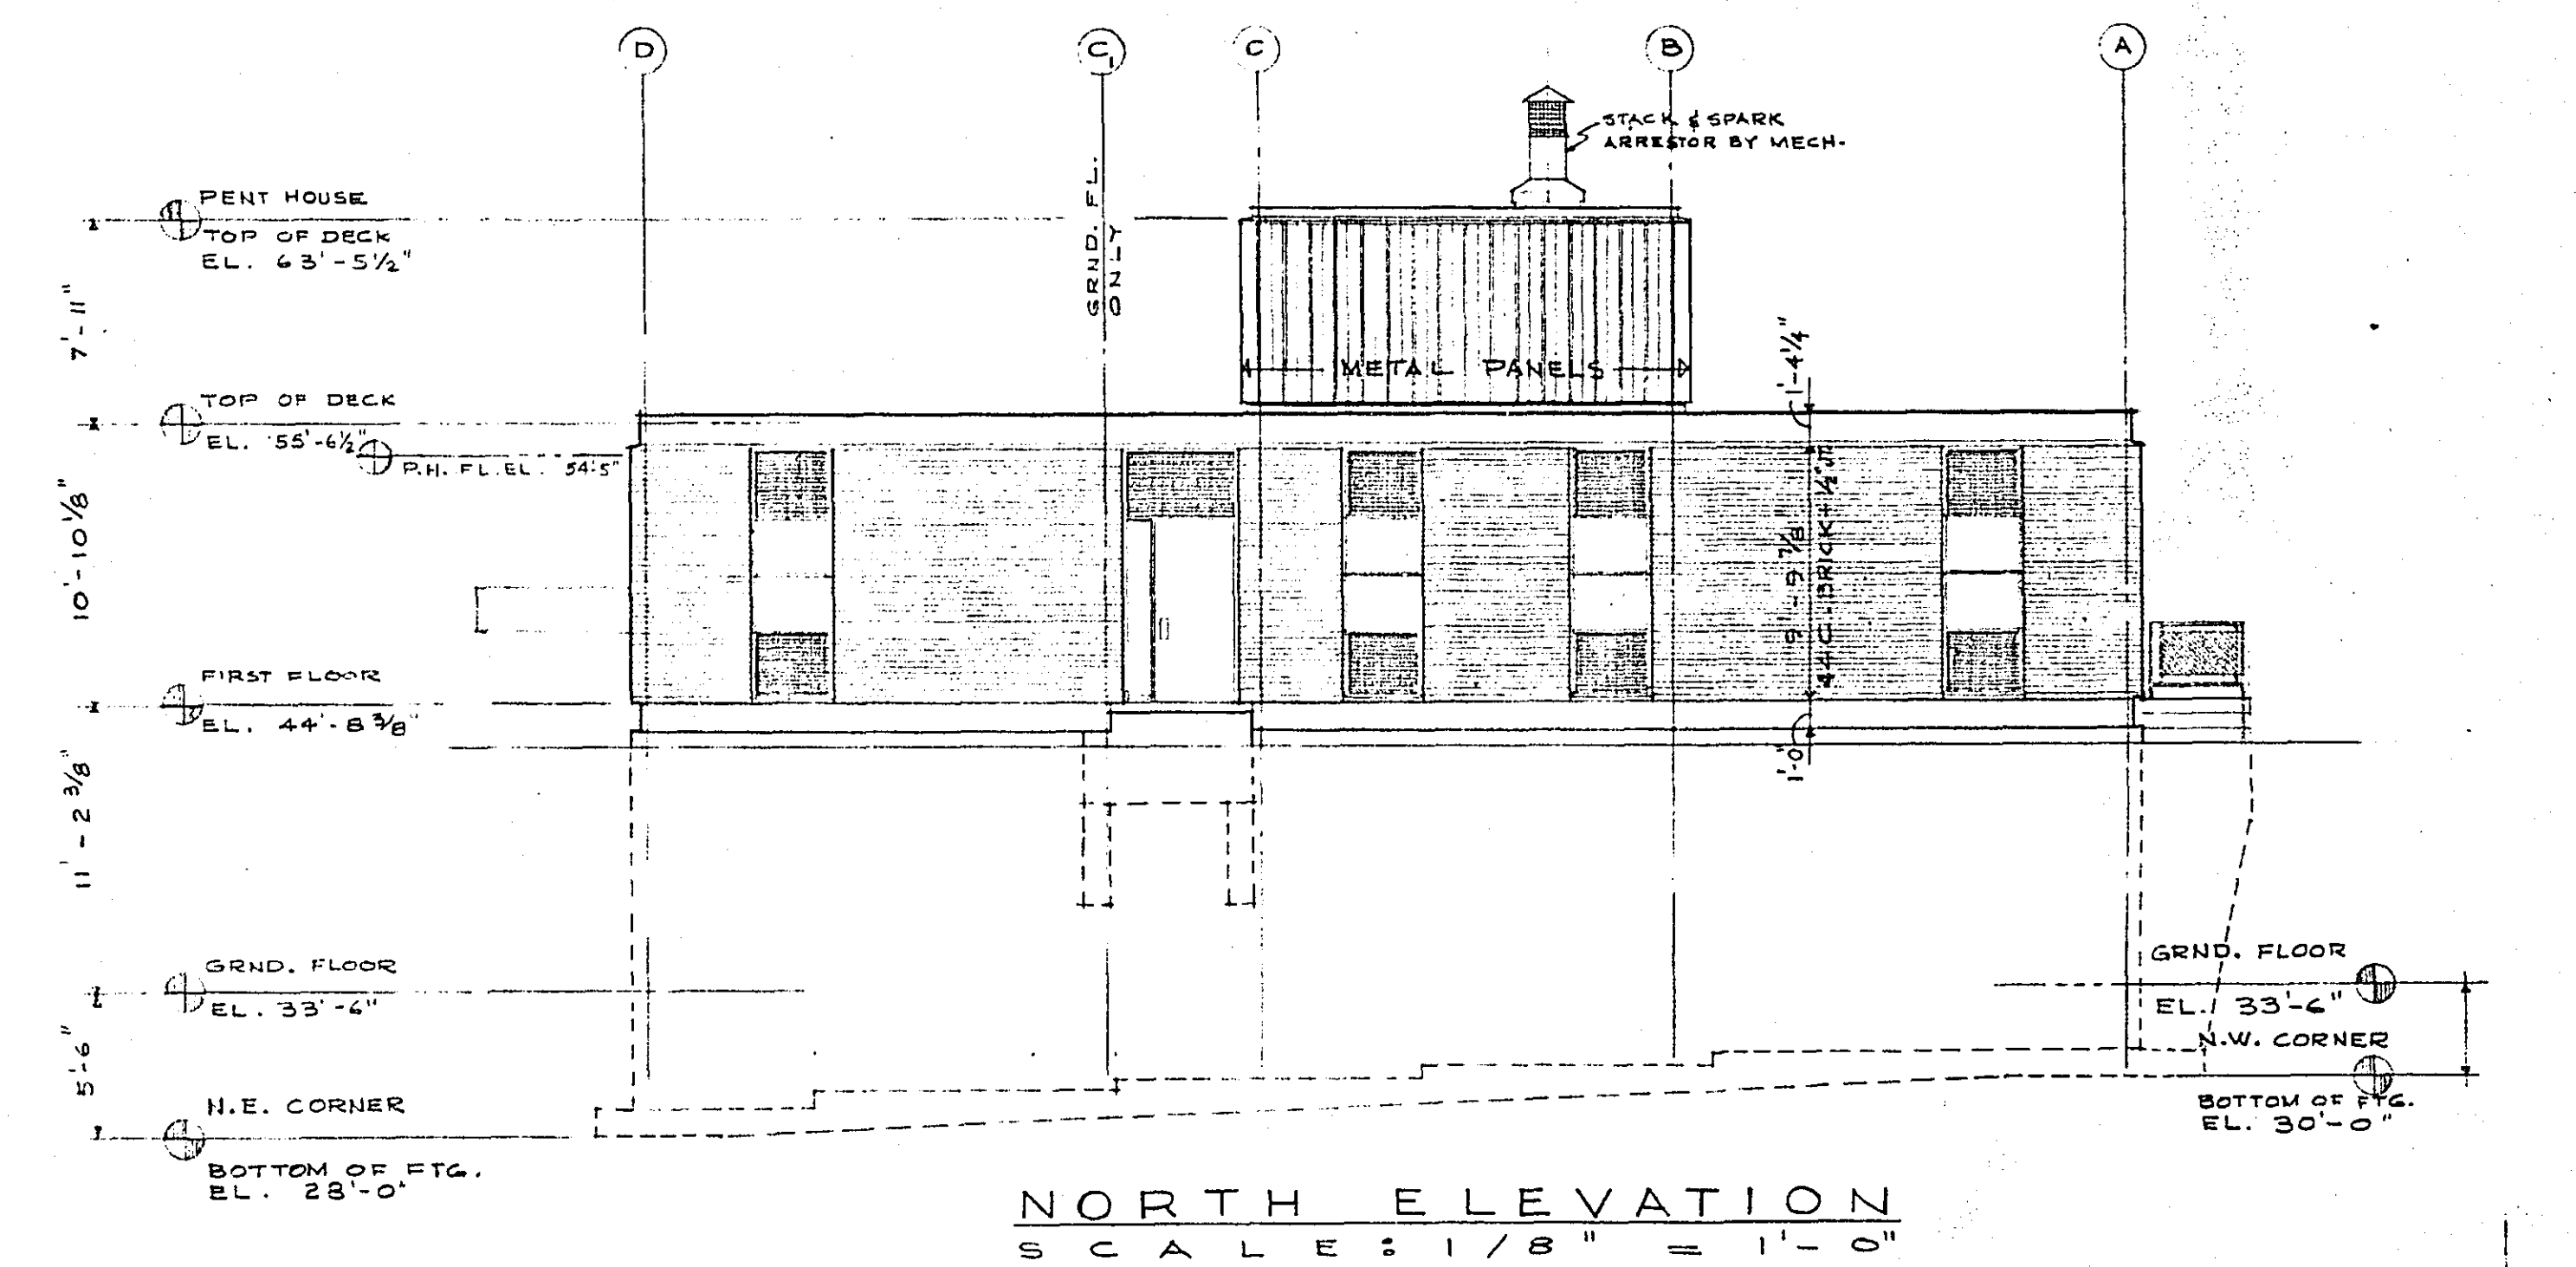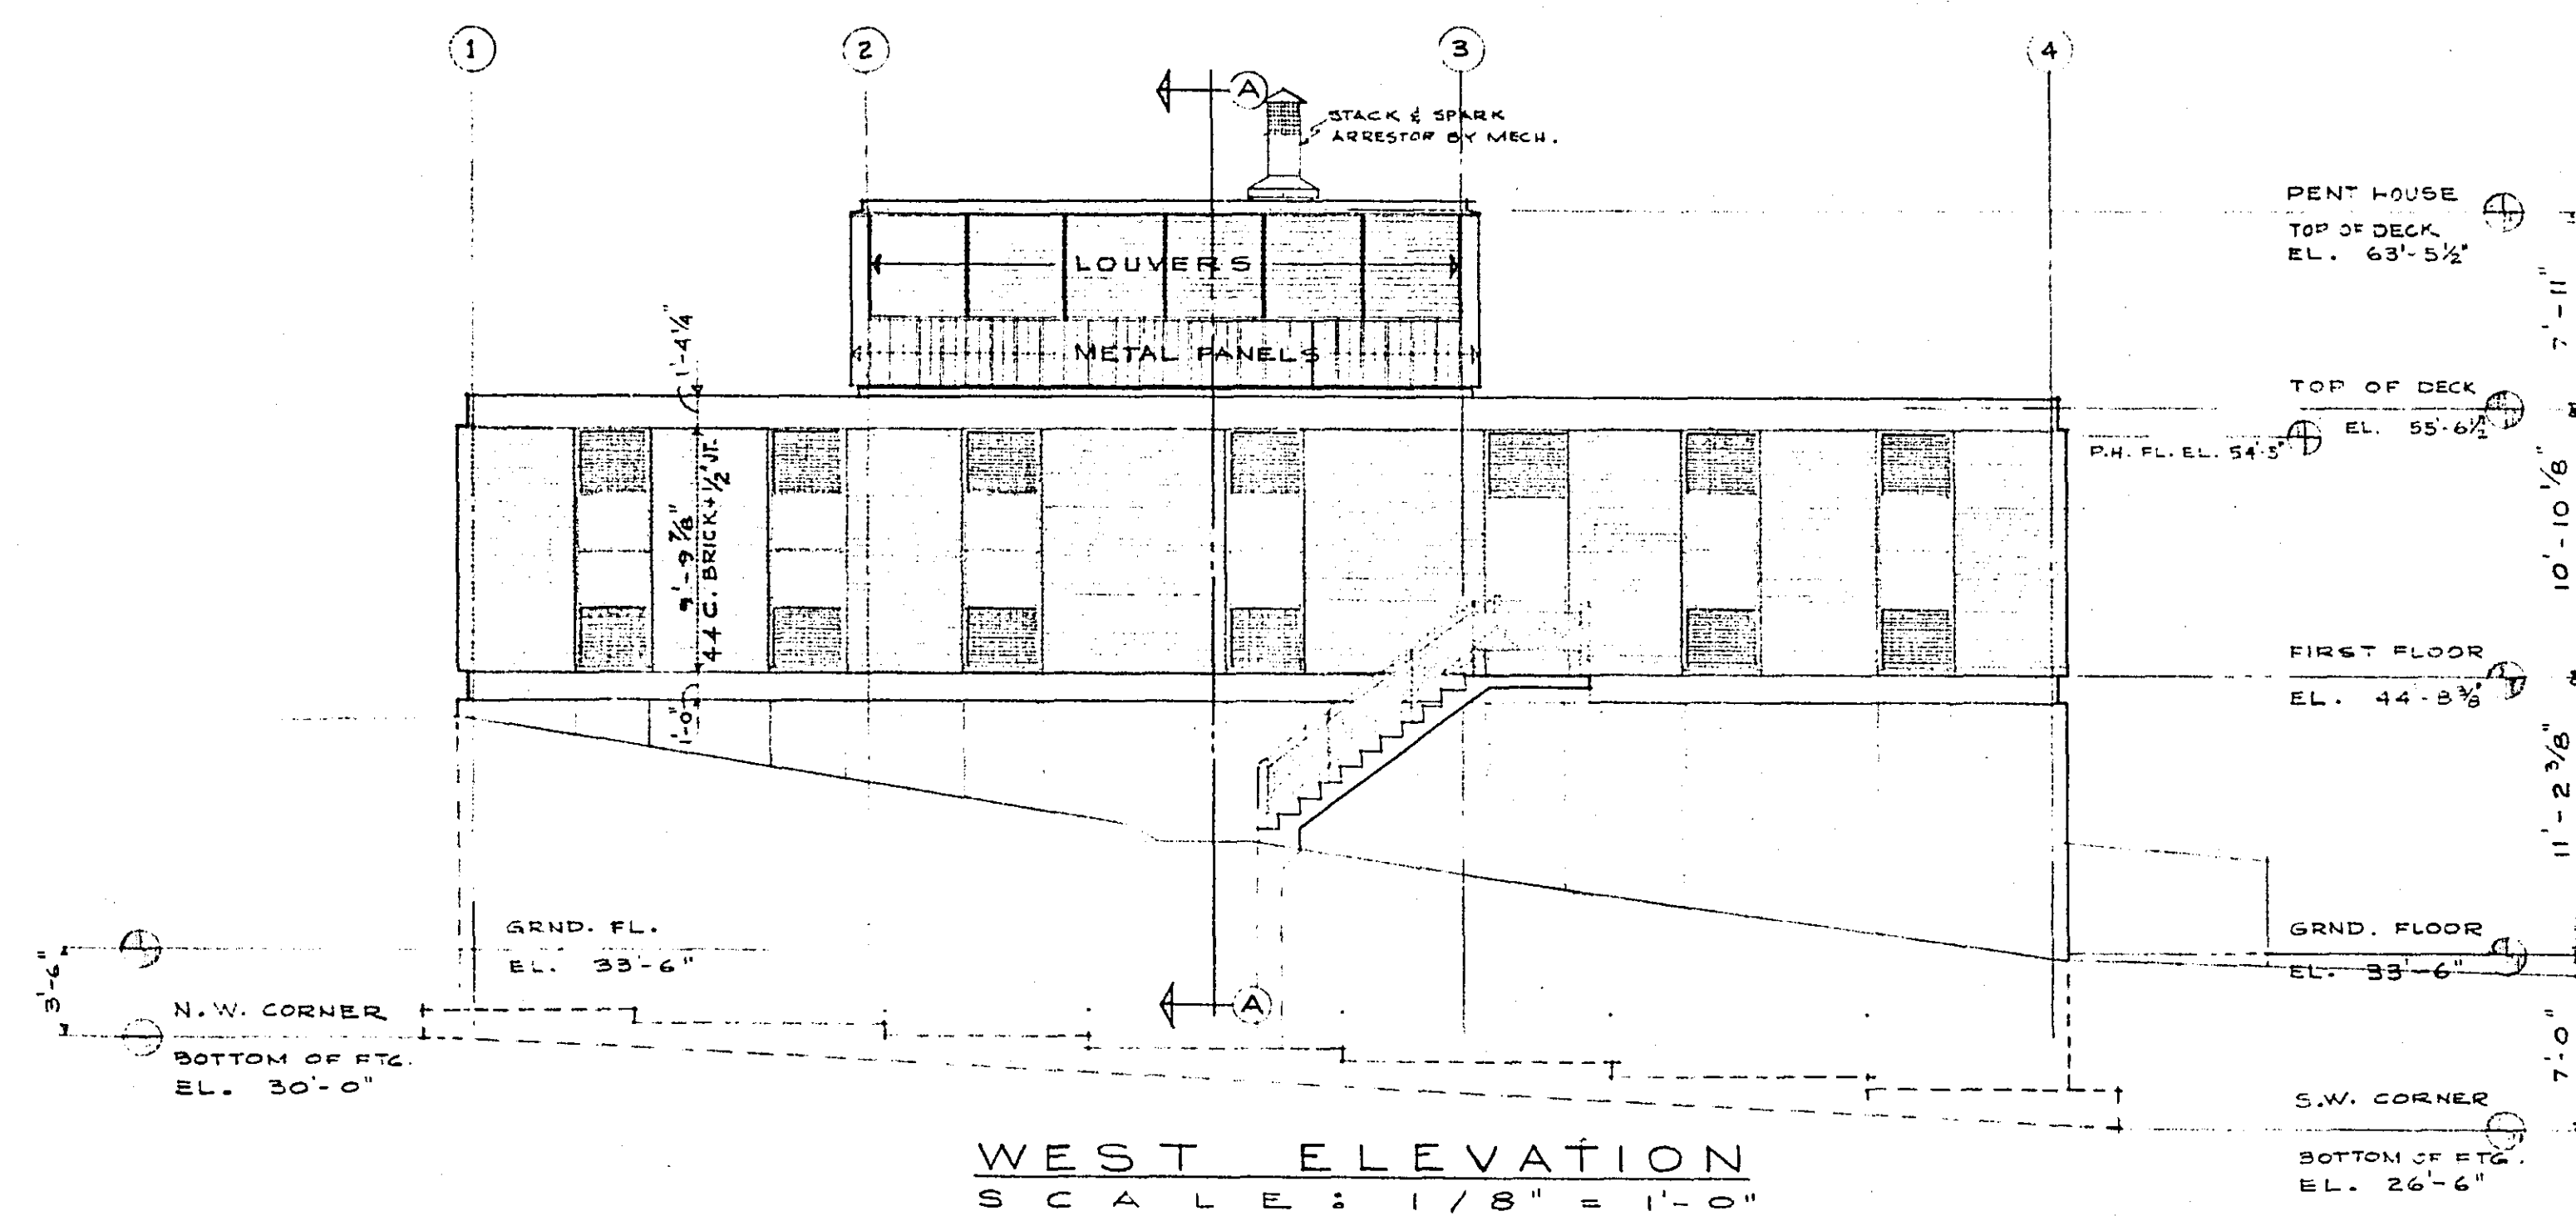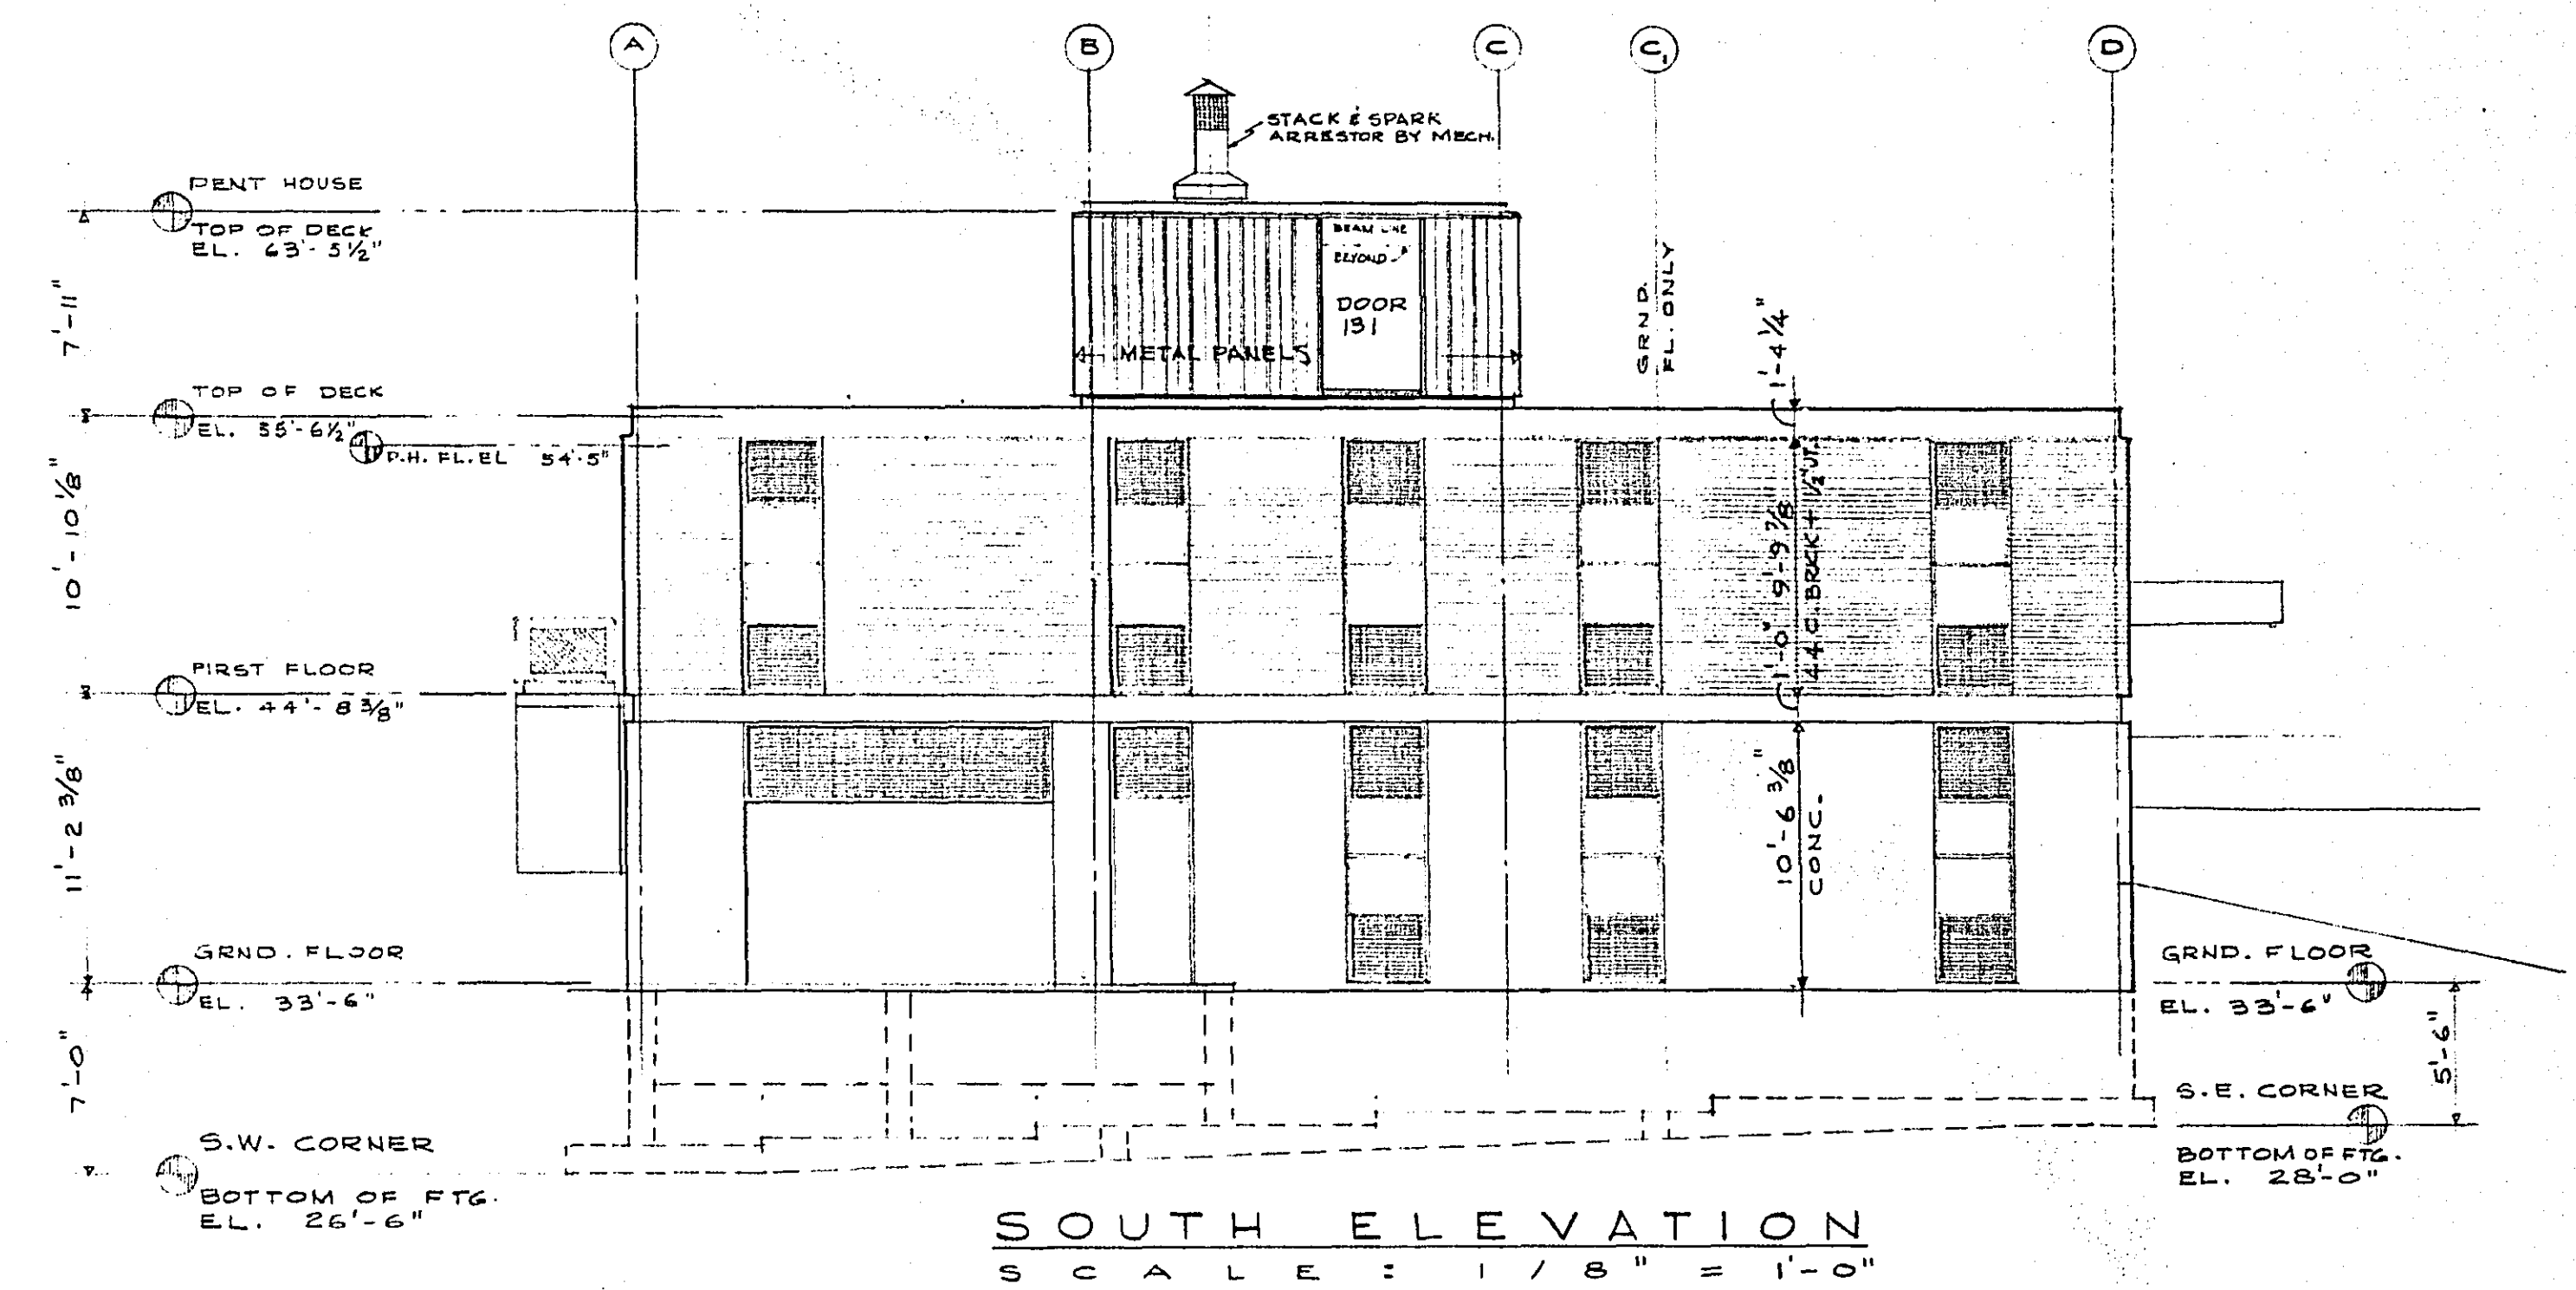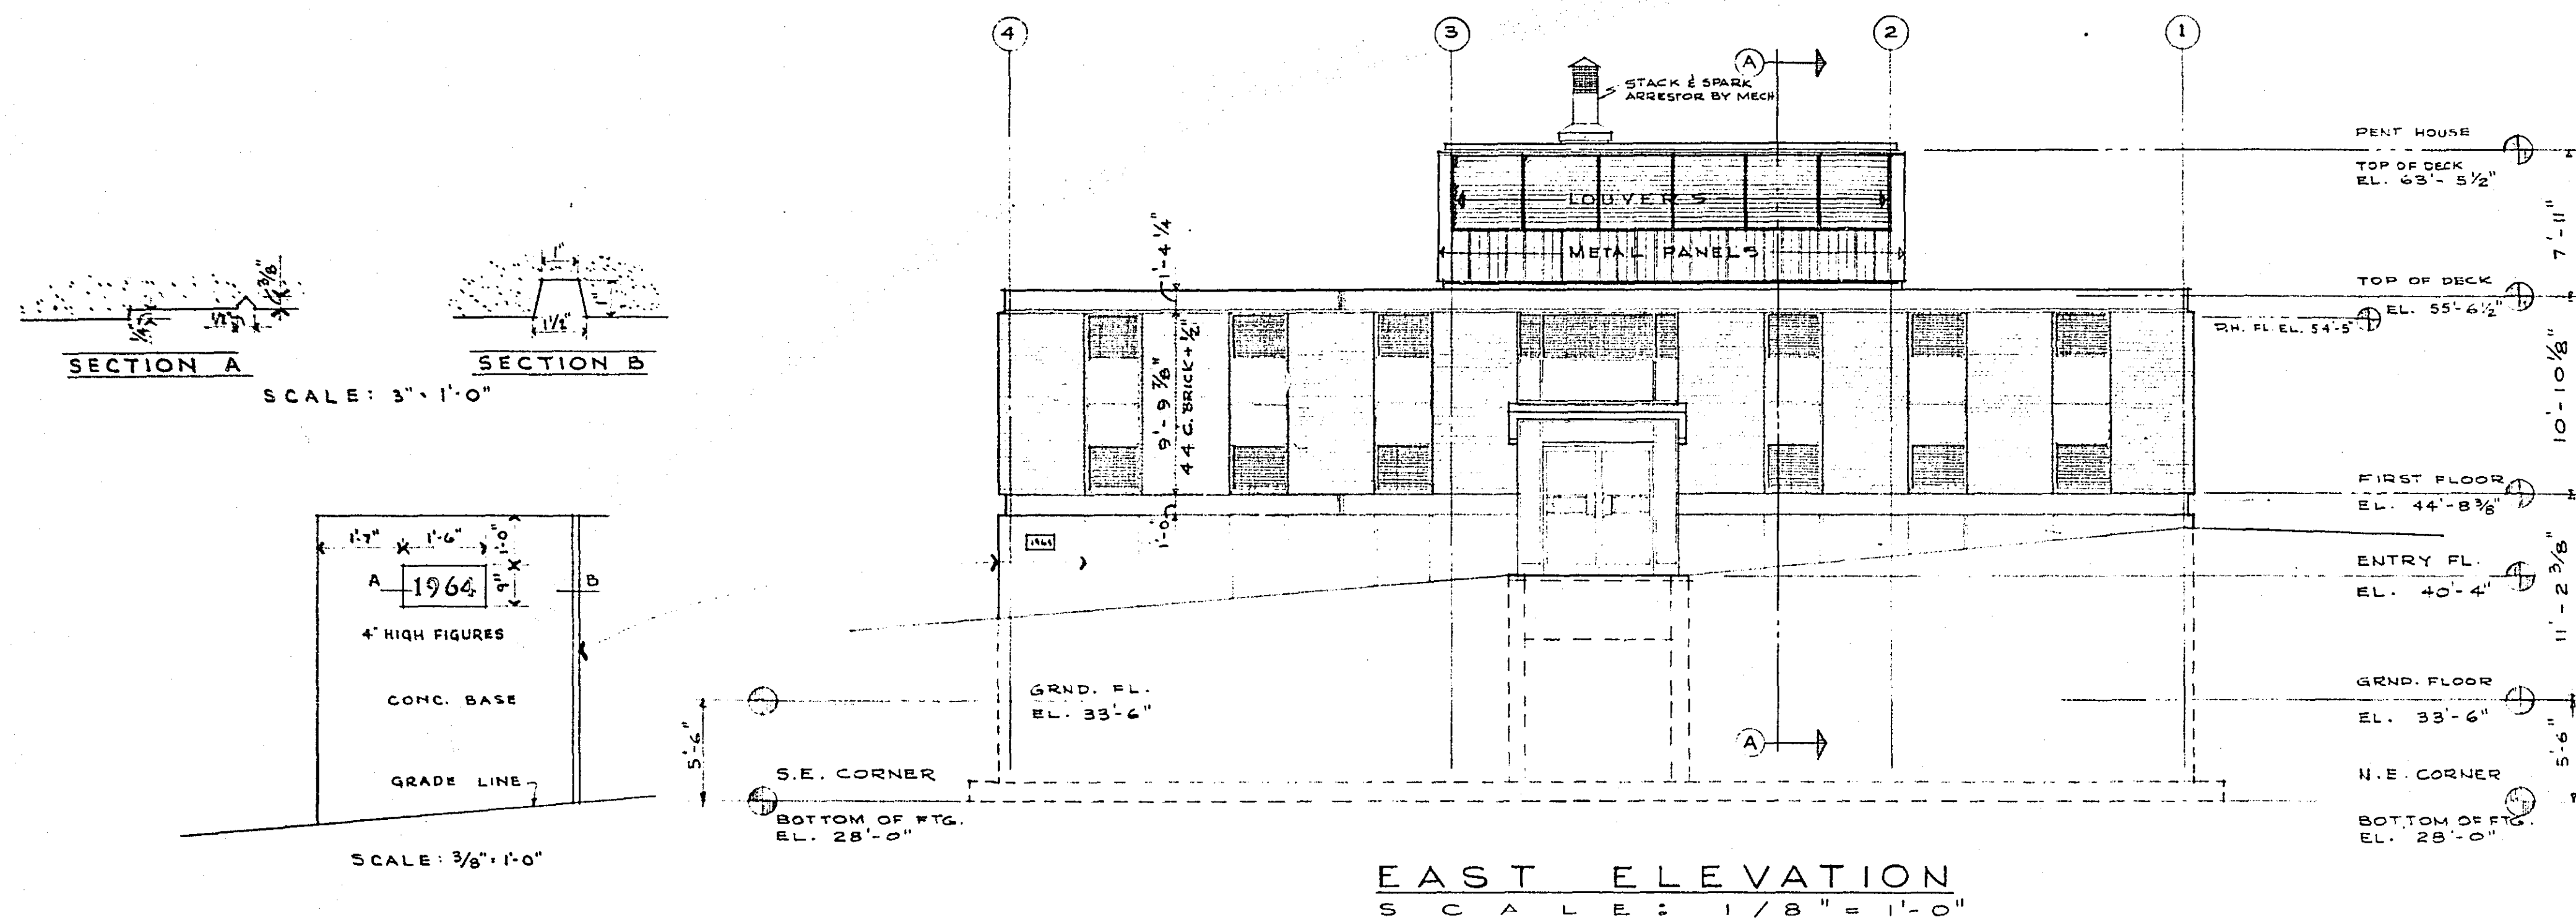

ELEVATIONS


RAMSEY COUNTY CORONERS OFFICE












ST. PAUL, MINNESOTA

**TOLTZ, KING, DUVALL, ANDERSON
AND ASSOCIATES, INC.**
ST. PAUL, MINNESOTA
ENGINEERS AND ARCHITECTS


MICROFILMED
RAMSEY CO. ENGR.

DESIGNED R.L.L.	I hereby certify that this plan was prepared by me or under my direct supervision and that I am a duly Registered ARCHITECT under the laws of the State of Minnesota. <i>Sherald A. Anderson</i> Date OCTOBER 7, 1963 Reg. No. 685	COM. 4603 DRG. A-3
DRAWN R.L.L.		
CHECKED		

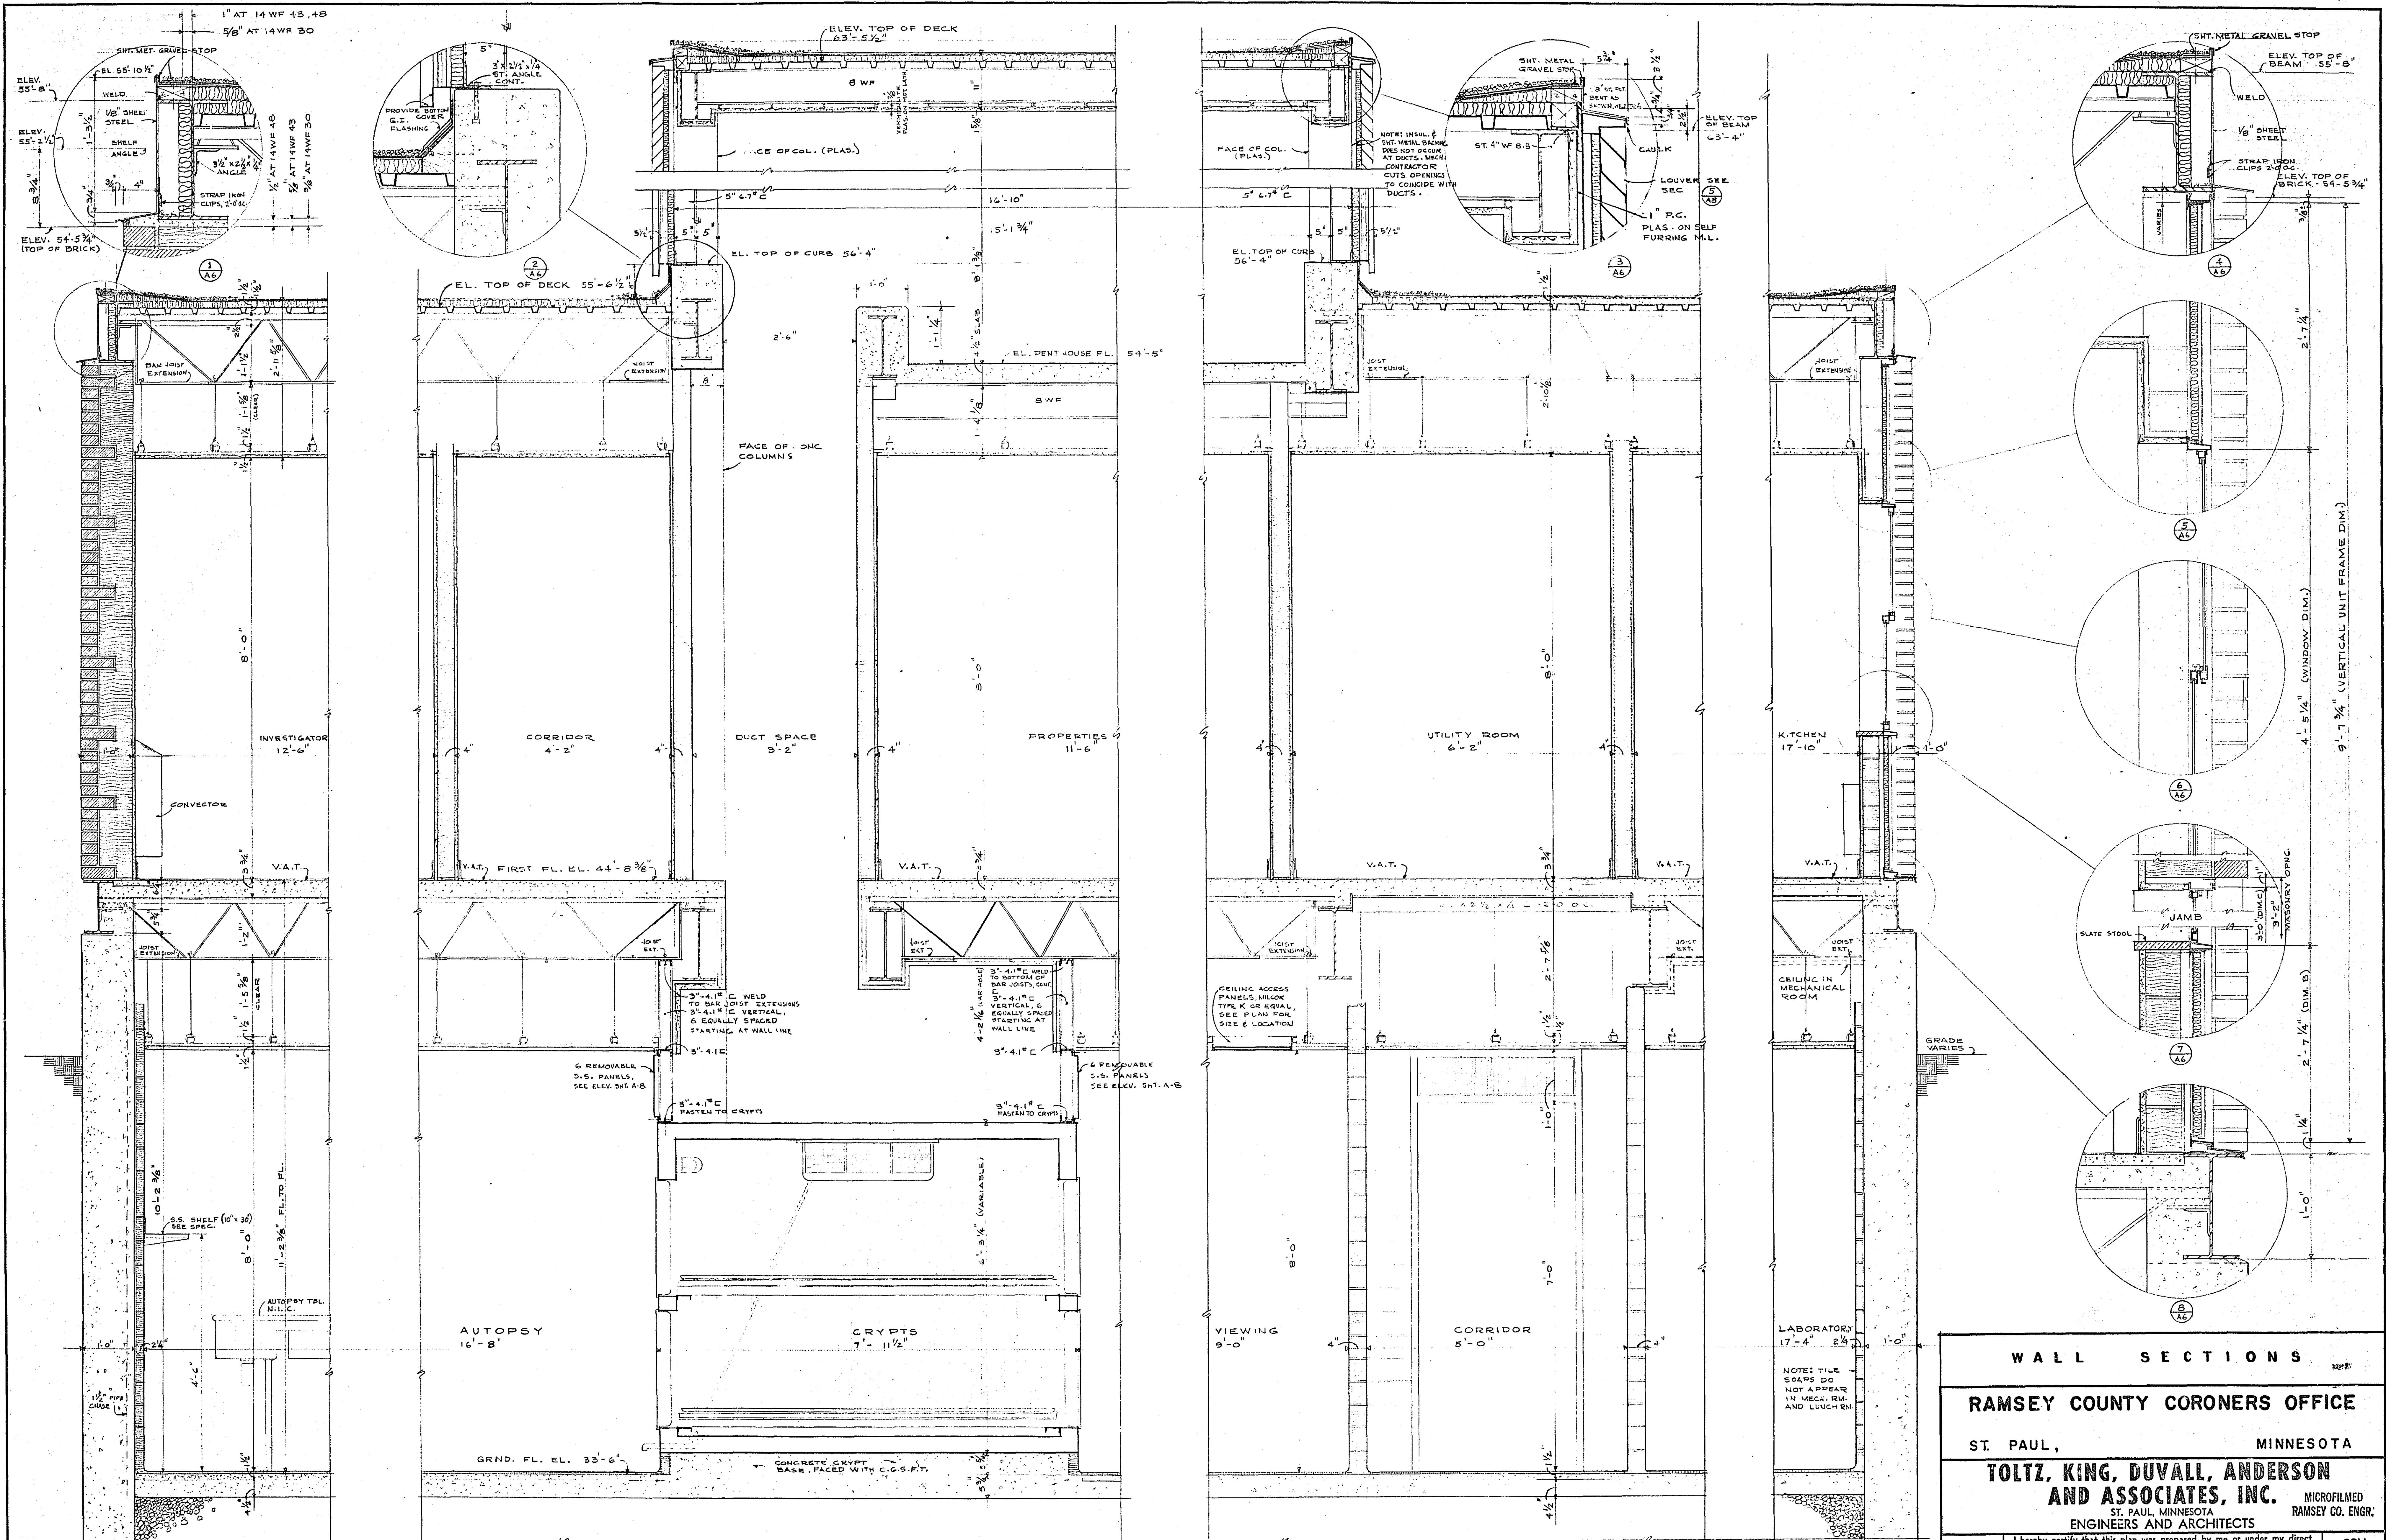


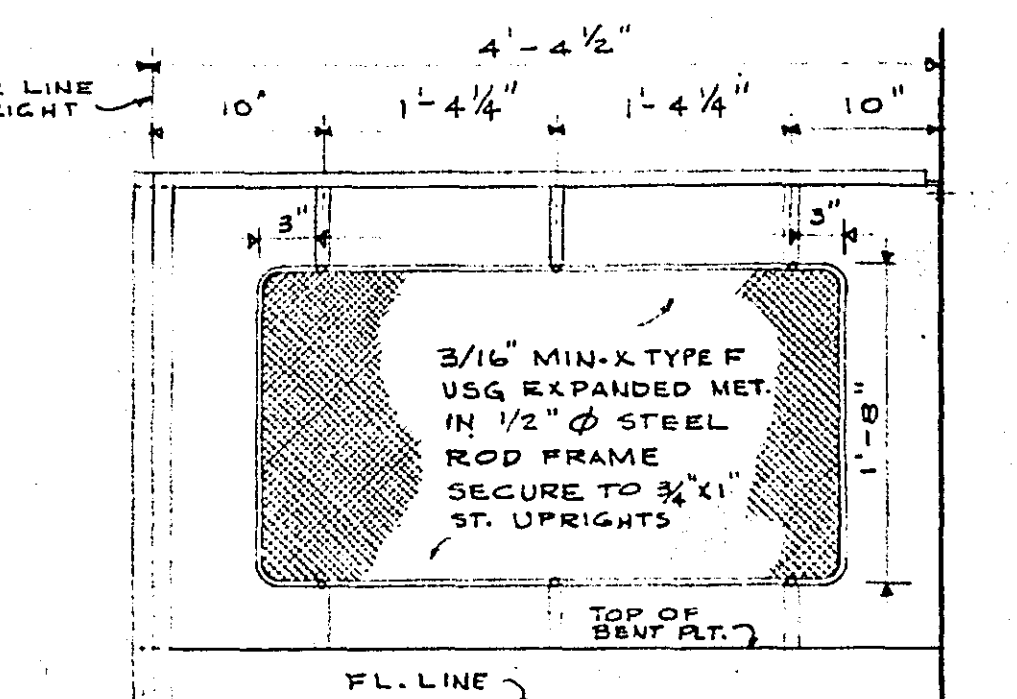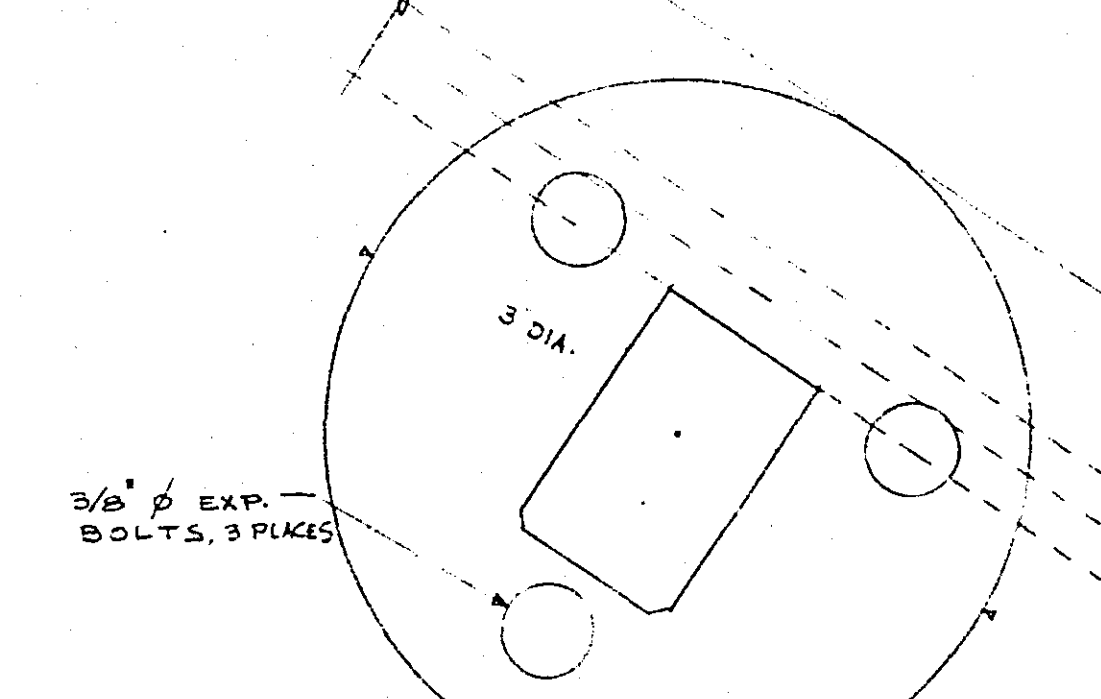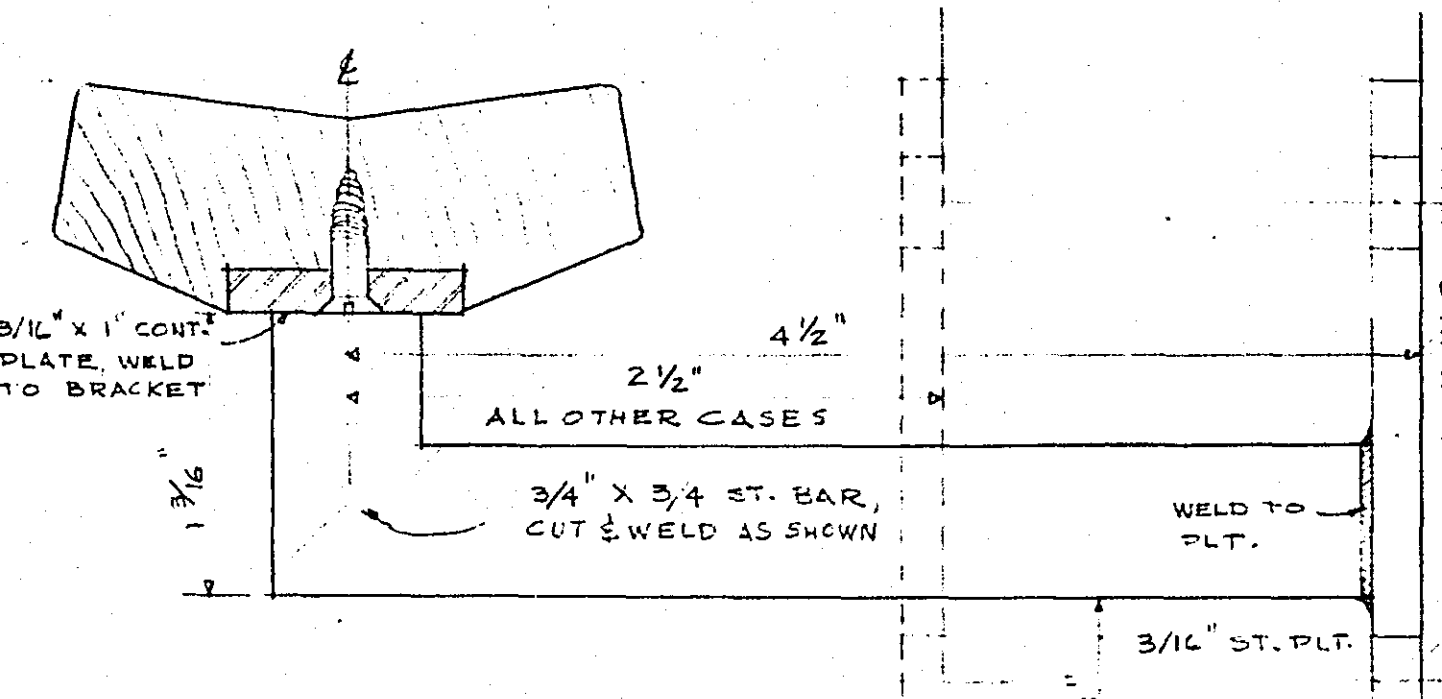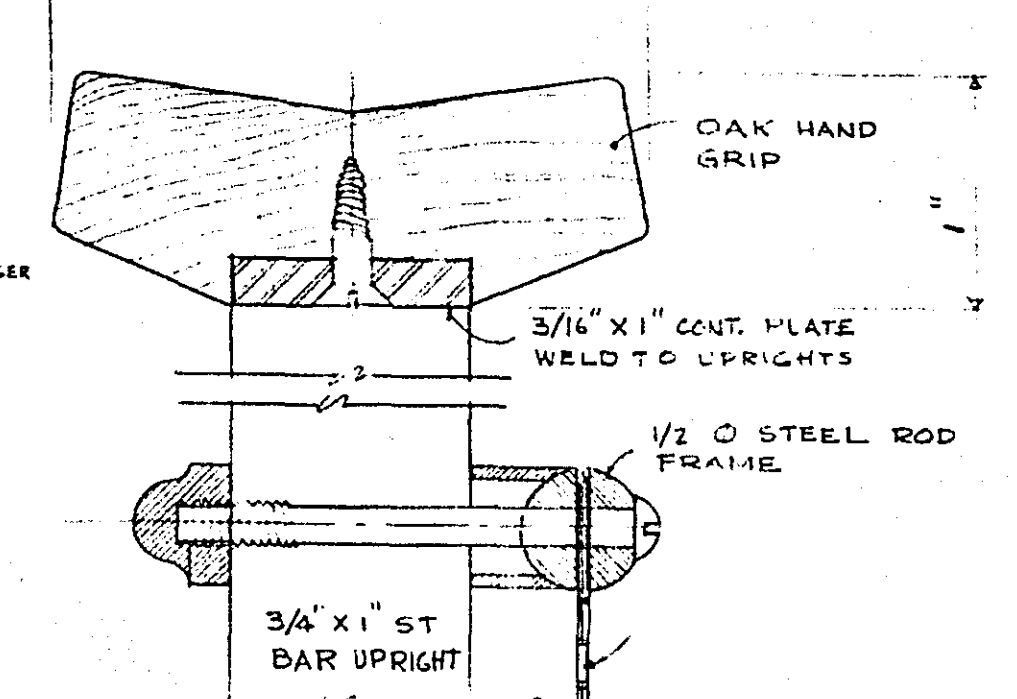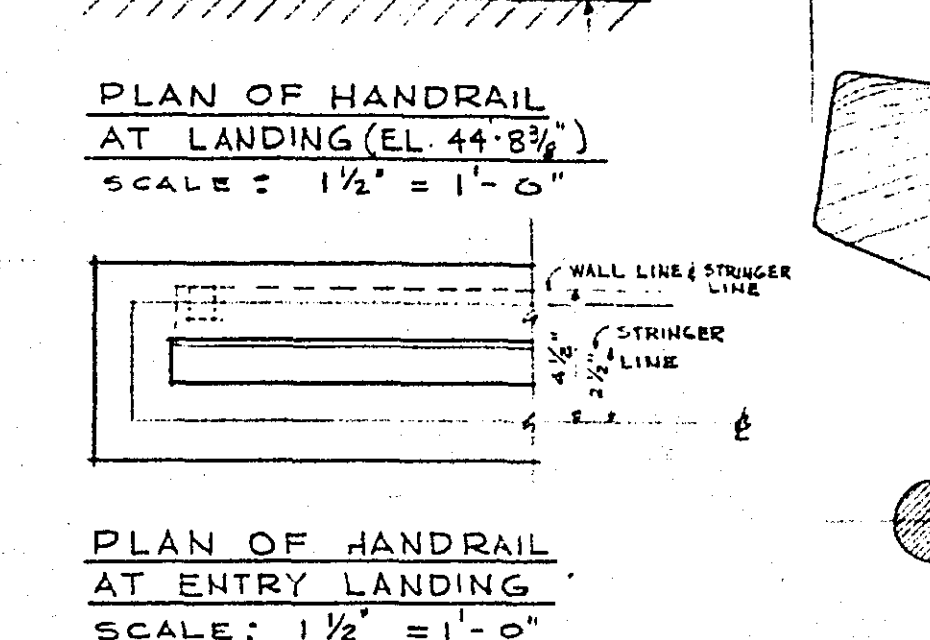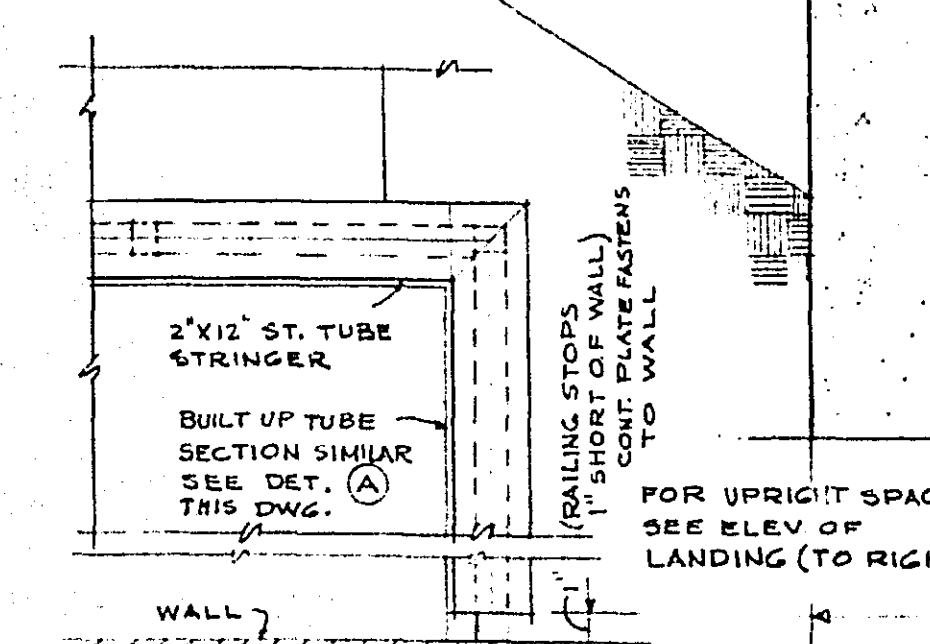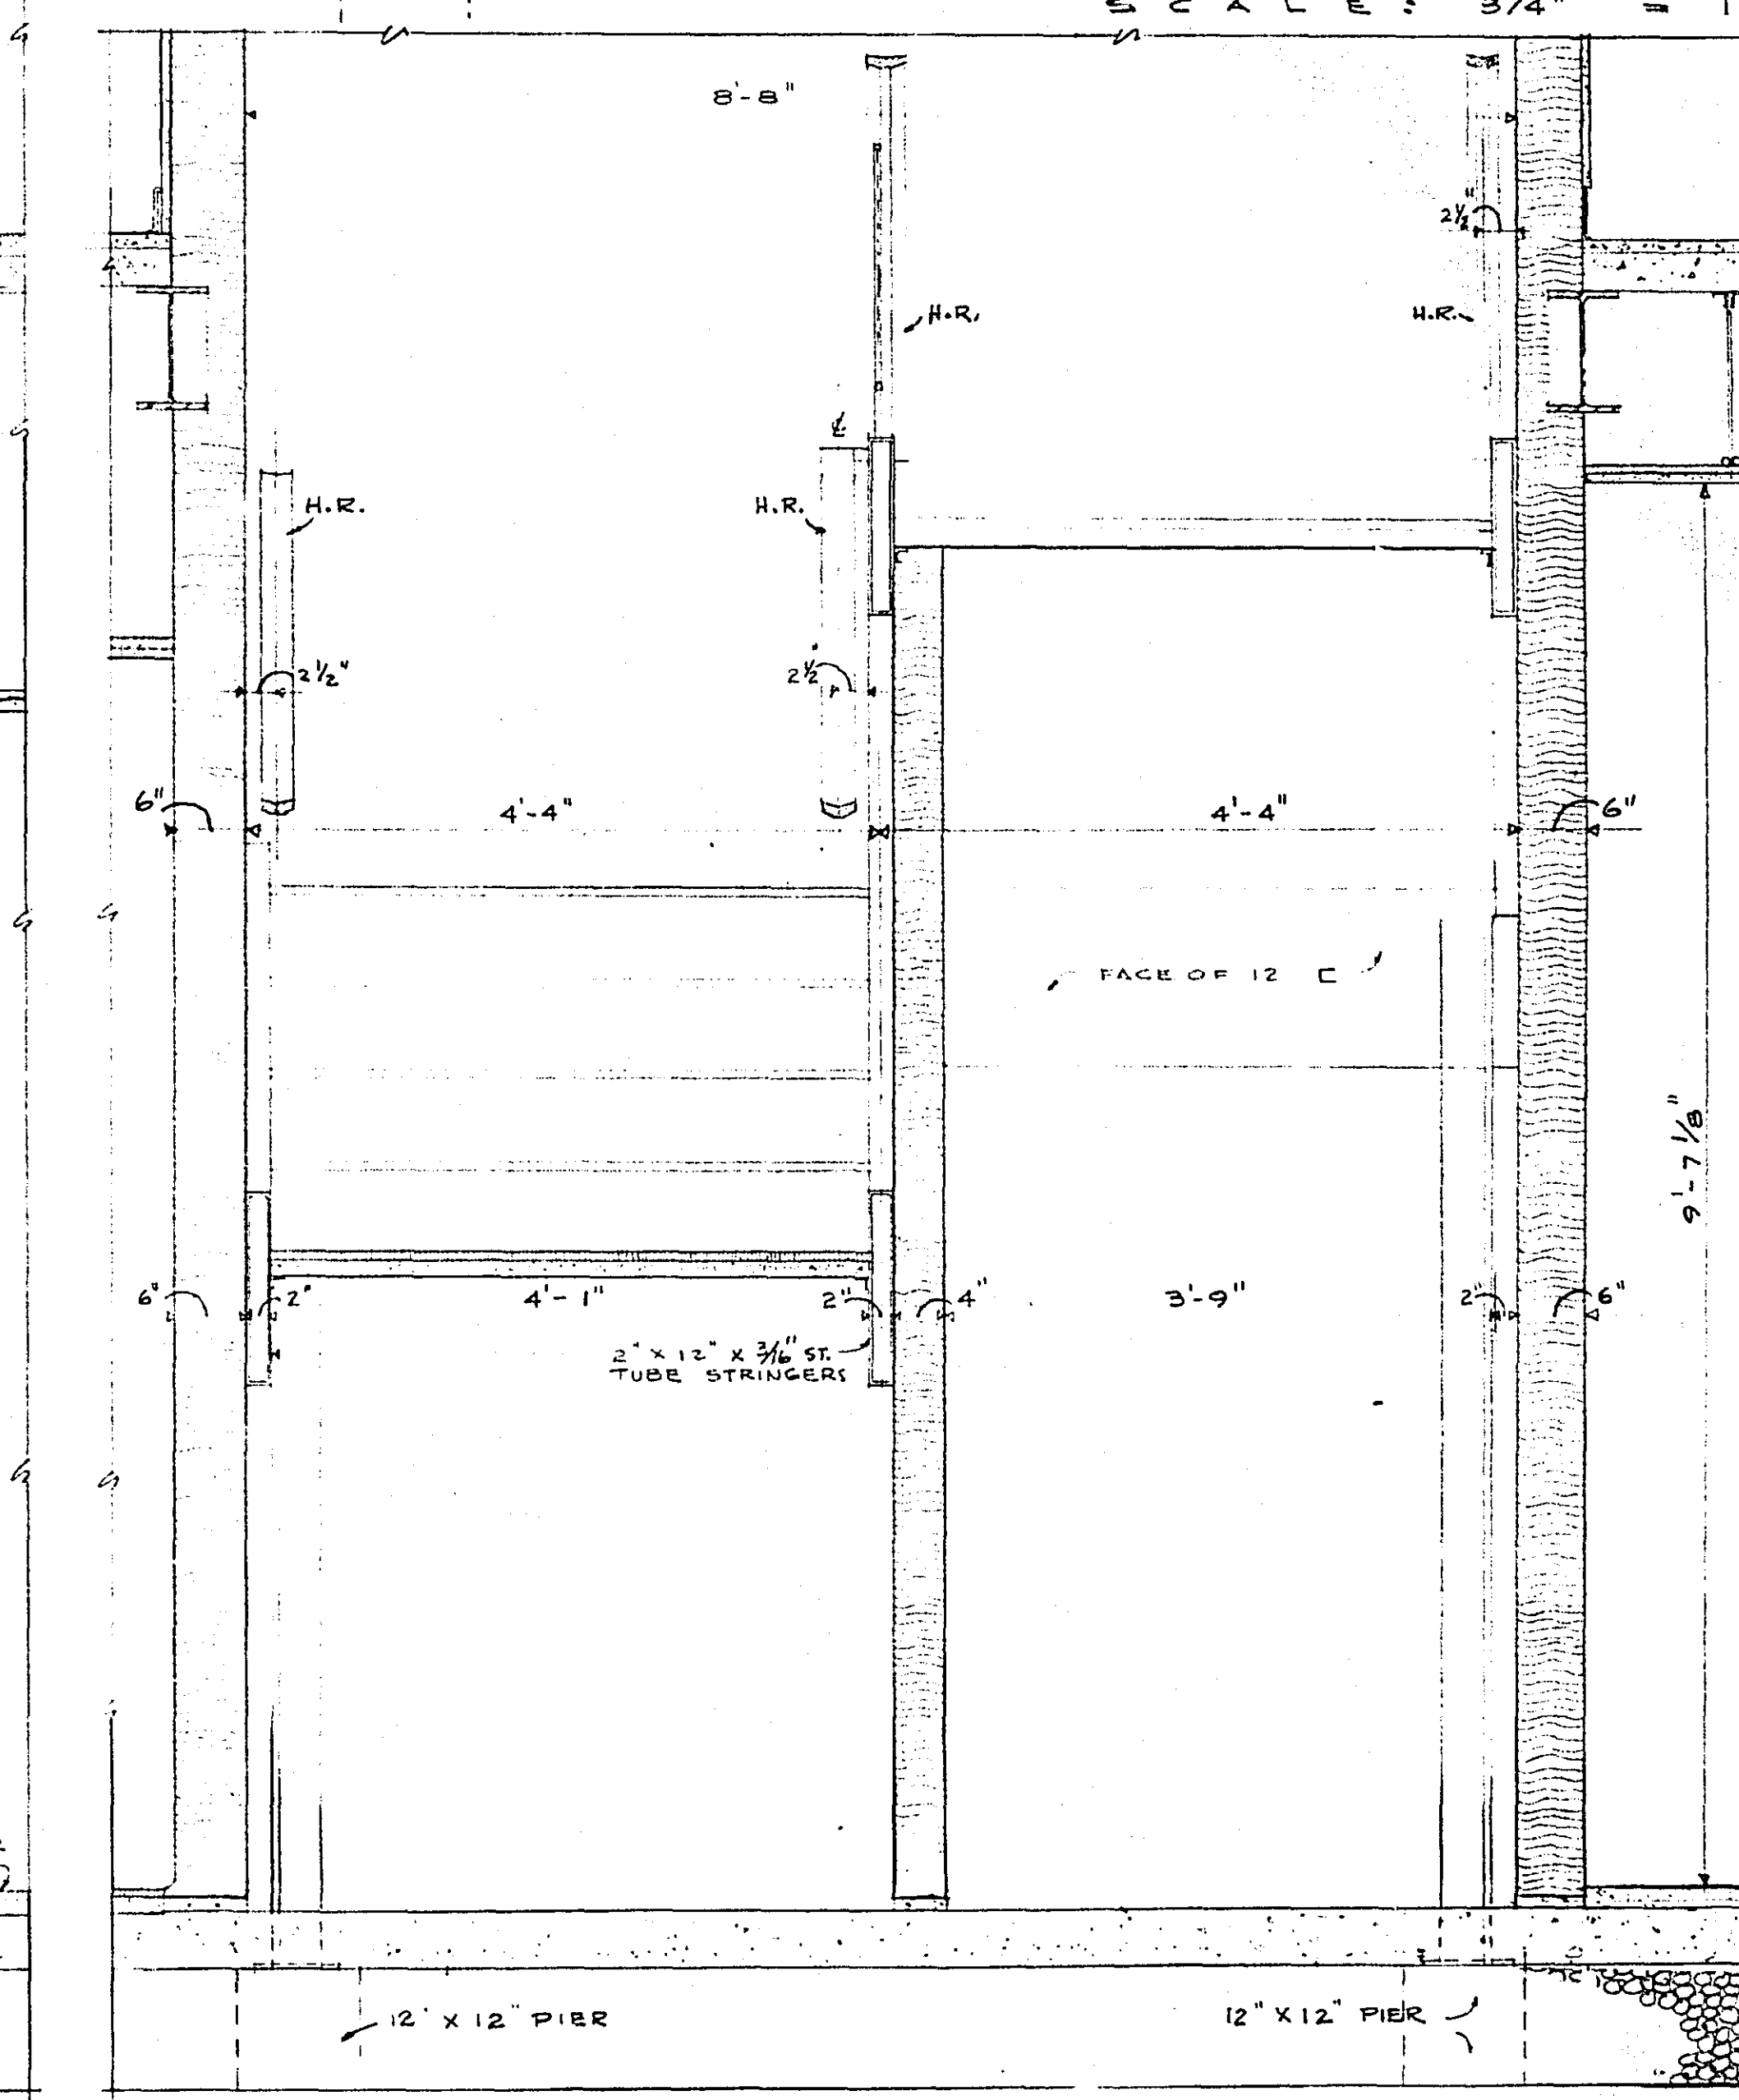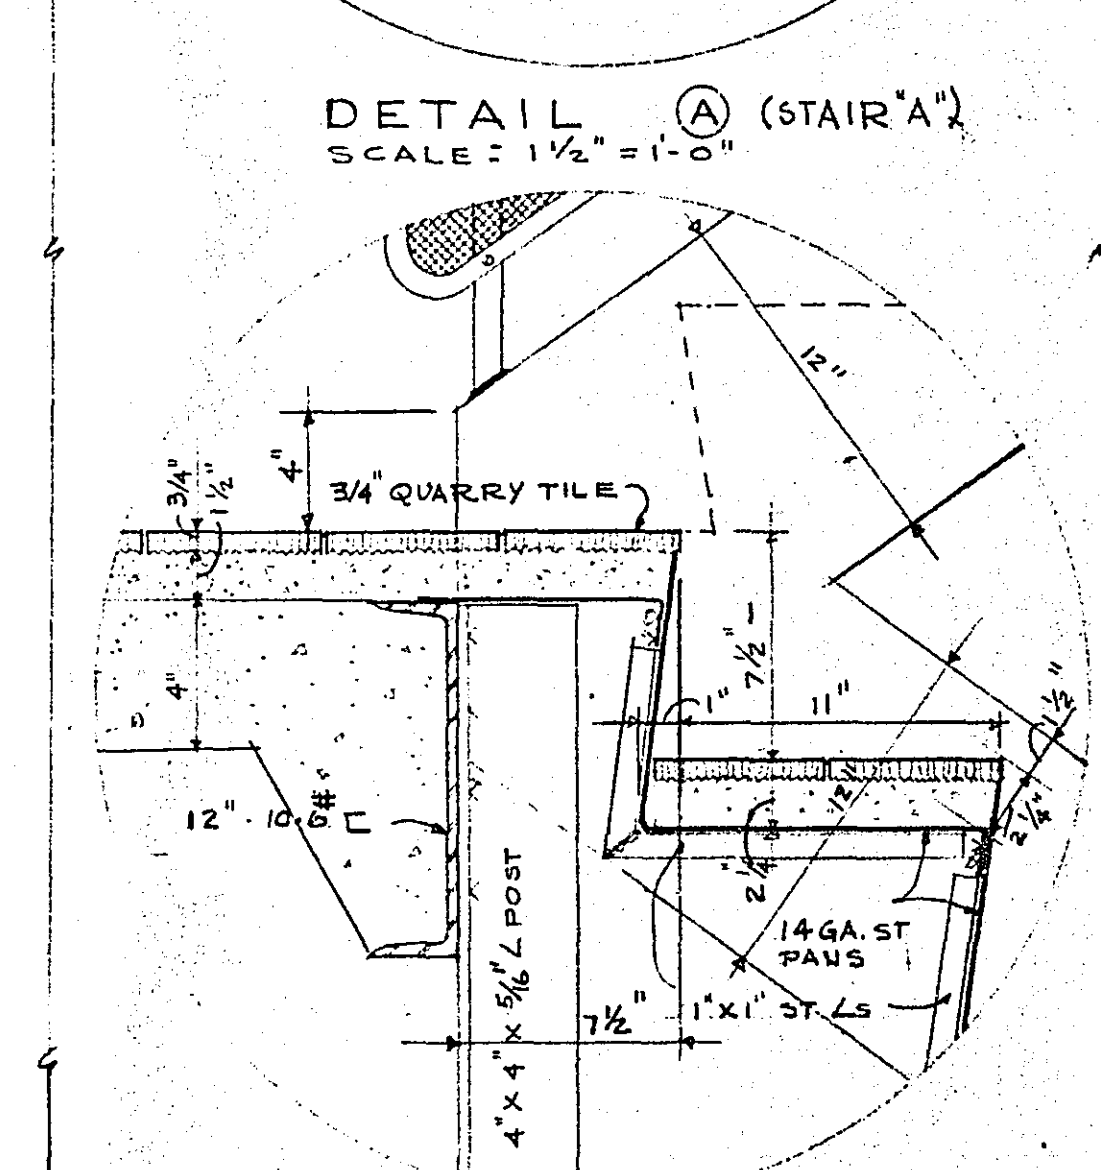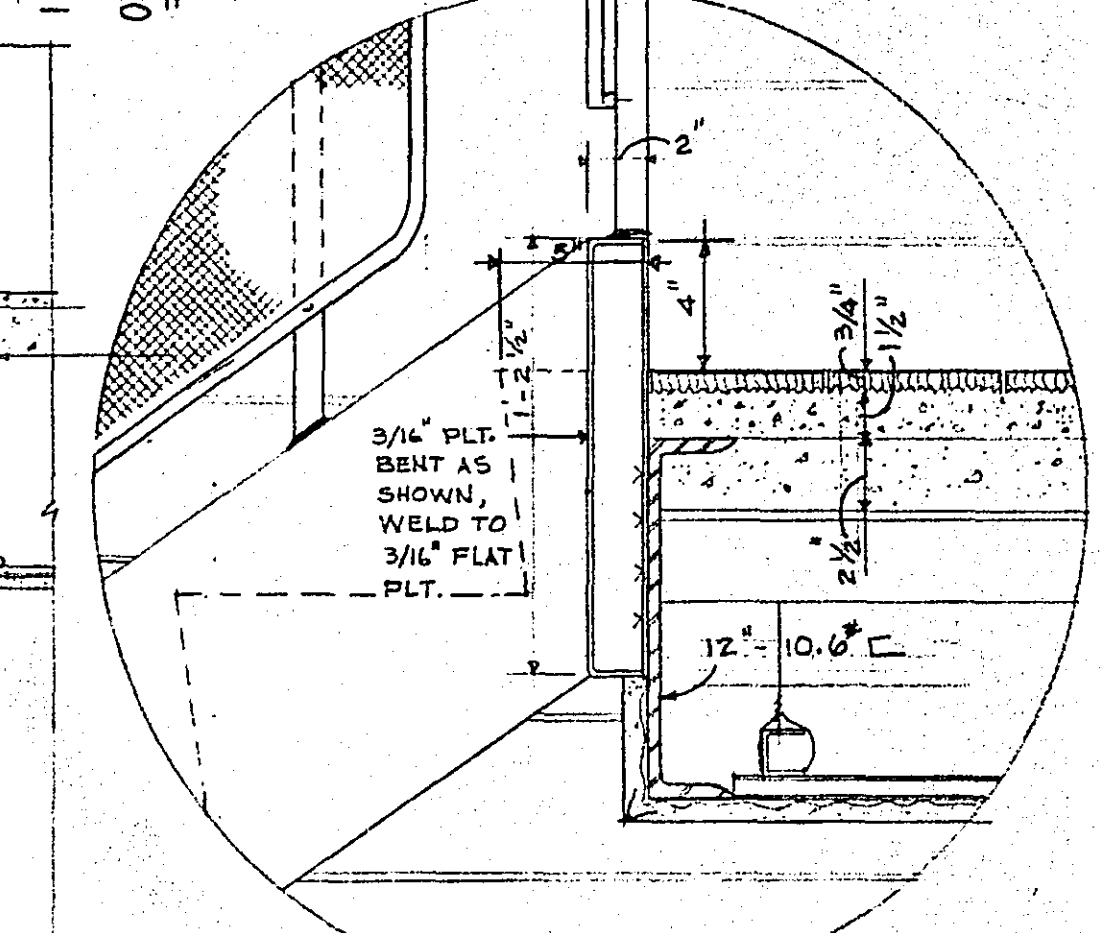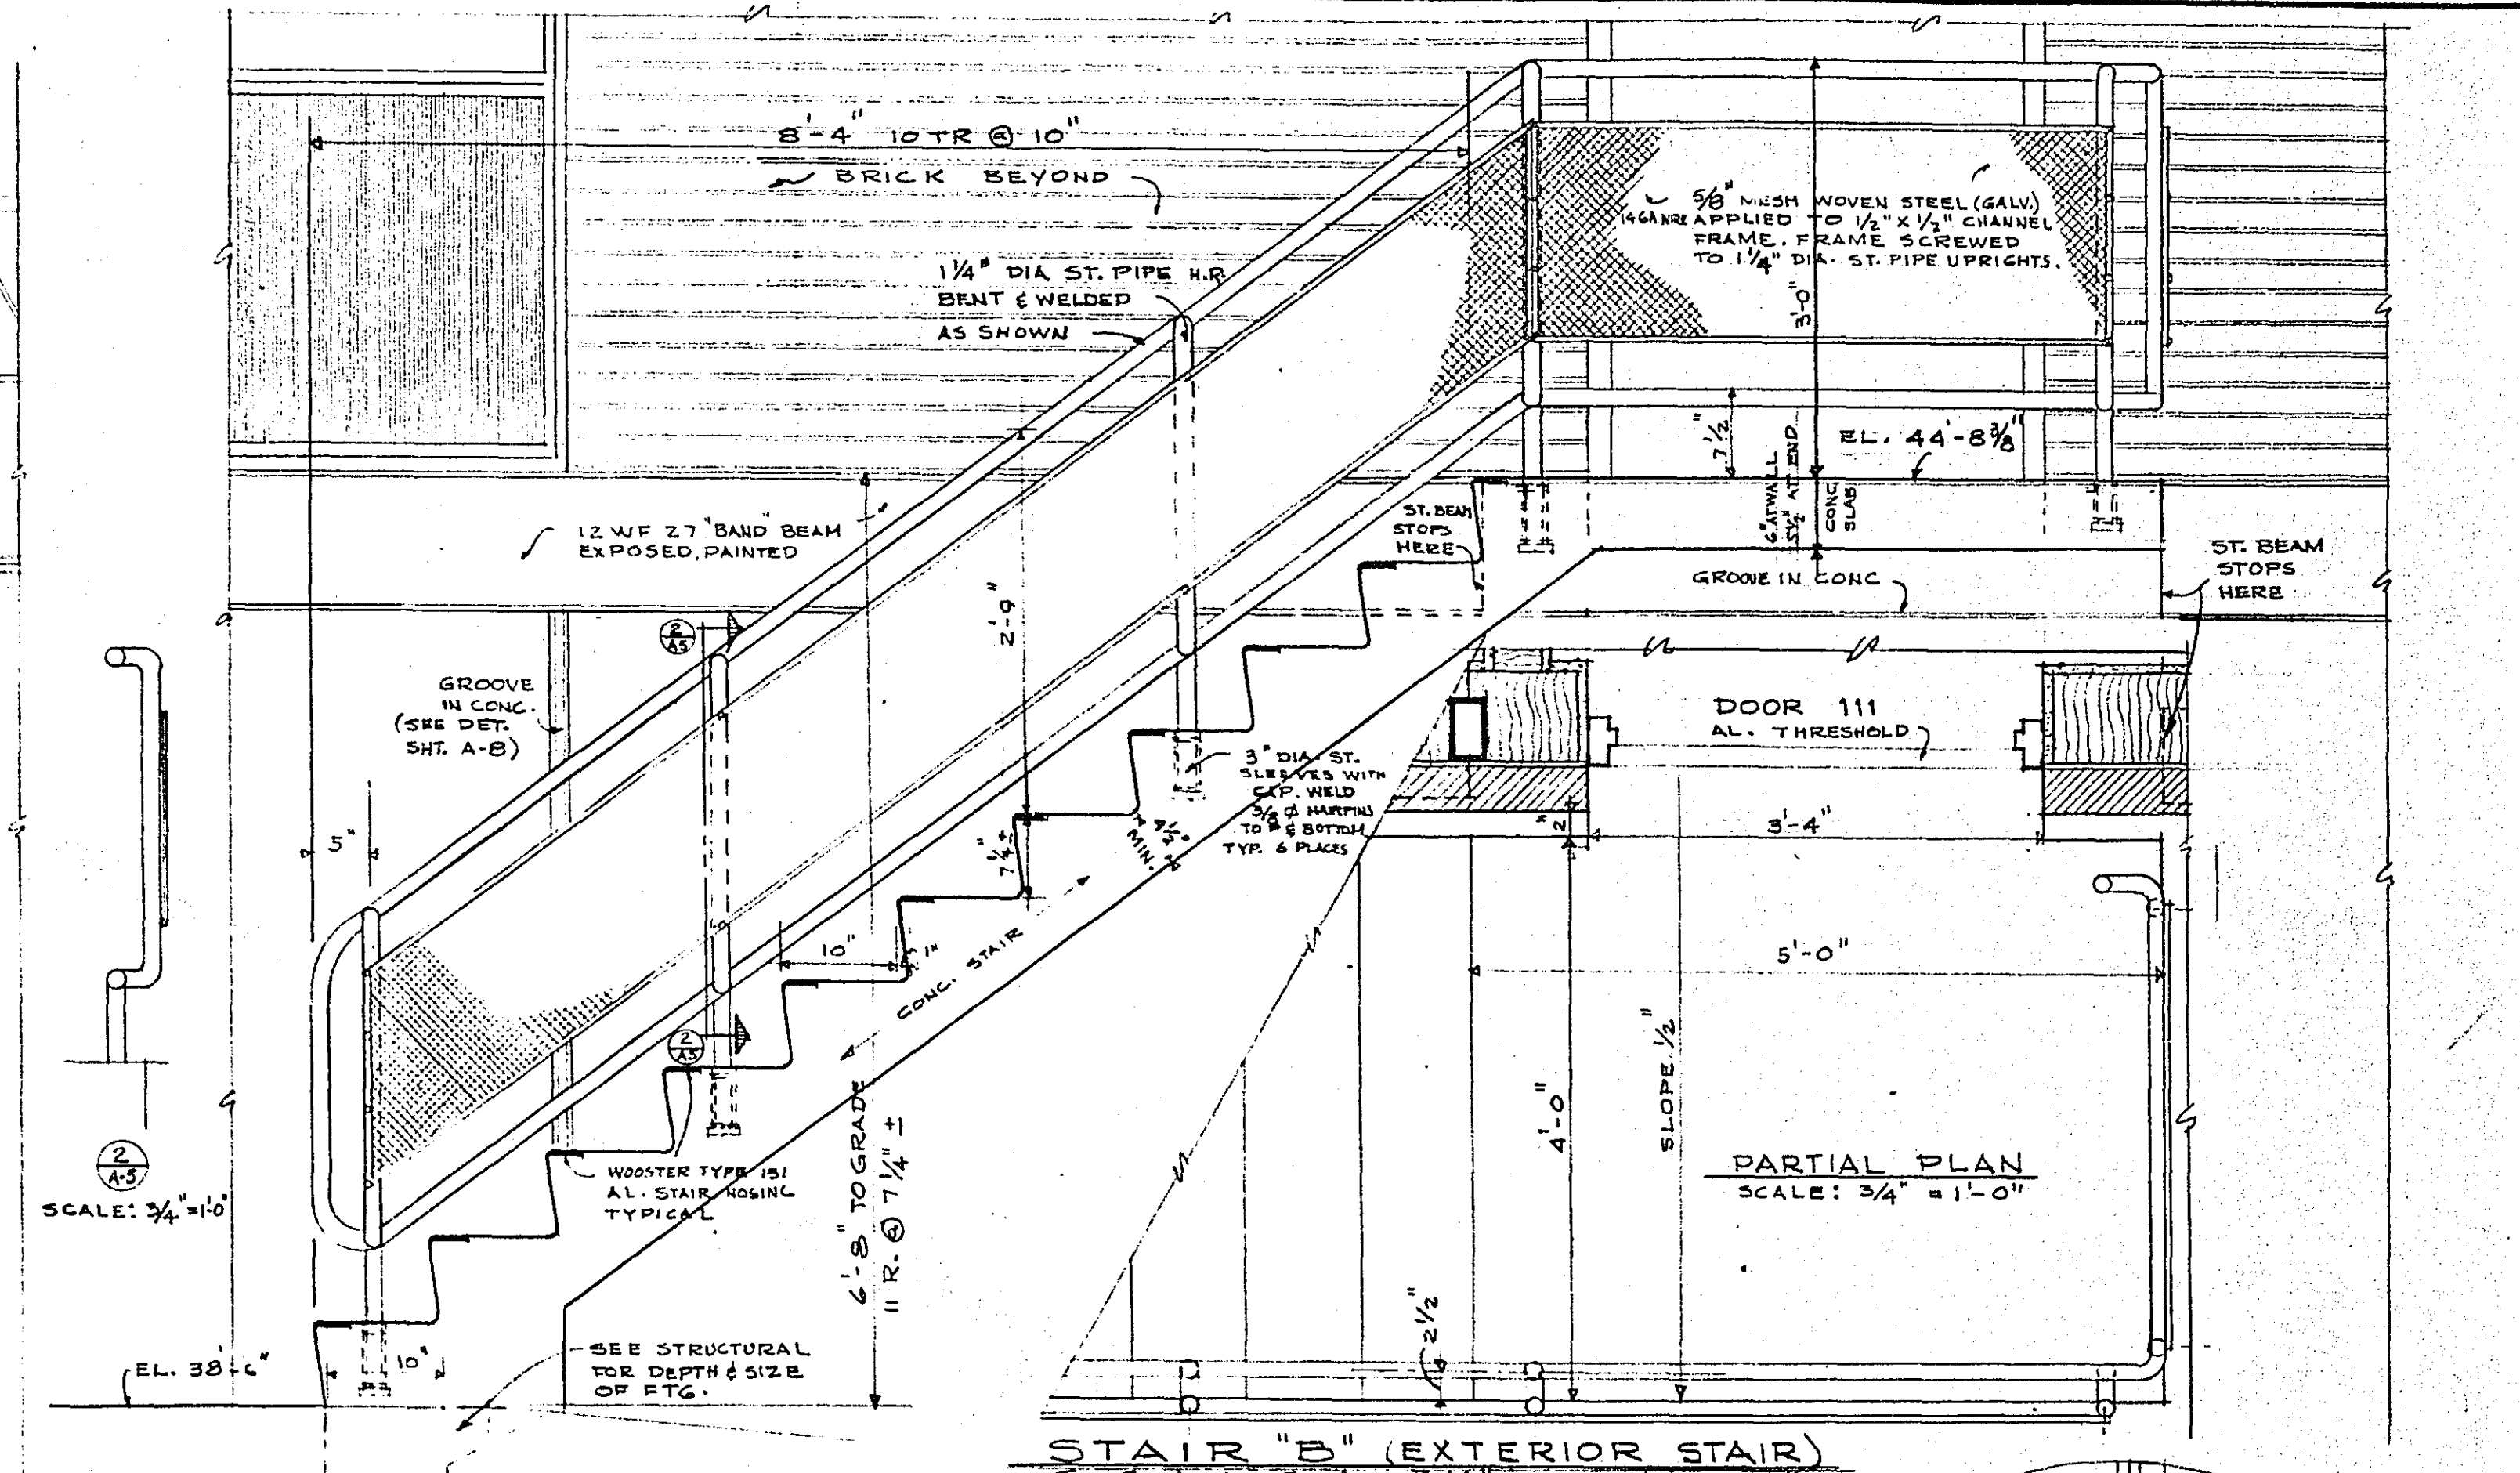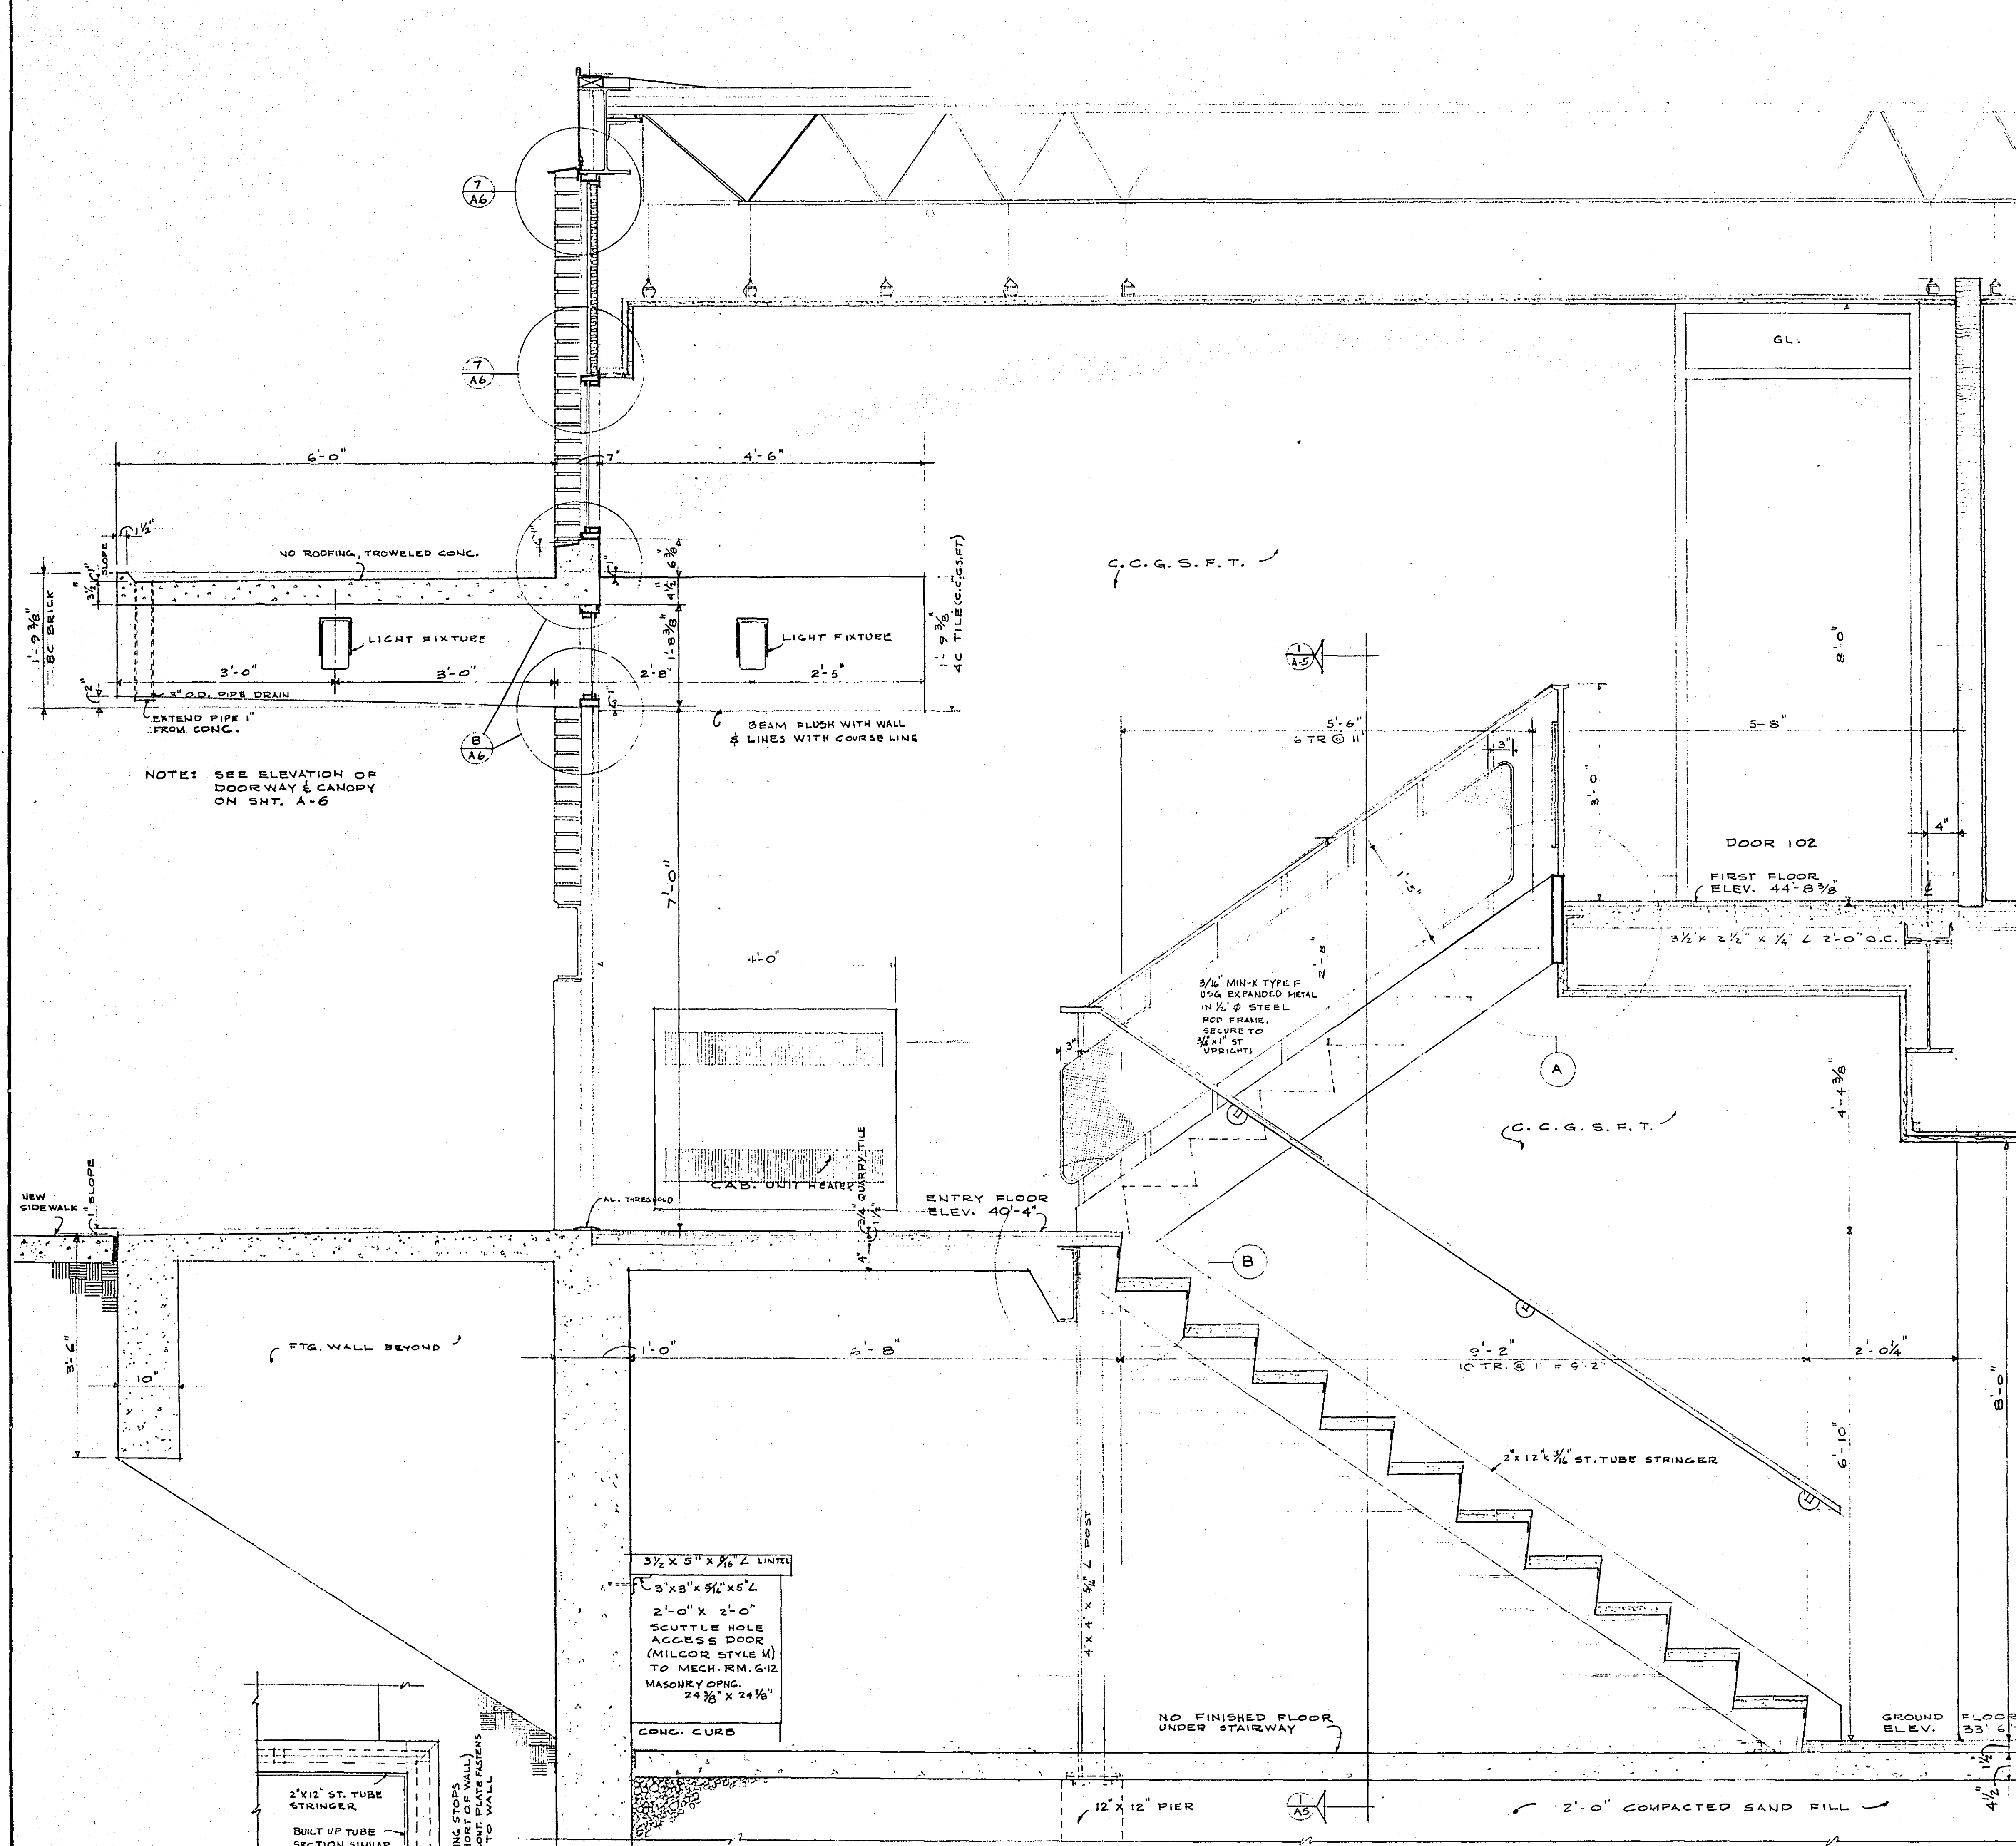


STAIR DETAILS			
RAMSEY COUNTY CORONERS OFFICE			
ST. PAUL,		MINNESOTA	
TOLTZ, KING, DUVAL, ANDERSON AND ASSOCIATES, INC.			
ST. PAUL, MINNESOTA		MICROFILMED RAMSEY CO. ENGR.	
ENGINEERS AND ARCHITECTS			
DESIGNED R.L.L.	I hereby certify that this plan was prepared by me or under my direct supervision and that I am a duly Registered ARCHITECT under the laws of the State of Minnesota. <i>Michael A. Anderson</i>		COM. 4603
DRAWN R.L.L.	Date OCTOBER 7, 1963 Reg. No. 685		DRG. A-5
CHECKED			

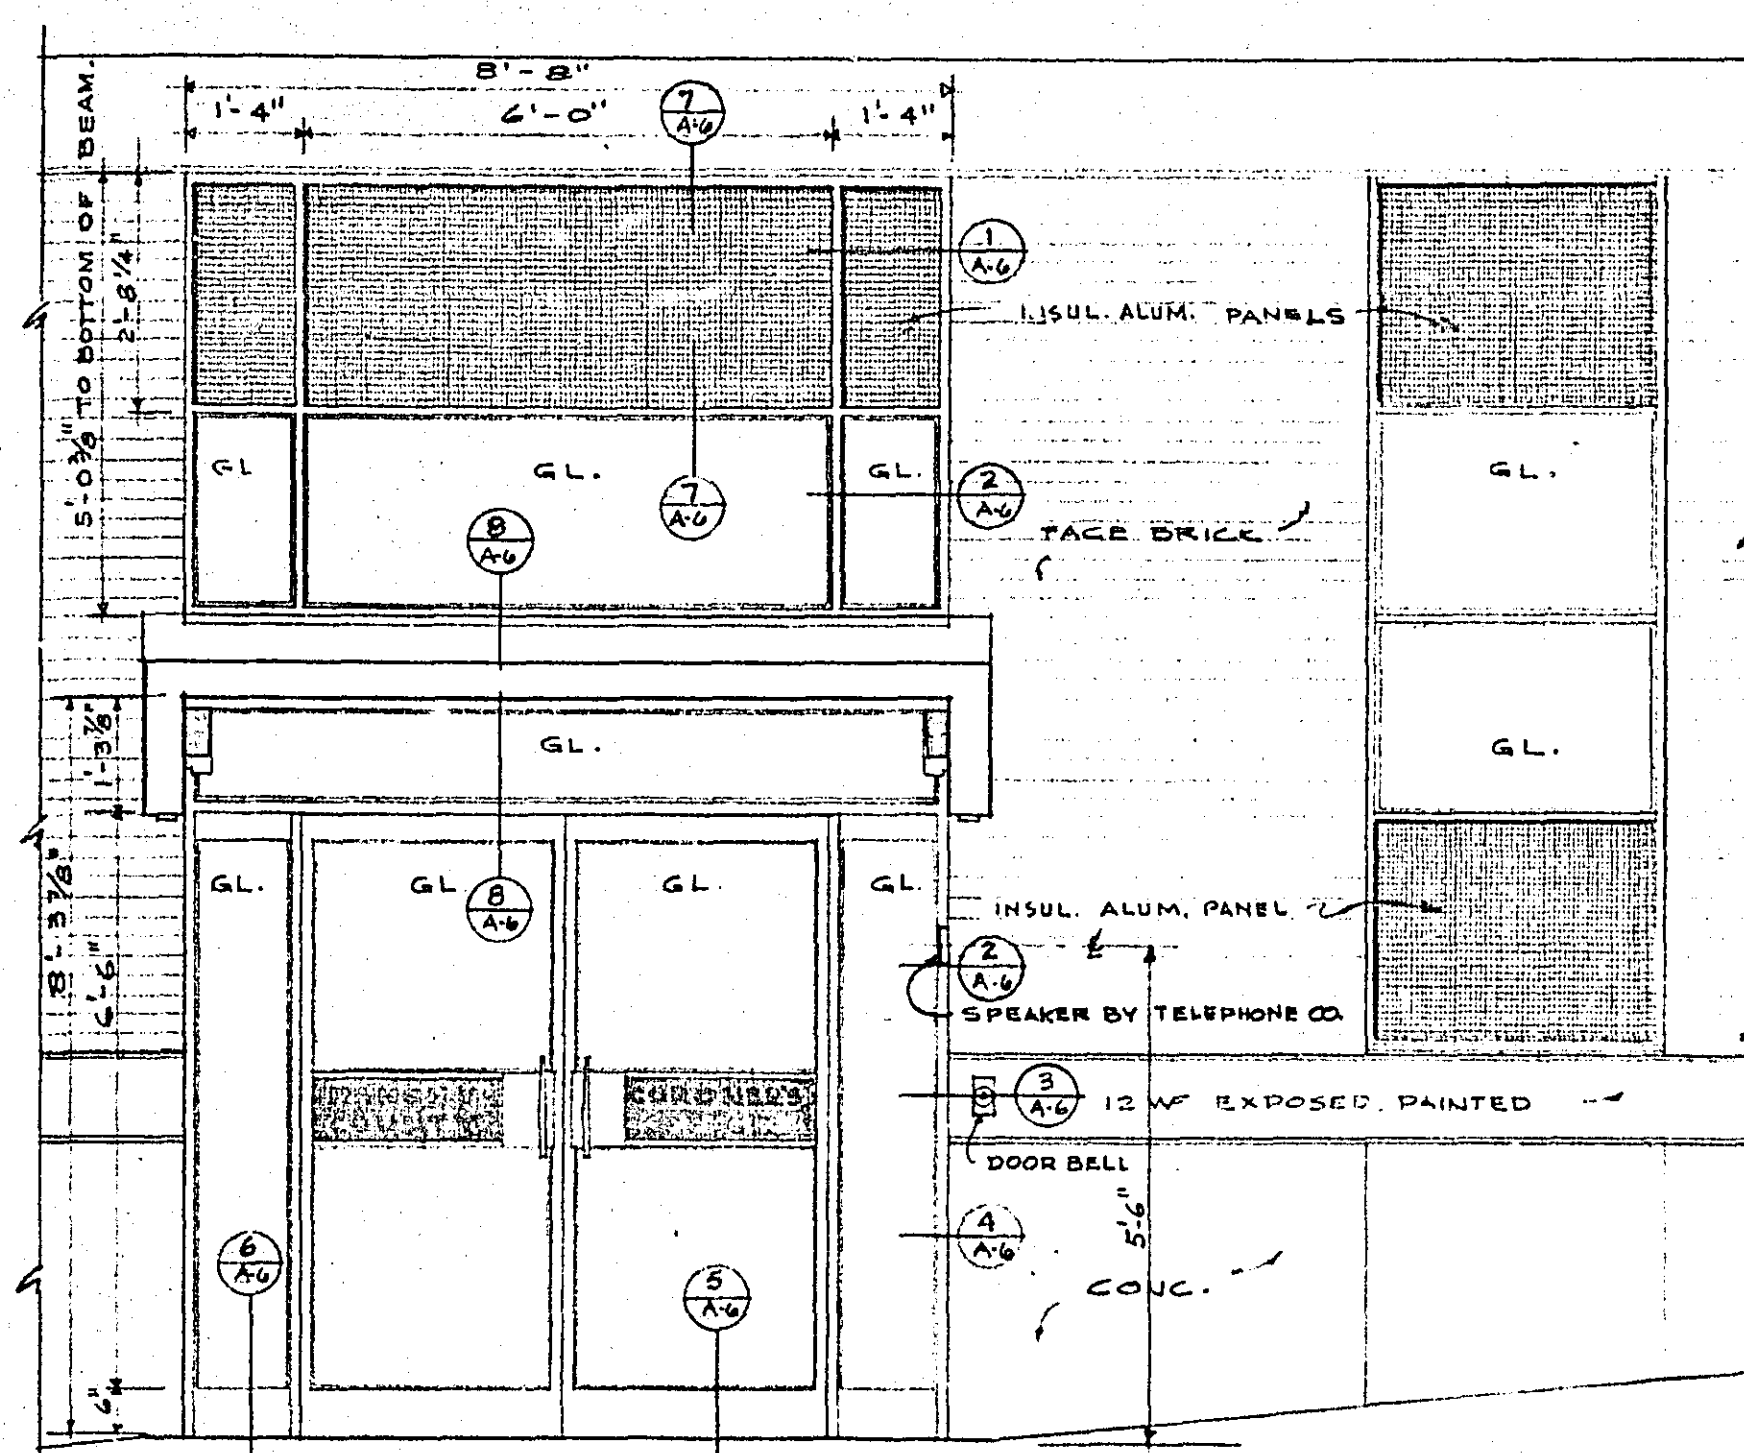


MAIN ENTRANCE (HILL ST.)
SCALE: 3/8" = 1'-0"

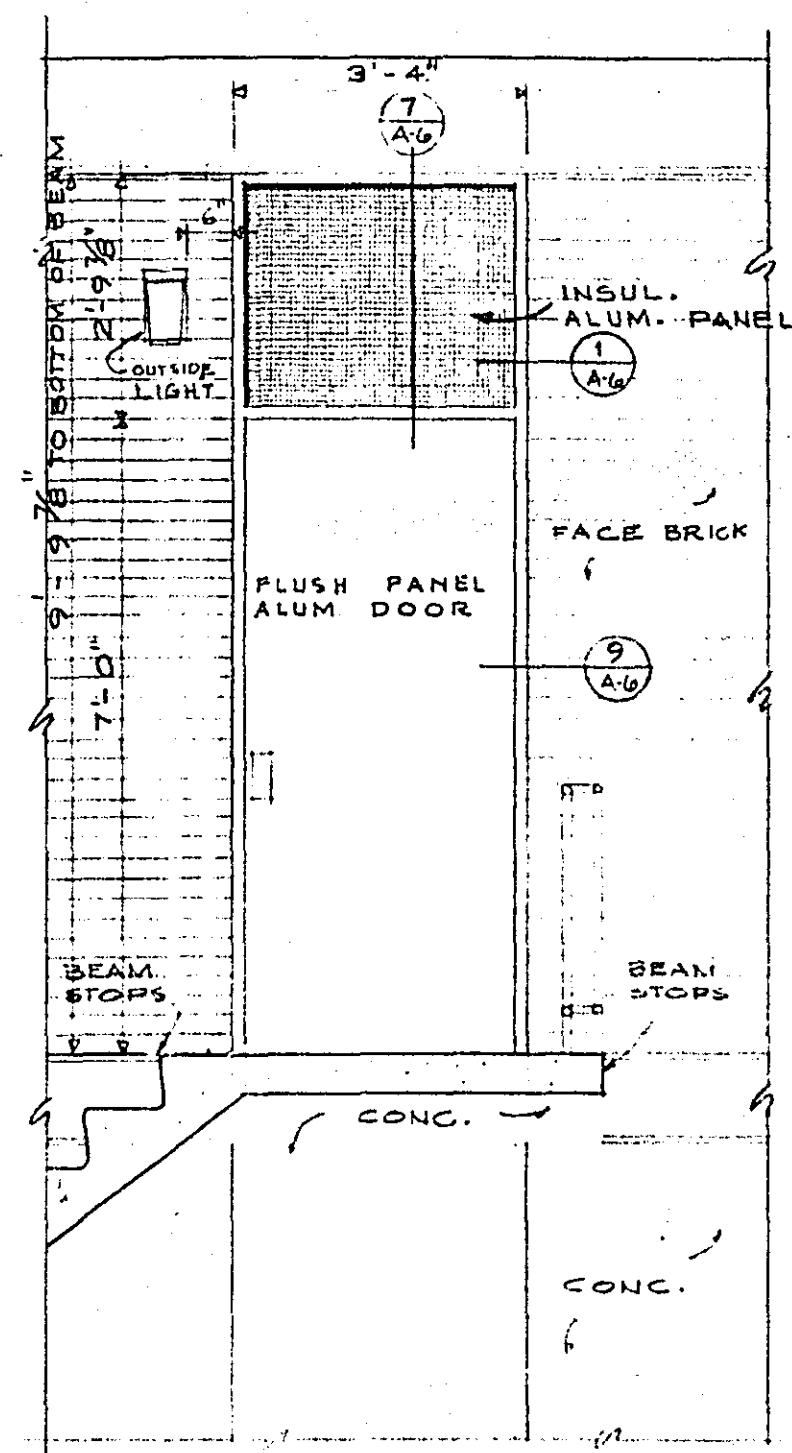

WEST ENTRANCE
SCALE: 3/8" = 1'-0"


























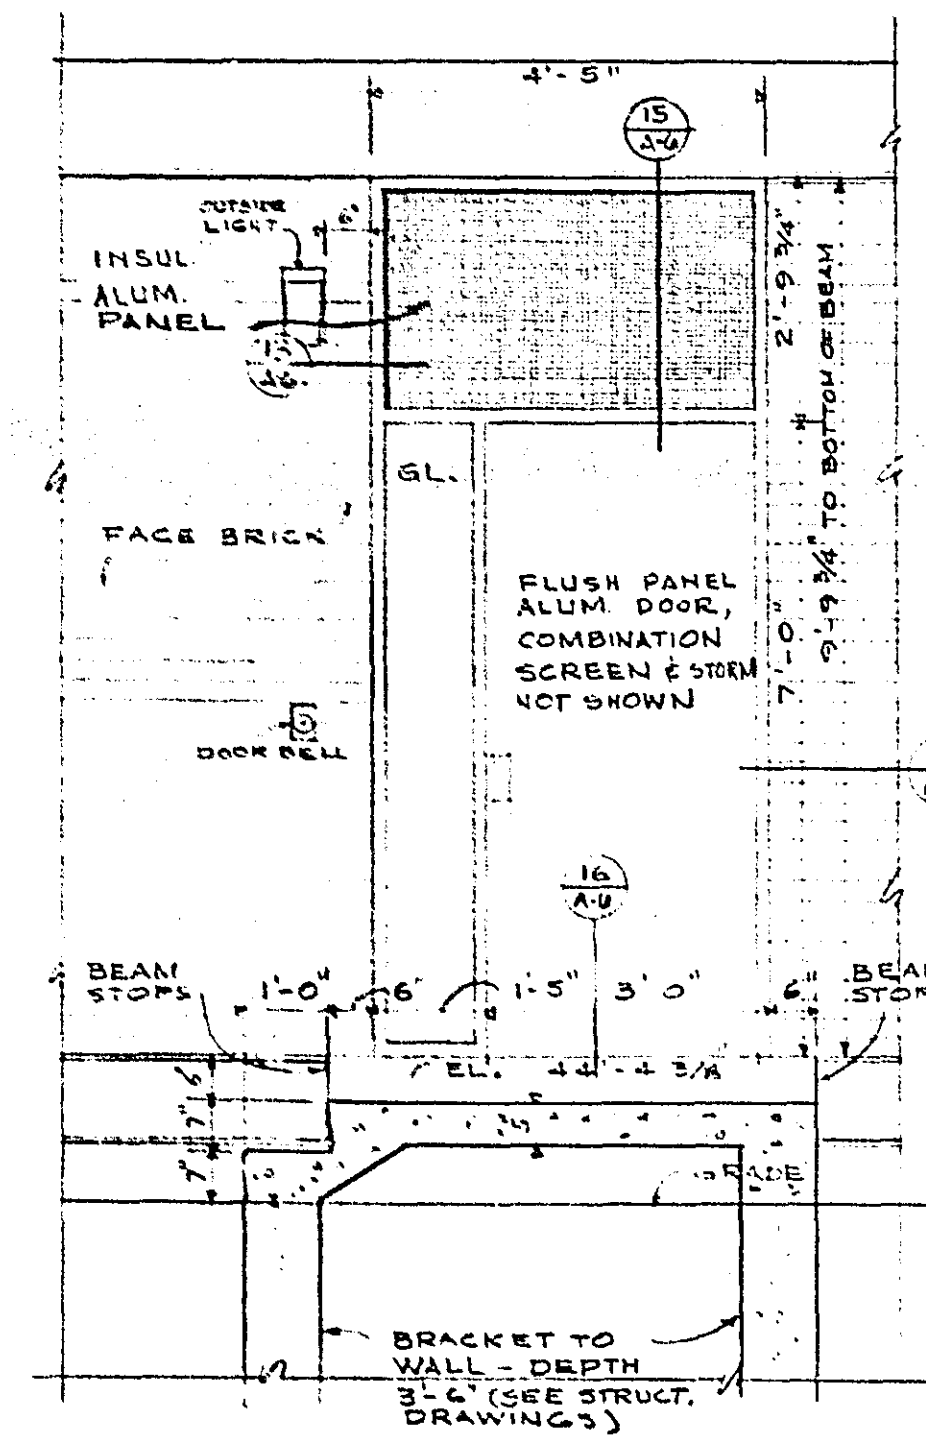


NORTH ENTRANCE (APT.)
SCALE: 3/8" = 1'-0"

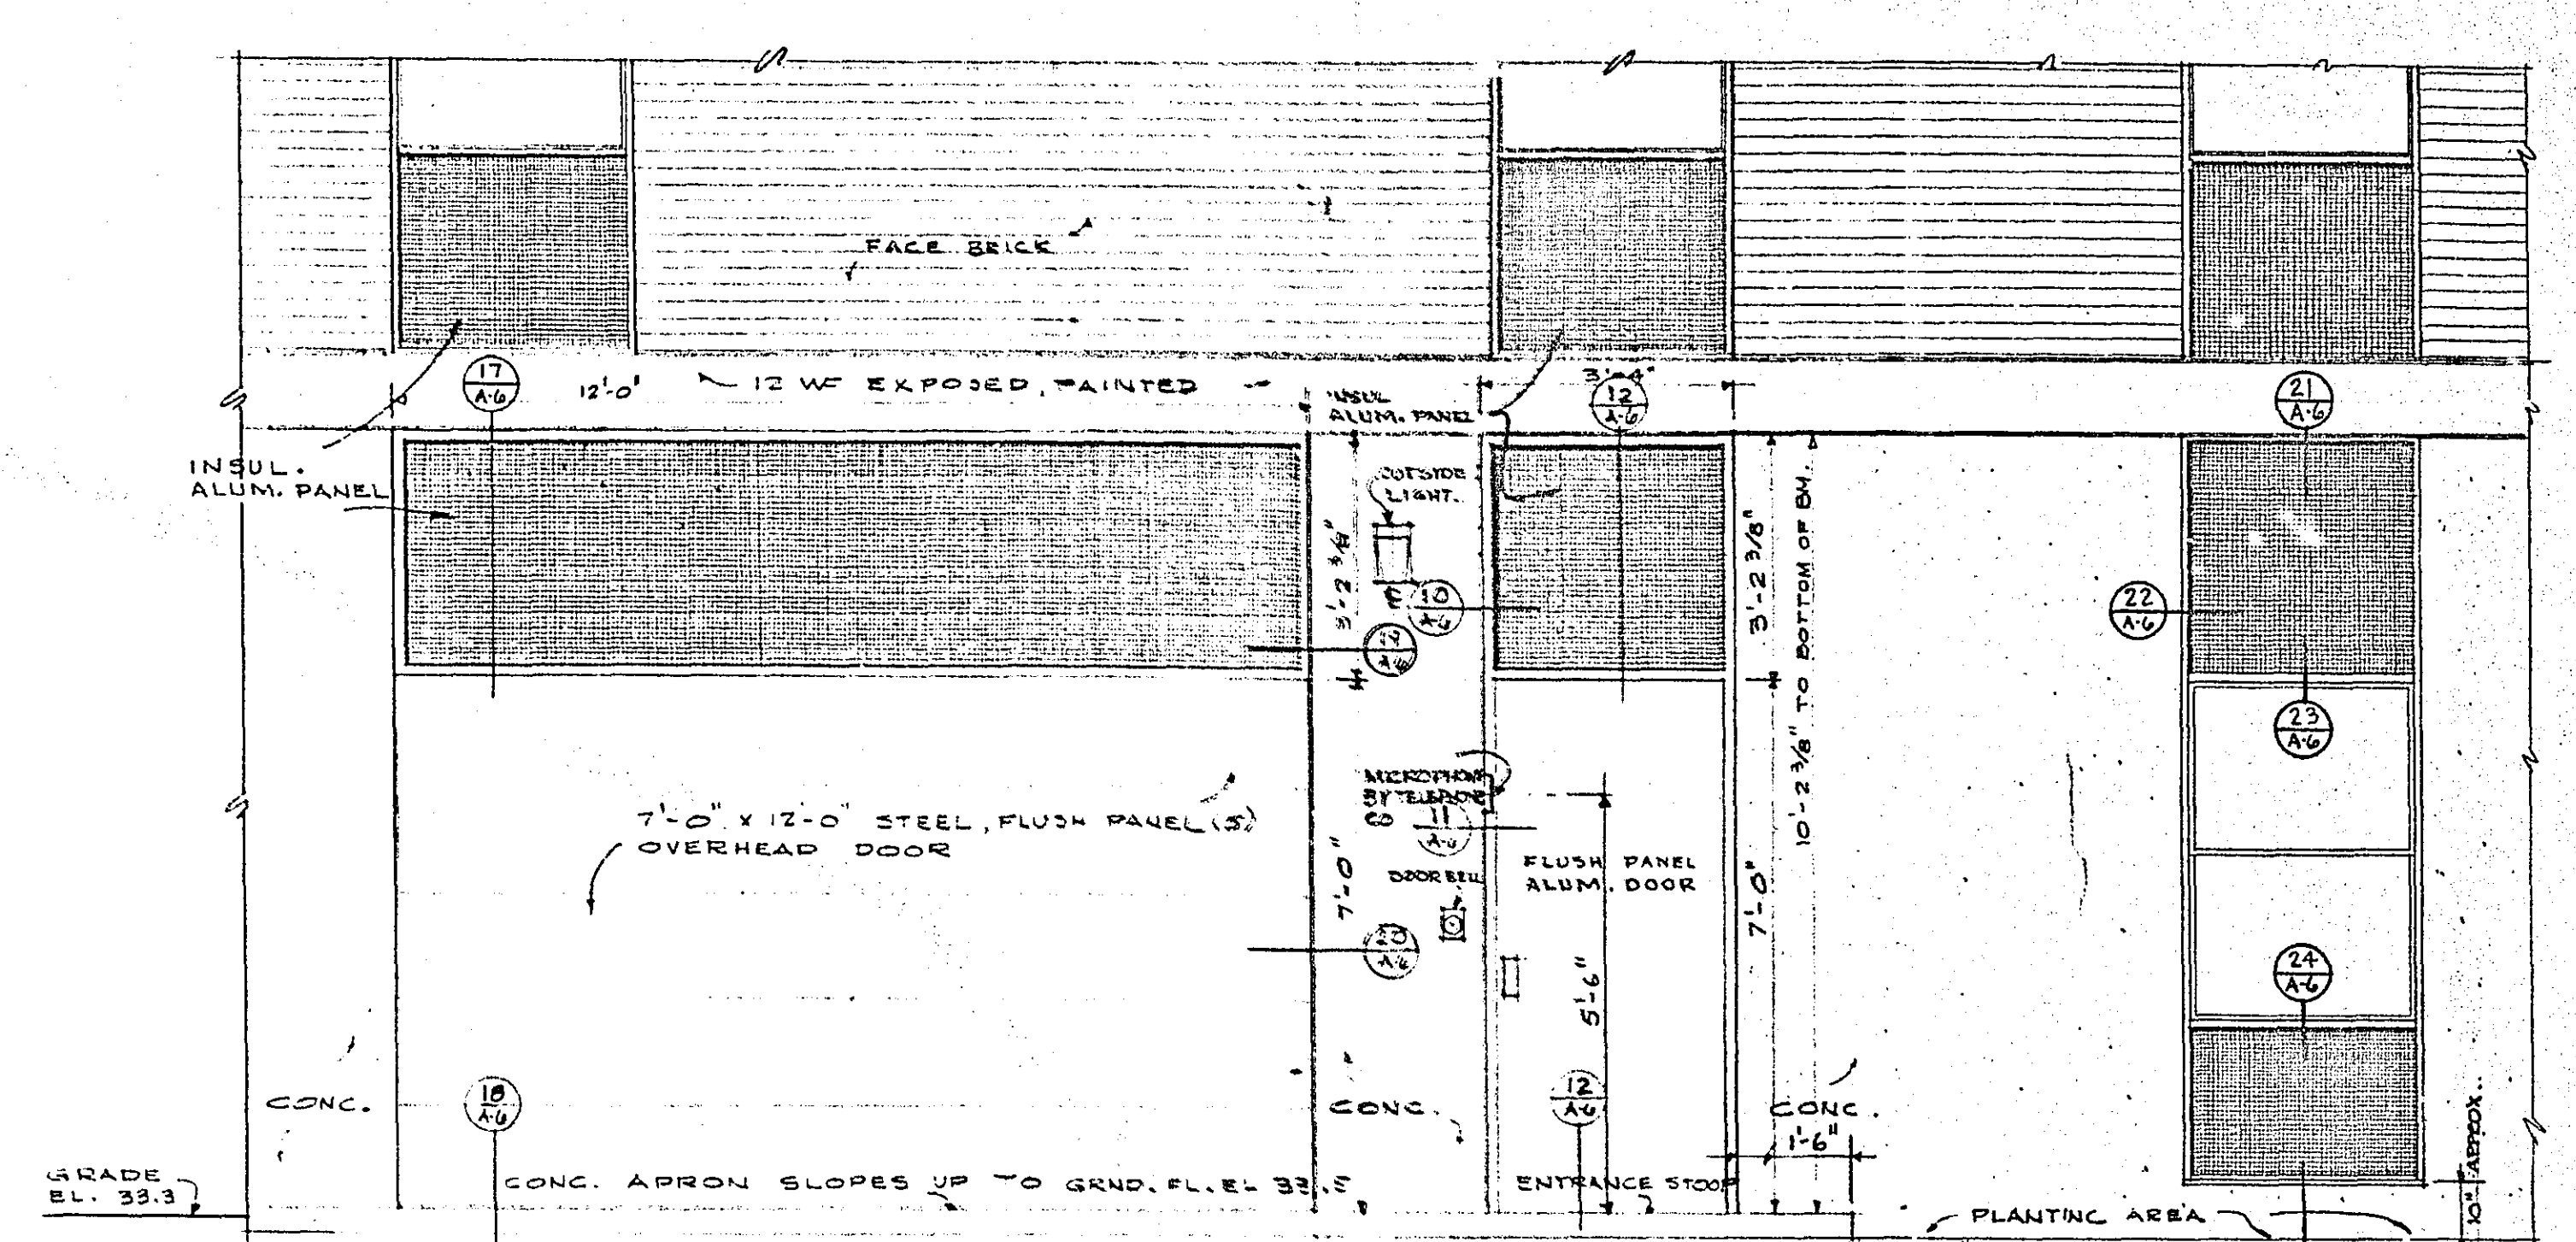

SOUTH ENTRANCE, RECEIVING & PEDESTRIAN
SCALE: 3/8" = 1'-0"

ENTRANCE ELEVATIONS

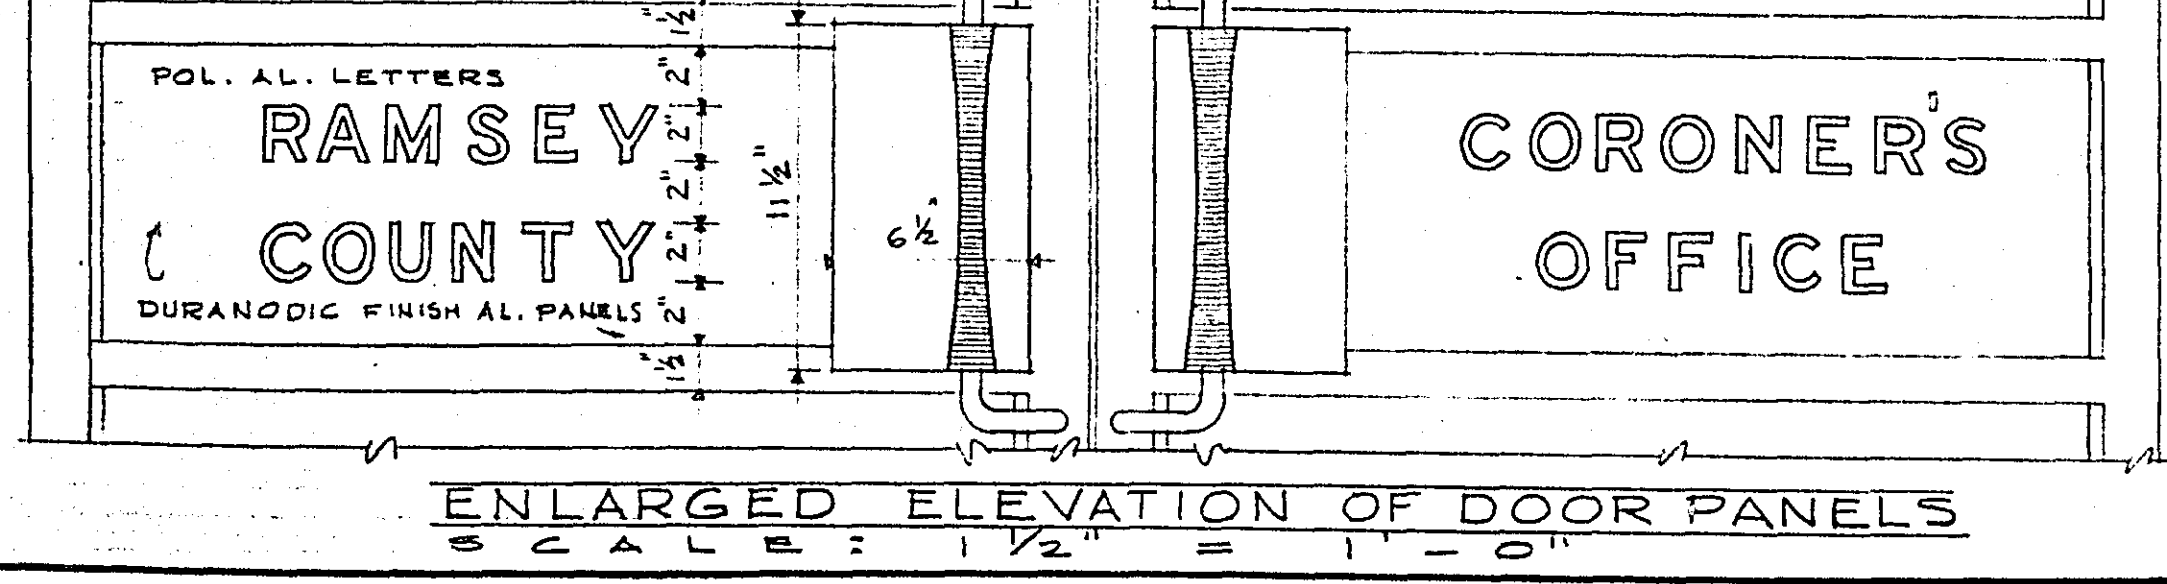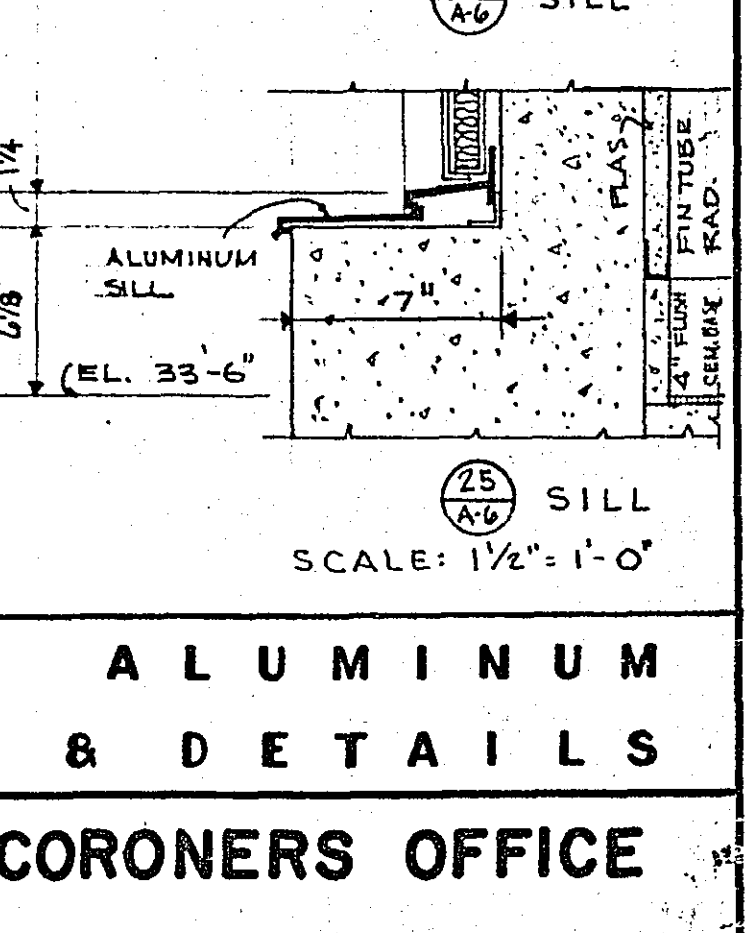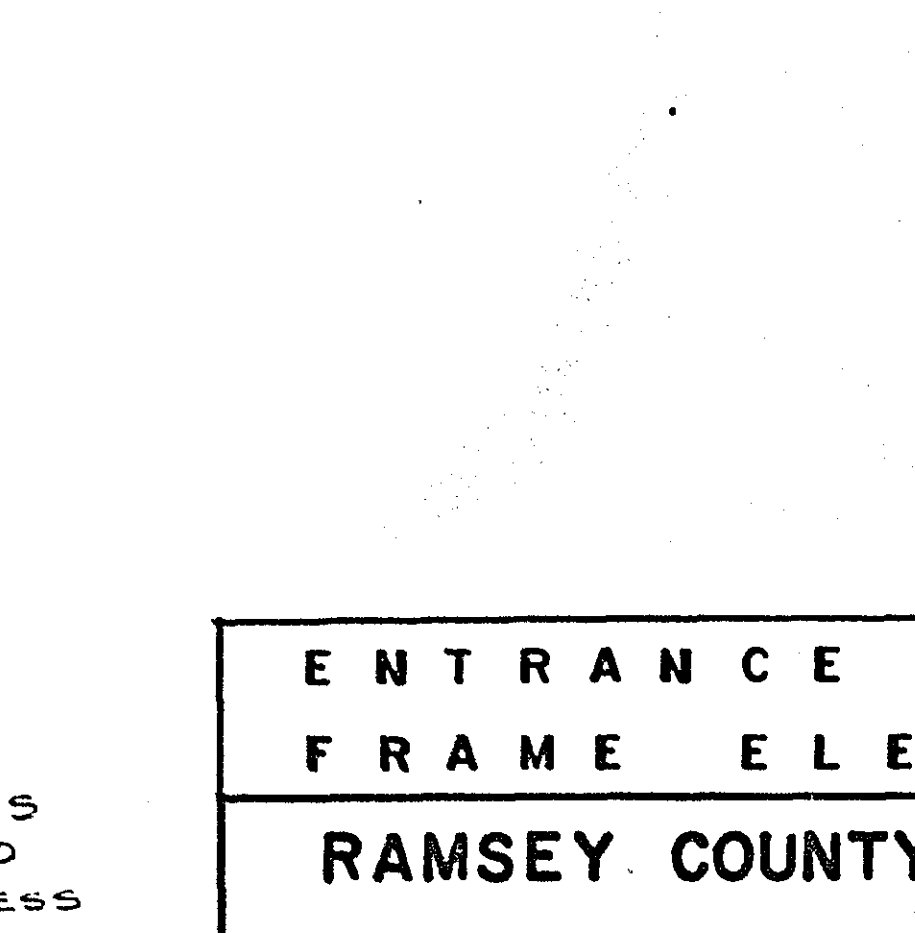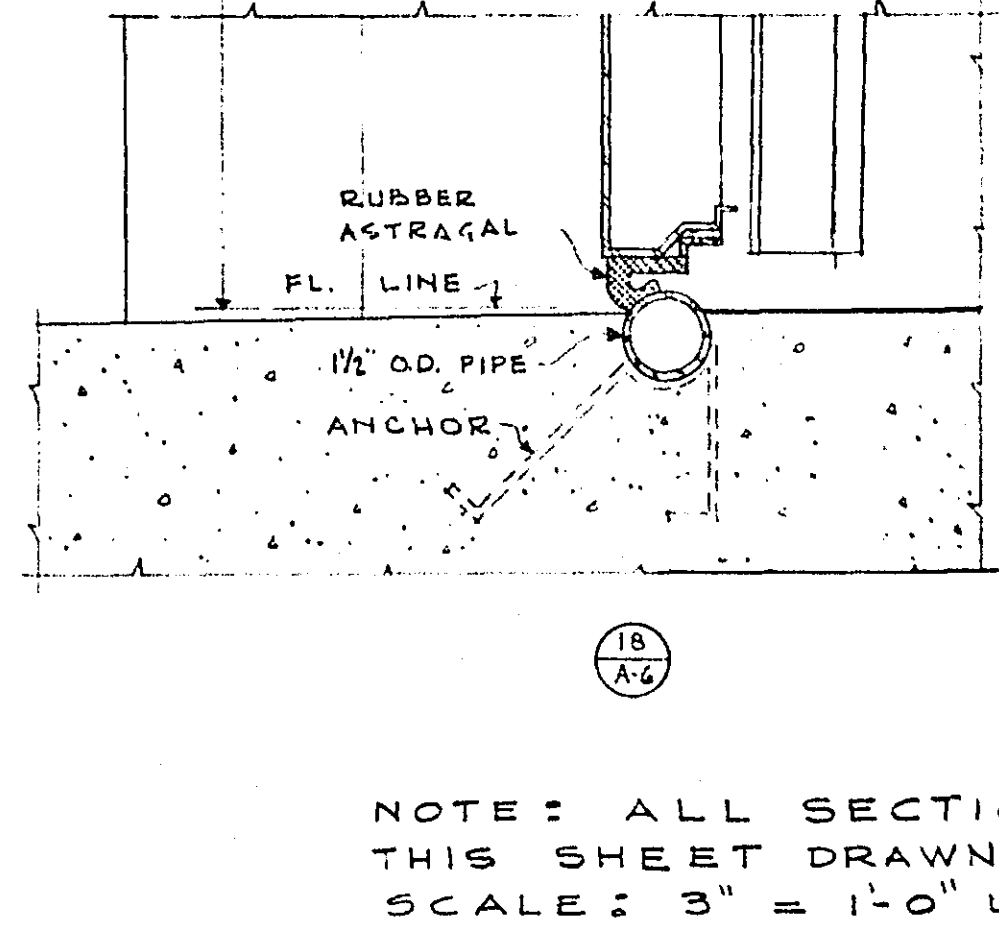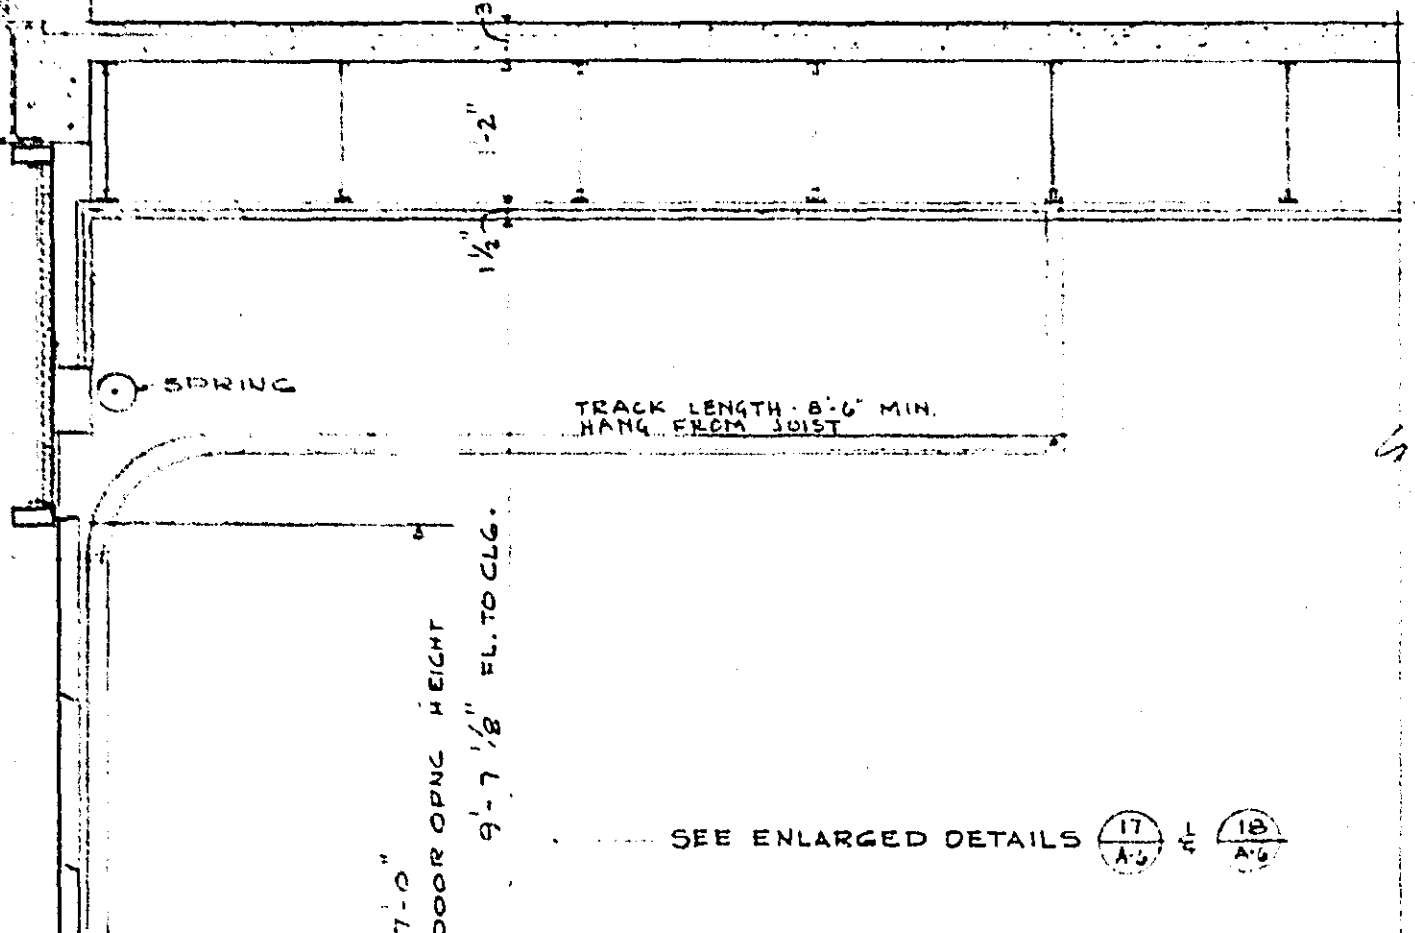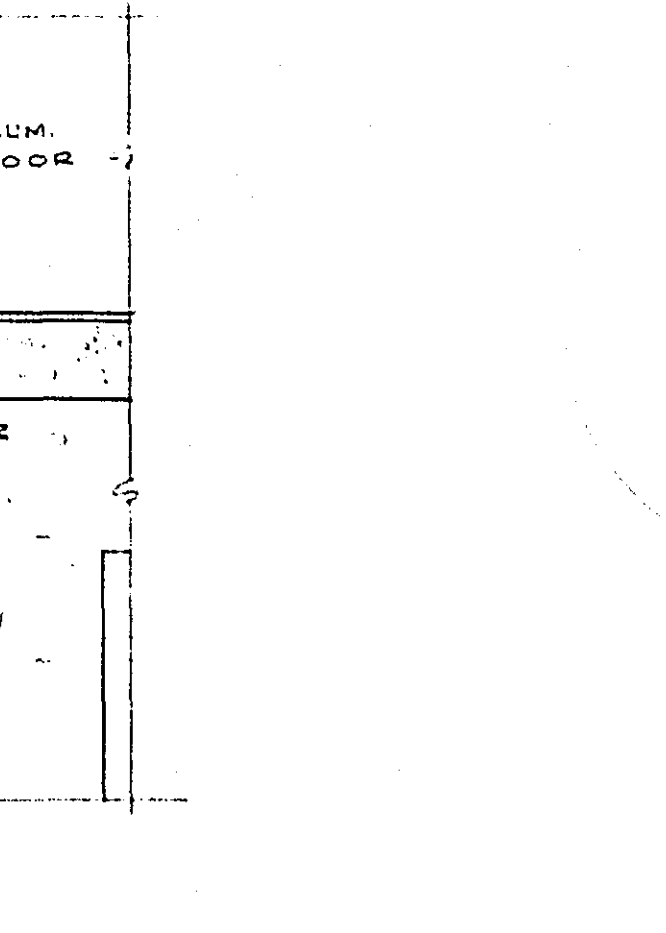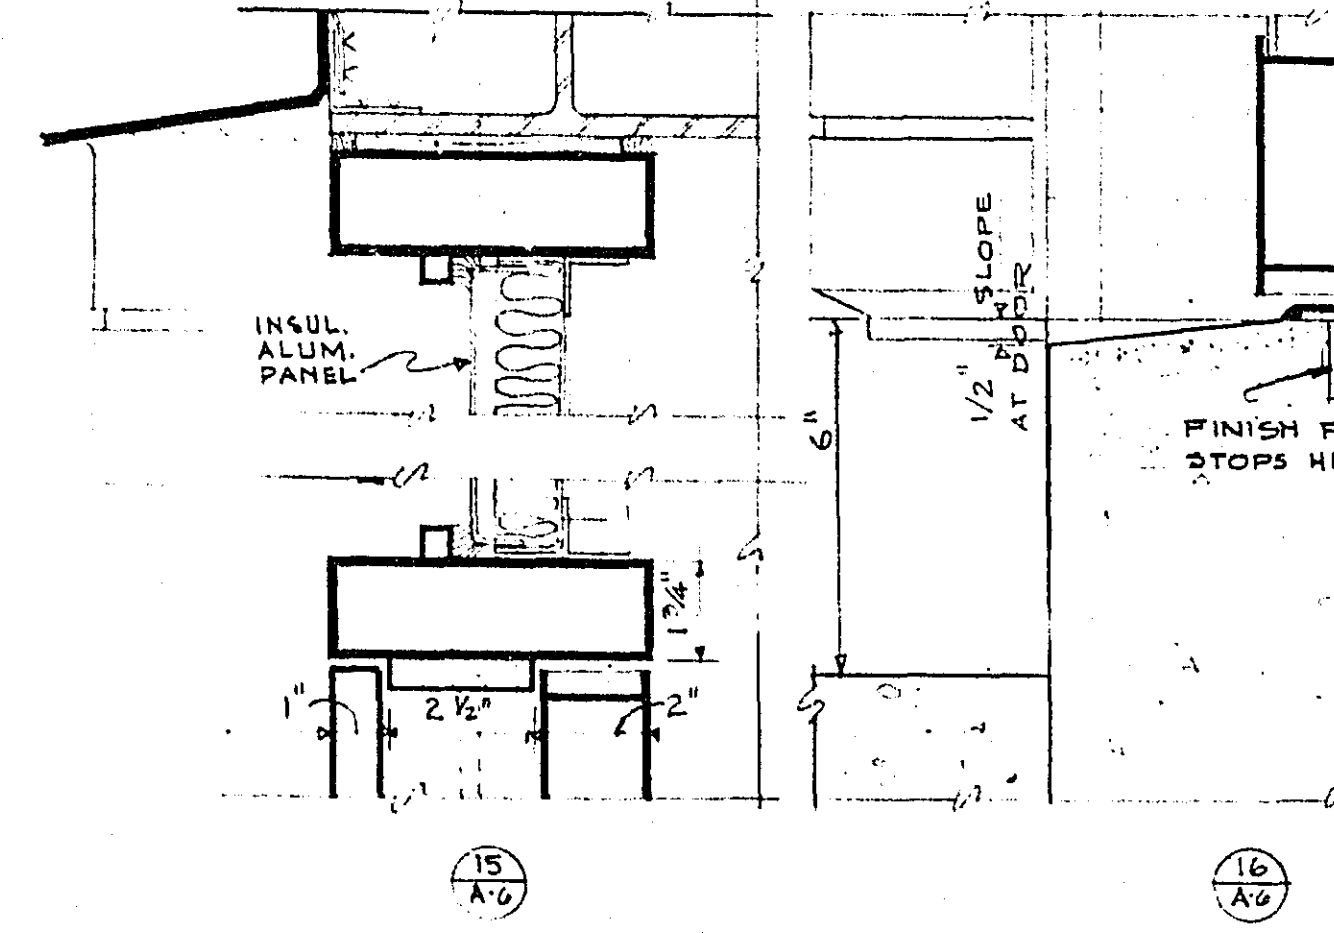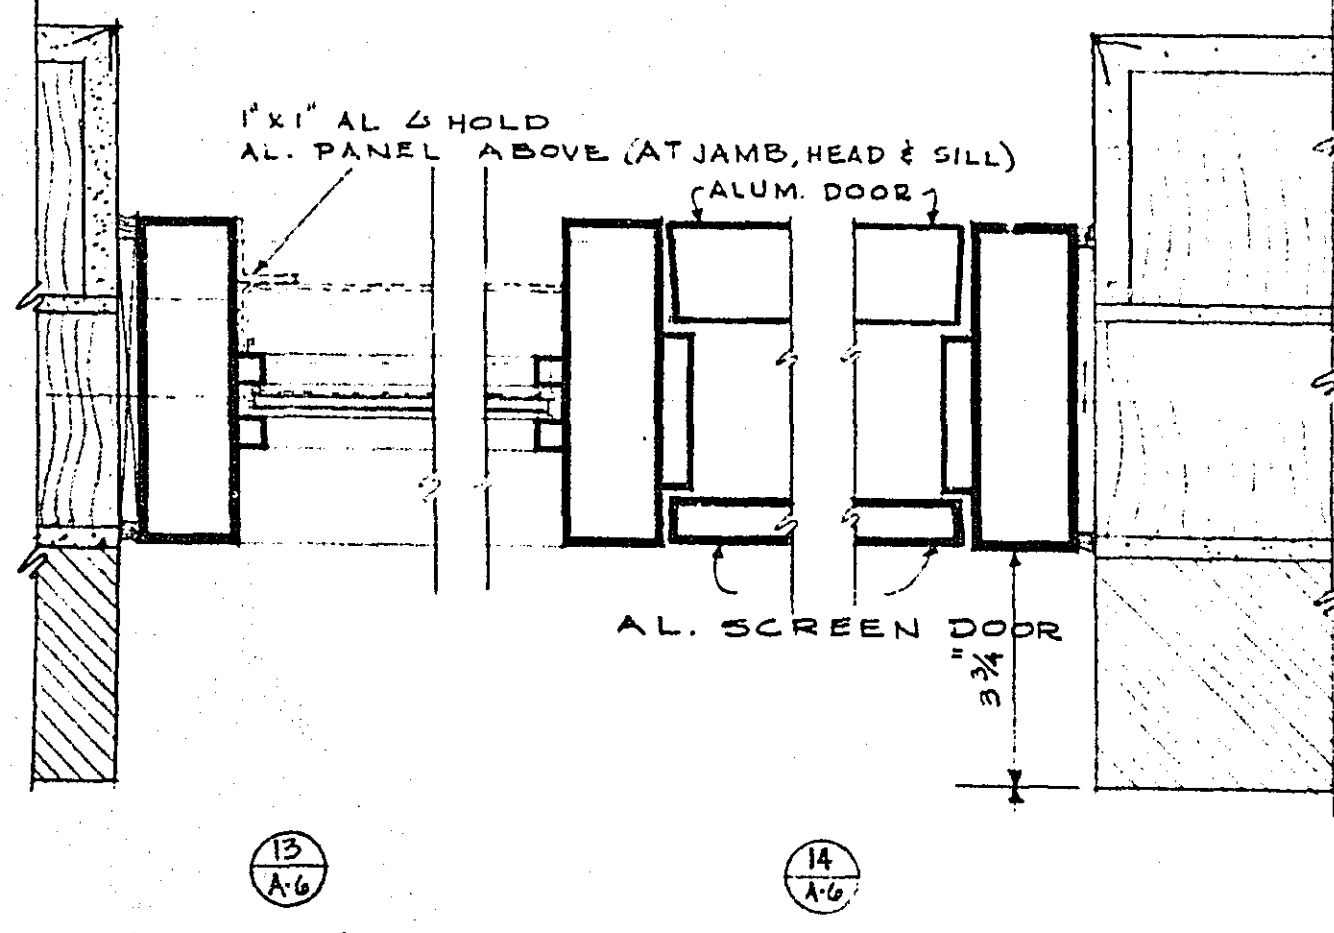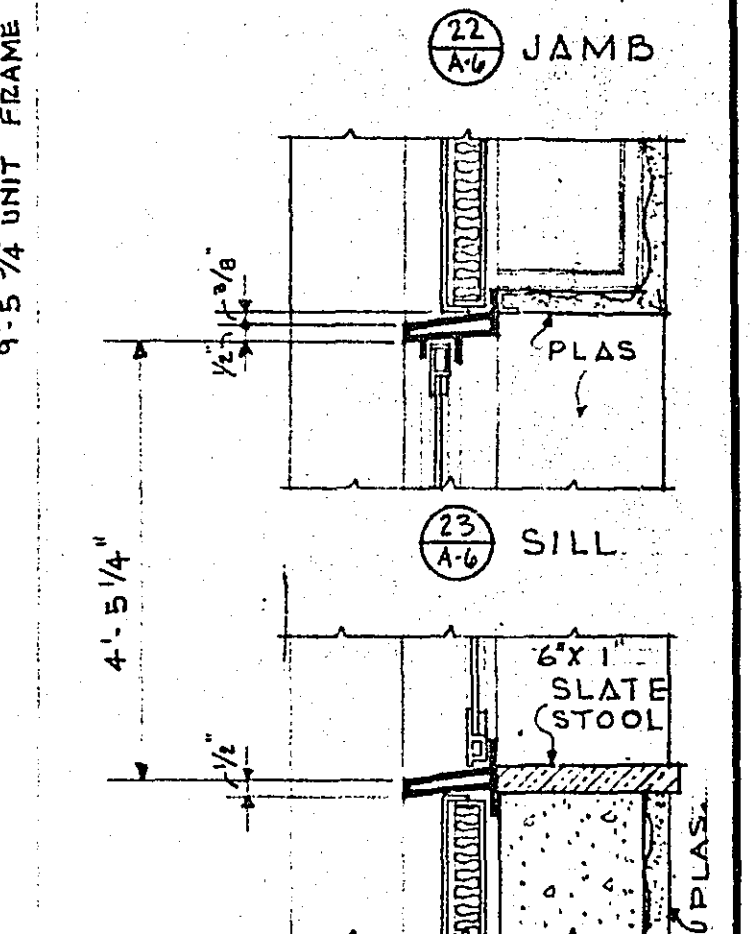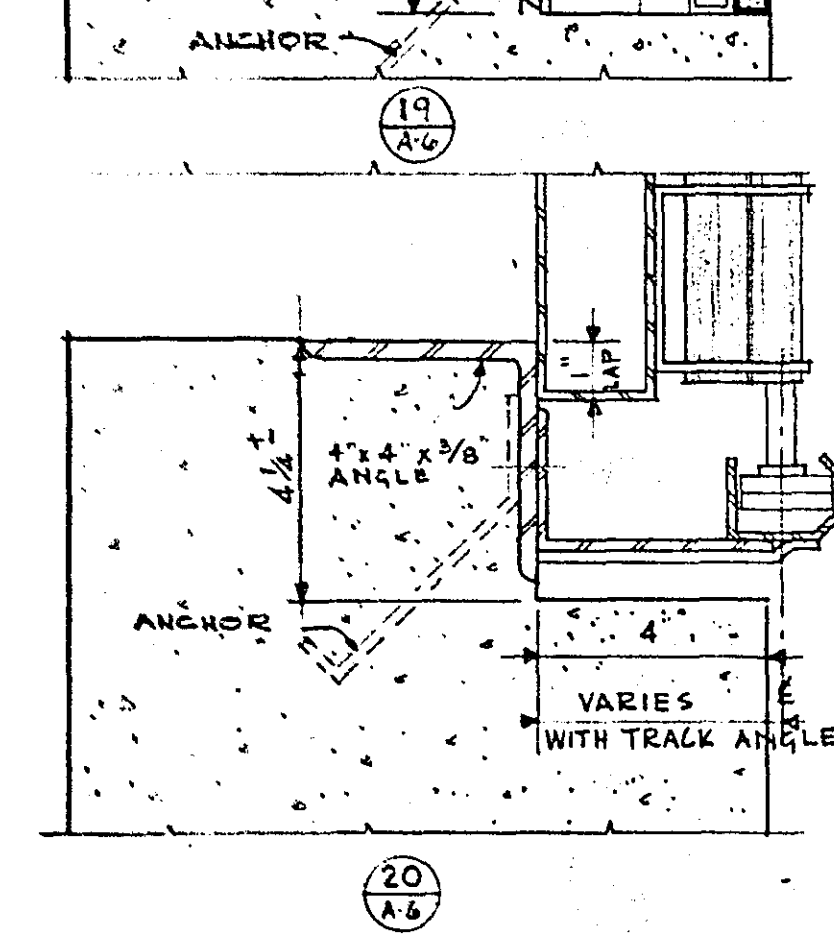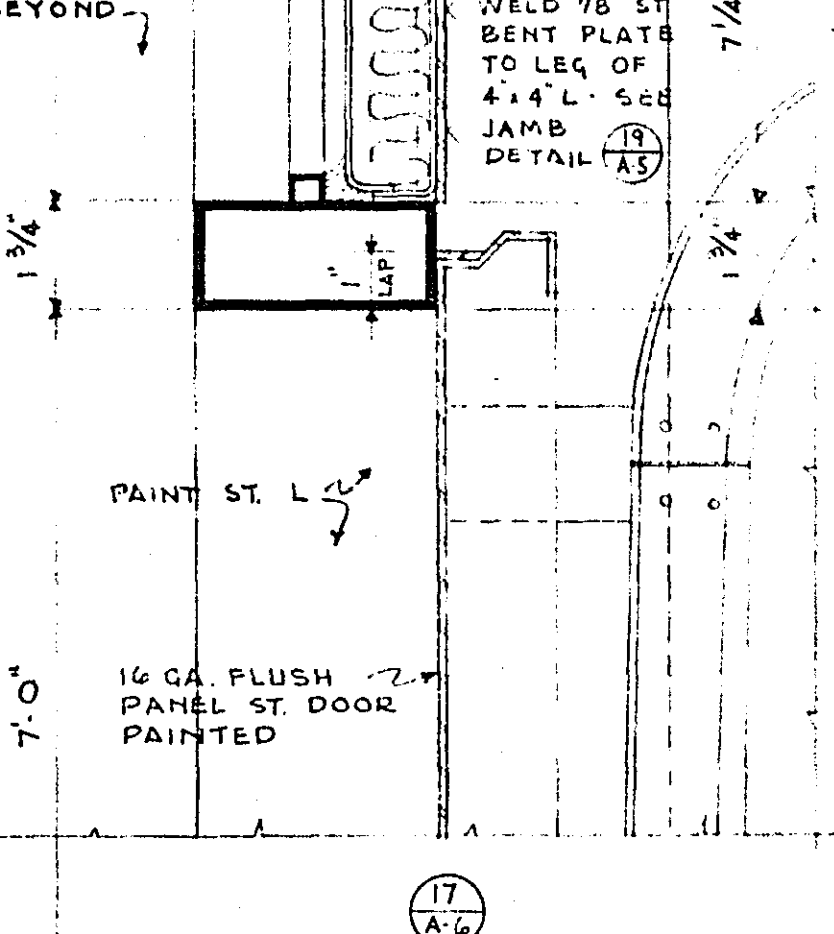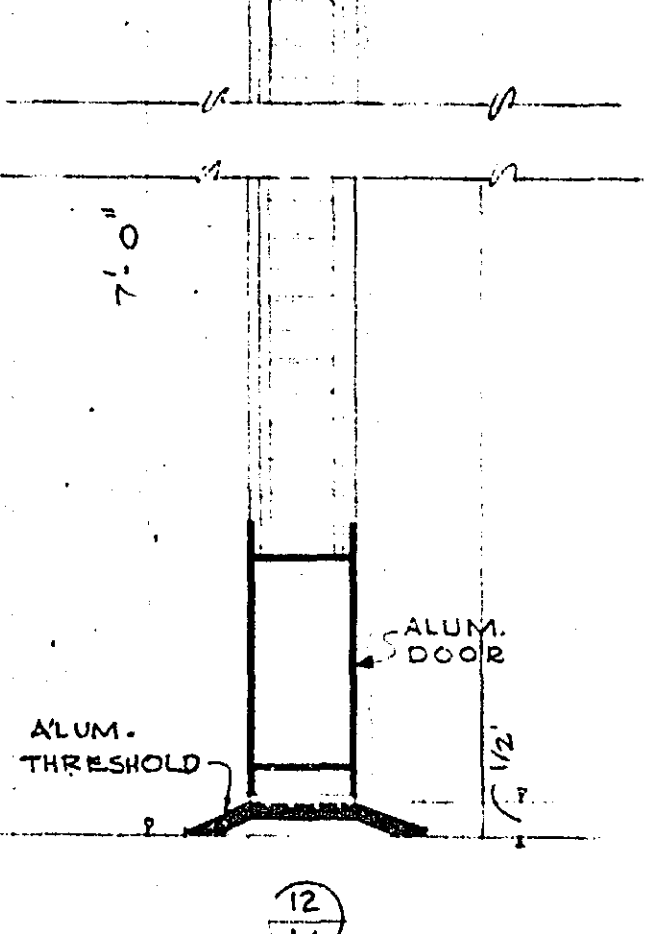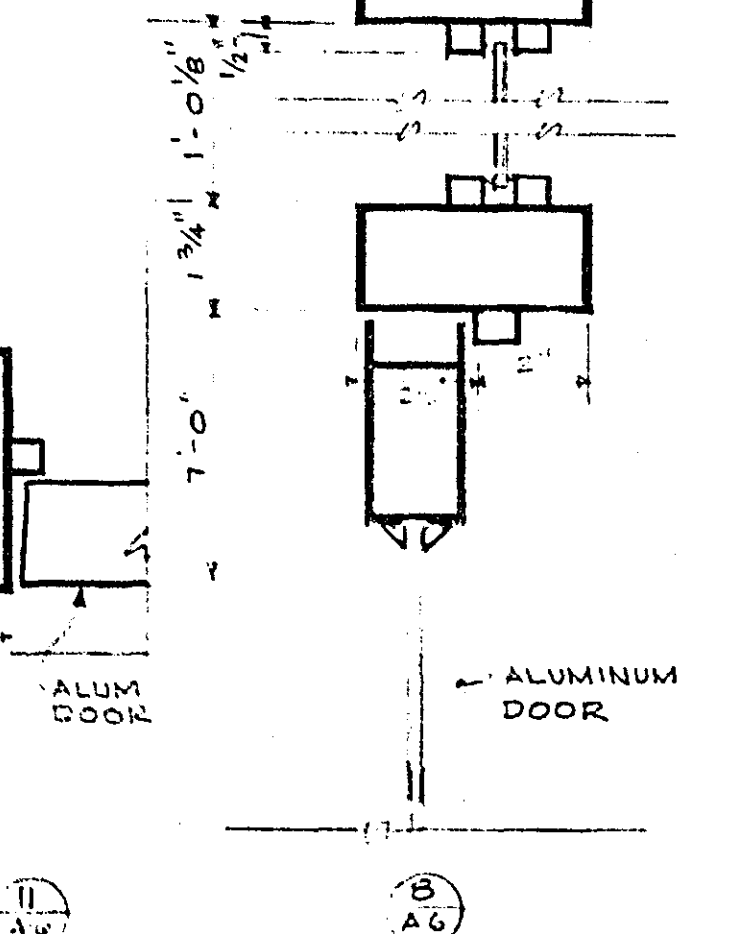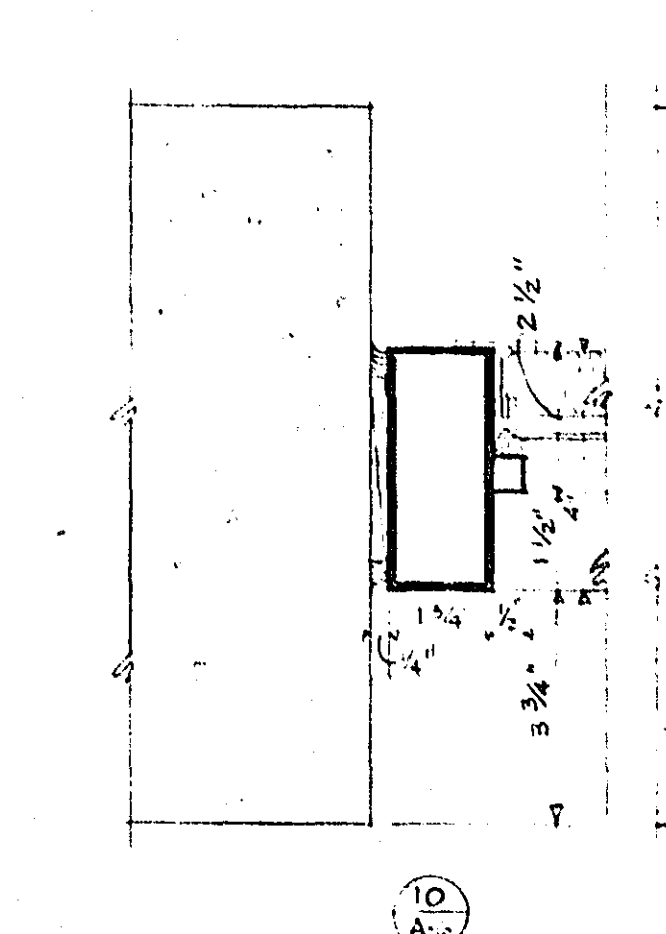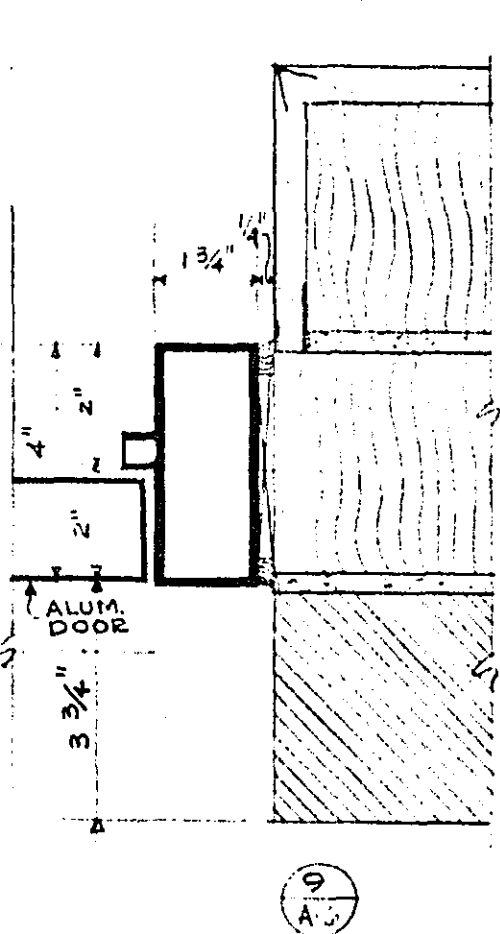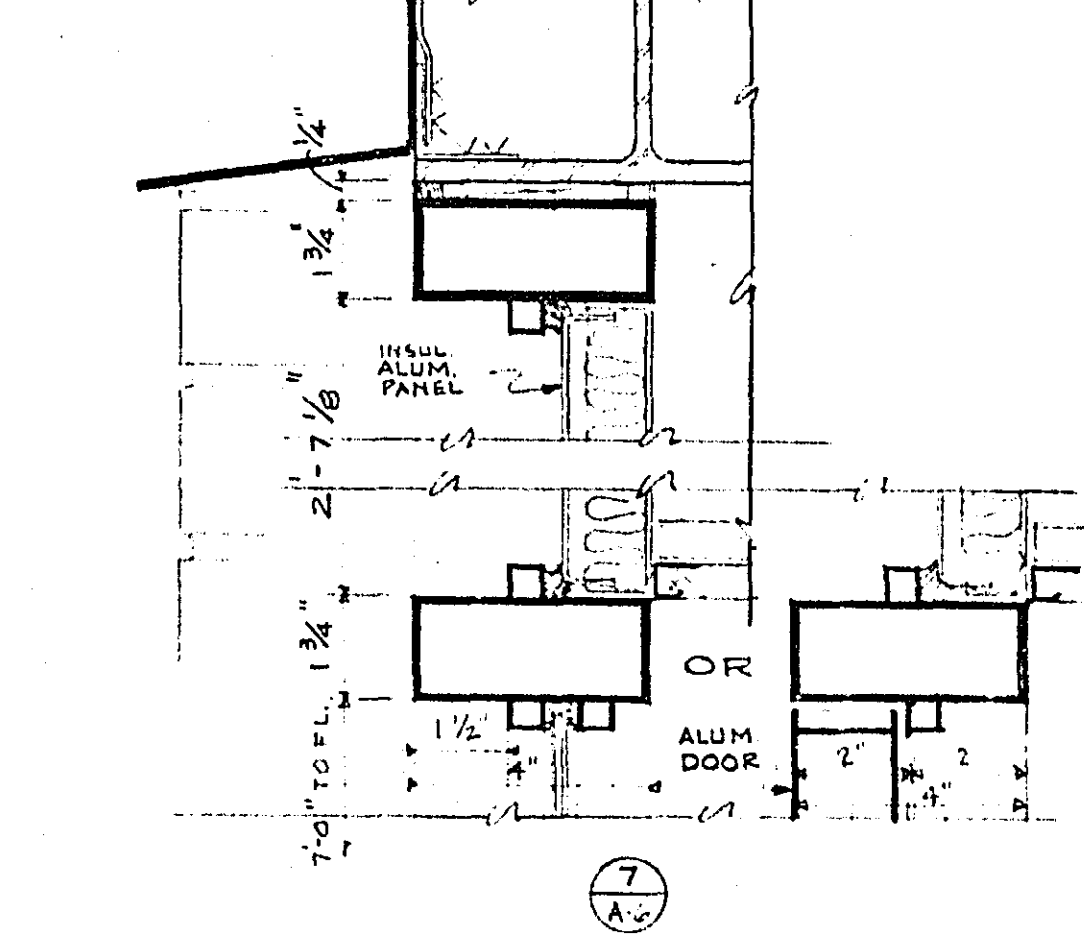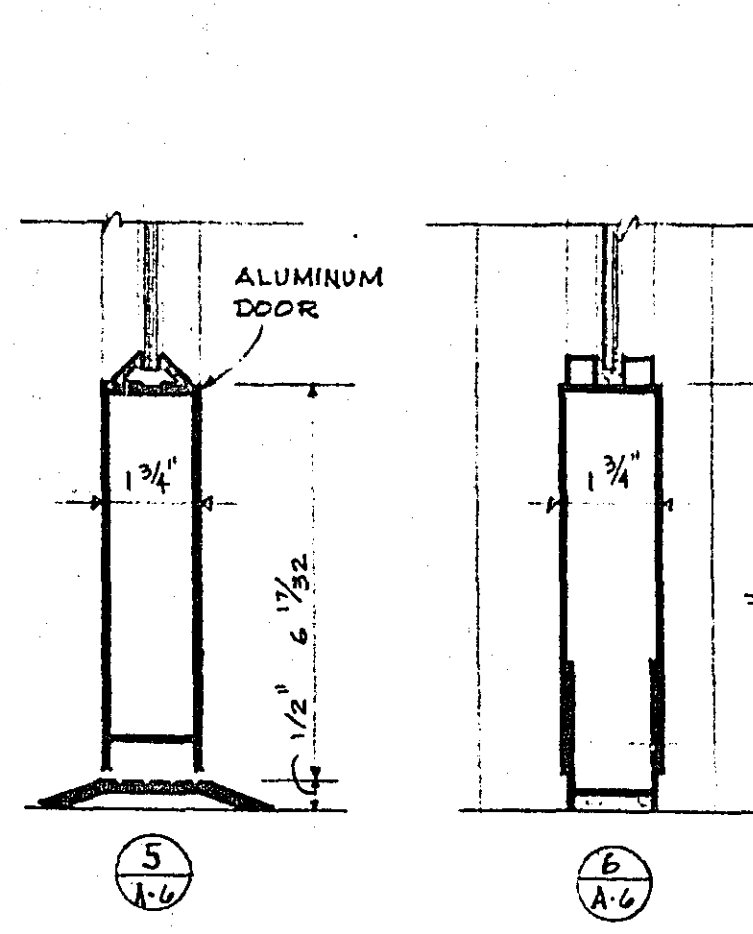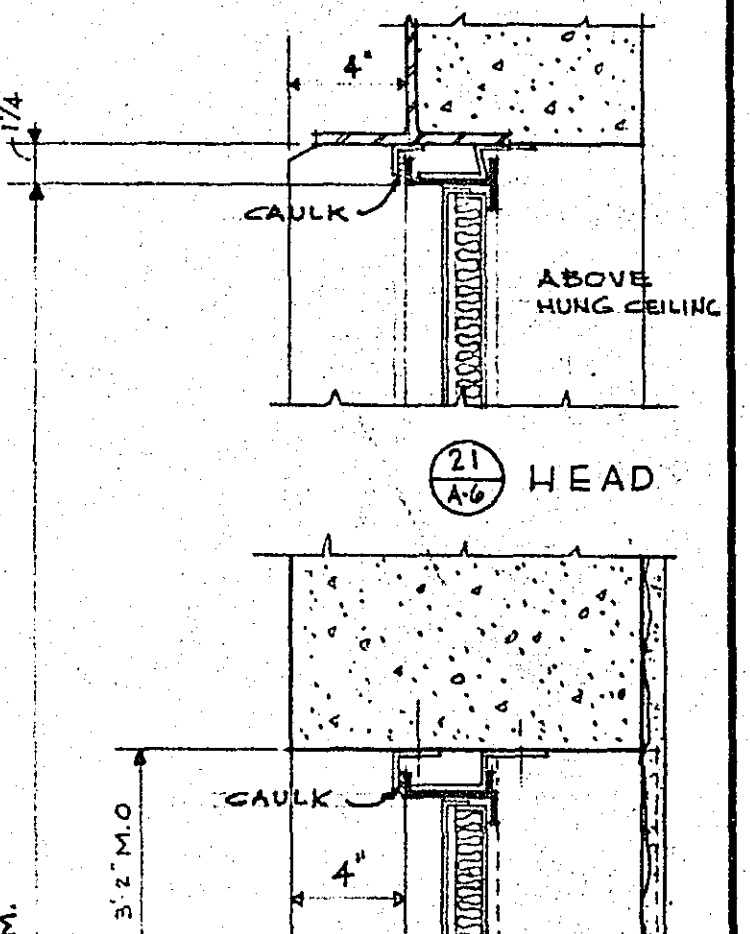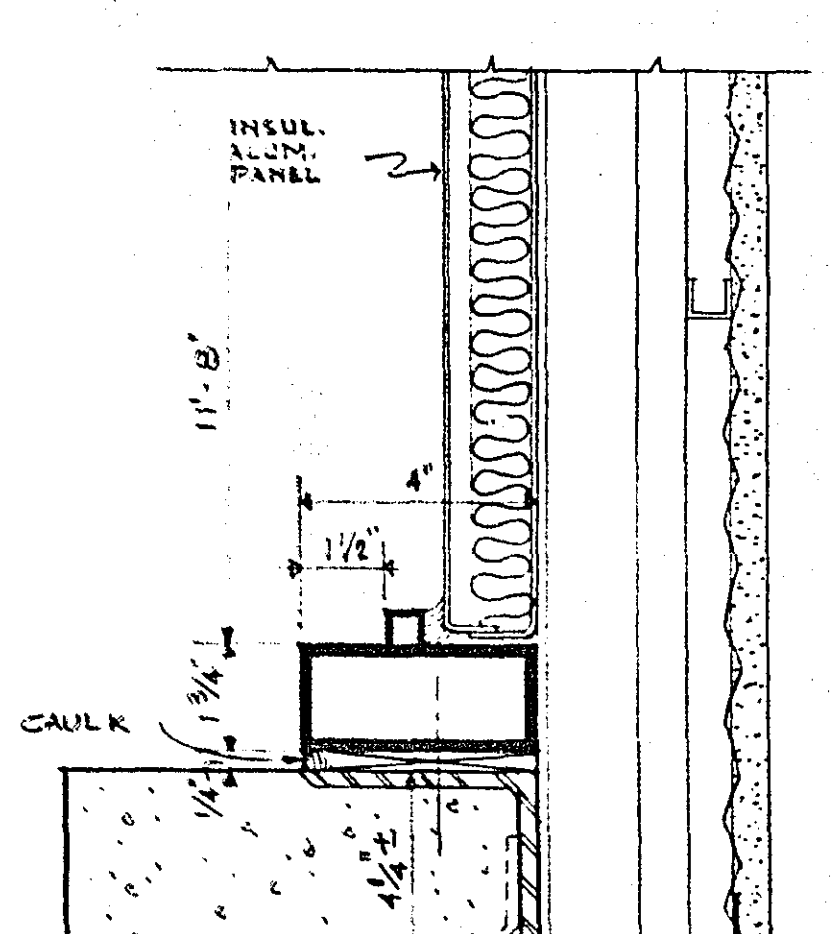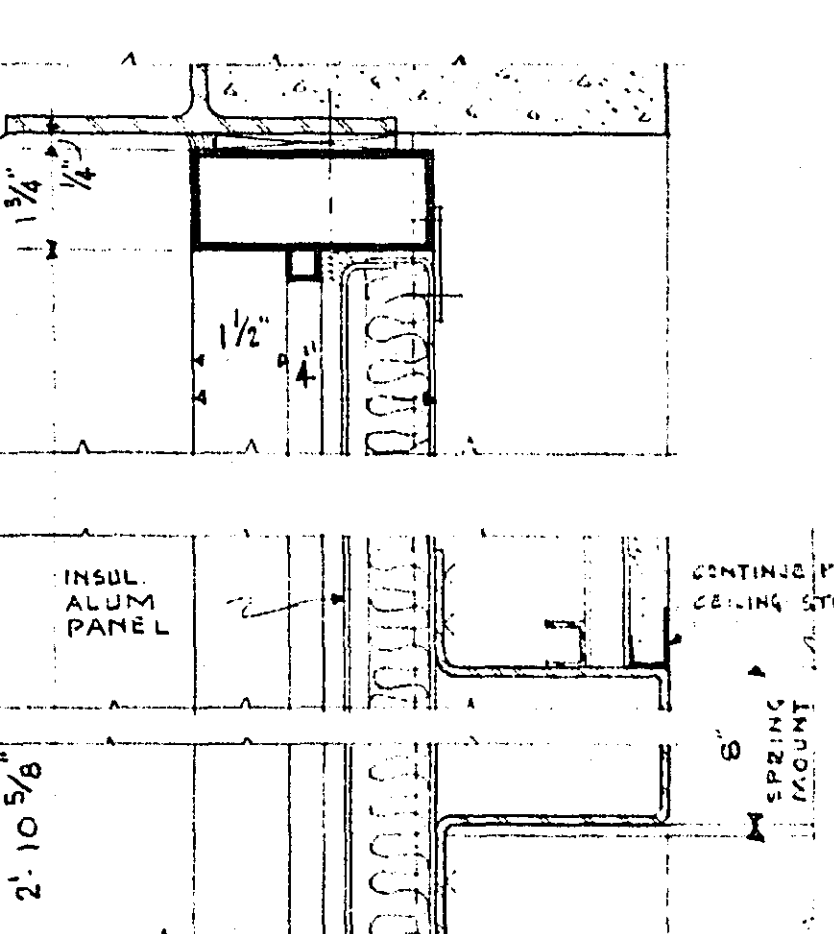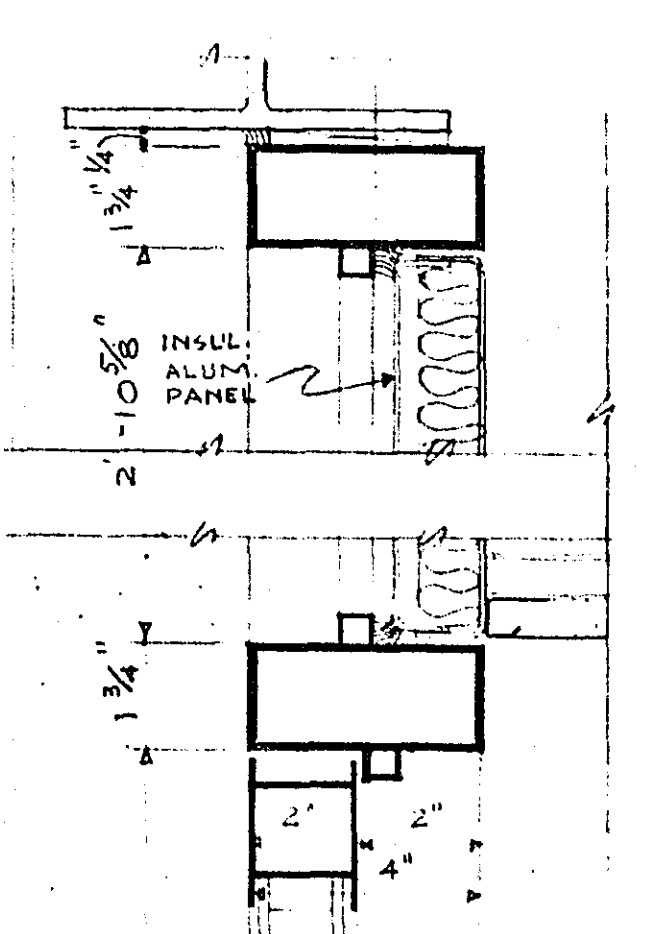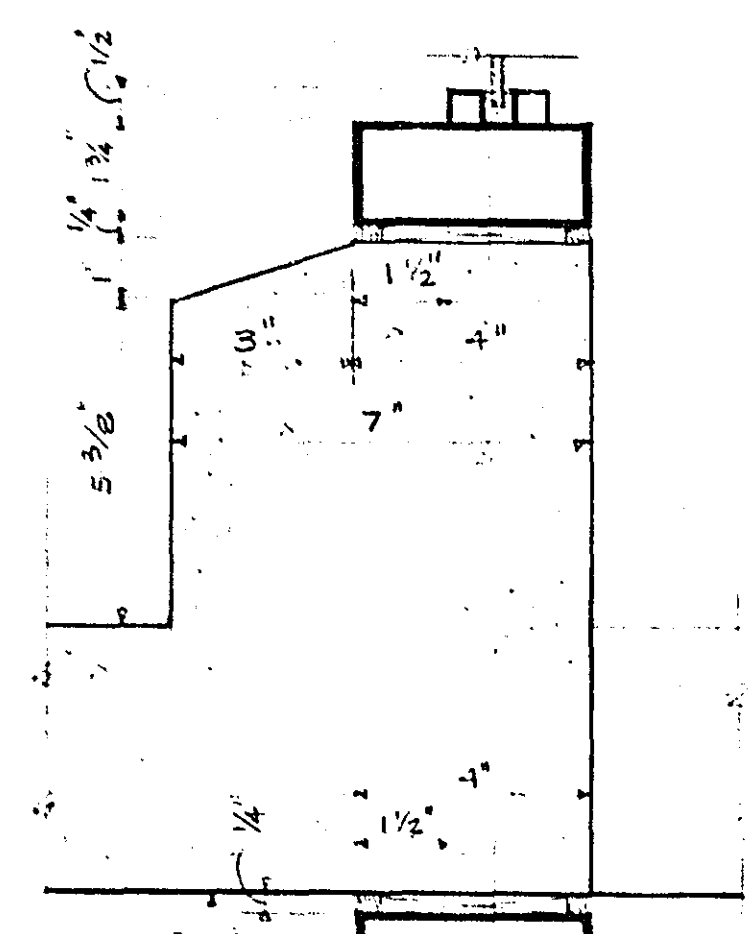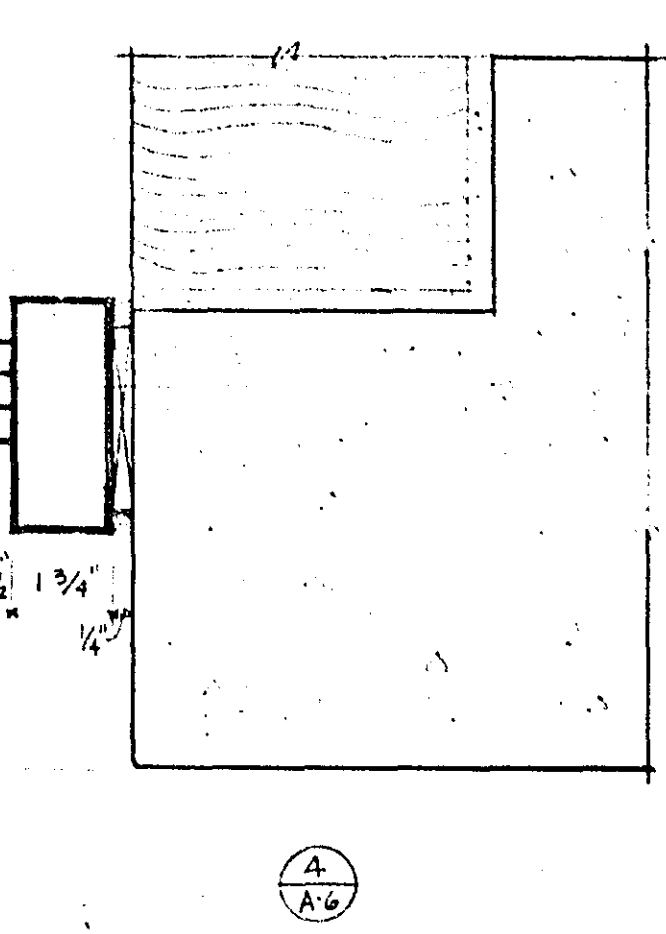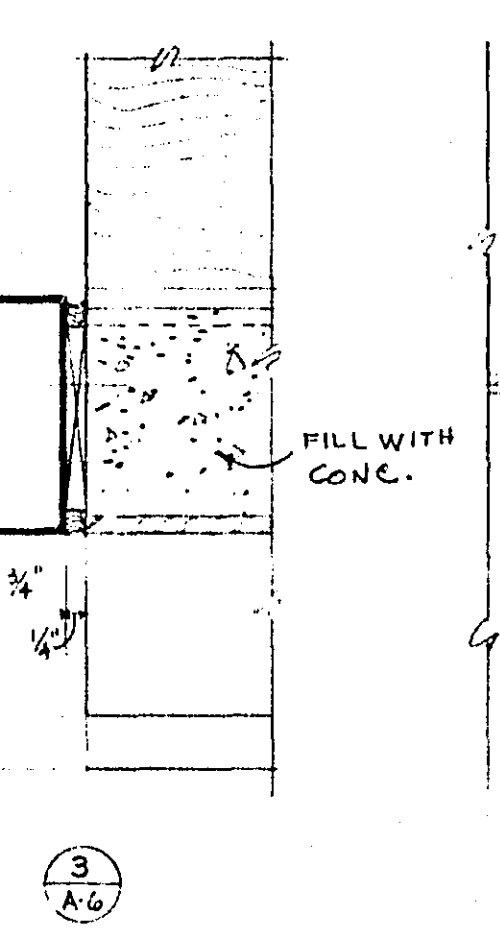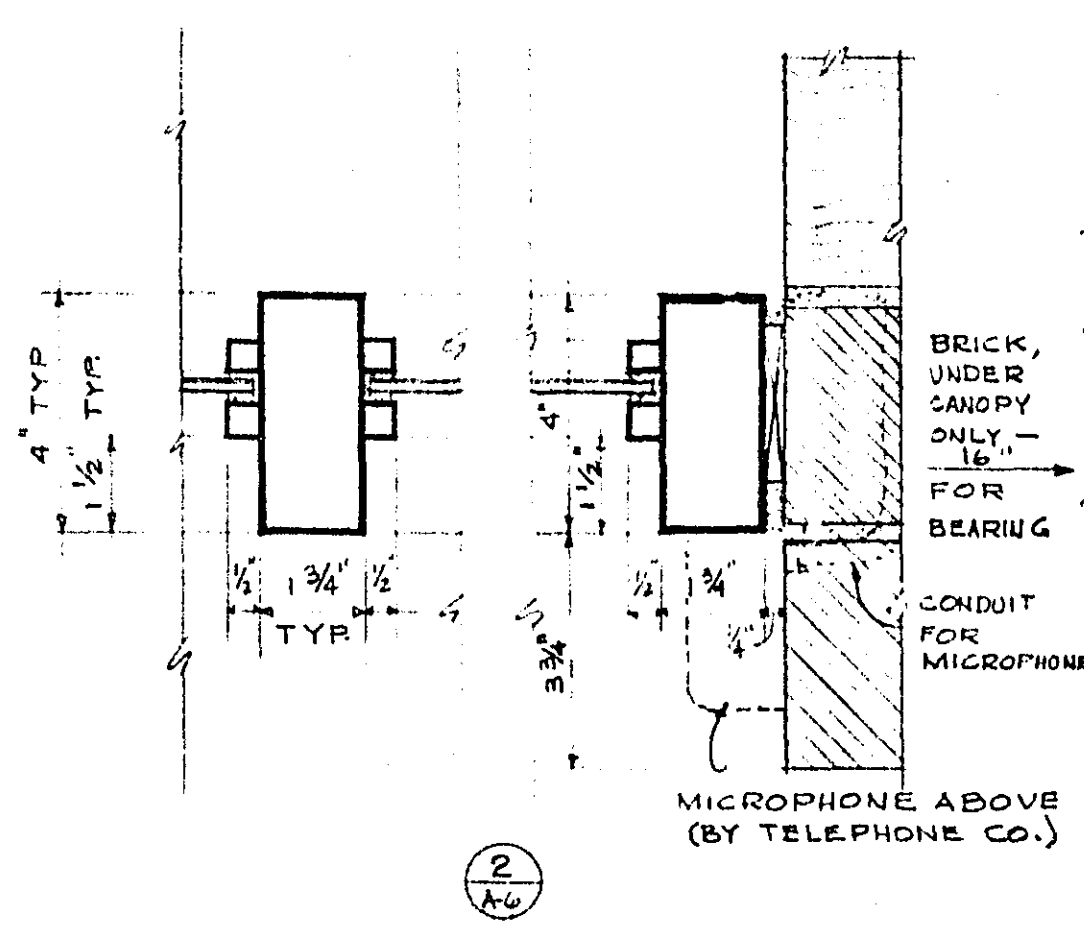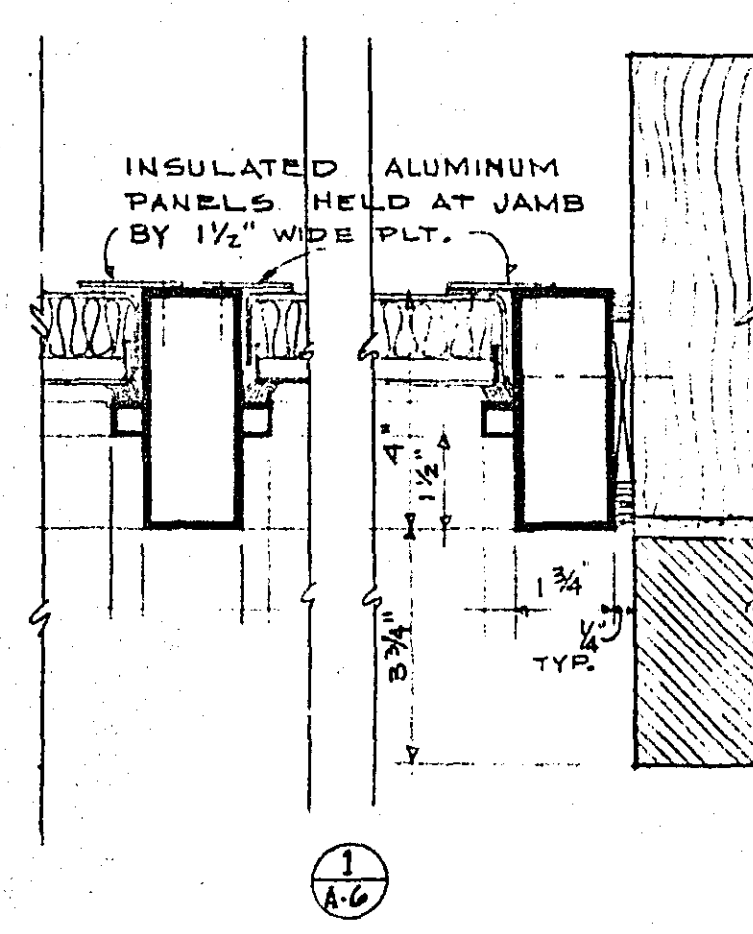

ENLARGED ELEVATION OF DOOR PANELS
SCALE: 1/2" = 1'-0"

SECTION THRU OVERHEAD DOOR
SCALE: 1/2" = 1'-0"

NOTE: ALL SECTIONS
THIS SHEET DRAWN TO
SCALE: 3/8" = 1'-0" UNLESS
OTHERWISE NOTED.


ENTRANCE & ALUMINUM
FRAME ELEV. & DETAILS

RAMSEY COUNTY CORONERS OFFICE


ST. PAUL, MINNESOTA

TOLTZ, KING, DUVALL, ANDERSON
AND ASSOCIATES, INC.
ST. PAUL, MINNESOTA
ENGINEERS AND ARCHITECTS


DESIGNED R.L.L.
DRAWN R.L.L.
CHECKED
I hereby certify that this plan was prepared by me or under my direct supervision and that I am a duly Registered ARCHITECT under the laws of the State of Minnesota.
Date OCTOBER 7, 1963 Reg. No. 685
COM. 4603 DRG. A-6

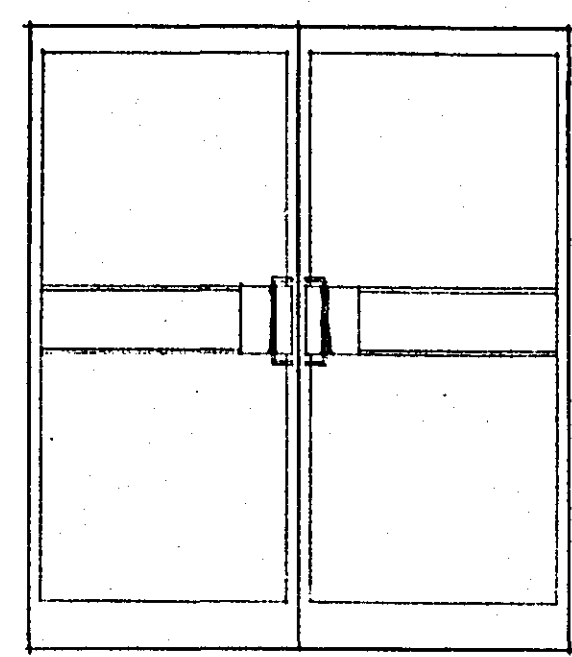


A ALUMINUM

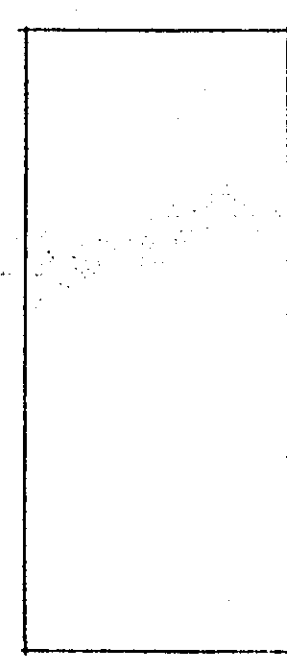


B FLUSH PANEL ALUMINUM
B FLUSH H.M. LABEL

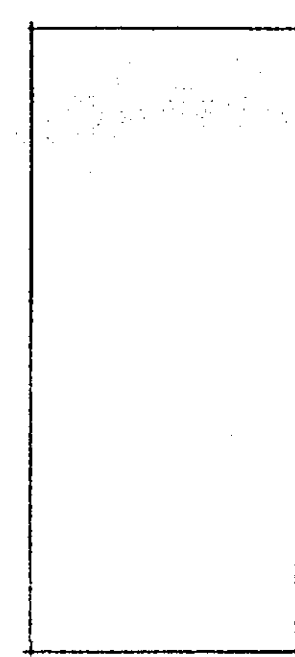


C AL. SCREEN

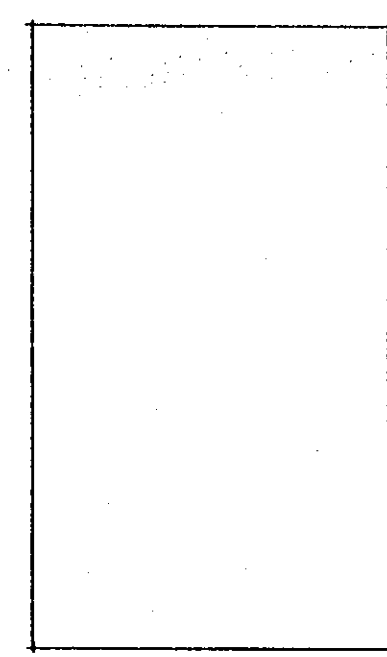


D 4'-0" FLUSH H.M.

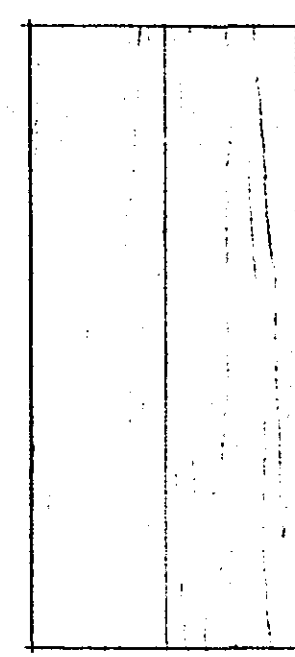


E 3'-0" FLUSH WOOD BI-FOLD

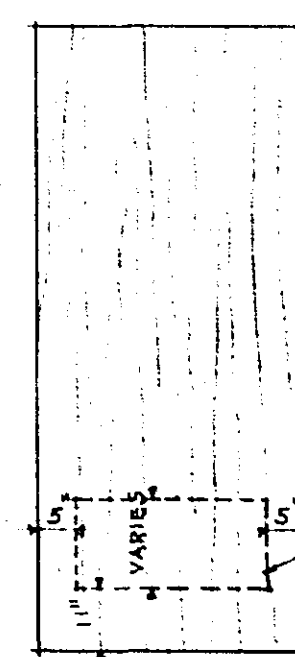

F FLUSH WOOD

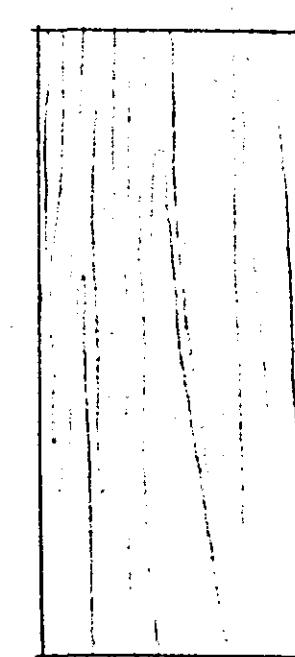


G FLUSH WOOD LEAD LINED

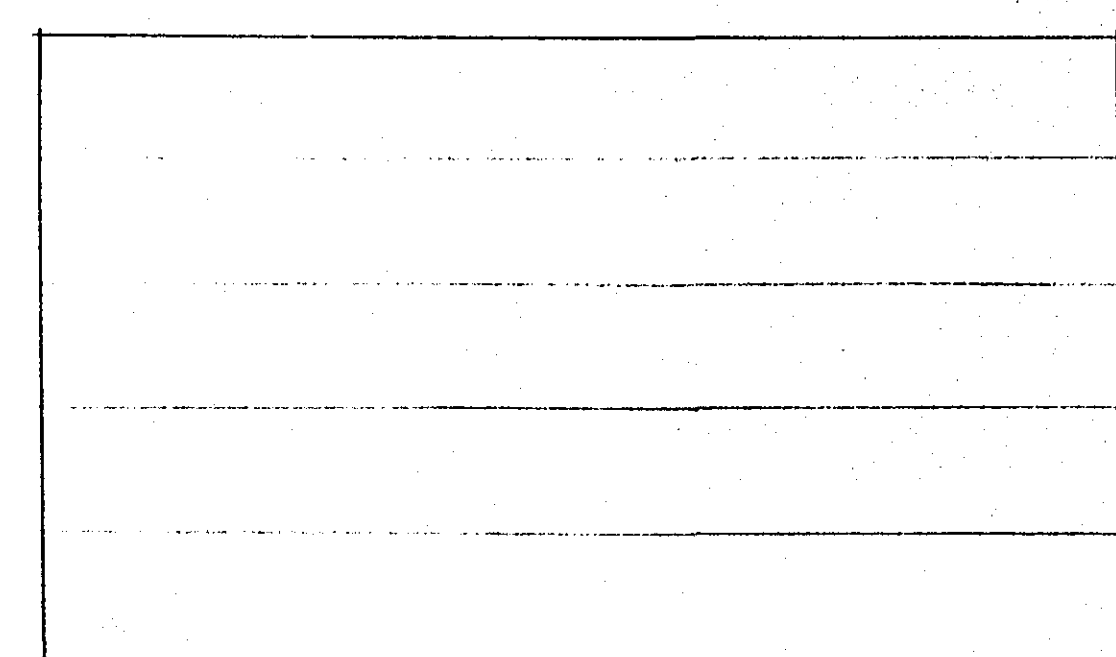


H STEEL FLUSH PANEL OVERHEAD


DOOR TYPES
SCALE: 3/8" = 1'-0"

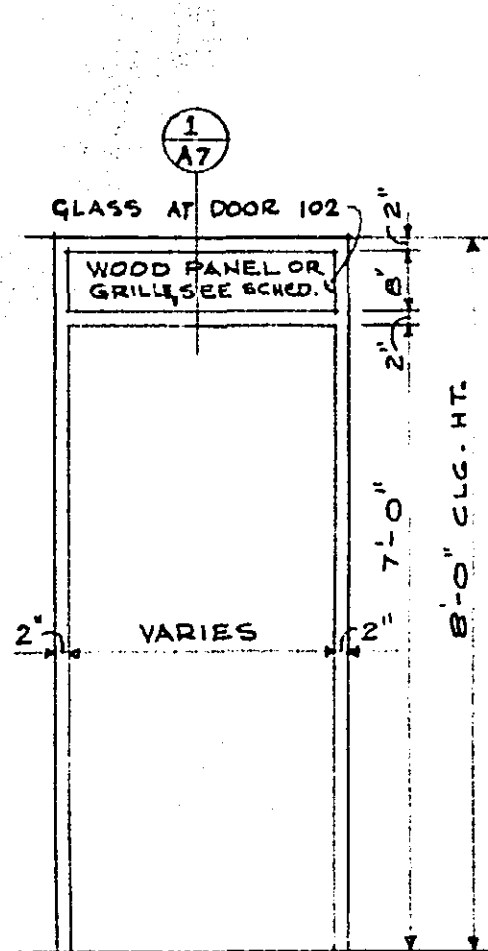


F1

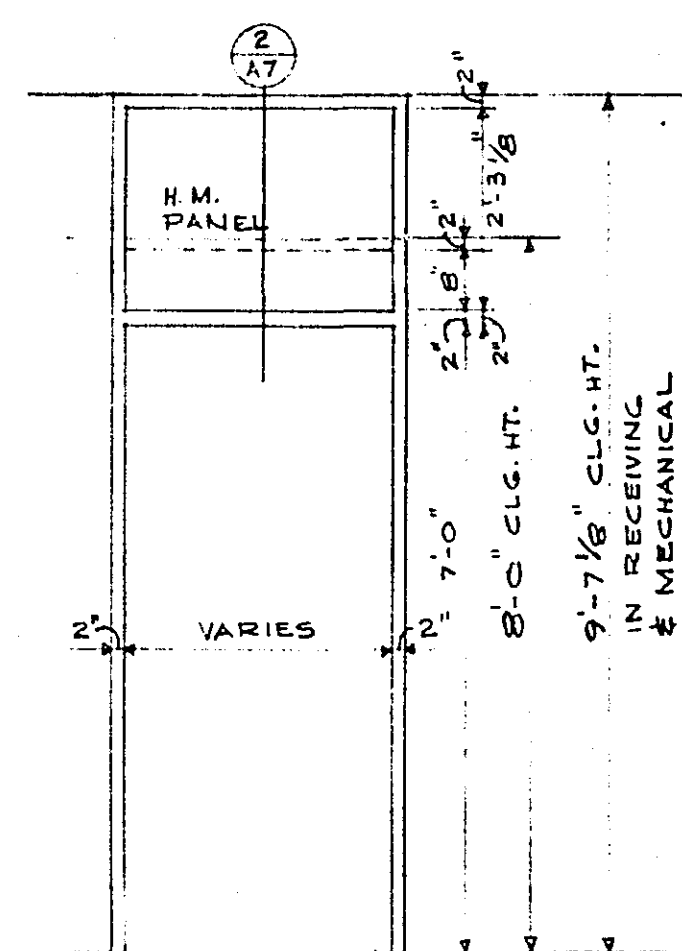


F2

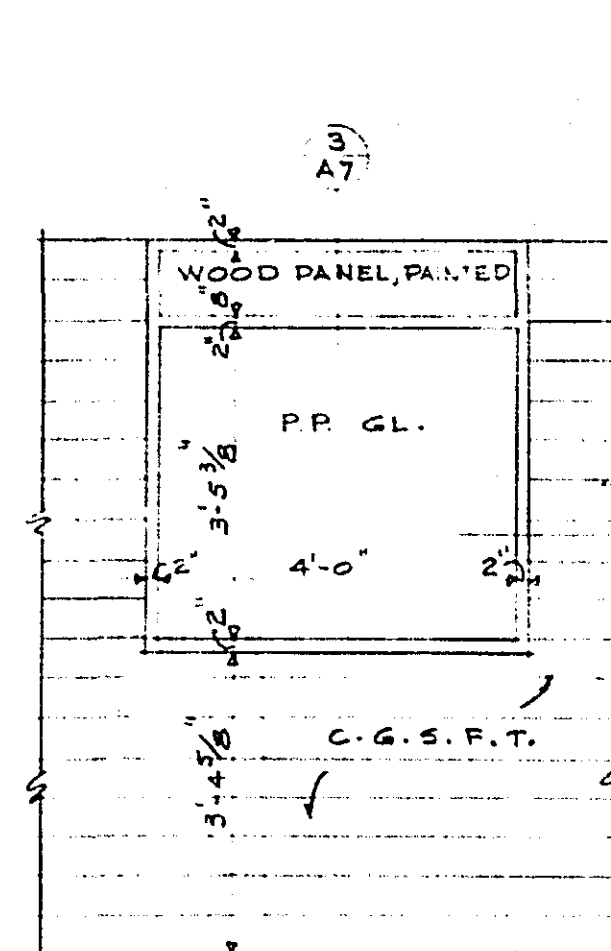


VIEWING WINDOW IN CORRIDOR G-11

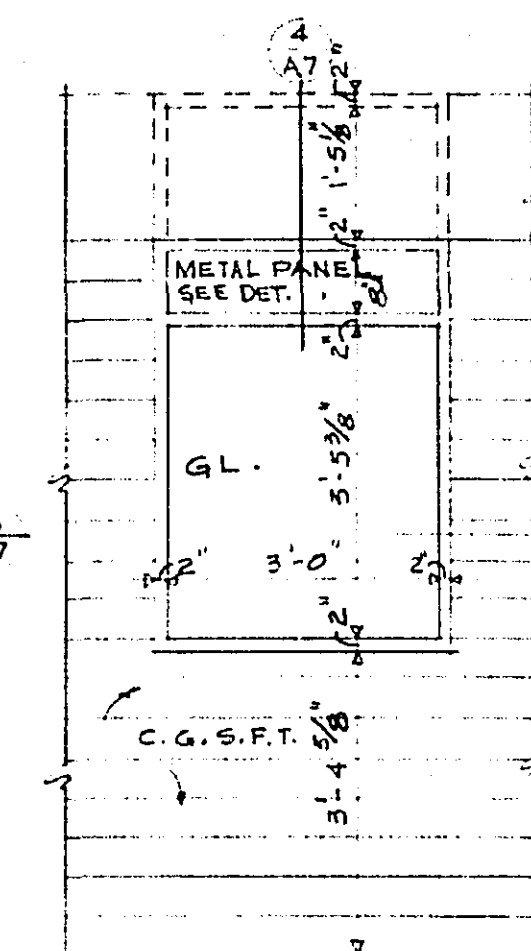


BORROWED LIGHT UNIT IN RM. G-15

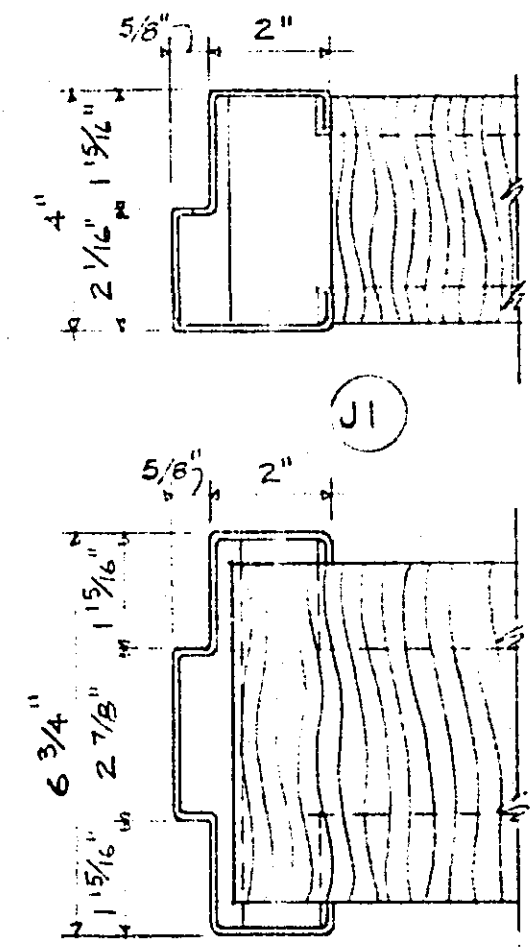

J3

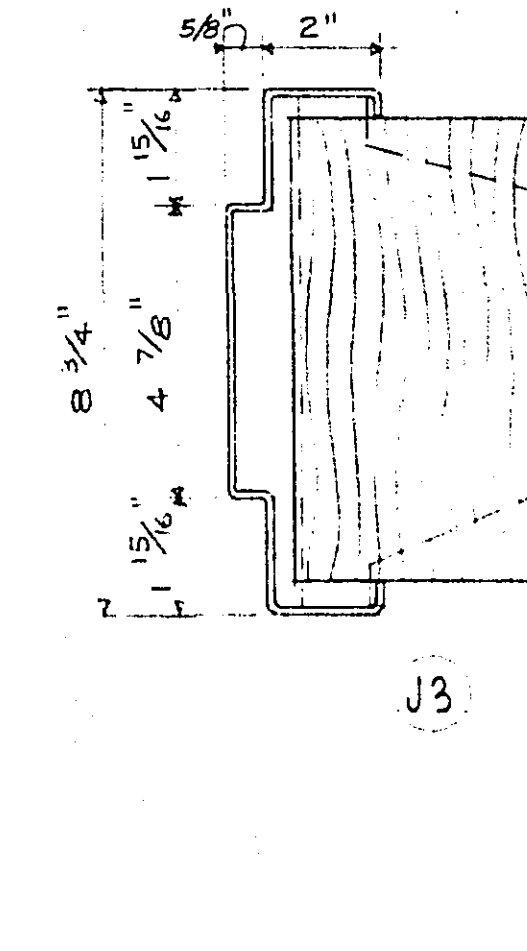

J4

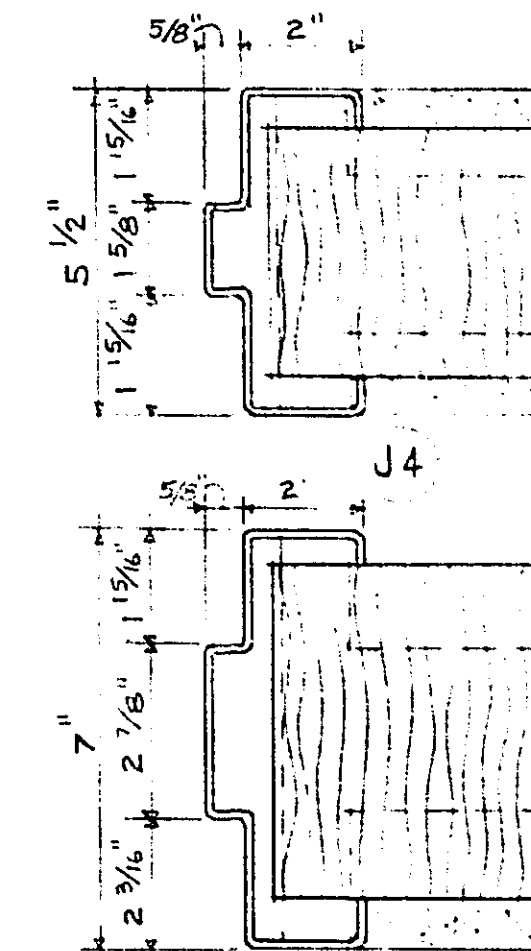


J5


FRAME ELEVATIONS
SCALE: 3/8" = 1'-0"

BORROWED LIGHT ELEVATIONS
SCALE: 3/8" = 1'-0"


DOOR FRAME TYPES
SCALE: 3/8" = 1'-0"

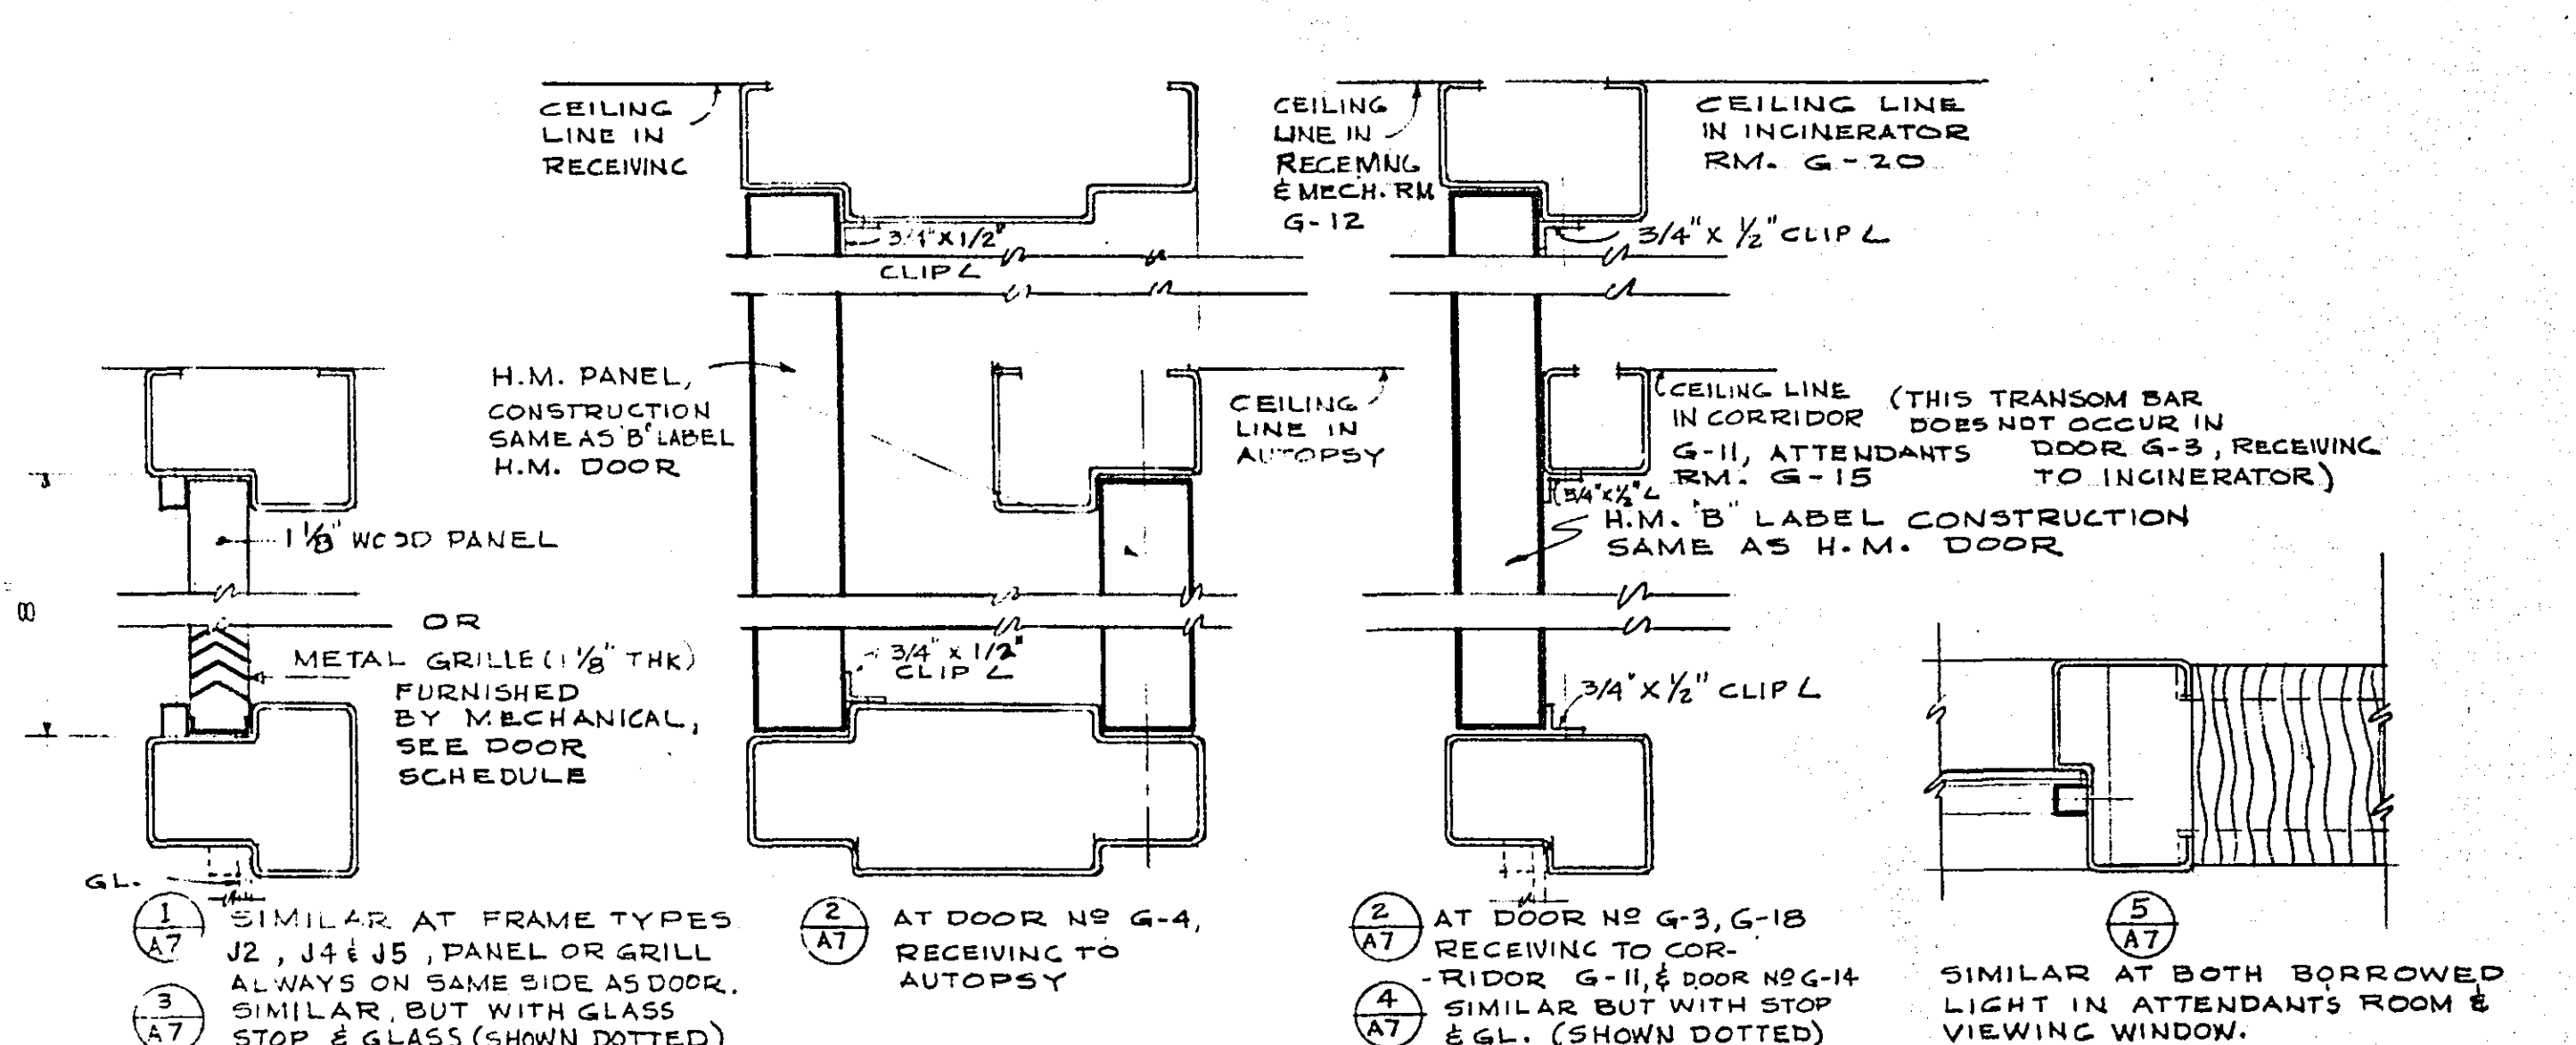


DETAIL SECTIONS
SCALE: 3/8" = 1'-0"

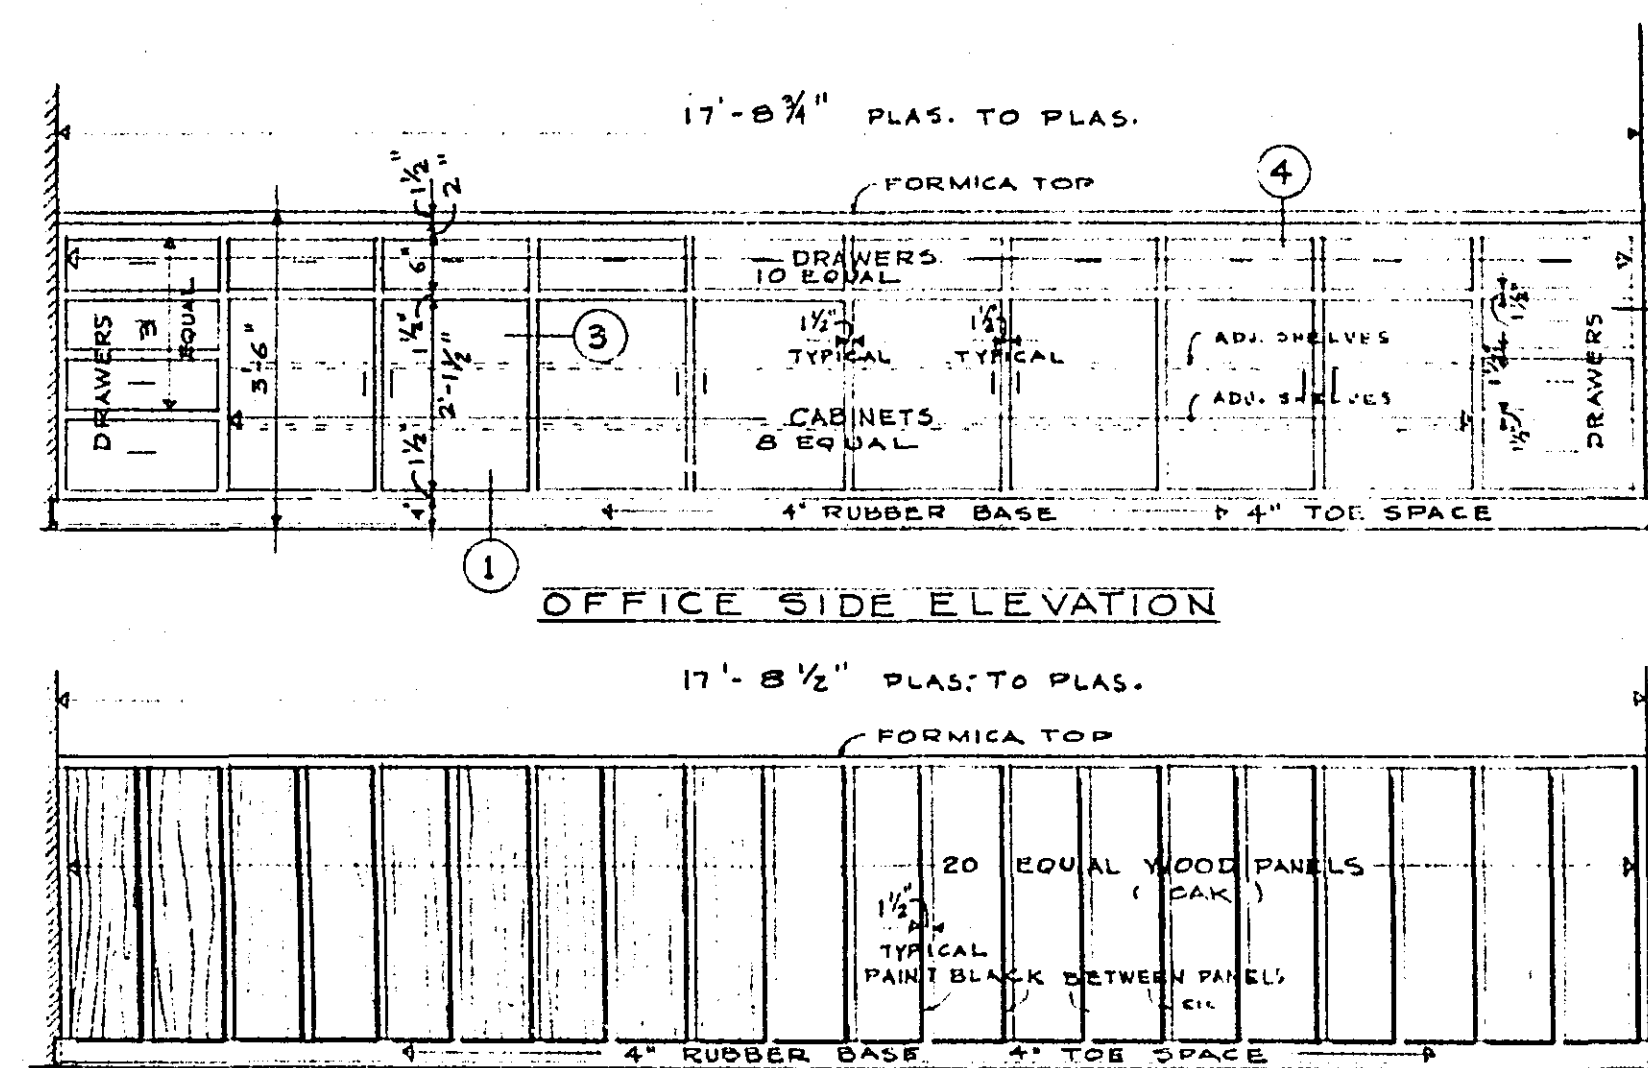



OFFICE SIDE ELEVATION
WAITING AREA SIDE ELEVATION
MAIN OFFICE (RM. 103) COUNTER
SCALE: 3/8" = 1'-0"

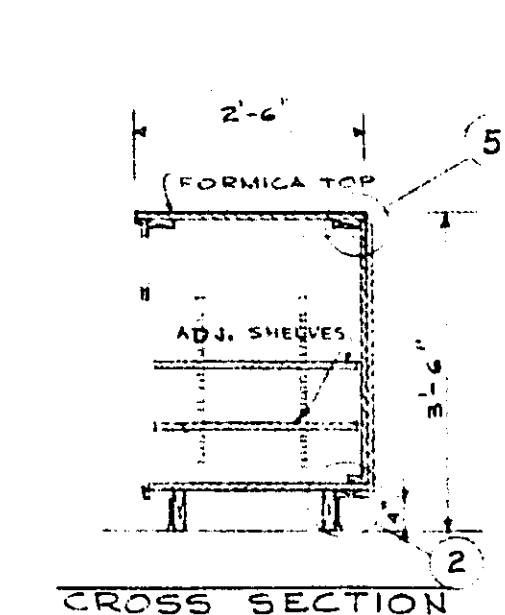


CROSS SECTION

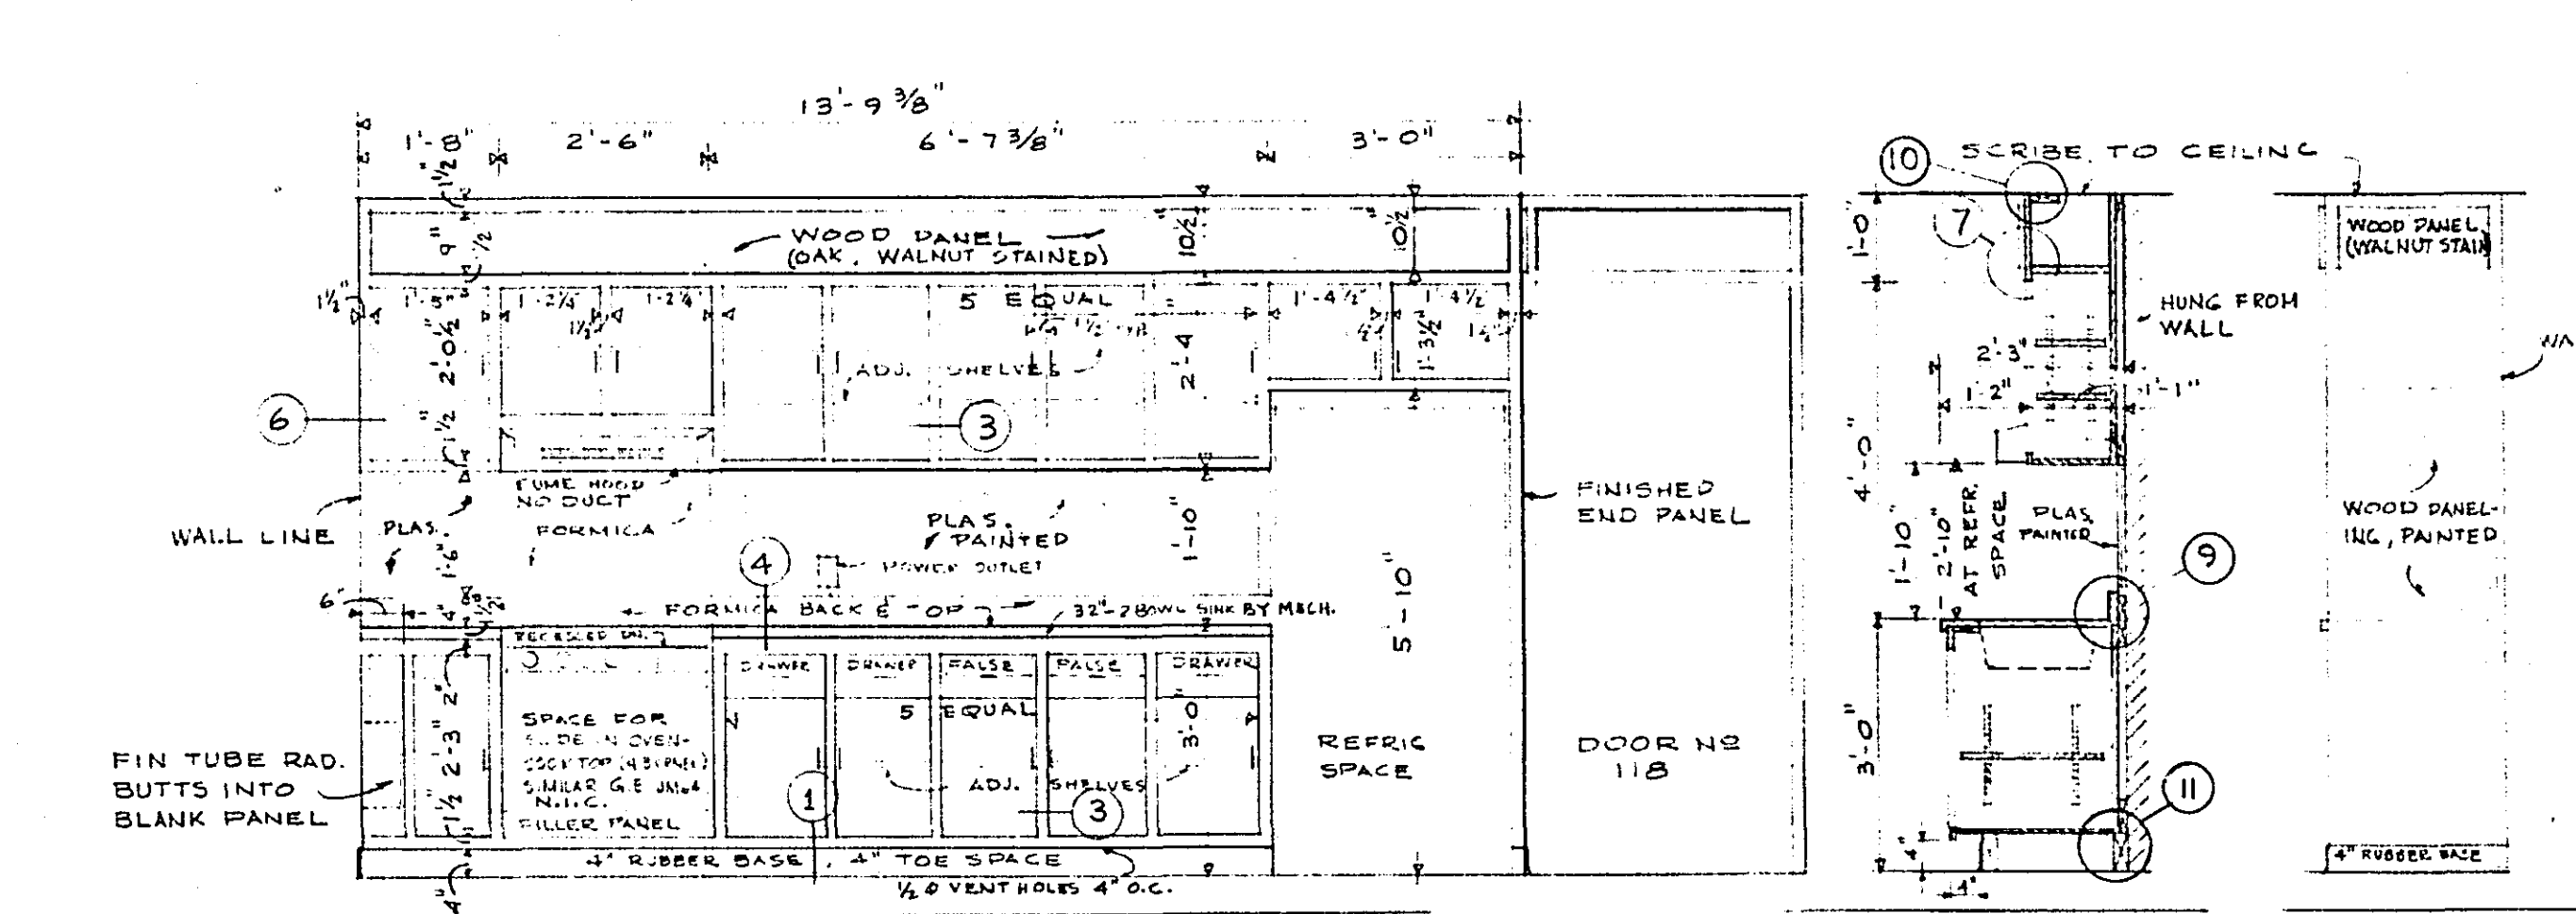


KITCHEN CABINETS FRONT ELEVATION
TYPICAL SECTION
END ELEVATION

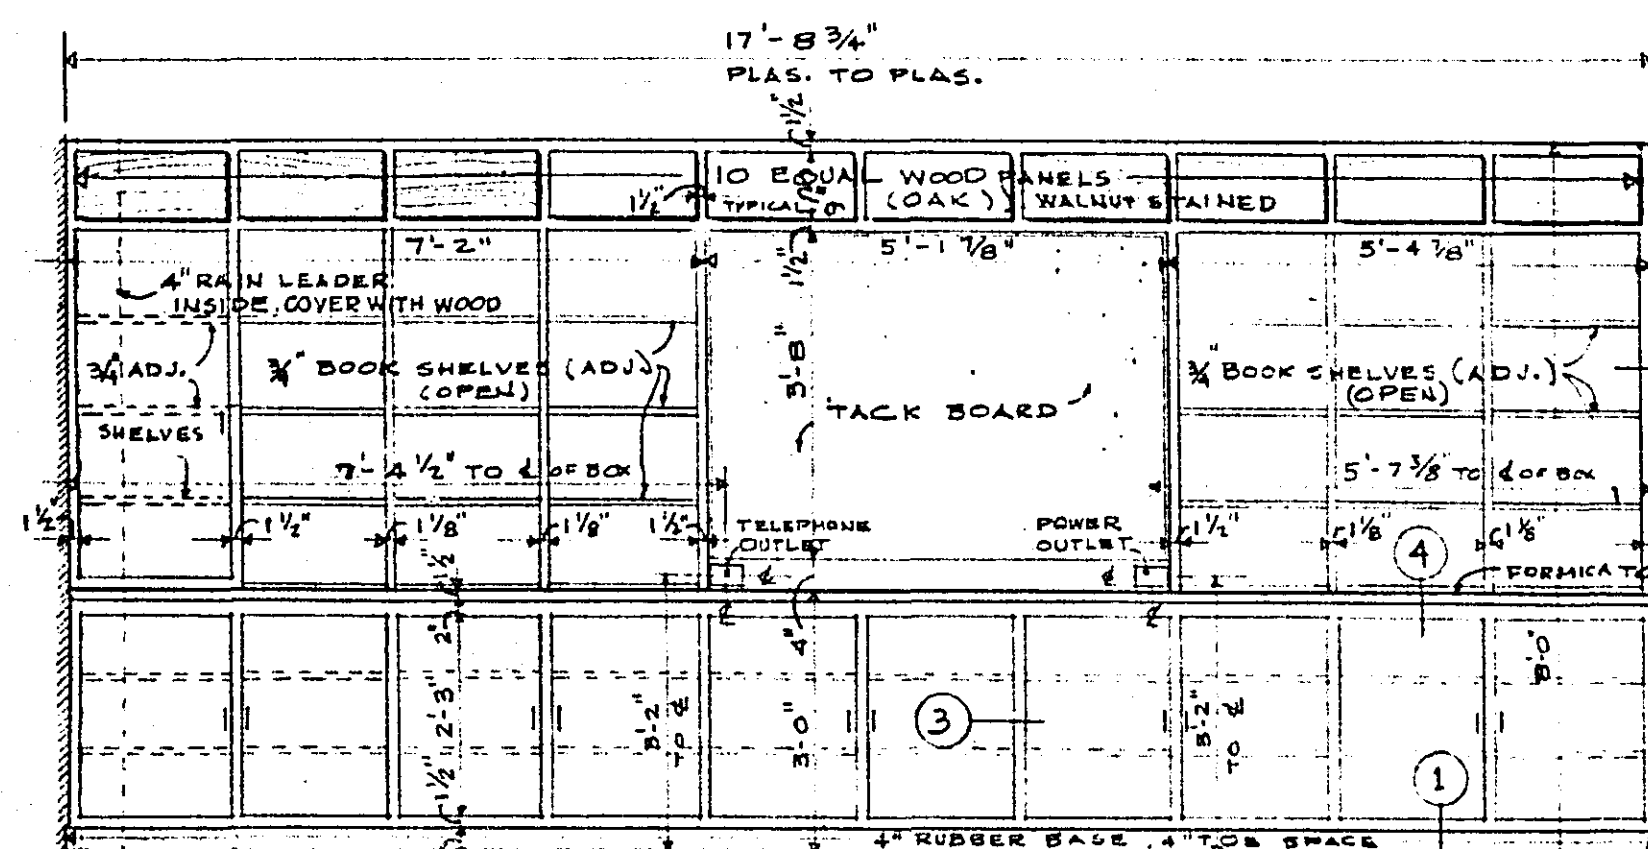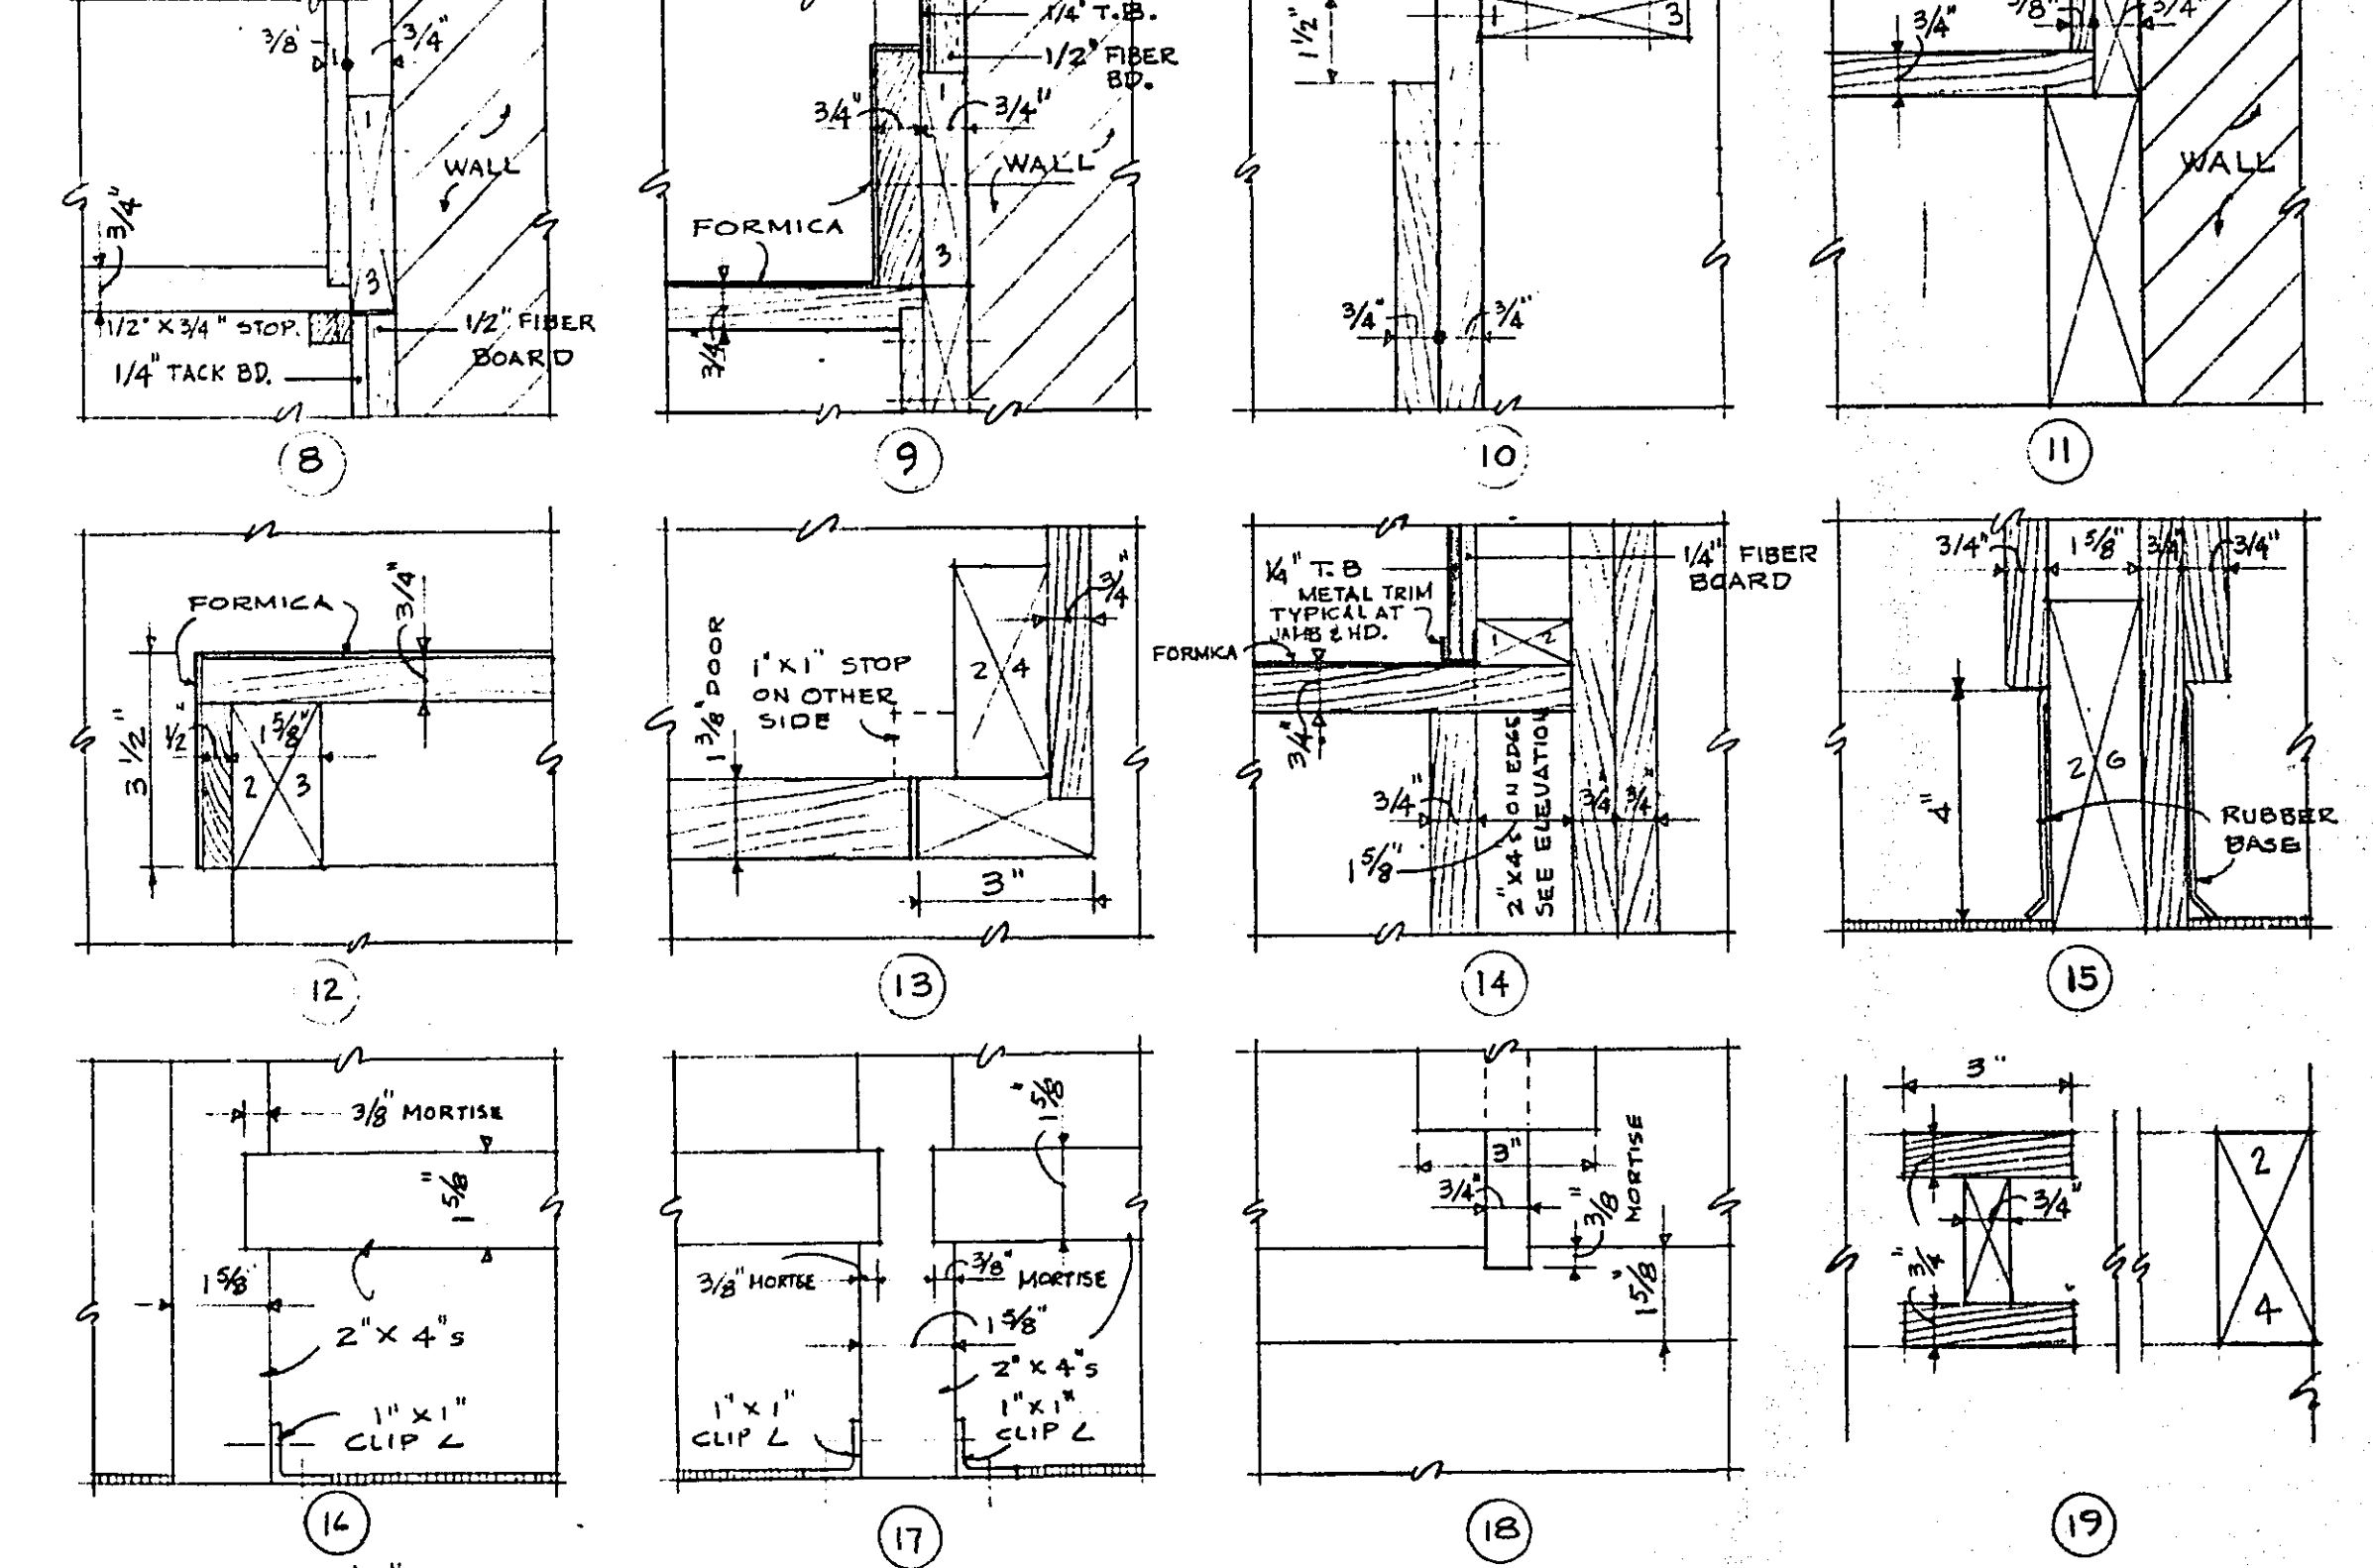


CONFERENCE ROOM CABINET
SCALE: 3/8" = 1'-0"

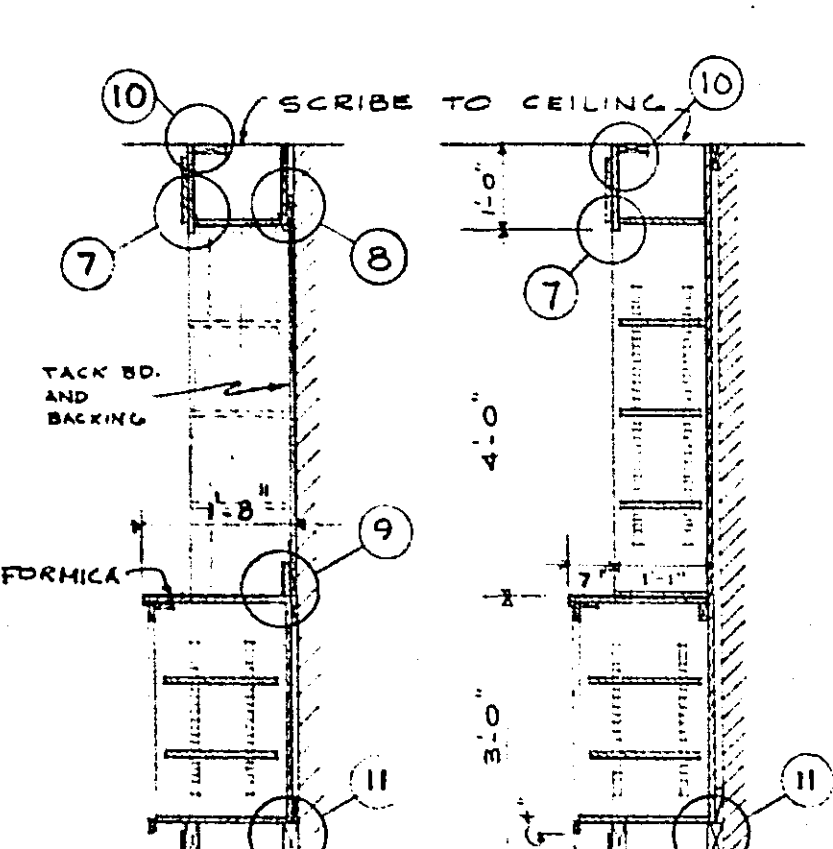

THRU TACK BD. - THRU BOOK CASE
SCALE: 3/8" = 1'-0"

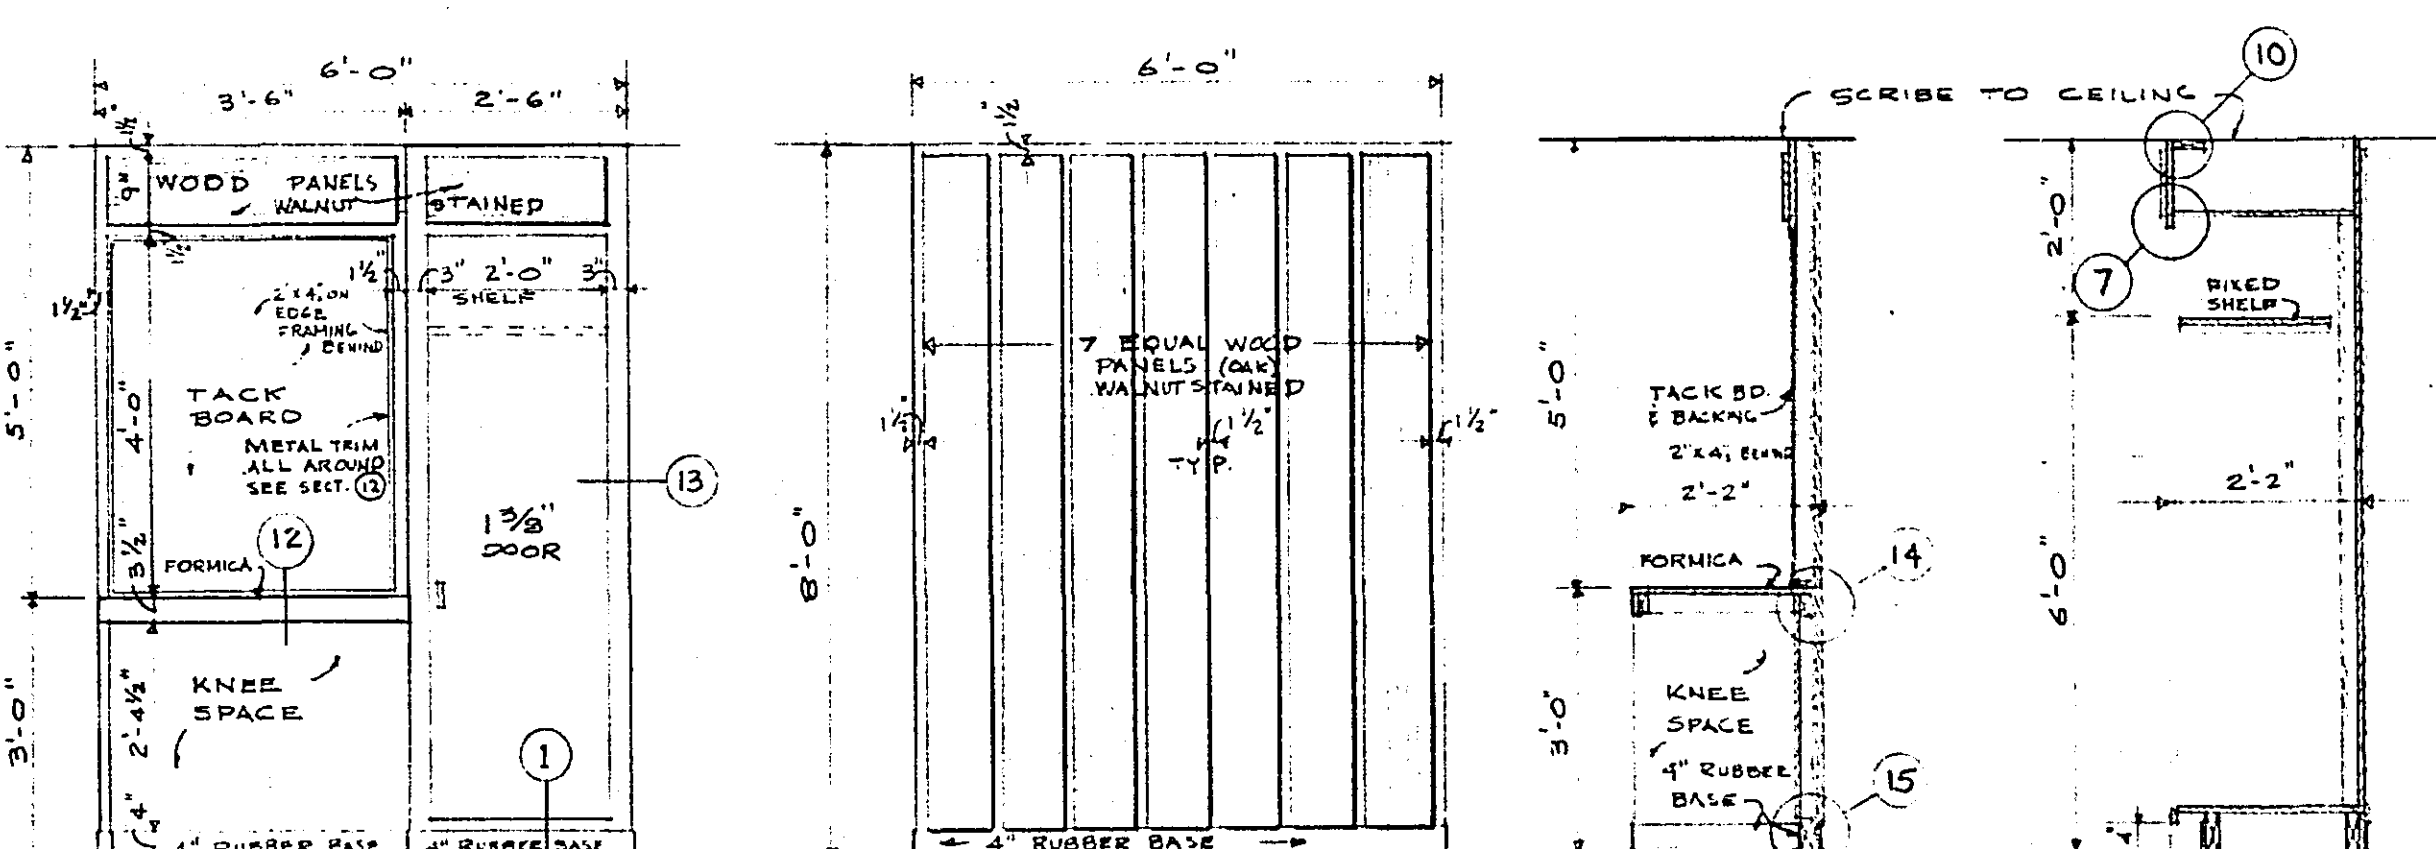

KITCHEN SIDE ELEVATION, BROOM CLOSET DESK - HALL ELEVATION
SECTION THRU DESK
SECTION THRU CLOSET

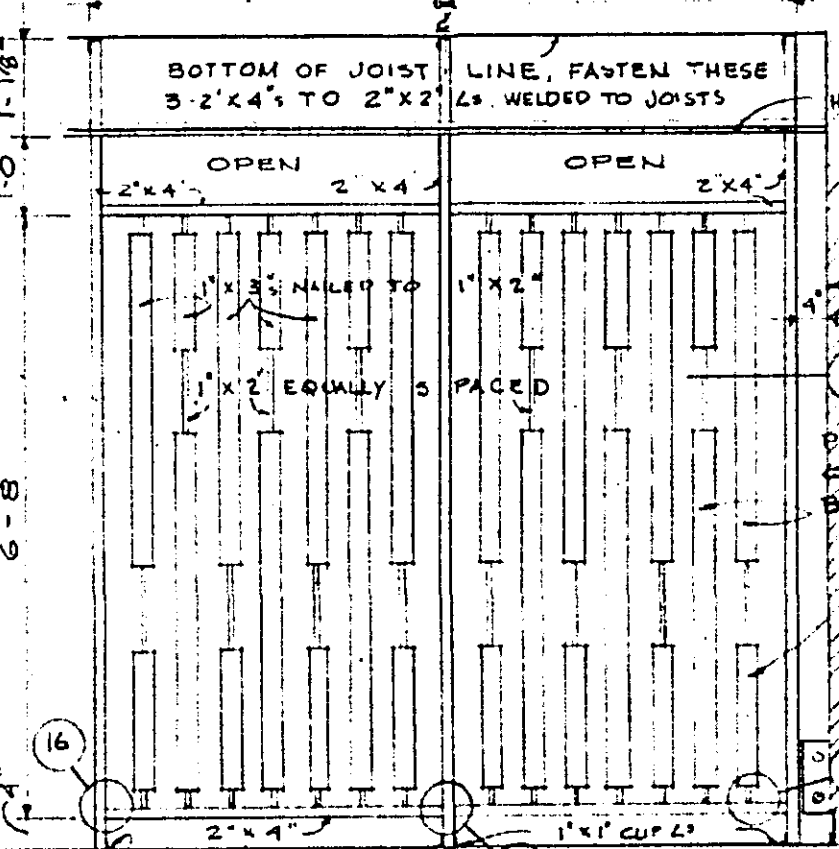

DIVIDER SCREEN, KITCHEN TO LIVING



















MILLWORK DETAILS, FIRST FLOOR



















DOOR TYPES & MILLWORK DETAILS
RAMSEY COUNTY CORONERS OFFICE
ST. PAUL, MINNESOTA
TOLTZ, KING, DUVALL, ANDERSON AND ASSOCIATES, INC.
ENGINERS AND ARCHITECTS
I hereby certify that this plan was prepared by me or under my direct supervision and that I am a duly registered ARCHITECT under the laws of the State of Minnesota.
B. A. Anderson
Date OCTOBER 7, 1963 Reg. No. 685
COM. 4603
DRG. A-7

GROUT SHALL BE $\frac{7}{8}$ " THICK

* BOT. EL. OF BASE PL.

COL.	EL.
------	-----

                  

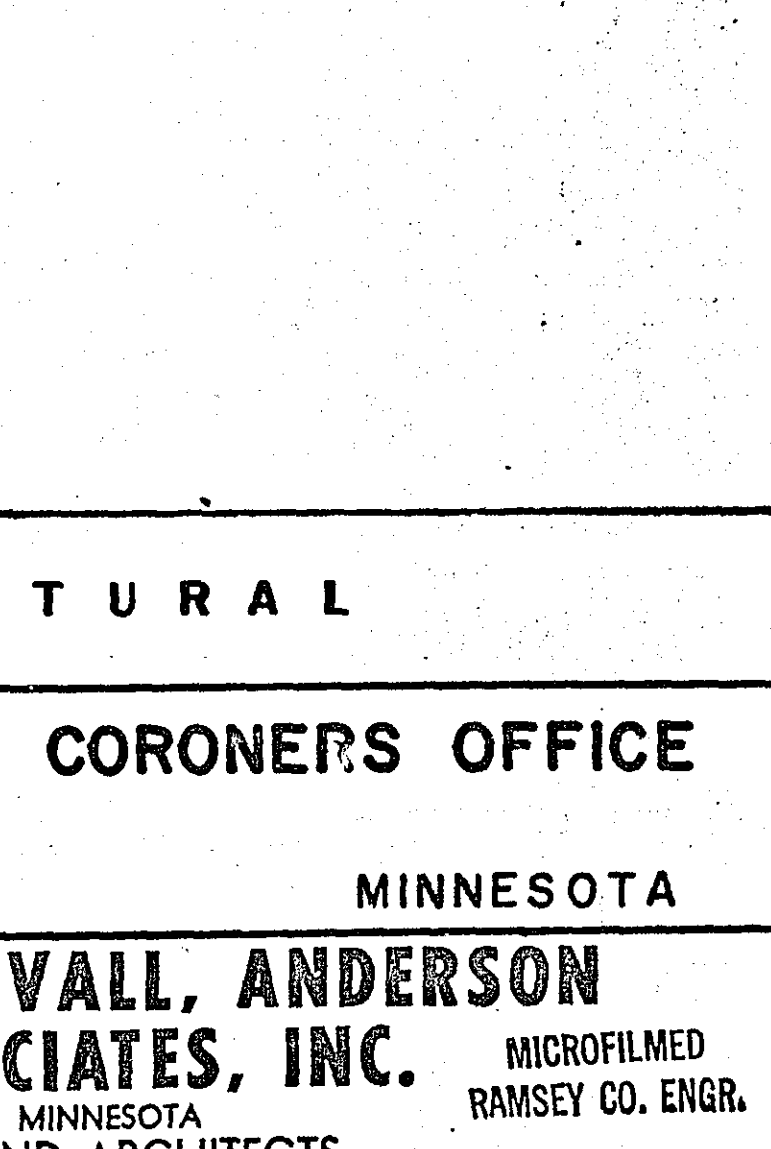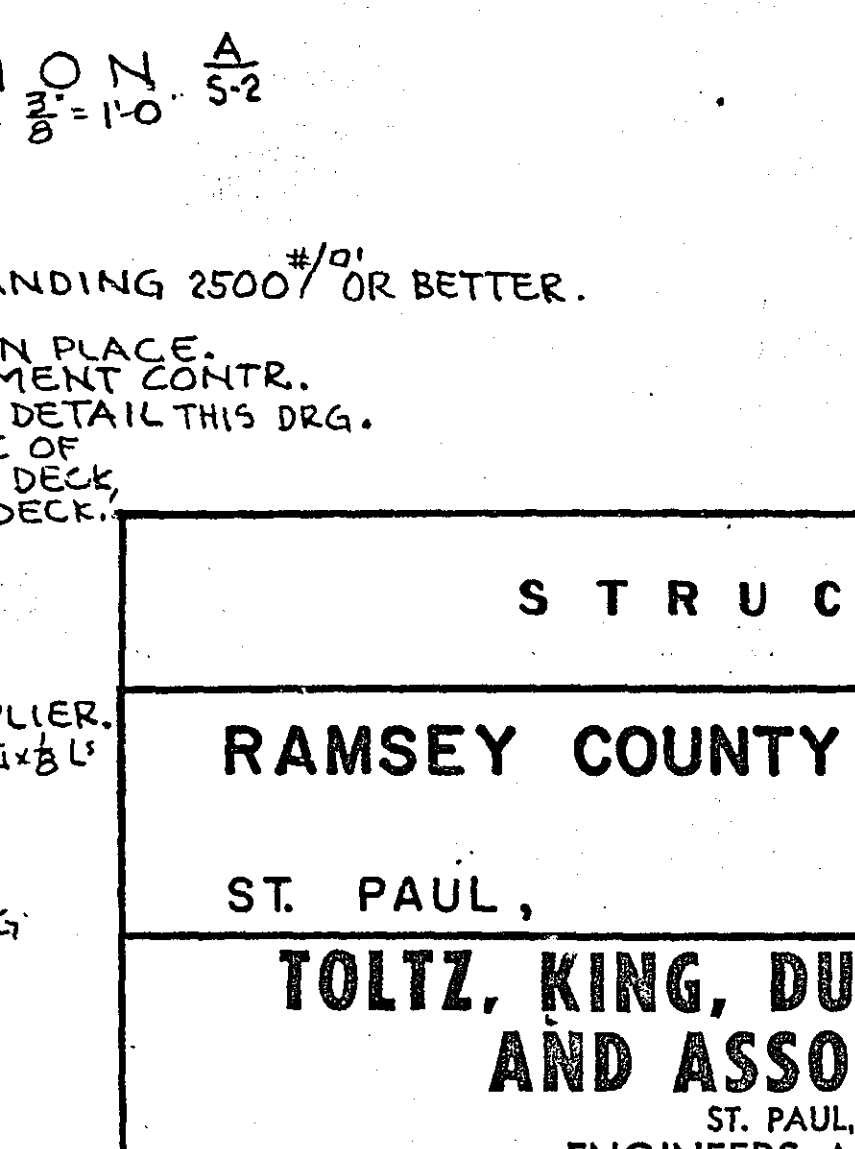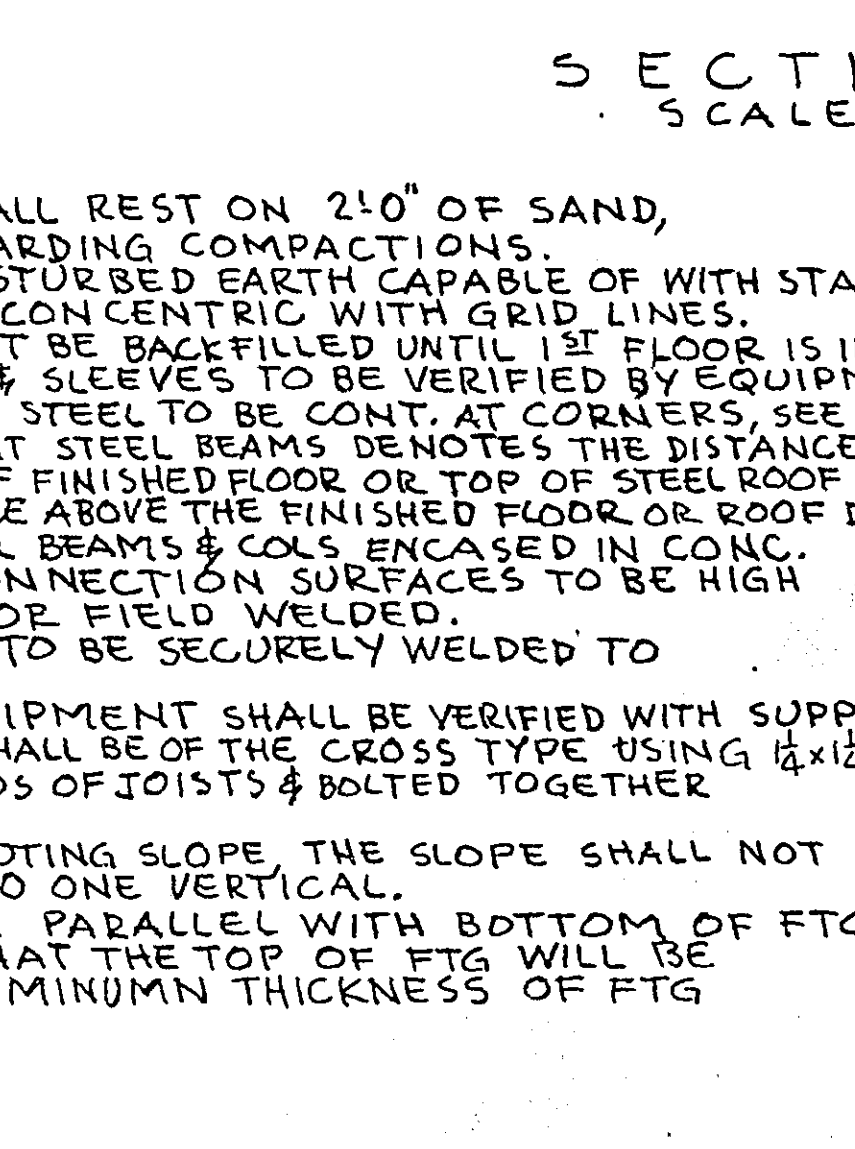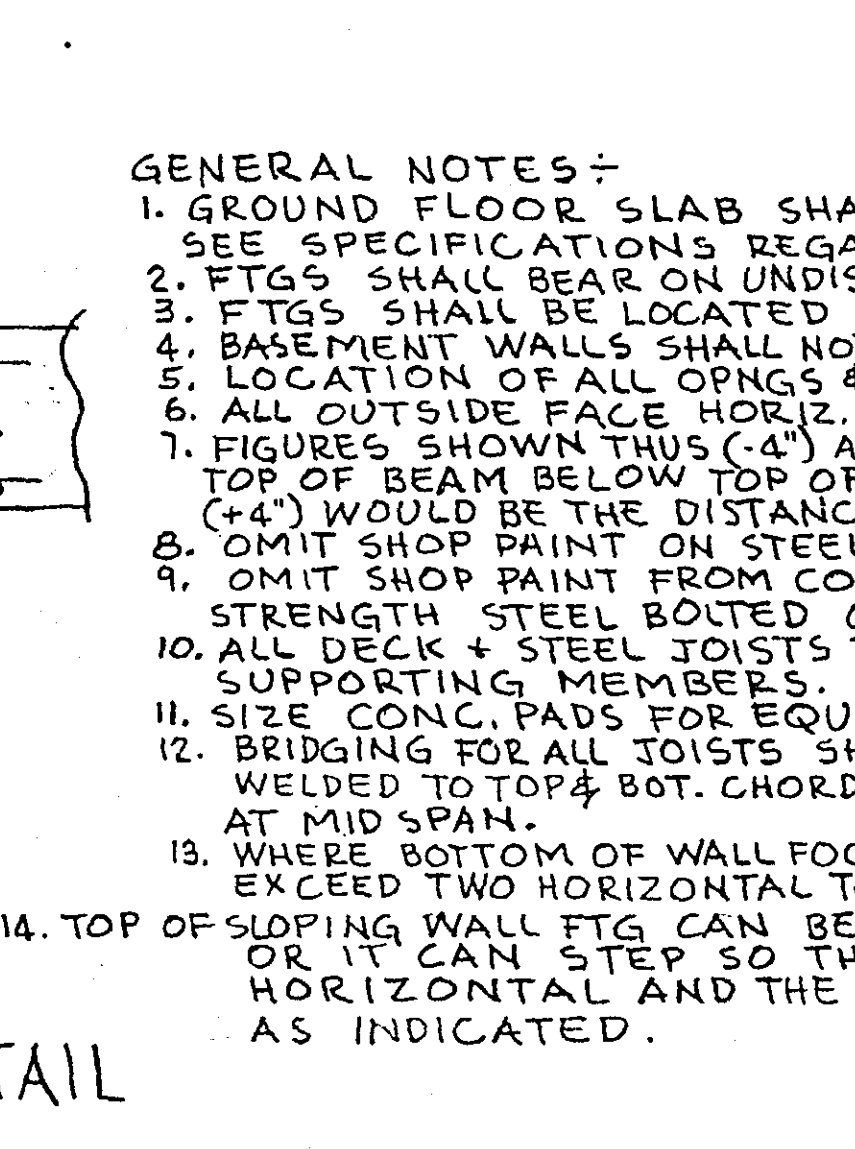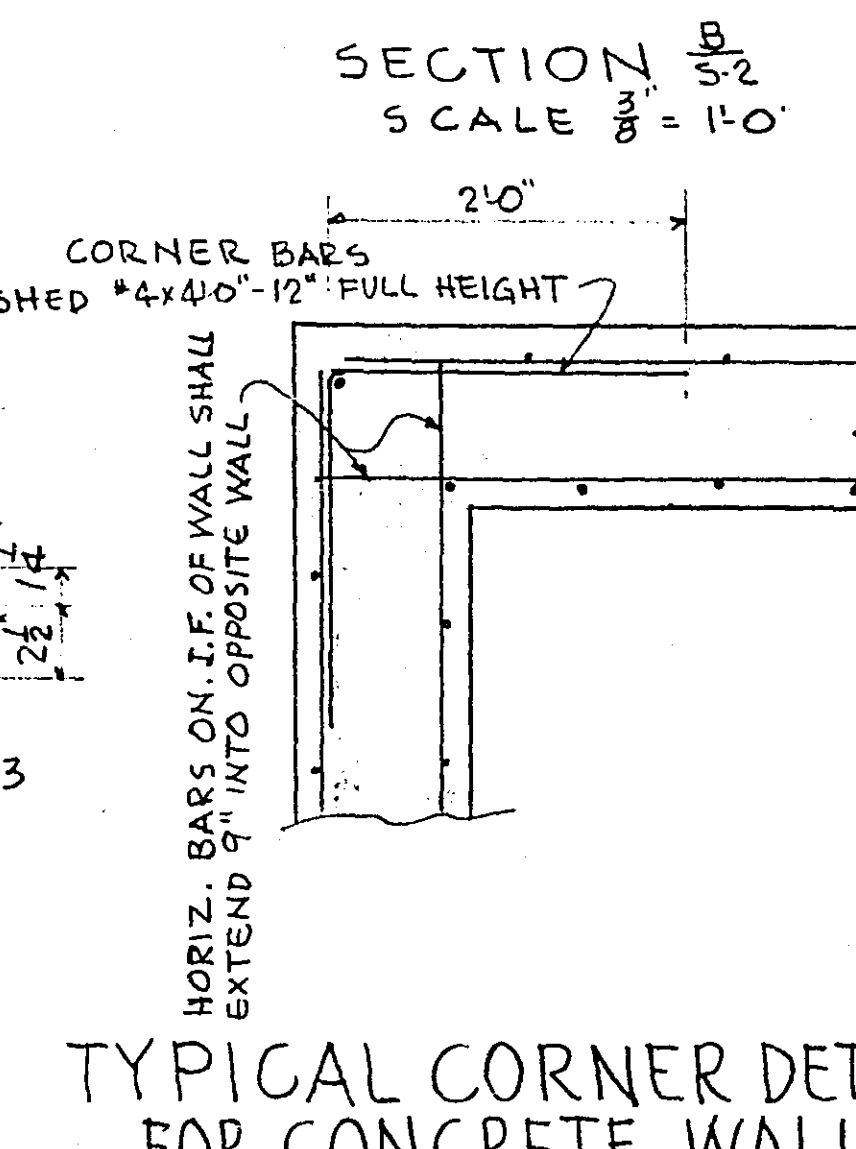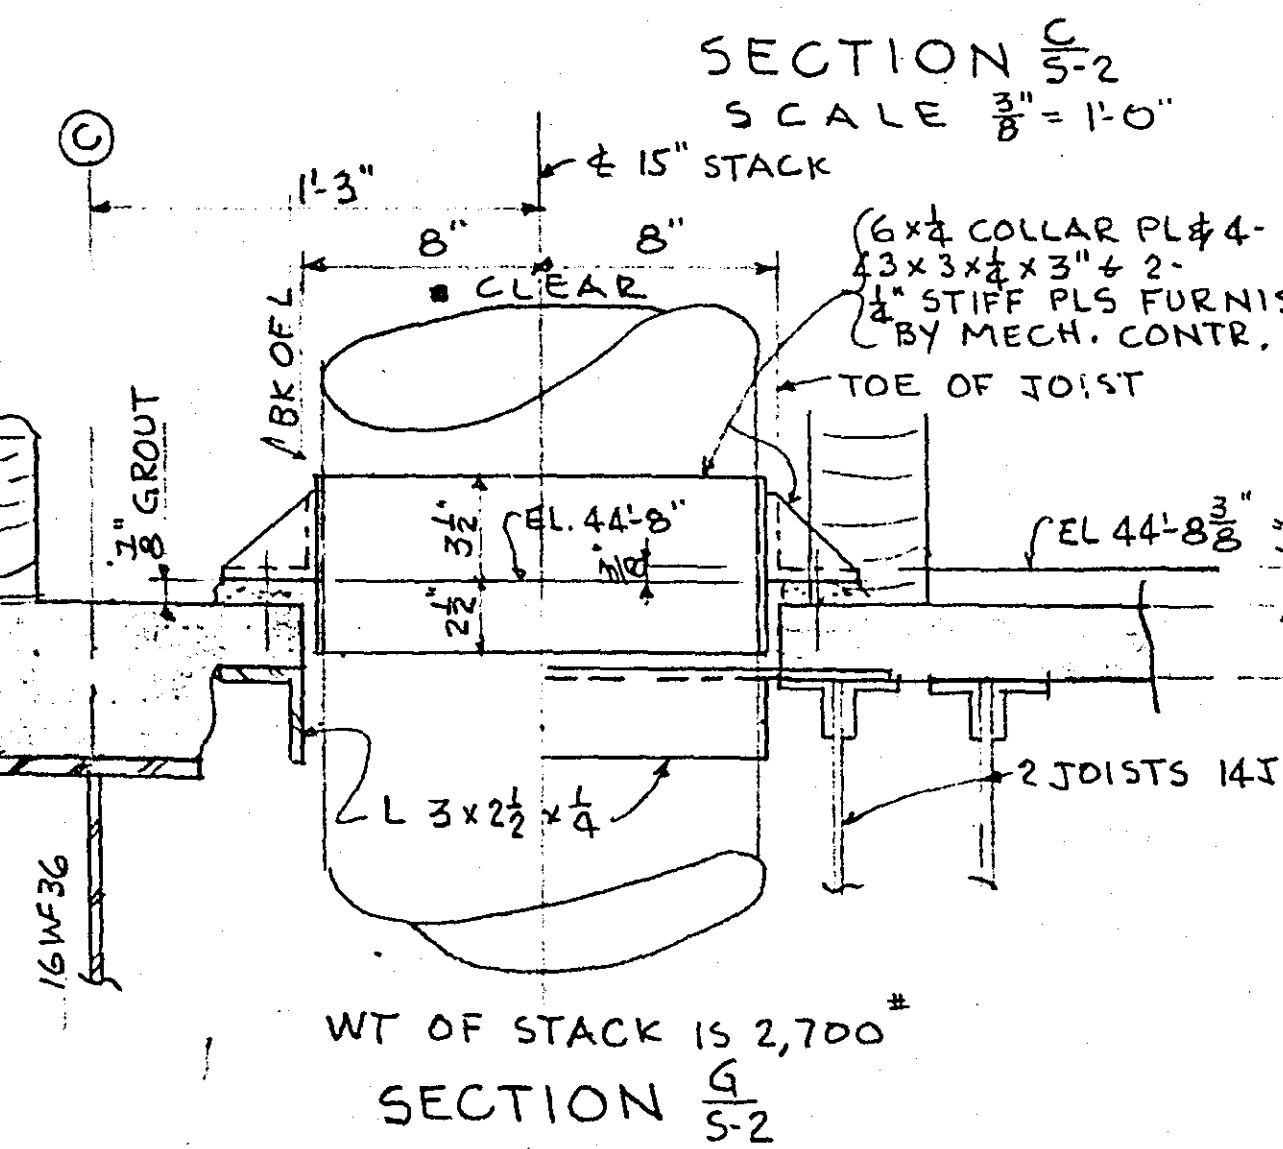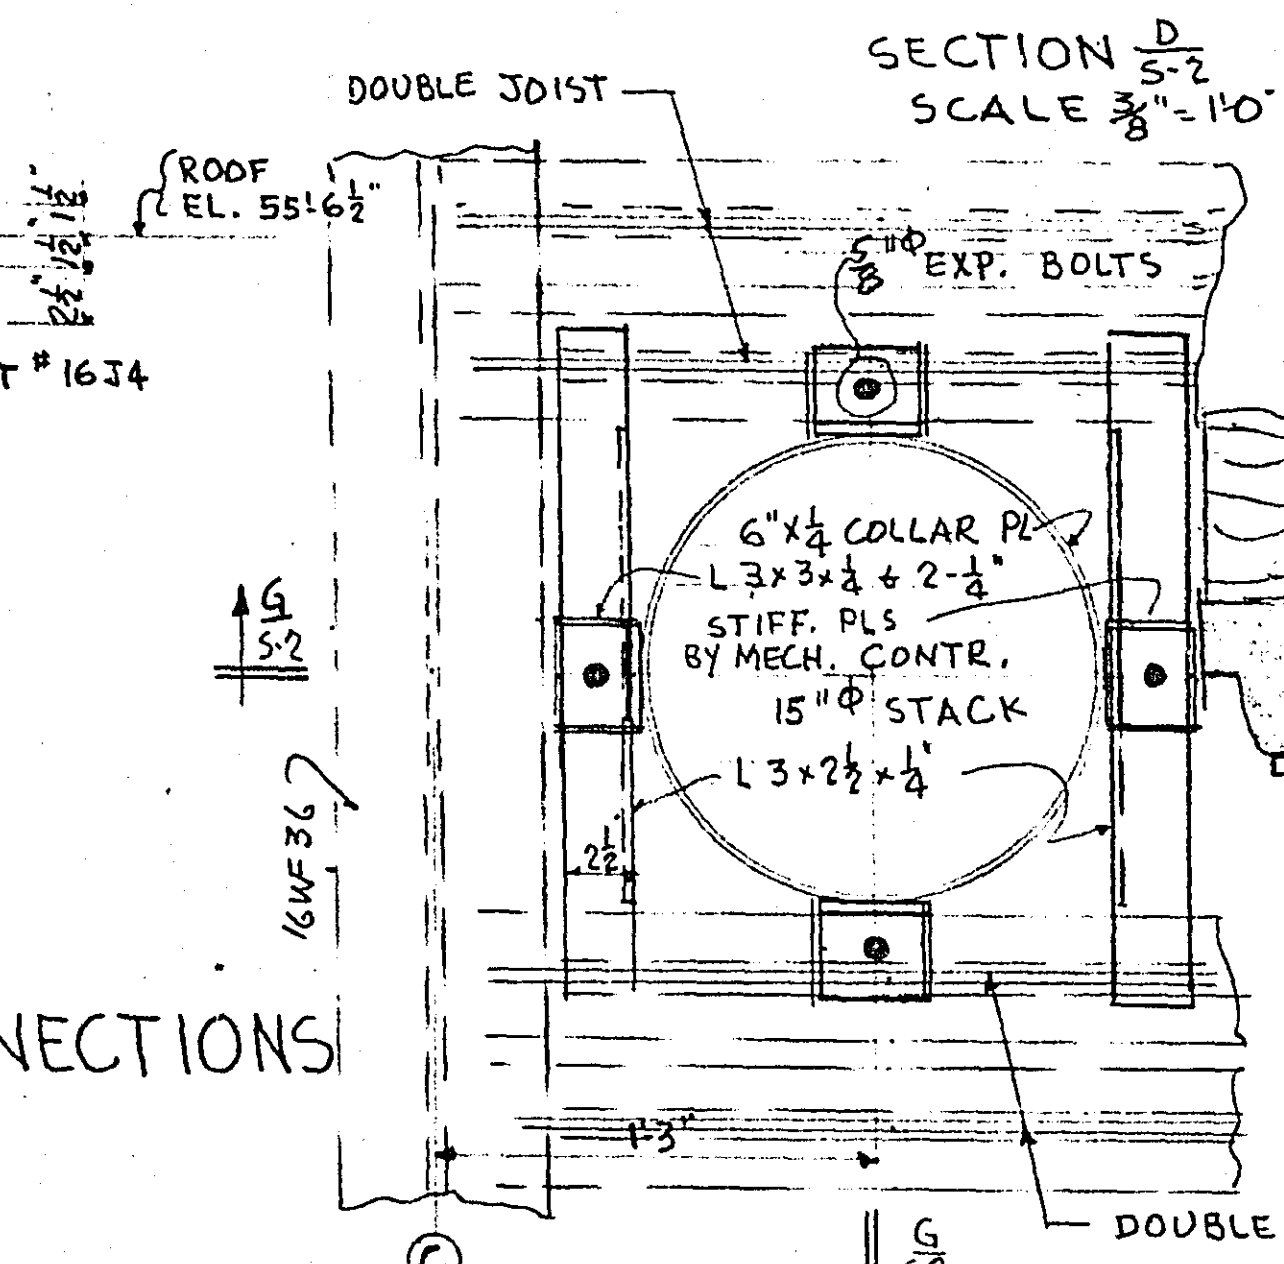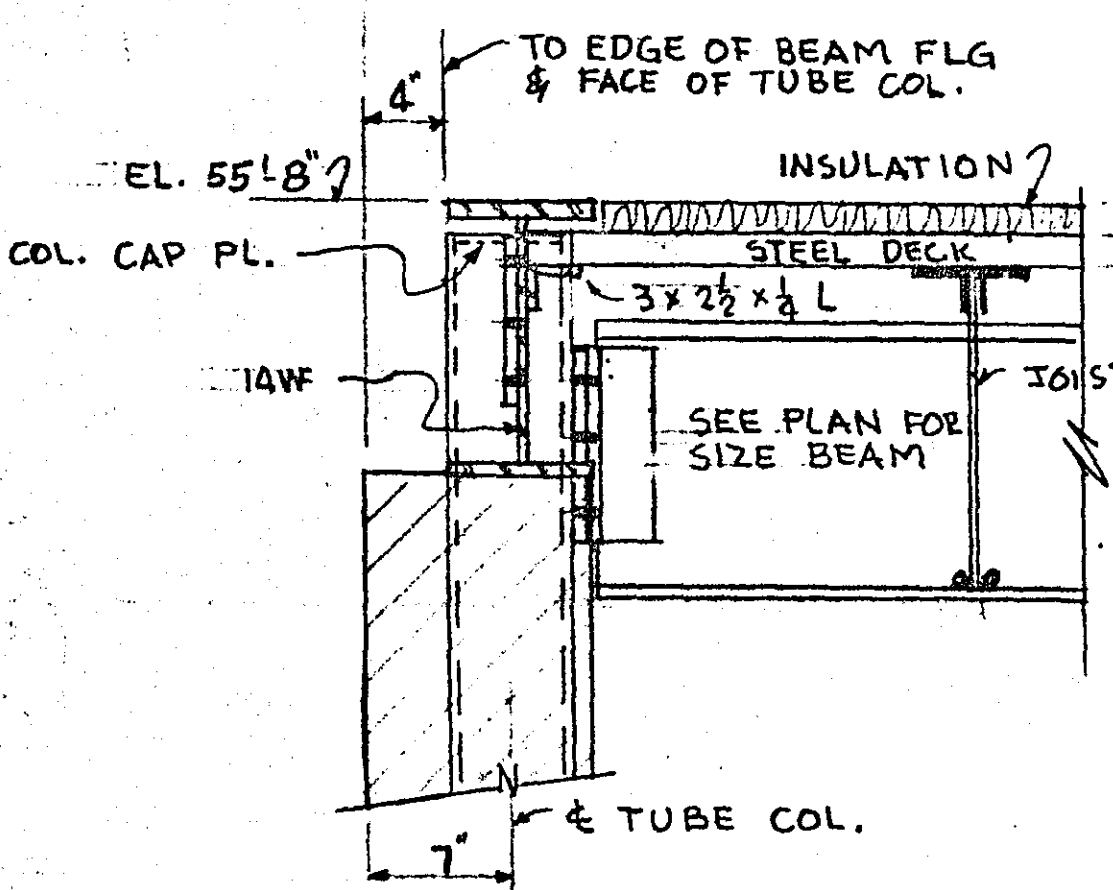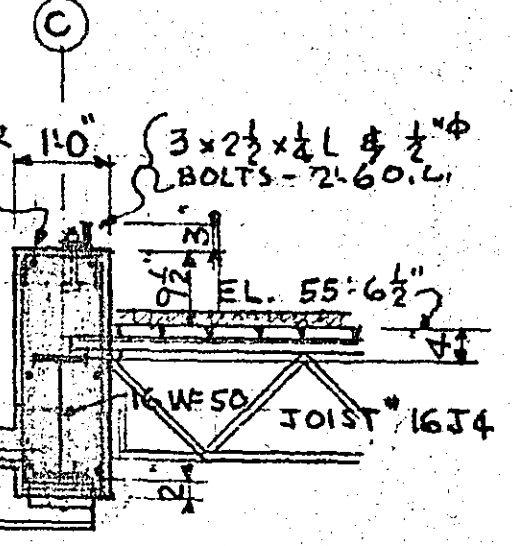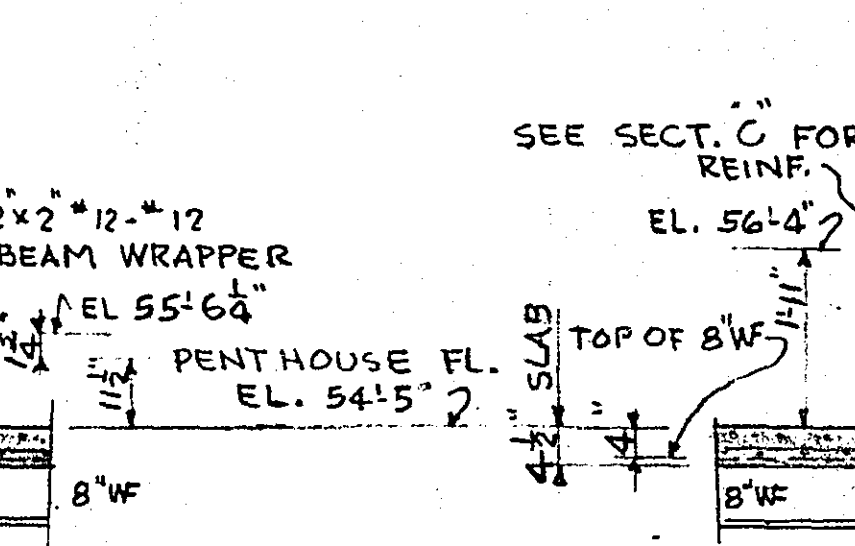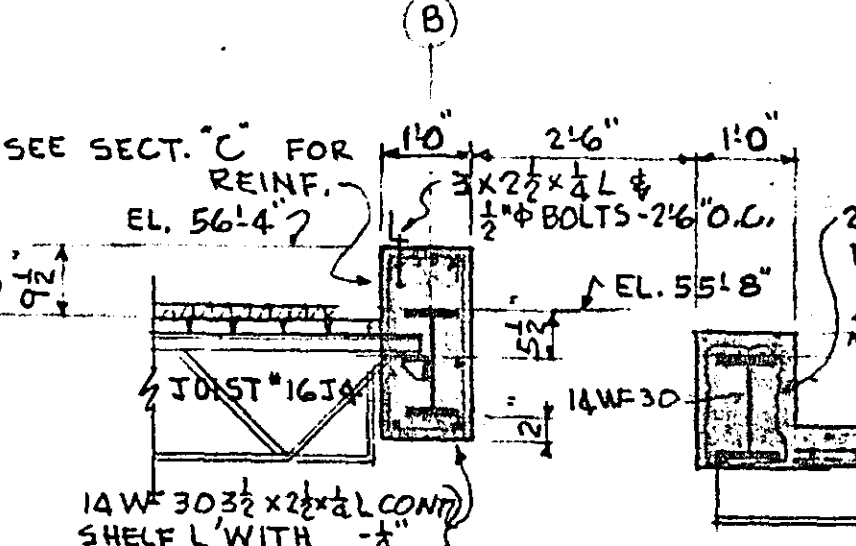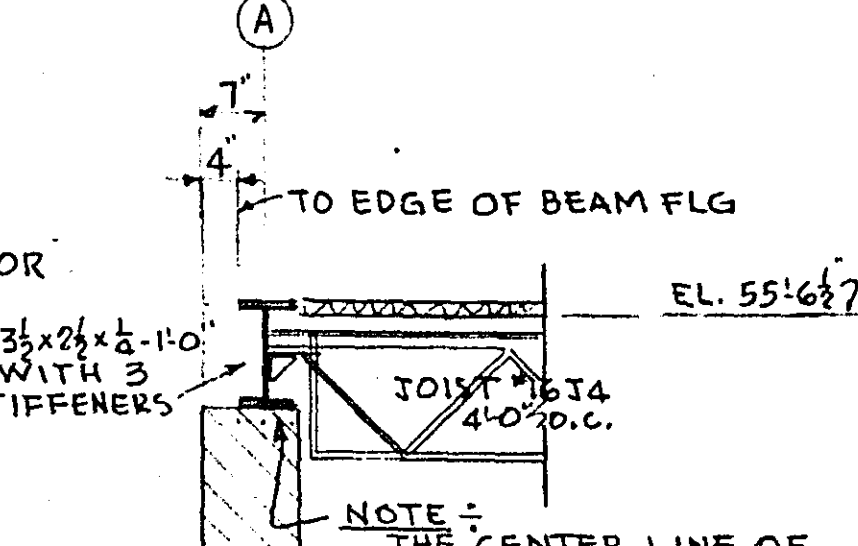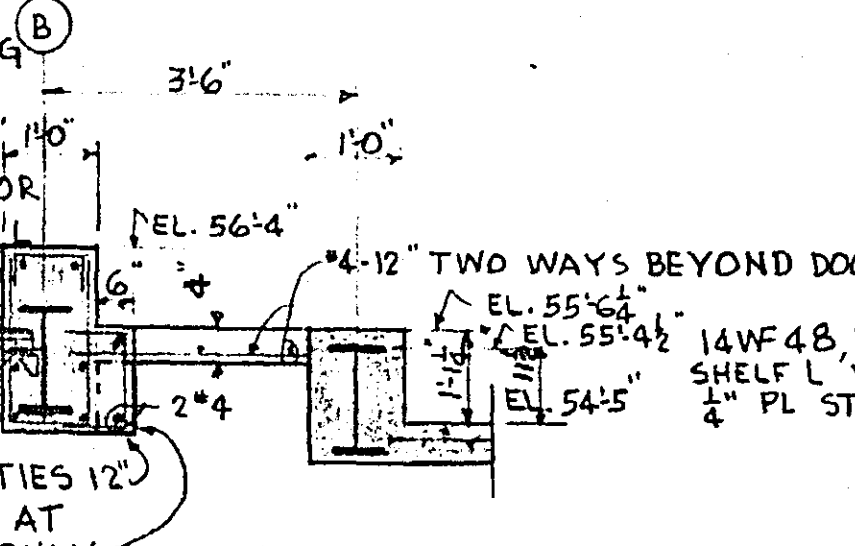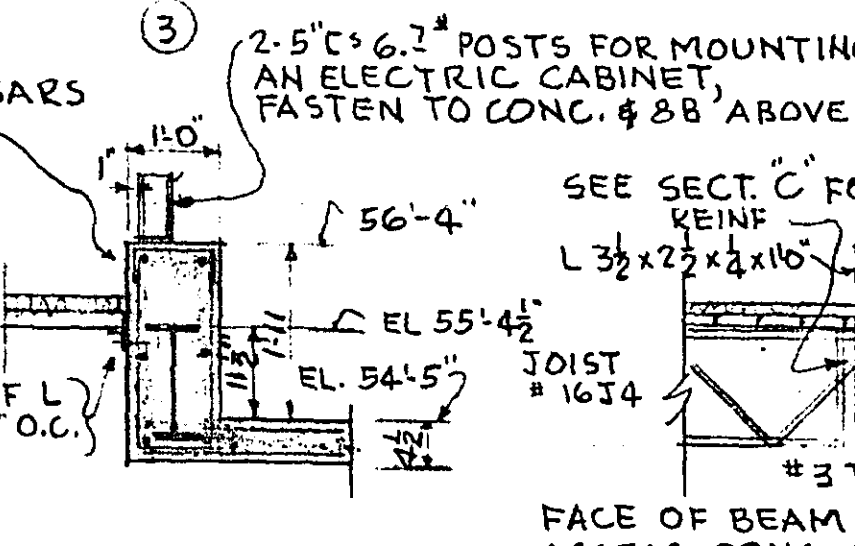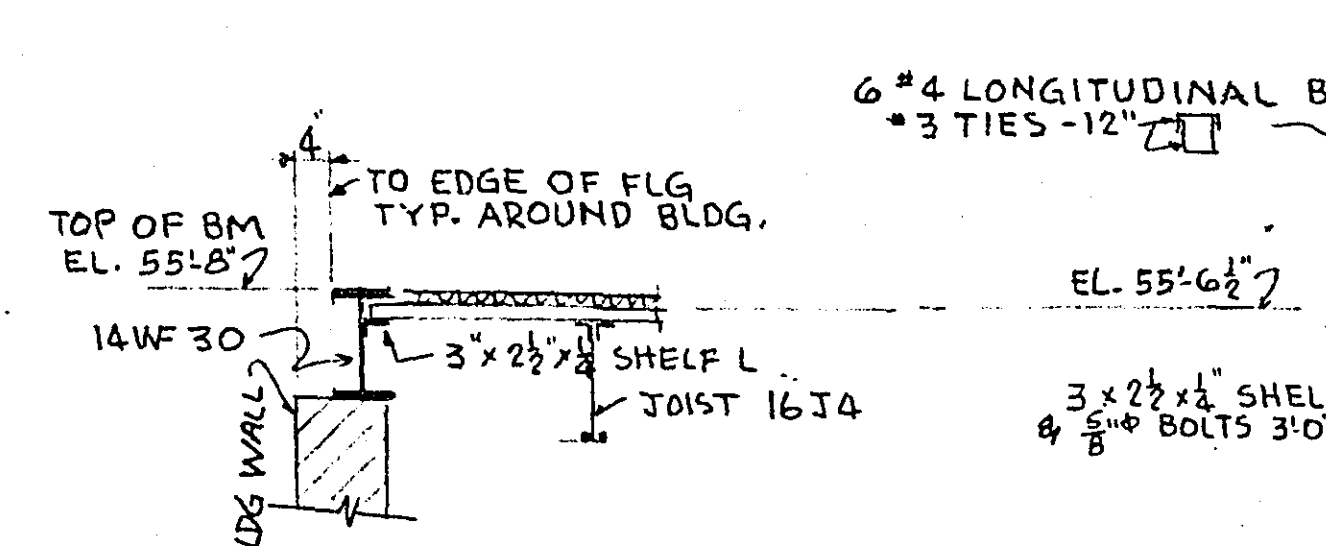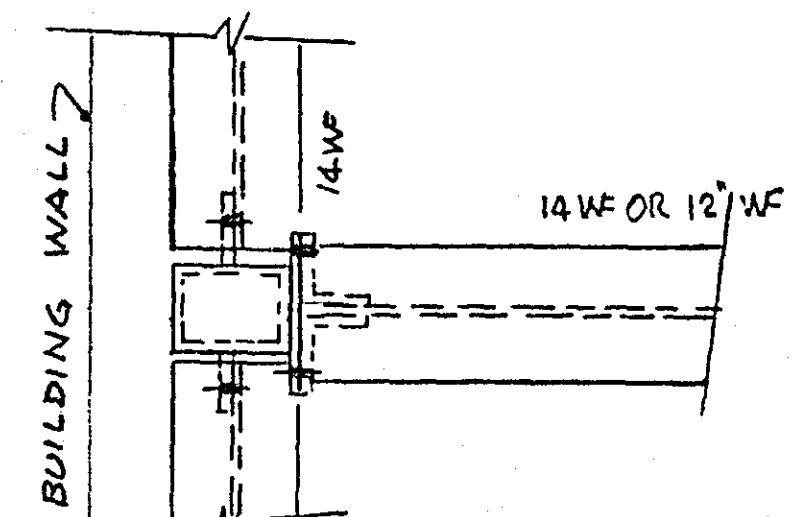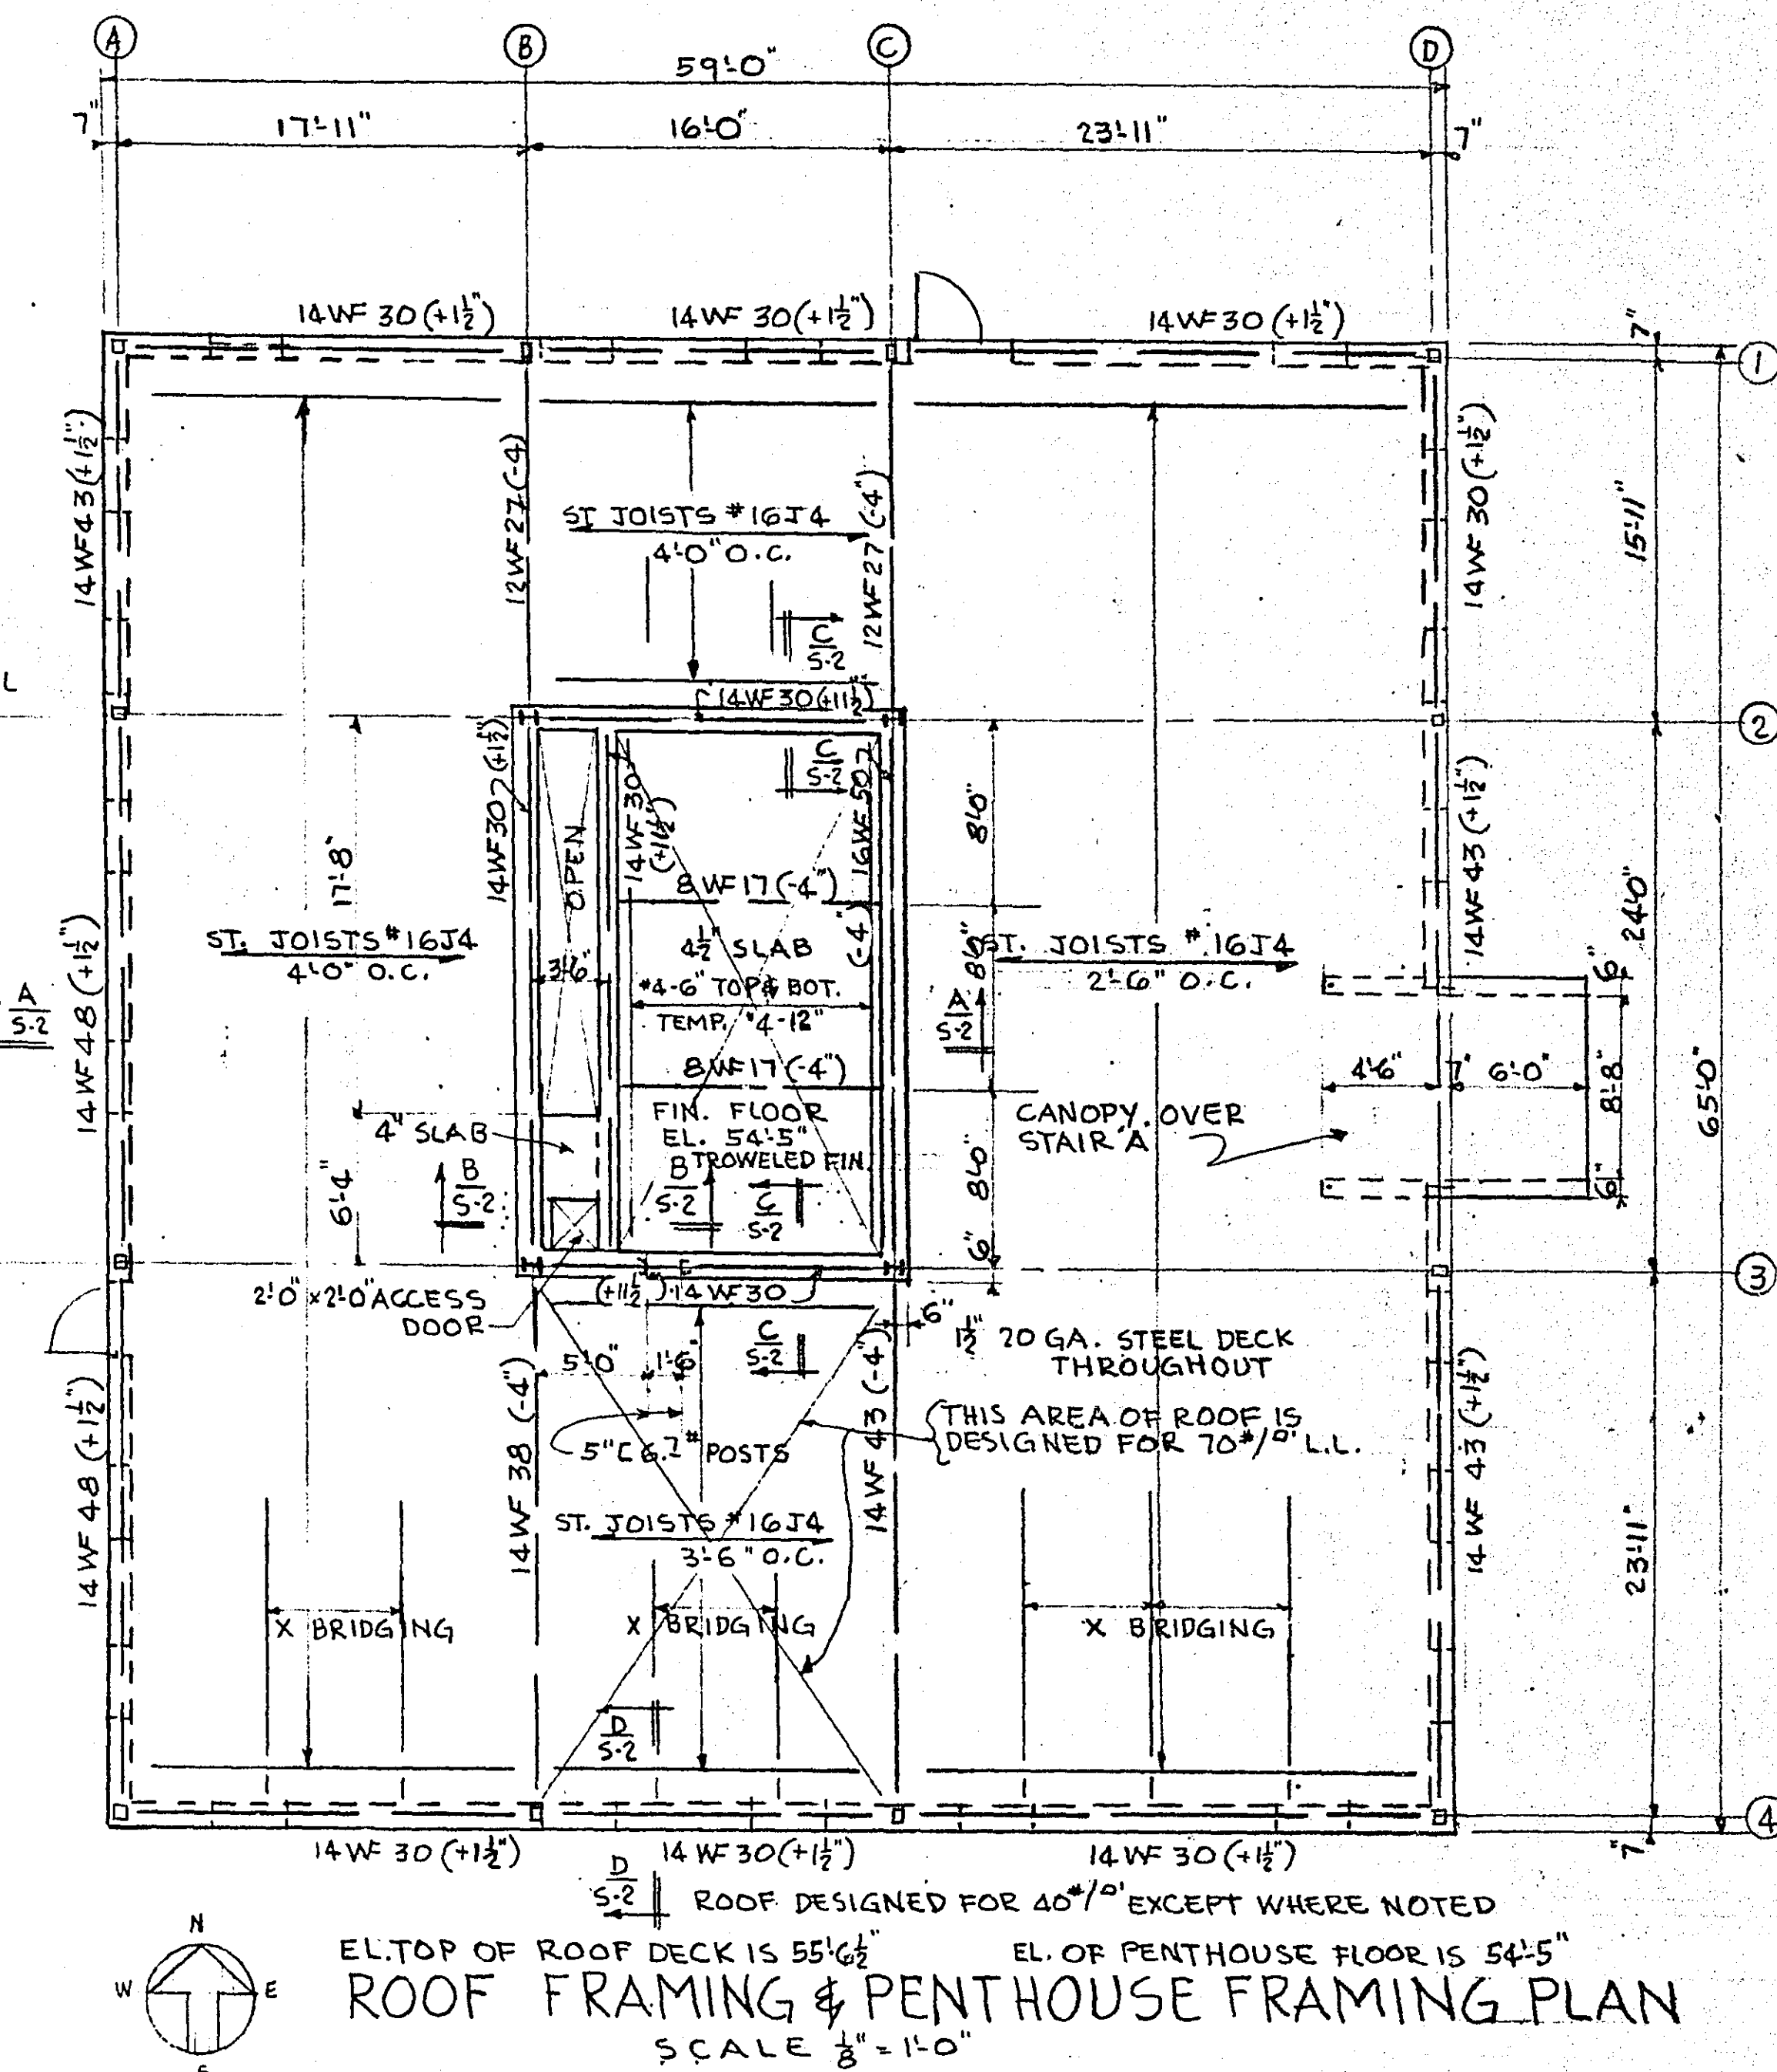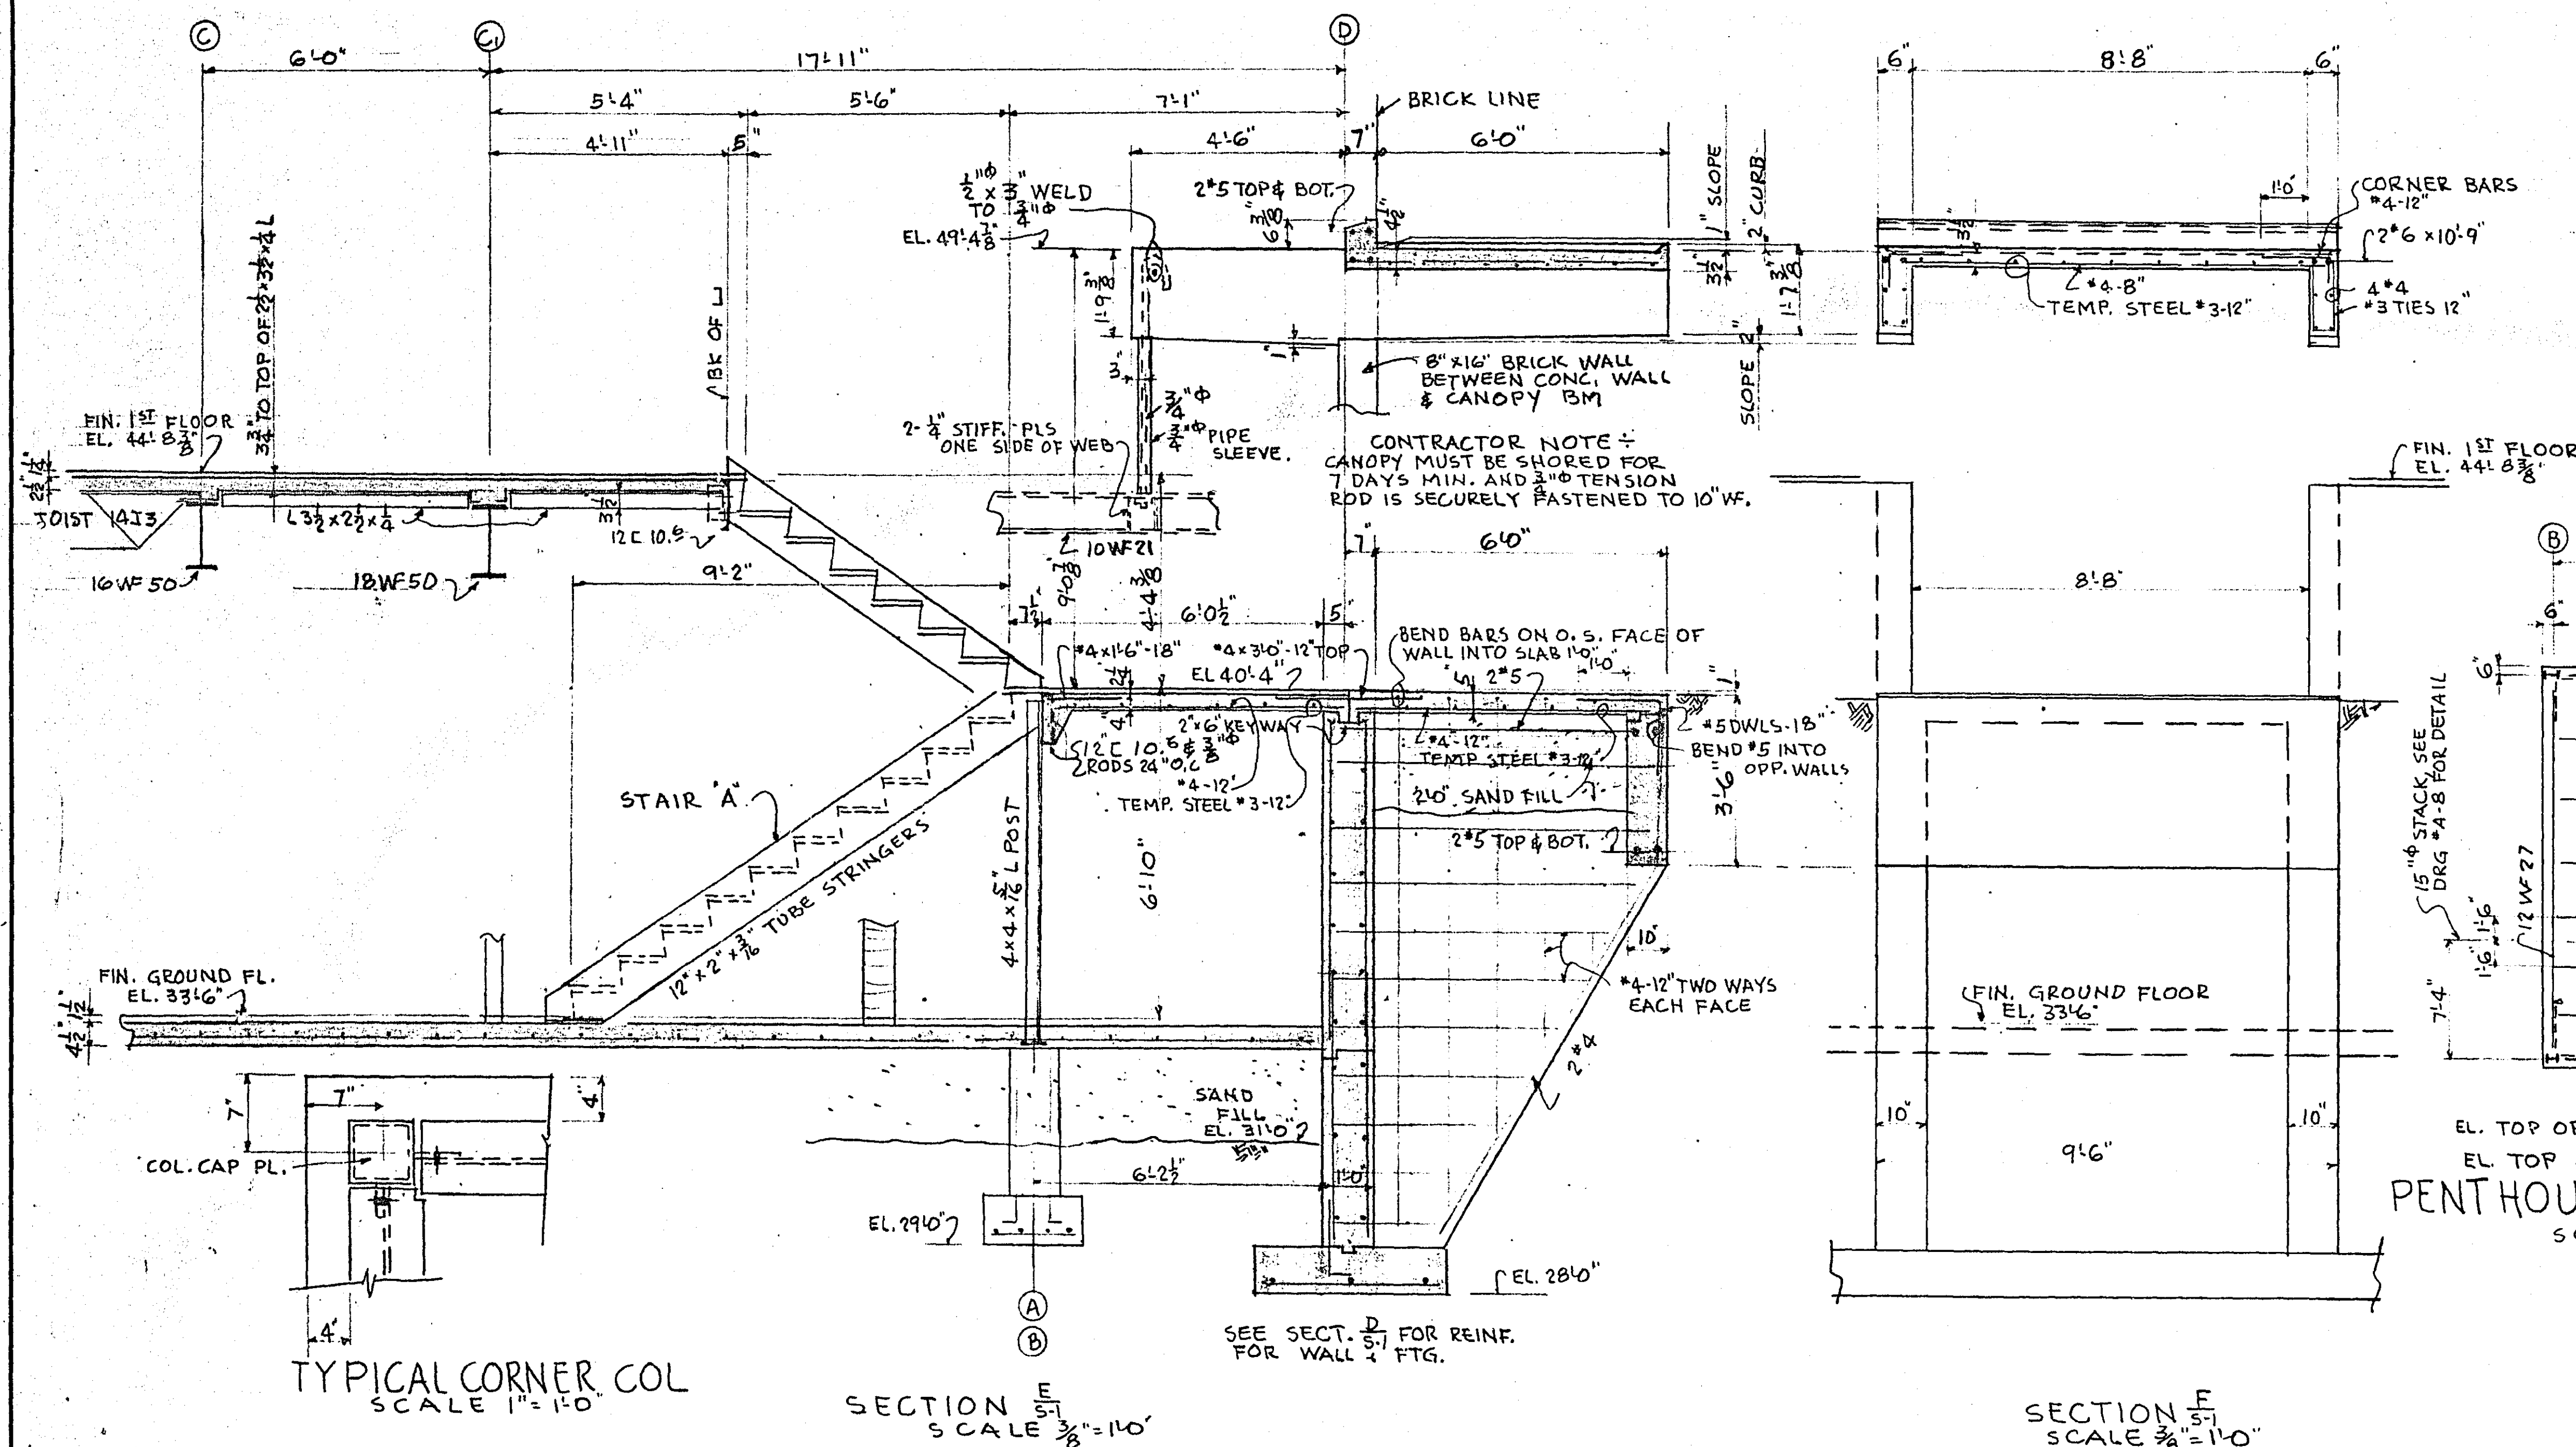

GENERAL NOTES+
1. GROUND FLOOR SLAB SHALL REST ON 2'0" OF SAND, SEE SPECIFICATIONS REGARDING COMPACTIONS.
2. FTG. SHA. BE ON UNDISTURBED PALE OF WITH STANDING 2500' #/ft.
3. FTGS. SHALL BE LOCATED CONCENTRIC WITH GRID LINES.
4. BASEMENT WALLS SHALL NOT BE BACKFILLED UNTIL 1ST FLOOR IS IN PLACE.
5. LOCATION OF ALL OPNGS & SLEEVES TO BE VERIFIED BY EQUIPMENT CONTR.
6. OMIT DRAINAGE FLE HOLE. TO BE CONT. AT CORNERS. SEE DETAIL THIS DRG.
7. FIGURES SHOWN THUS (4") AT STEEL BEAMS DENOTES THE DISTANCE OF TOP OF BEAM BELOW TOP OF FINISHED FLOOR OR TOP OF STEEL ROOF DECK. CORD WOULD BE THE DISTANCE FROM THE FINISHED FLOOR OR ROOF DECK.
8. OMIT SHOP PAINT ON STEEL BEAMS & COL. ENCASED IN CONC.
9. OMIT SHOP PAINT FROM CONNECTION SURFACES TO BE HIGH STRENGTH STEEL BOLTED OR FIELD WELDED.
10. ALL DECK & STEEL TOISTS TO BE SECURELY WELDED TO SUPPORTING MEMBERS.
11. SIZE CONC. PADS FOR EQUIPMENT SHALL BE VERIFIED WITH SUPPLIER.
12. BRIDGING FOR ALL TOISTS SHALL BE OF THE CROSS TYPE USING 4"x12"x8' WELDED TO TOP & BOT. CHORDS OF TOISTS & BOLTED TOGETHER AT MID SPAN.
13. WHERE BOTTOM OF WALL FOOTING SLOPE, THE SLOPE SHALL NOT EXCEED TWO HORIZONTAL TO ONE VERTICAL.
14. TOP OF SLOPING WALL CAN BE AT ANY PAUSE WITH BOTTOM OF FTG' OF SLOPE. BUT CAN BE SO THAT THE TOP OF FTG WILL BE HORIZONTAL AND THE MINIMUM THICKNESS OF FTG AS INDICATED.

STRUCTURAL

RAMSEY COUNTY CORONERS OFFICE


ST. PAUL, MINNESOTA

**TOLTZ, KING, DUVALL, ANDERSON
AND ASSOCIATES, INC.** MICROFILME
ST. PAUL, MINNESOTA RAMSEY CO. EN
ENGINEERS AND ARCHITECTS


DESIGNED <i>C. A. O.</i> DRAWN <i>O. A. O.</i> CHECKED <i>O. A. O.</i>	I hereby certify that this plan was prepared by me or under my direct supervision and that I am a duly		COM.
	Registered <u>PROFESSIONAL ENGINEER</u>		4603
	under the laws of the State of Minnesota.		DRG.
	<i>John A. Kinnick</i>		S-2
	Date <u>OCTOBER 7, 1963</u>	Reg. No. <u>4461</u>	

PIPE SIZE	M.B.H.	G.P.M.
1/2"	TO 6	TO 0.6
3/4"	6 TO 18	0.6 TO 1.8
1"	18 TO 33	1.8 TO 3.3
1 1/4"	33 TO 65	3.3 TO 6.5


THIS SCHEDULE TO BE USED
WHERE BRANCH SIZES ARE
NOT SHOWN

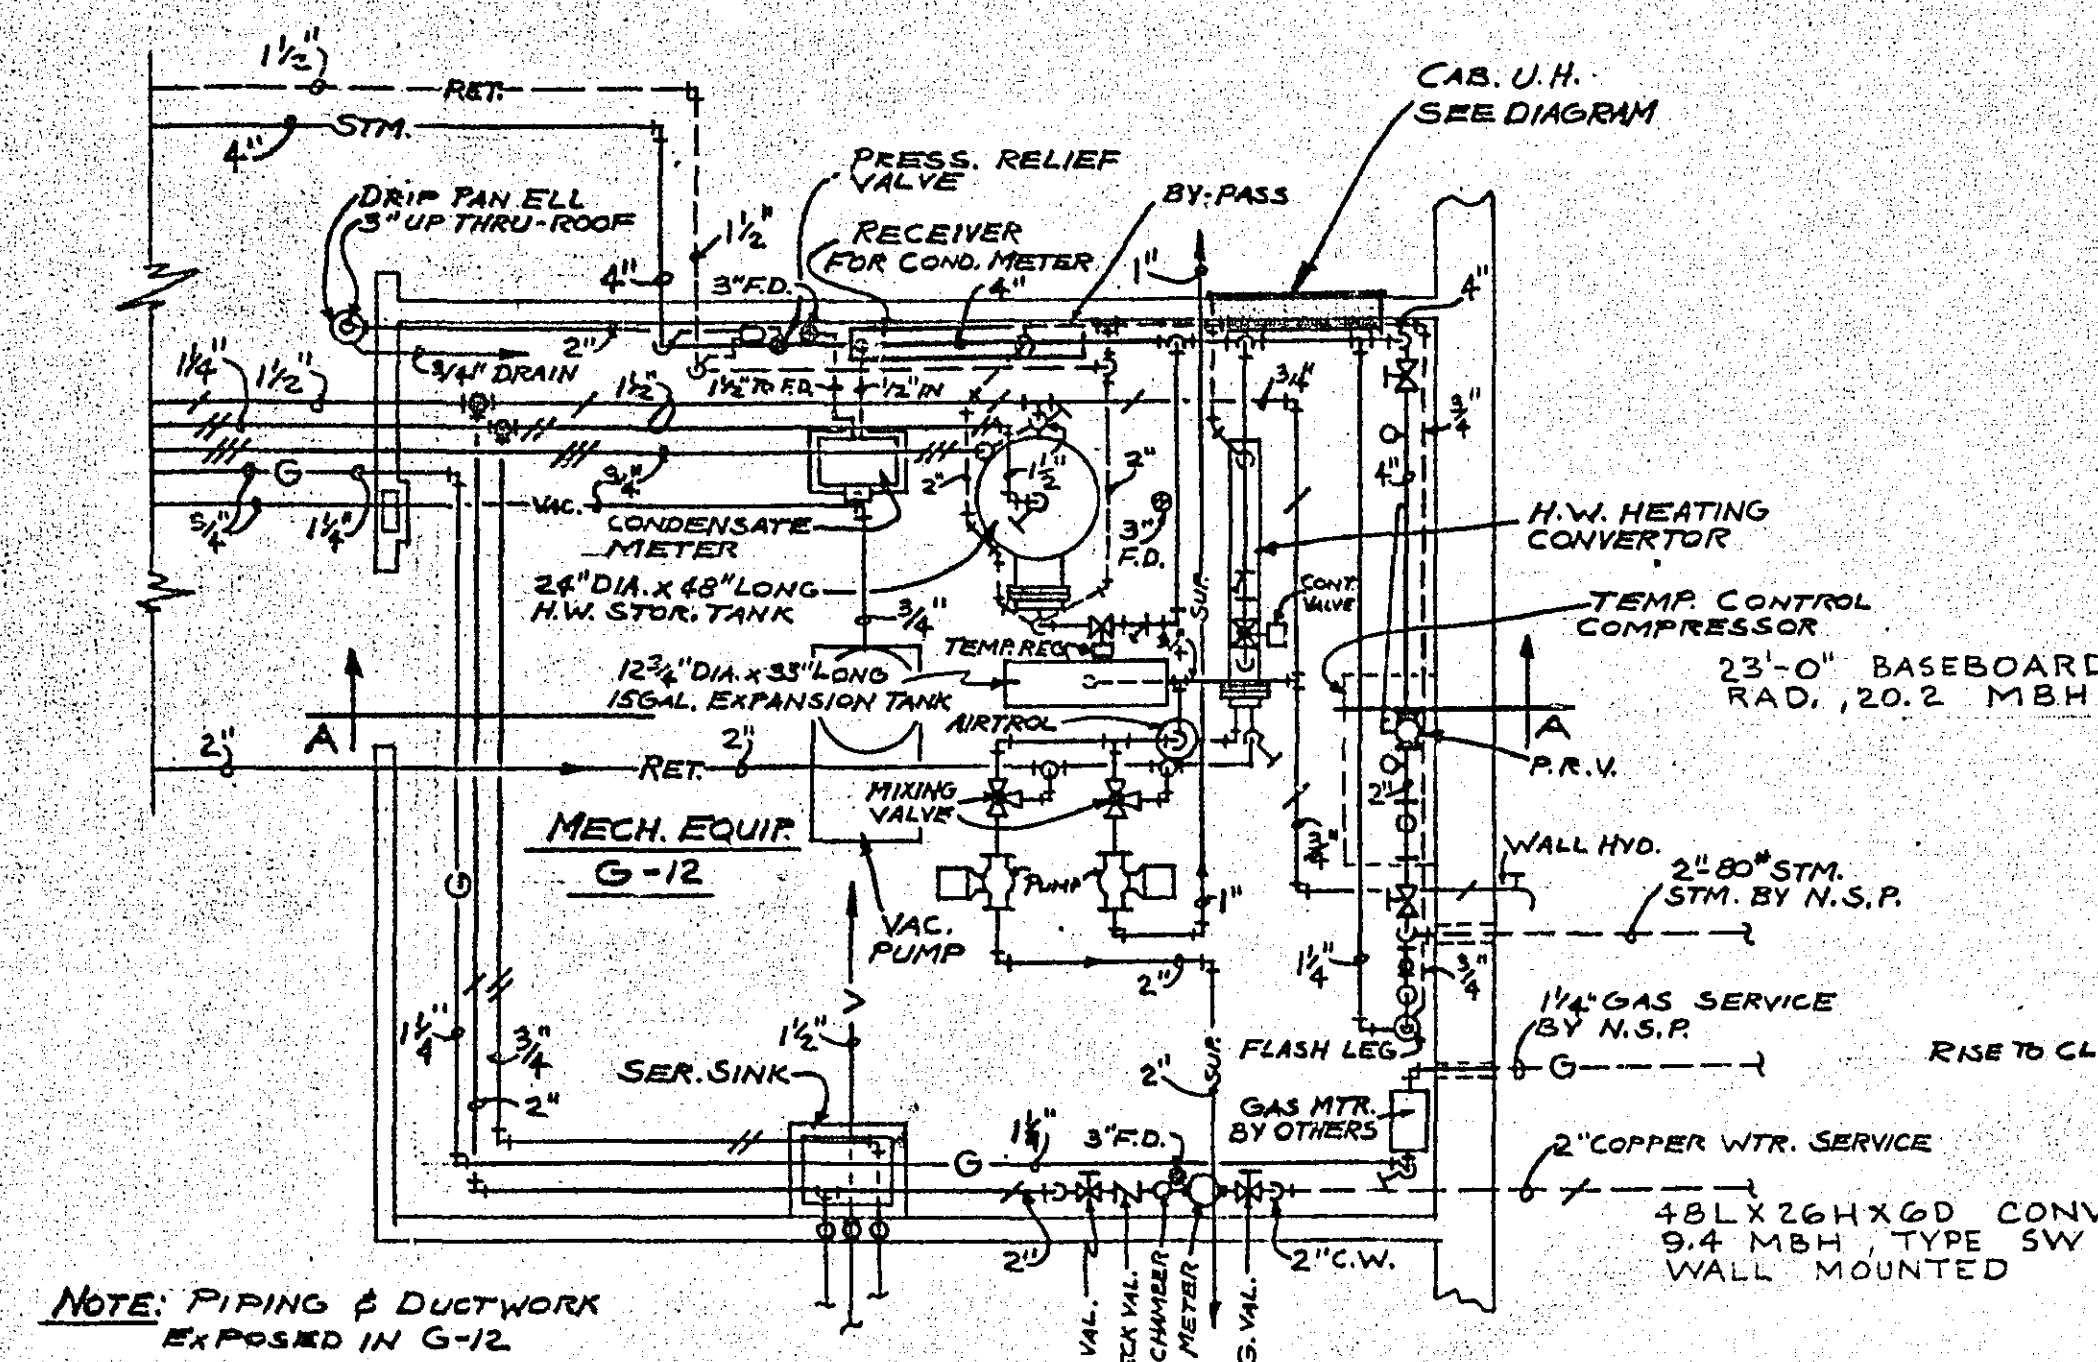


MECH. EQUIP. ROOM PLAN
SCALE: 1/4" = 1'-0"

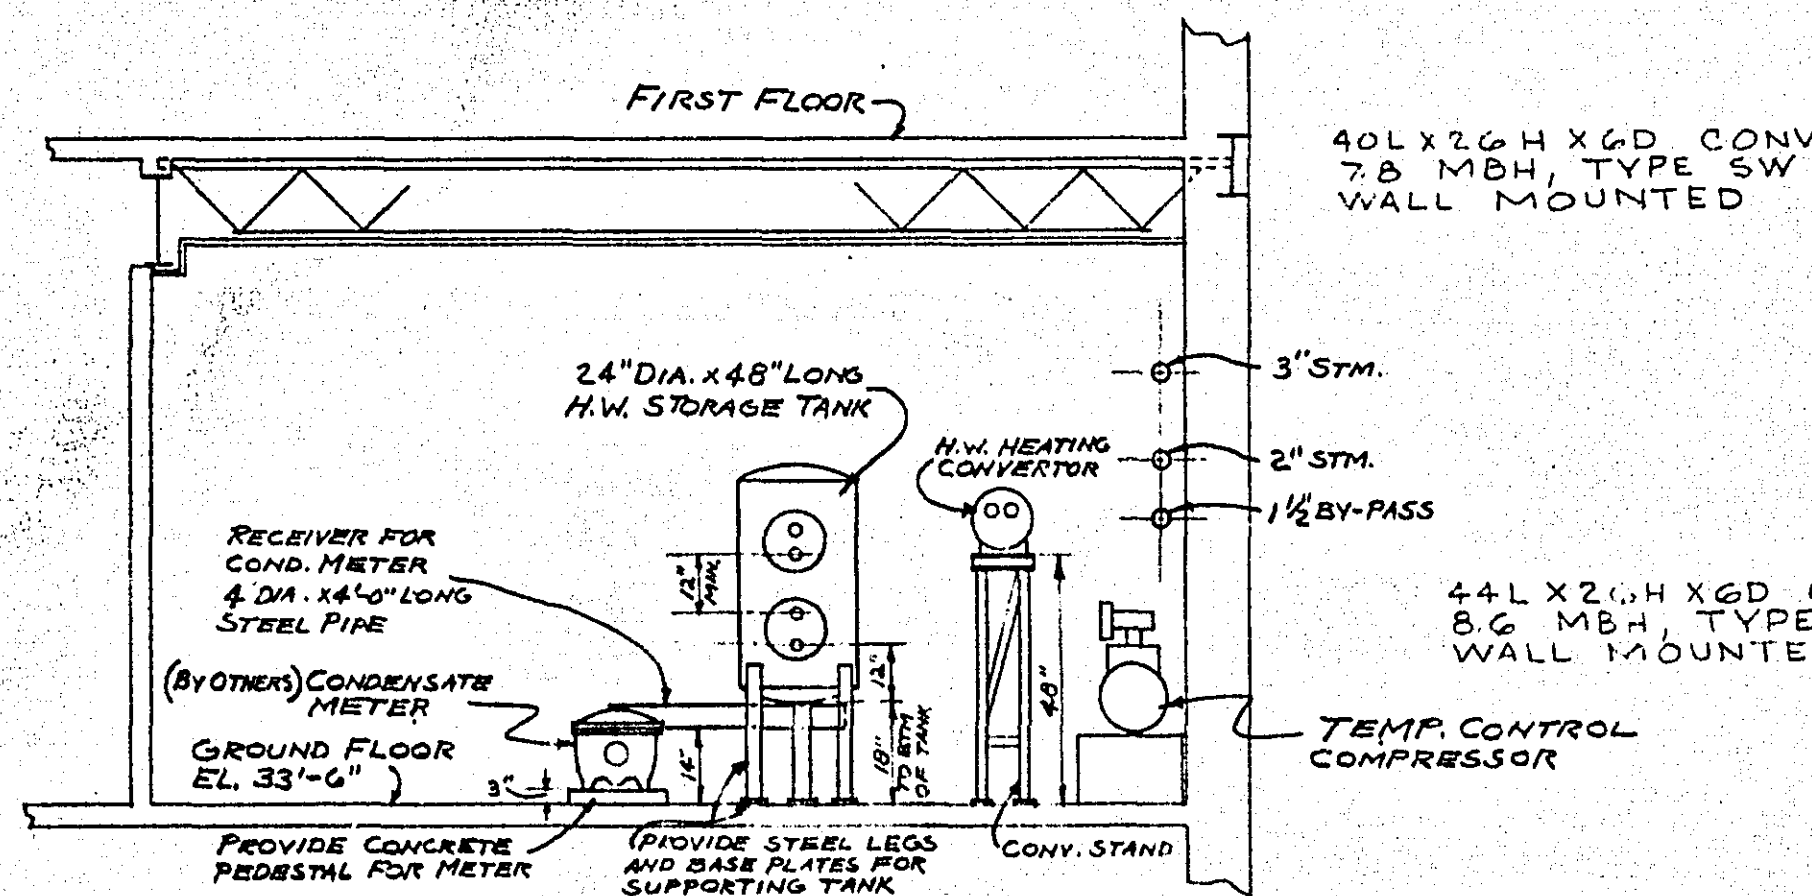


SECTION 'AA'
SCALE: 1/4" = 1'-0"

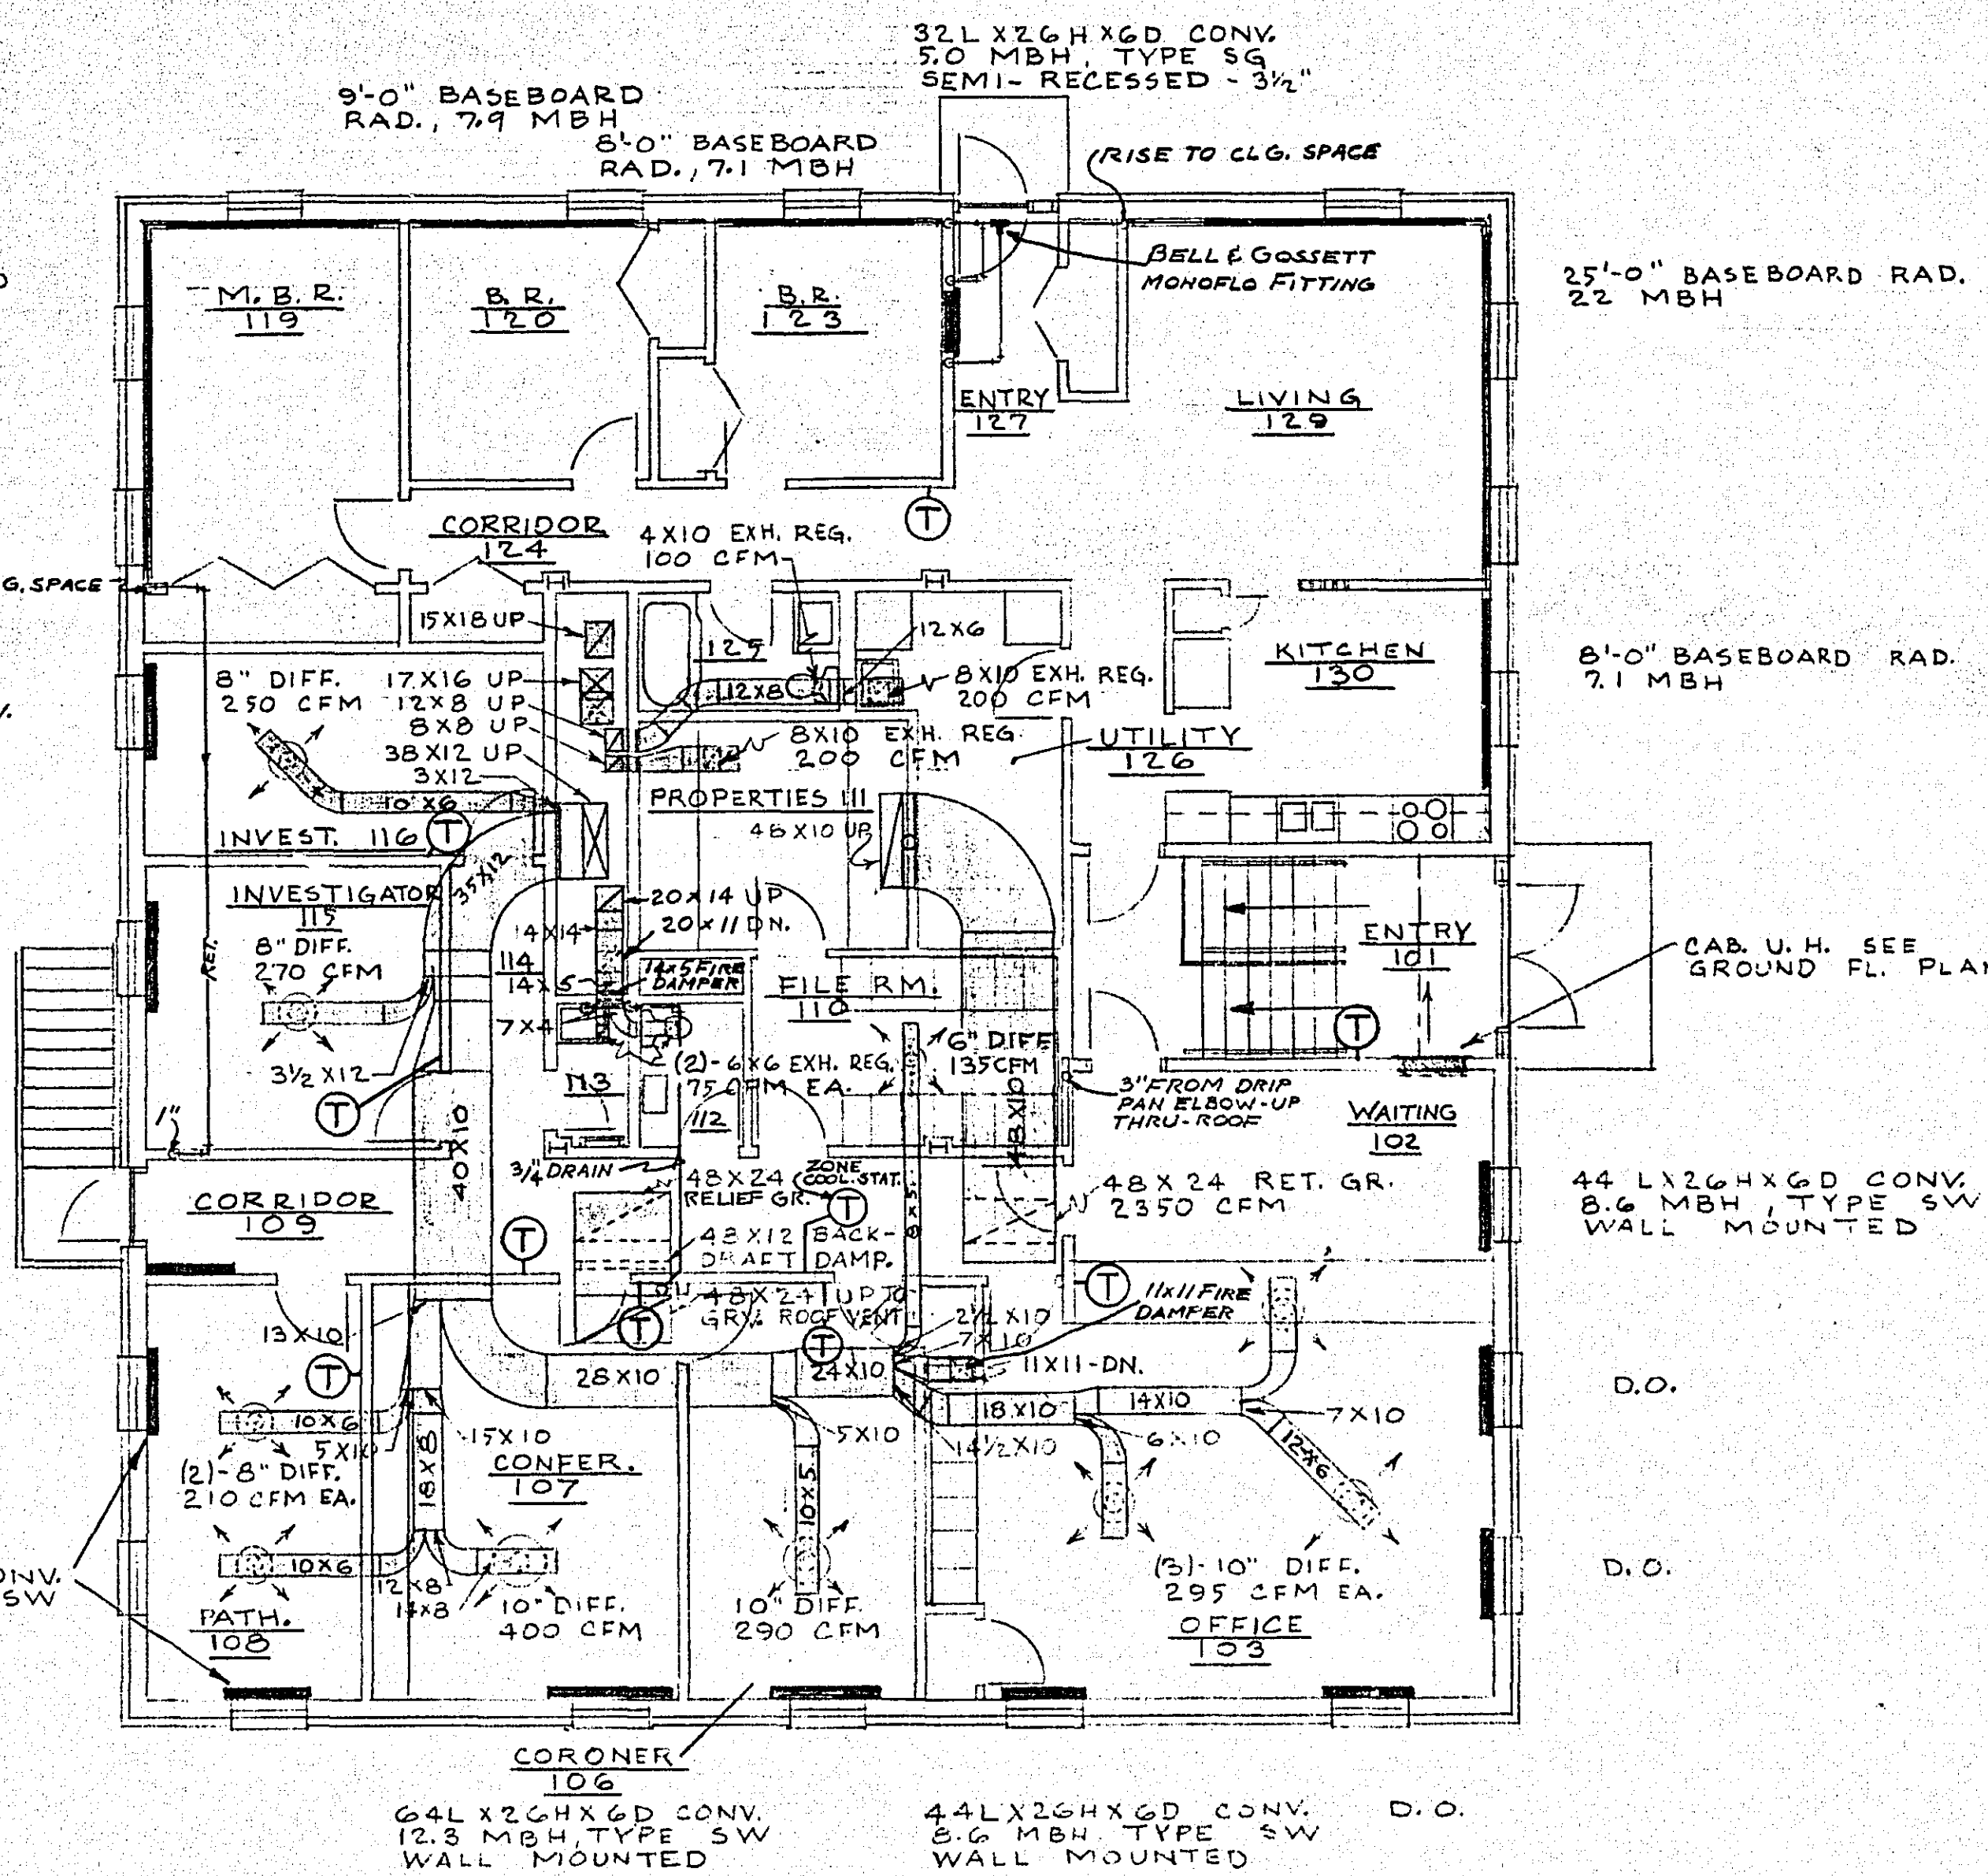


FIRST FLOOR PLAN
SCALE: 1/8" = 1'-0"

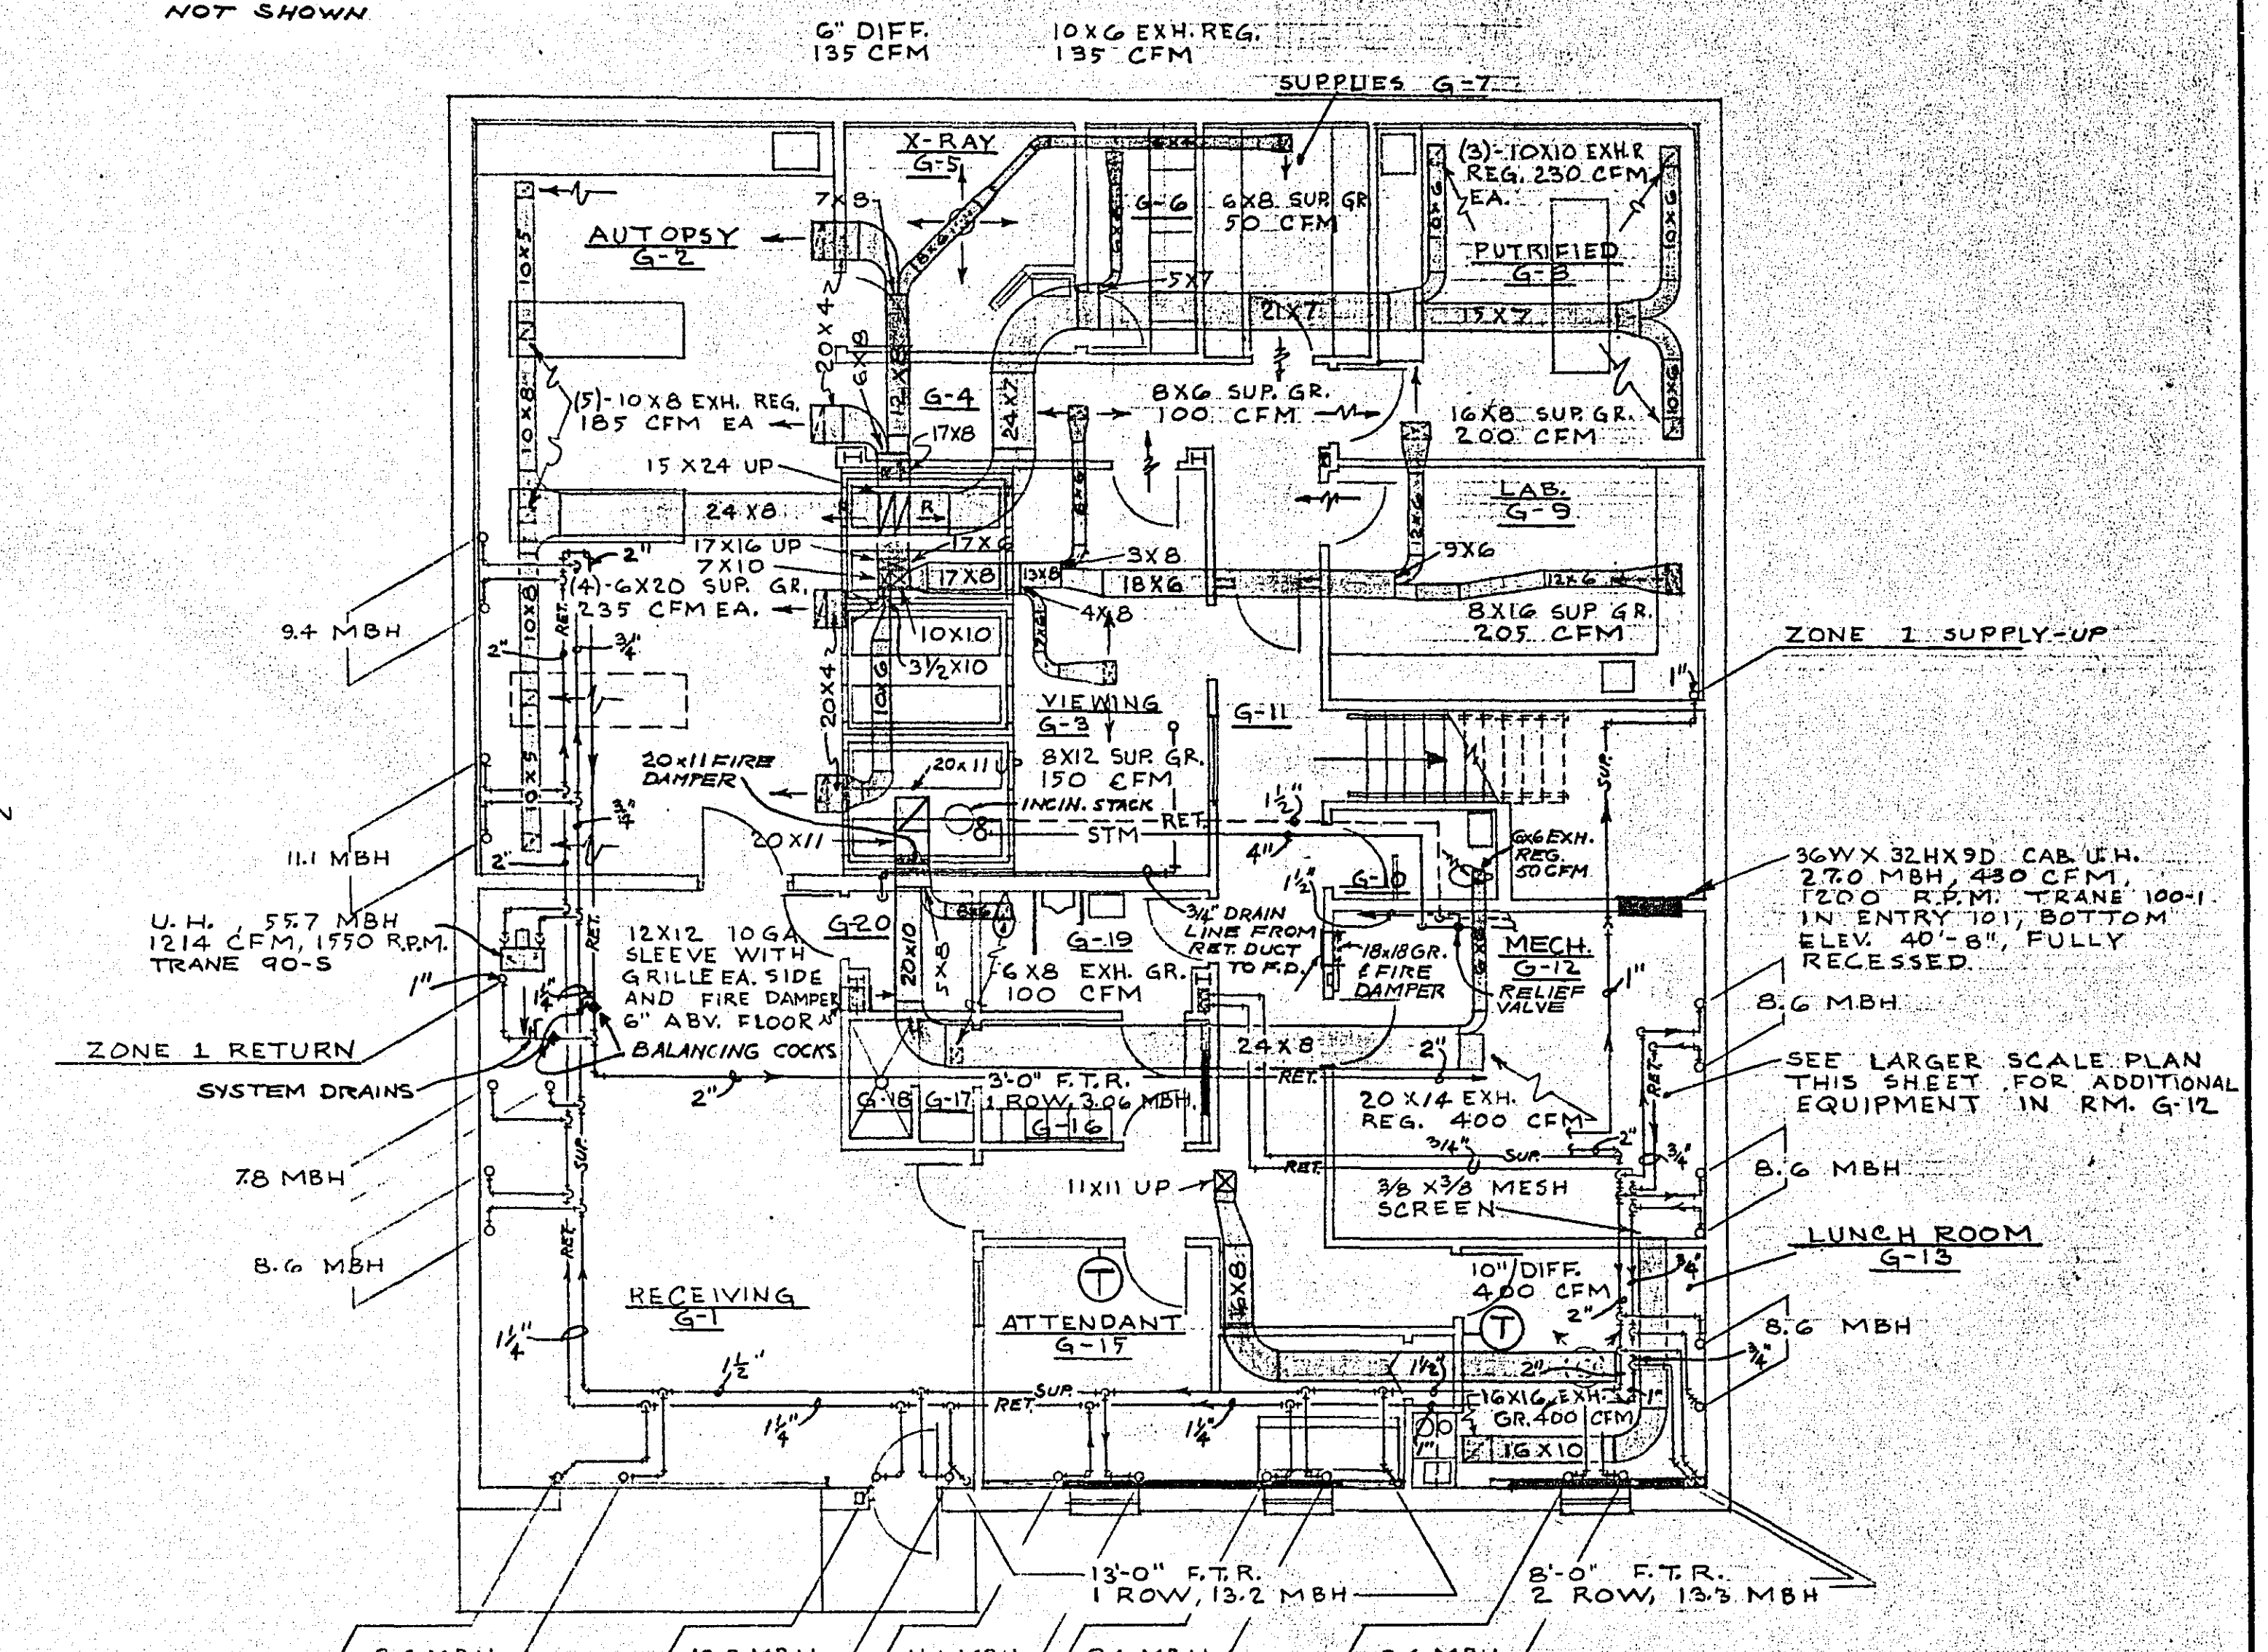

GROUND FLOOR PLAN
SCALE: 1/8" = 1'-0"

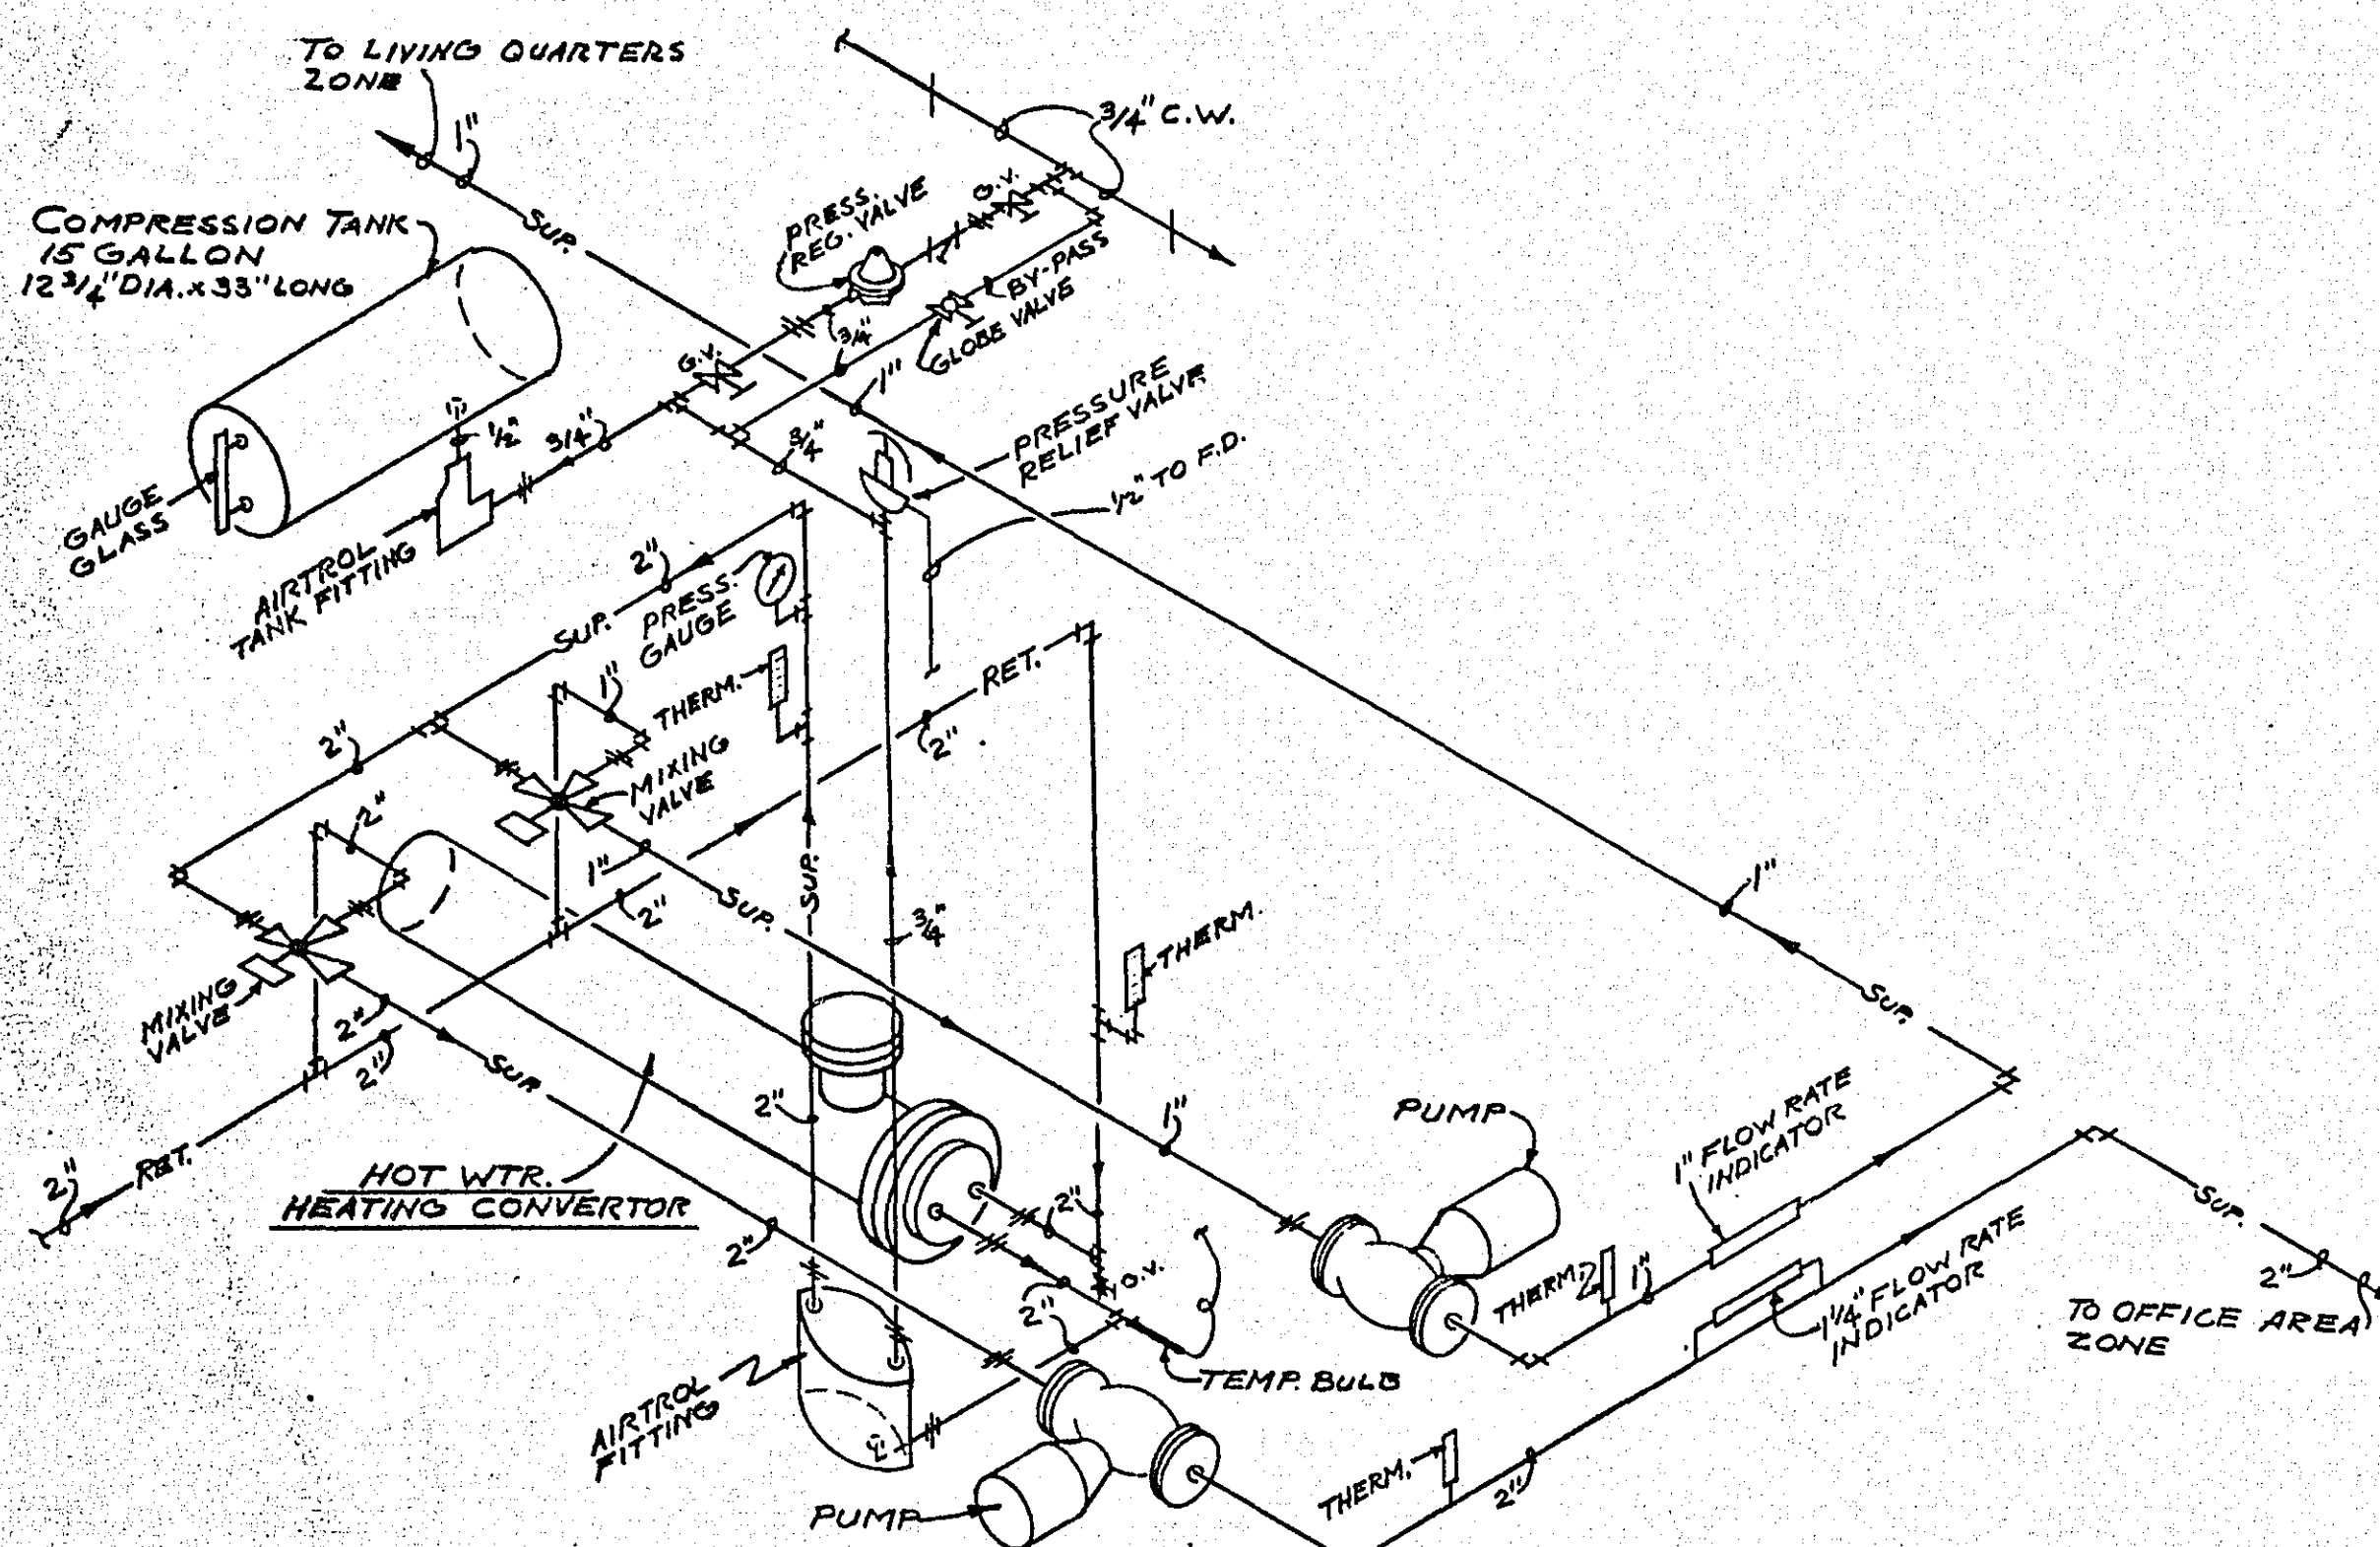

HOT WATER HEATING ISOMETRIC
NO SCALE

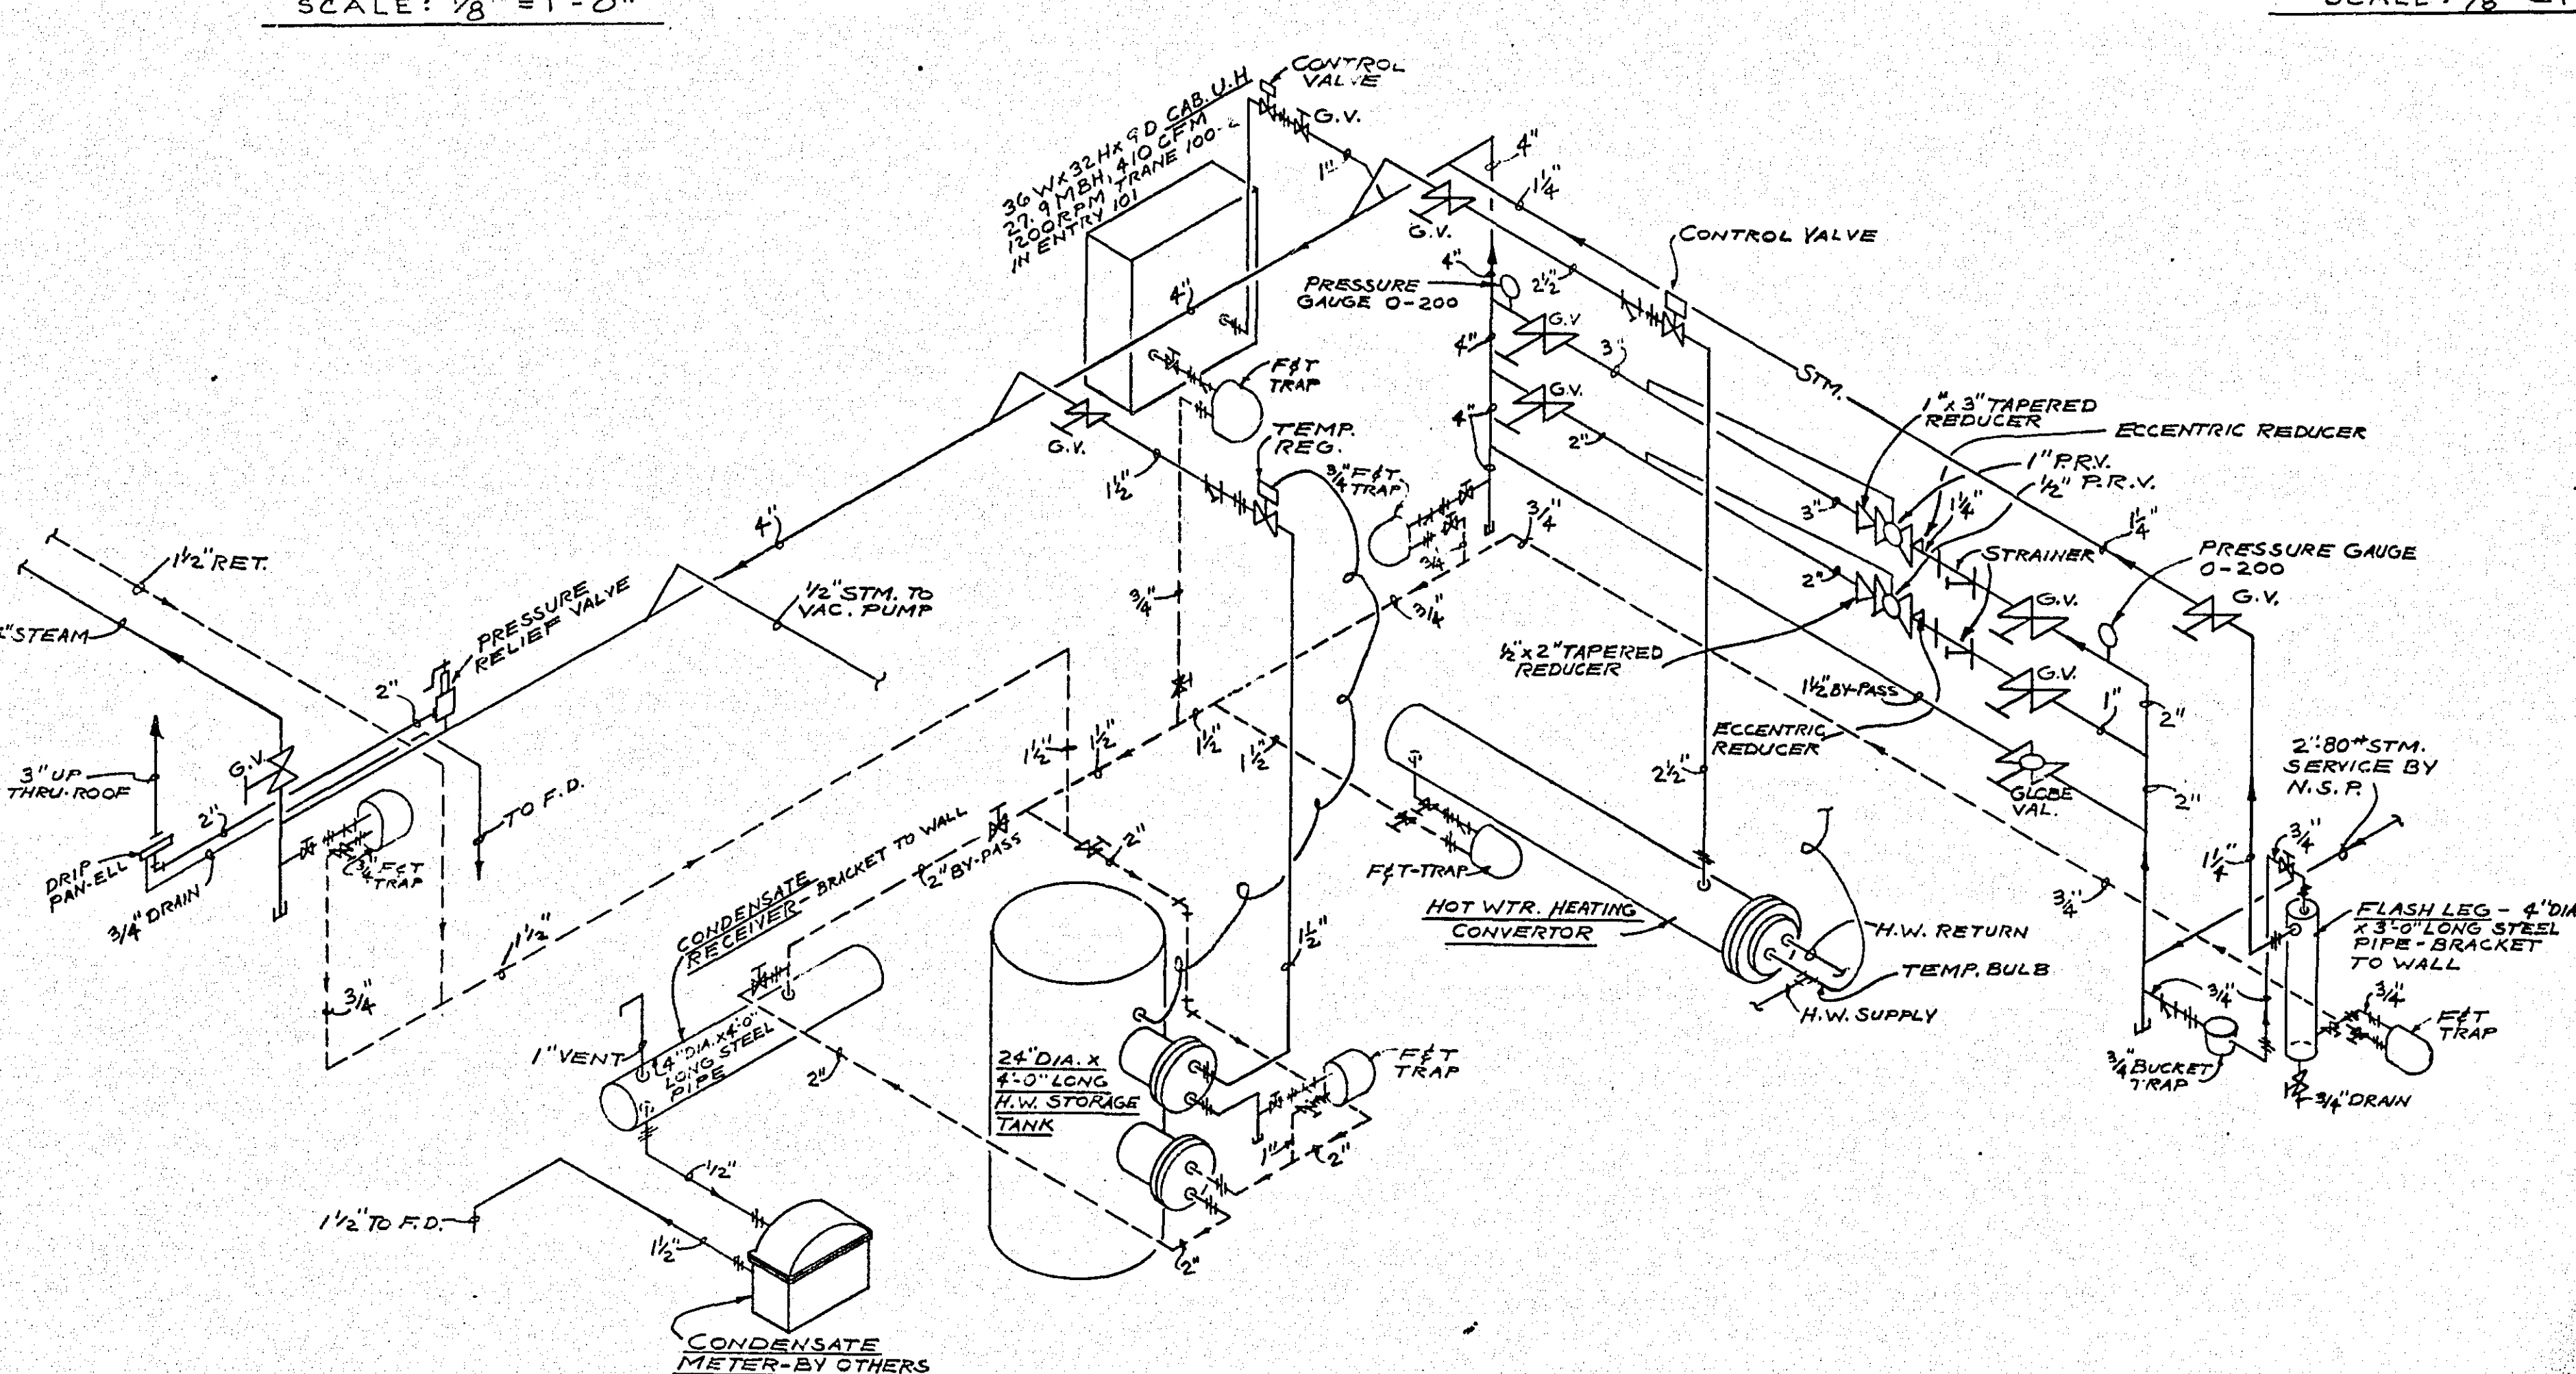

STEAM PIPING ISOMETRIC
NO SCALE

- NOTES:
- SEE DWG. M-3 FOR PENTHOUSE PLAN AND DETAILS.
 - ALL PIPING & DUCTWORK TO RUN CONCEALED IN PURRED CEILING SPACE EXCEPT AS OTHERWISE INDICATED.
 - CUT "U" SLOTS IN RADIATION COVERS FOR PIPING RISERS.

HEATING & VENTILATING

RAMSEY COUNTY CORONERS OFFICE

ST. PAUL, MINNESOTA

TOLTZ, KING, DUVALL, ANDERSON
AND ASSOCIATES, INC.

ST. PAUL, MINNESOTA
ENGINEERS AND ARCHITECTS

DESIGNED R.J.H.
DRAWN R.J.H.
CHECKED O.L.L.


I hereby certify that this plan was prepared by me or under my direct supervision and that I am a duly Registered PROFESSIONAL ENGINEER under the laws of the State of Minnesota.

O. L. L. J. J.


DATE OCTOBER 7, 1983 Reg. No. 2303

COM. 4603
D.B. M-1


NOTE: THE LOUVERS ARE FURNISHED BY THE GEN. CONTR. WITH METAL AND INSULATED BACK. THIS CONTRACTOR SHALL CUT THE BACKING AS REQUIRED FOR THE DUCTS AND MAKE A WATER TIGHT CONNECTION SCREWED ON 3" CENTERS 2" SPACING RUBBER GASKET.

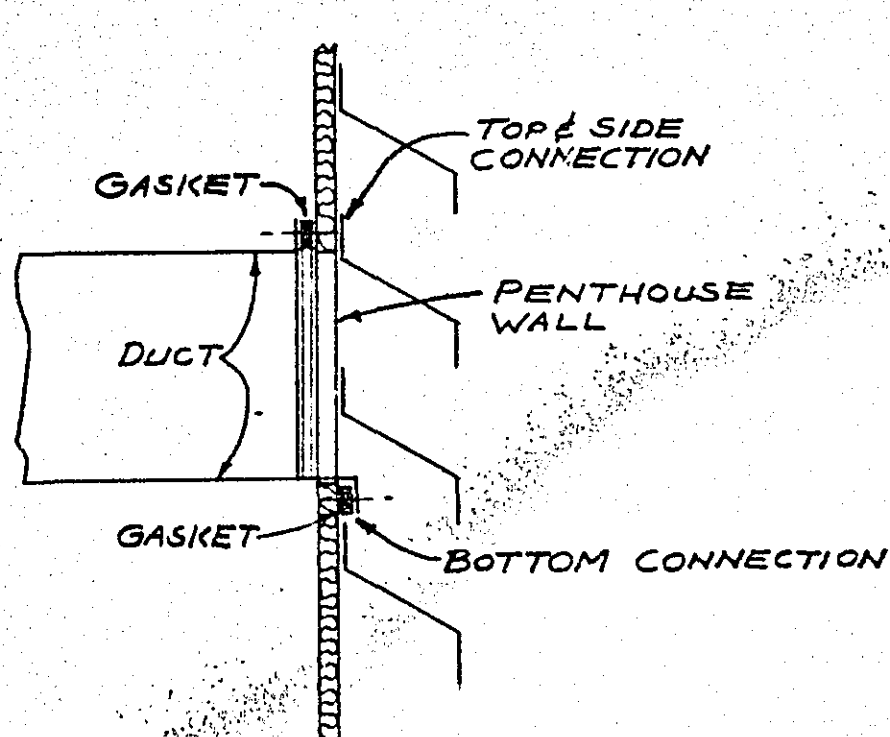


DUCT CONNECTION TO LOUVER

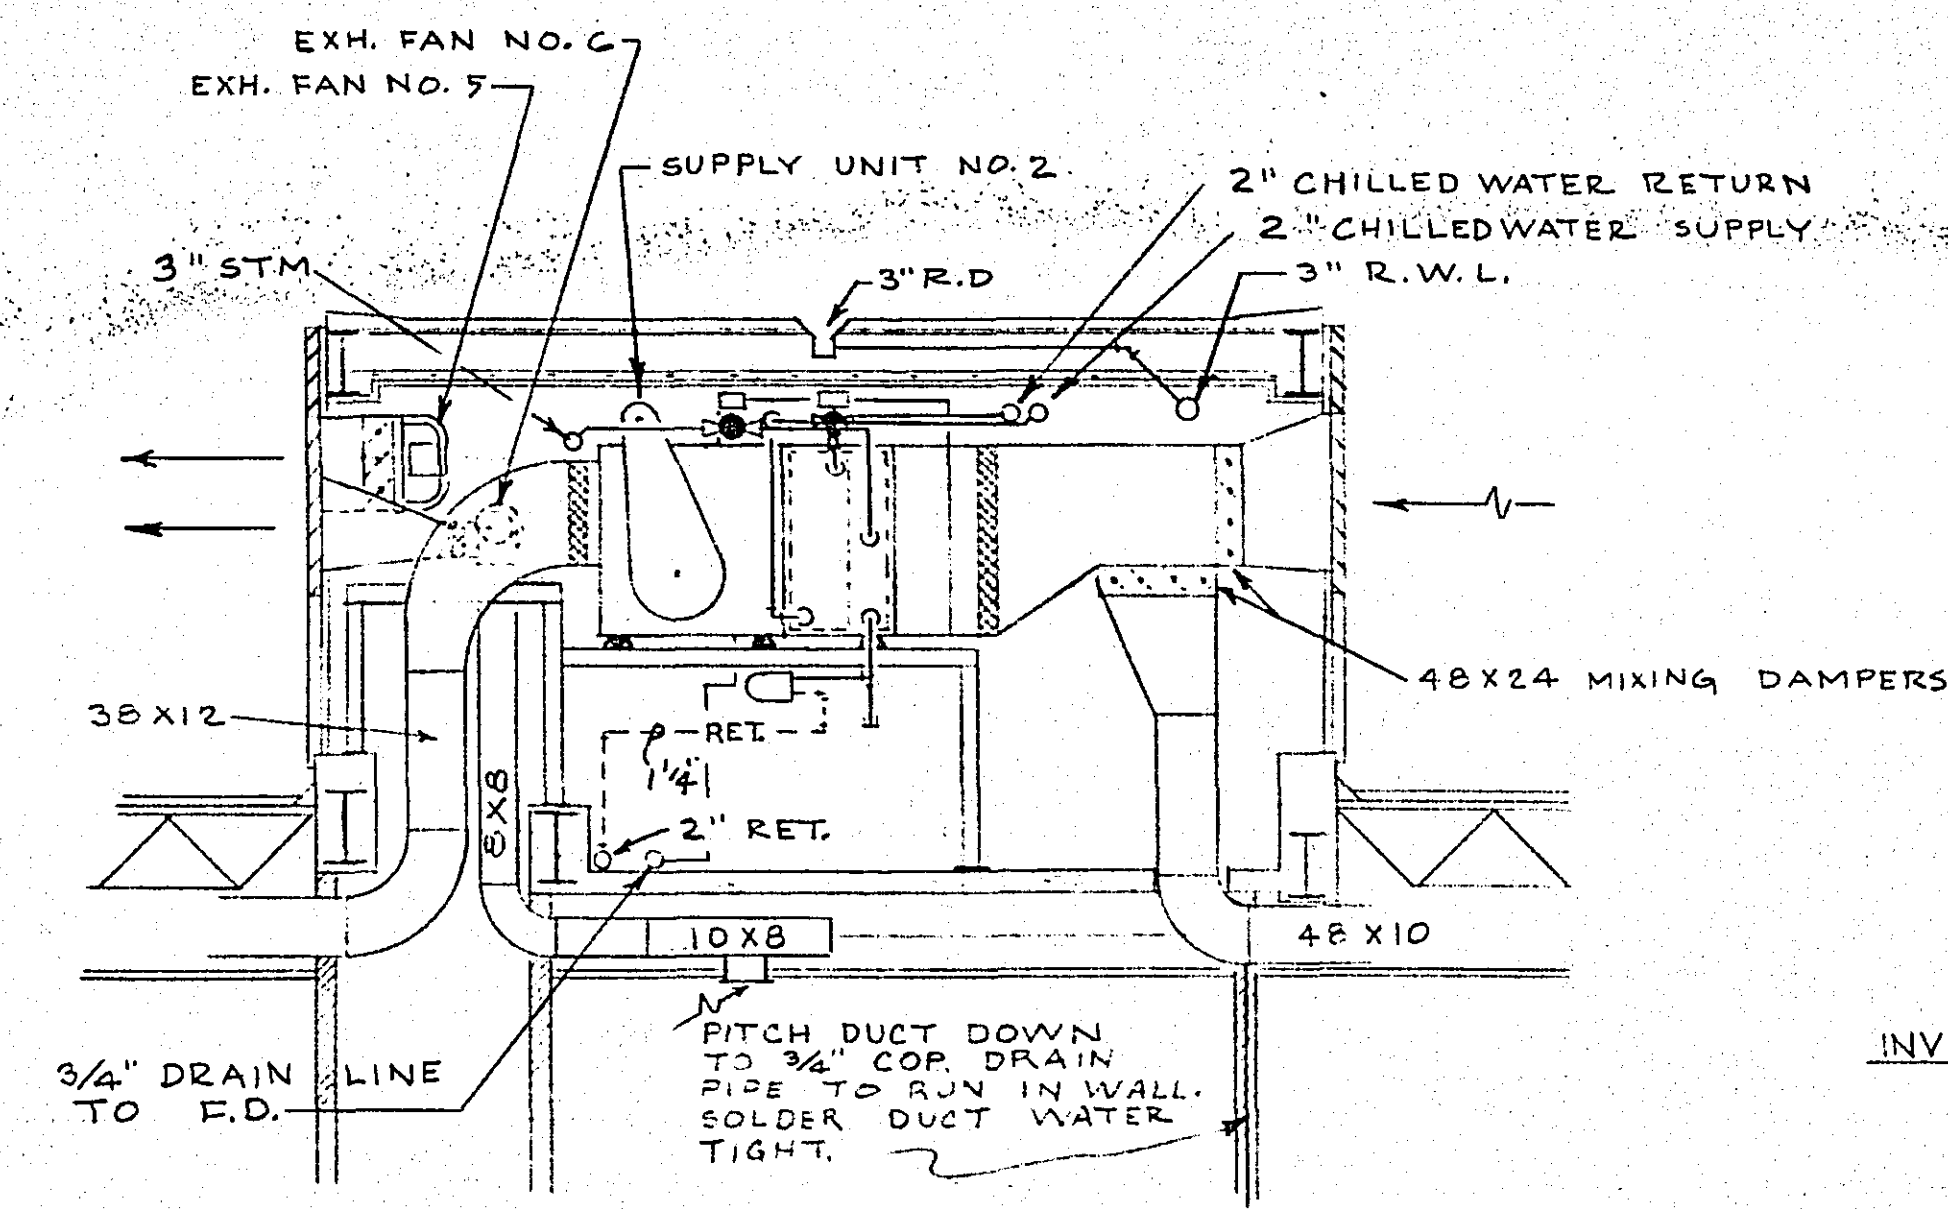


SECTION B-B
SCALE: 1/4" = 1'-0"

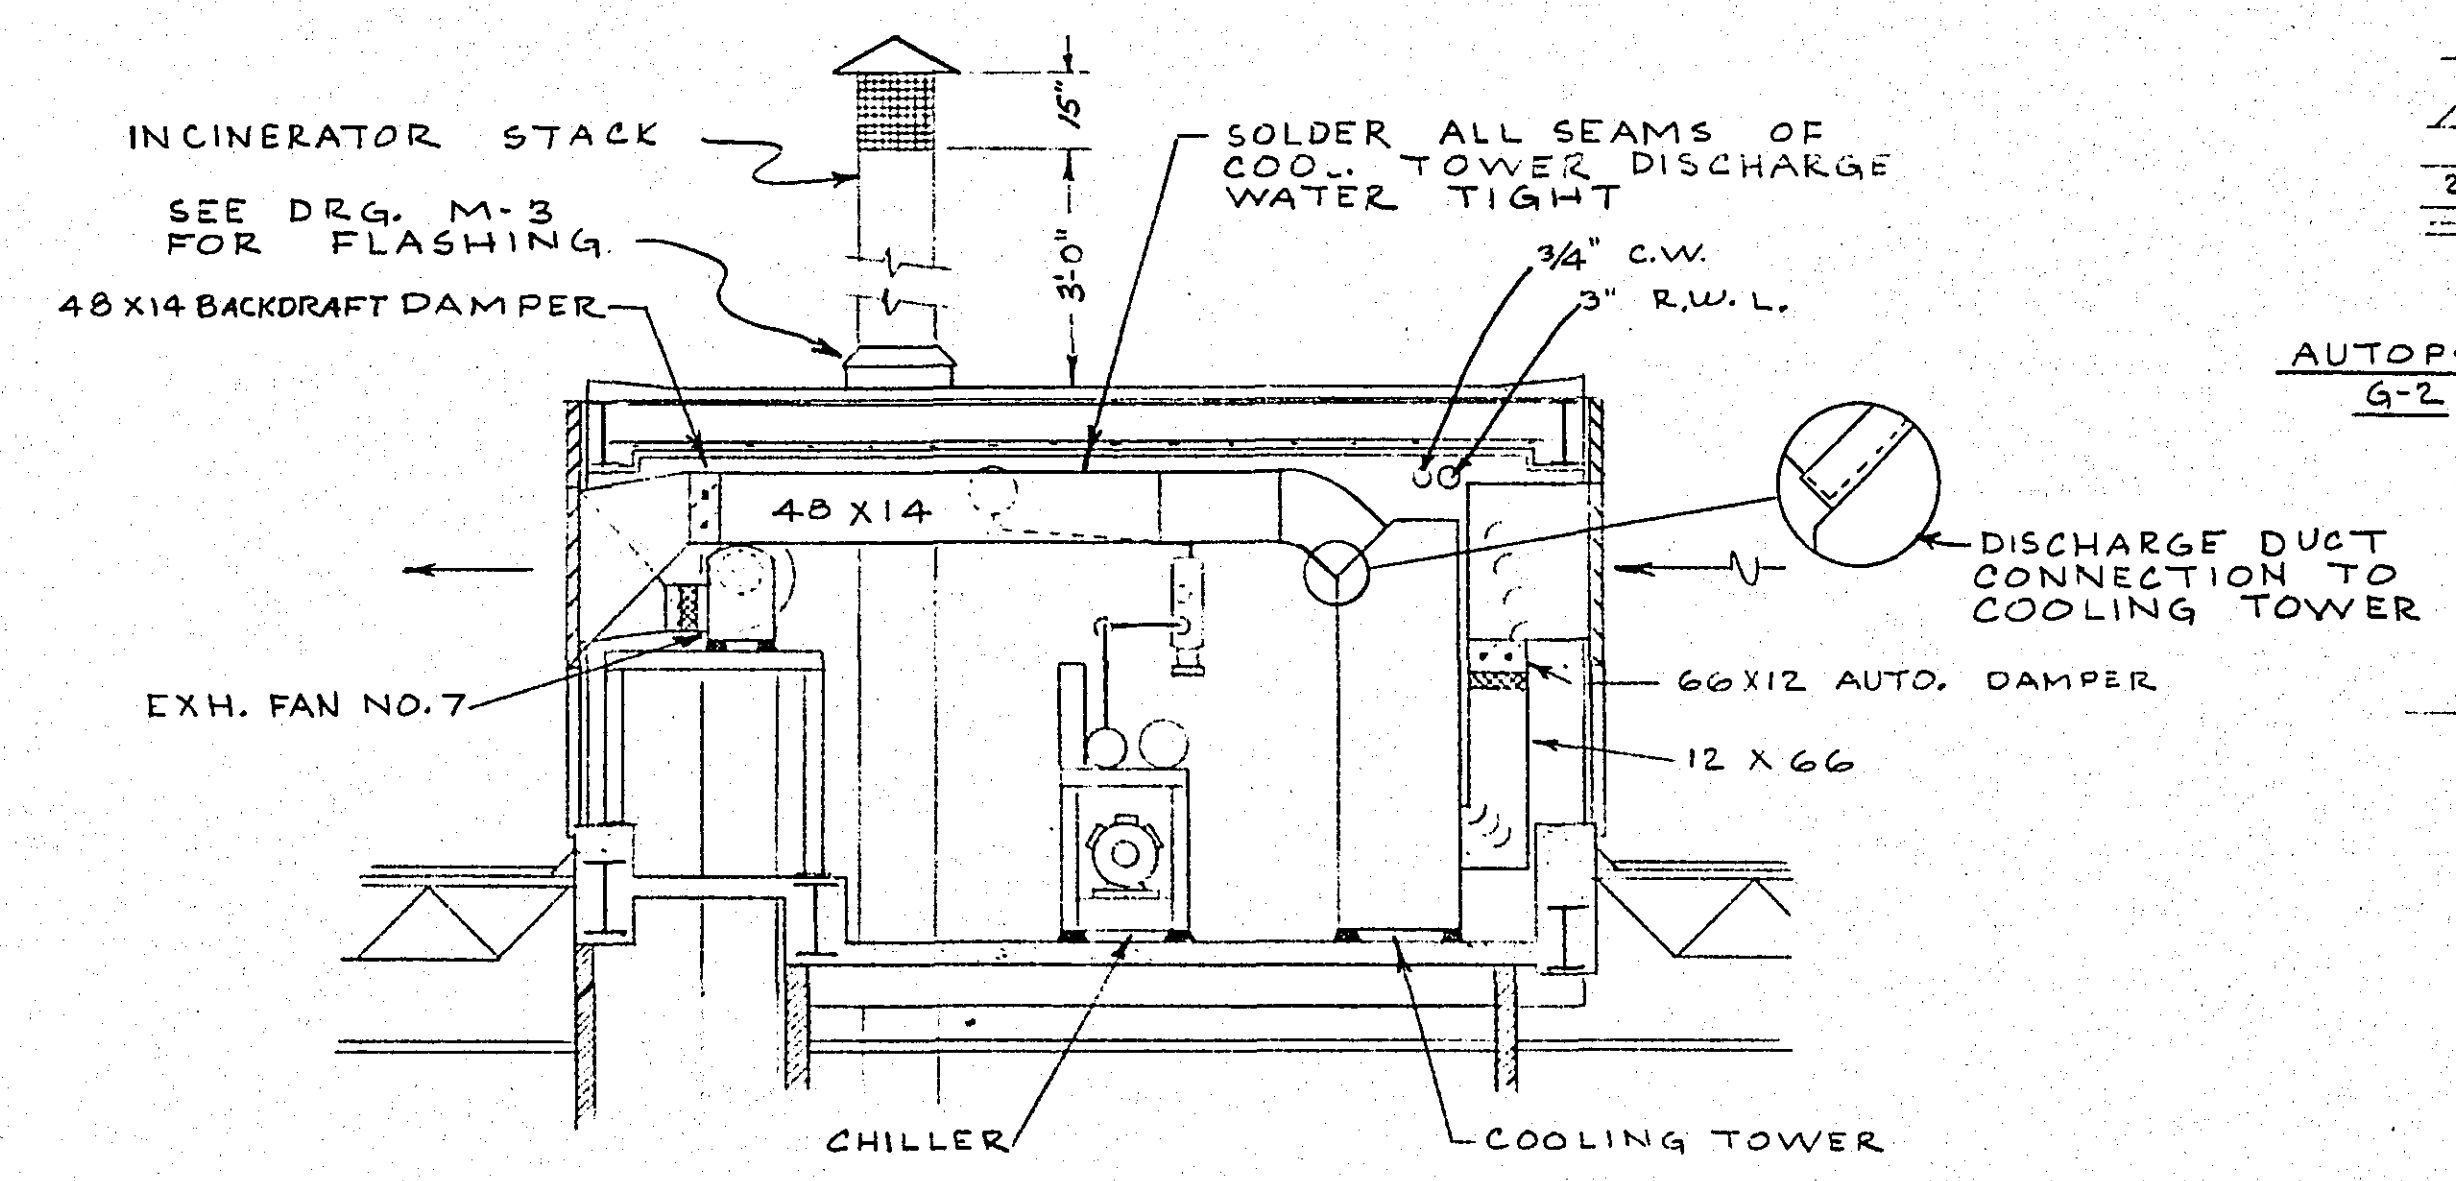


SECTION C-C
SCALE: 1/4" = 1'-0"

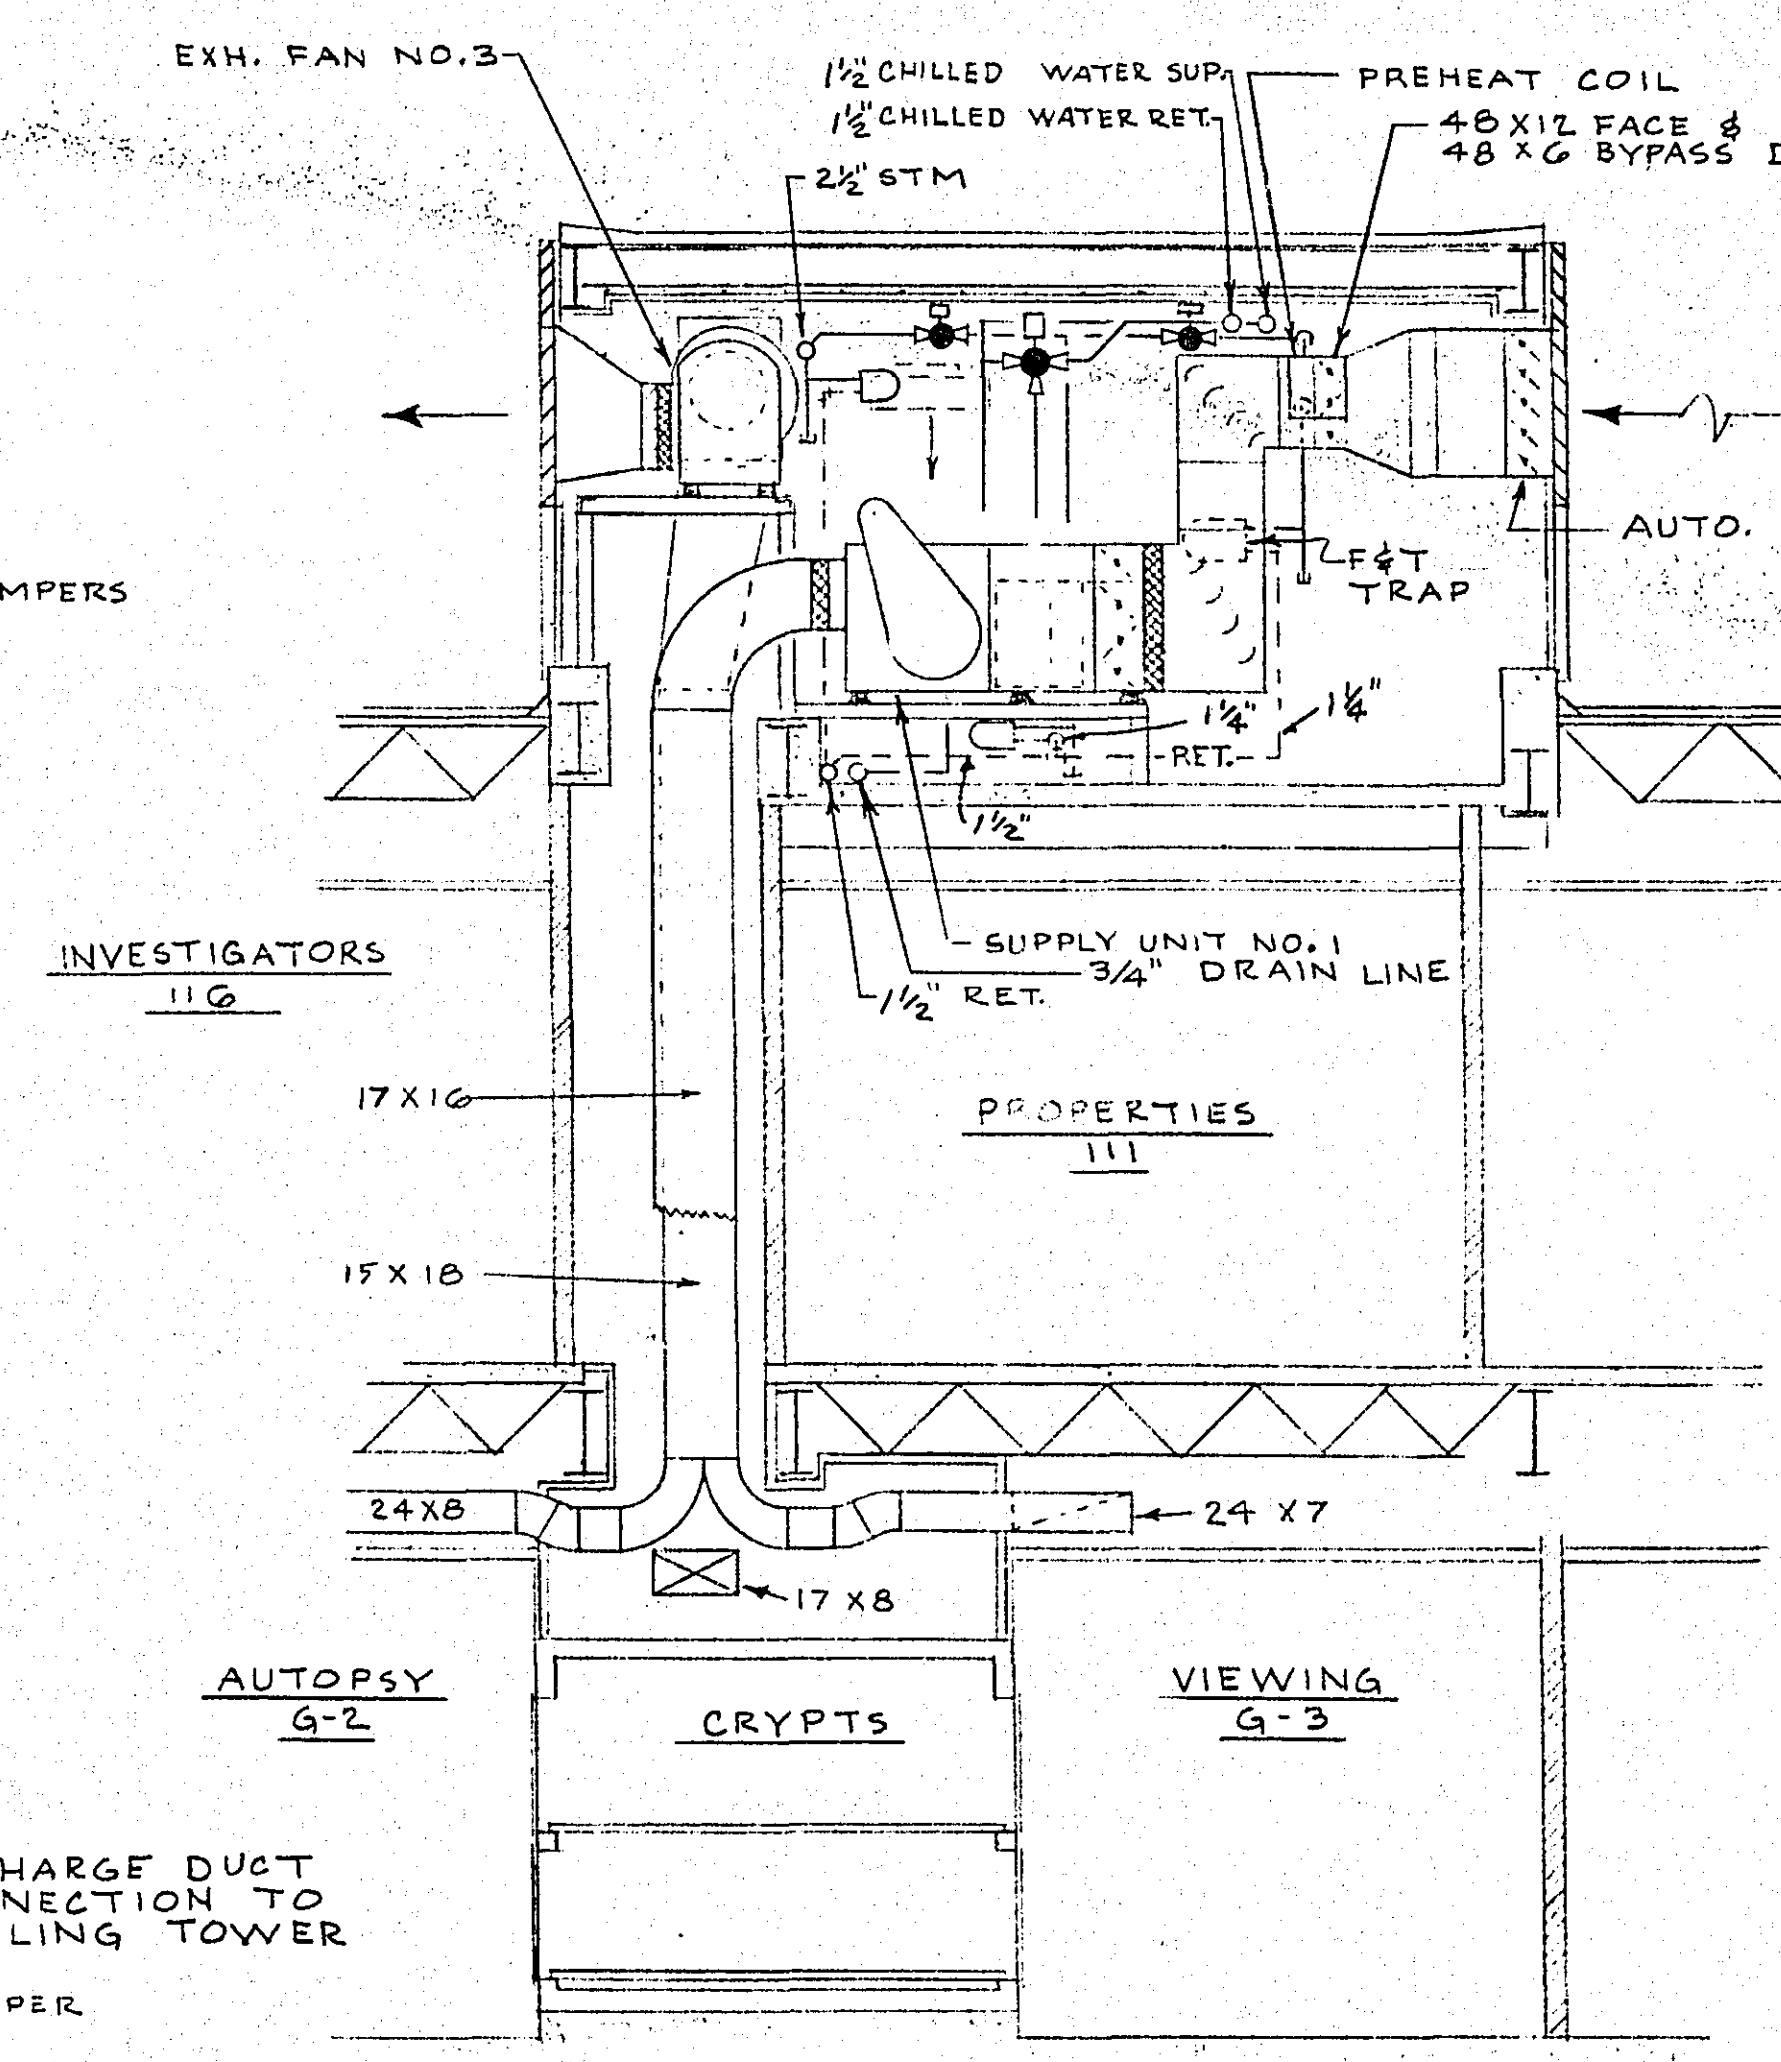


SECTION A-A
SCALE: 1/4" = 1'-0"

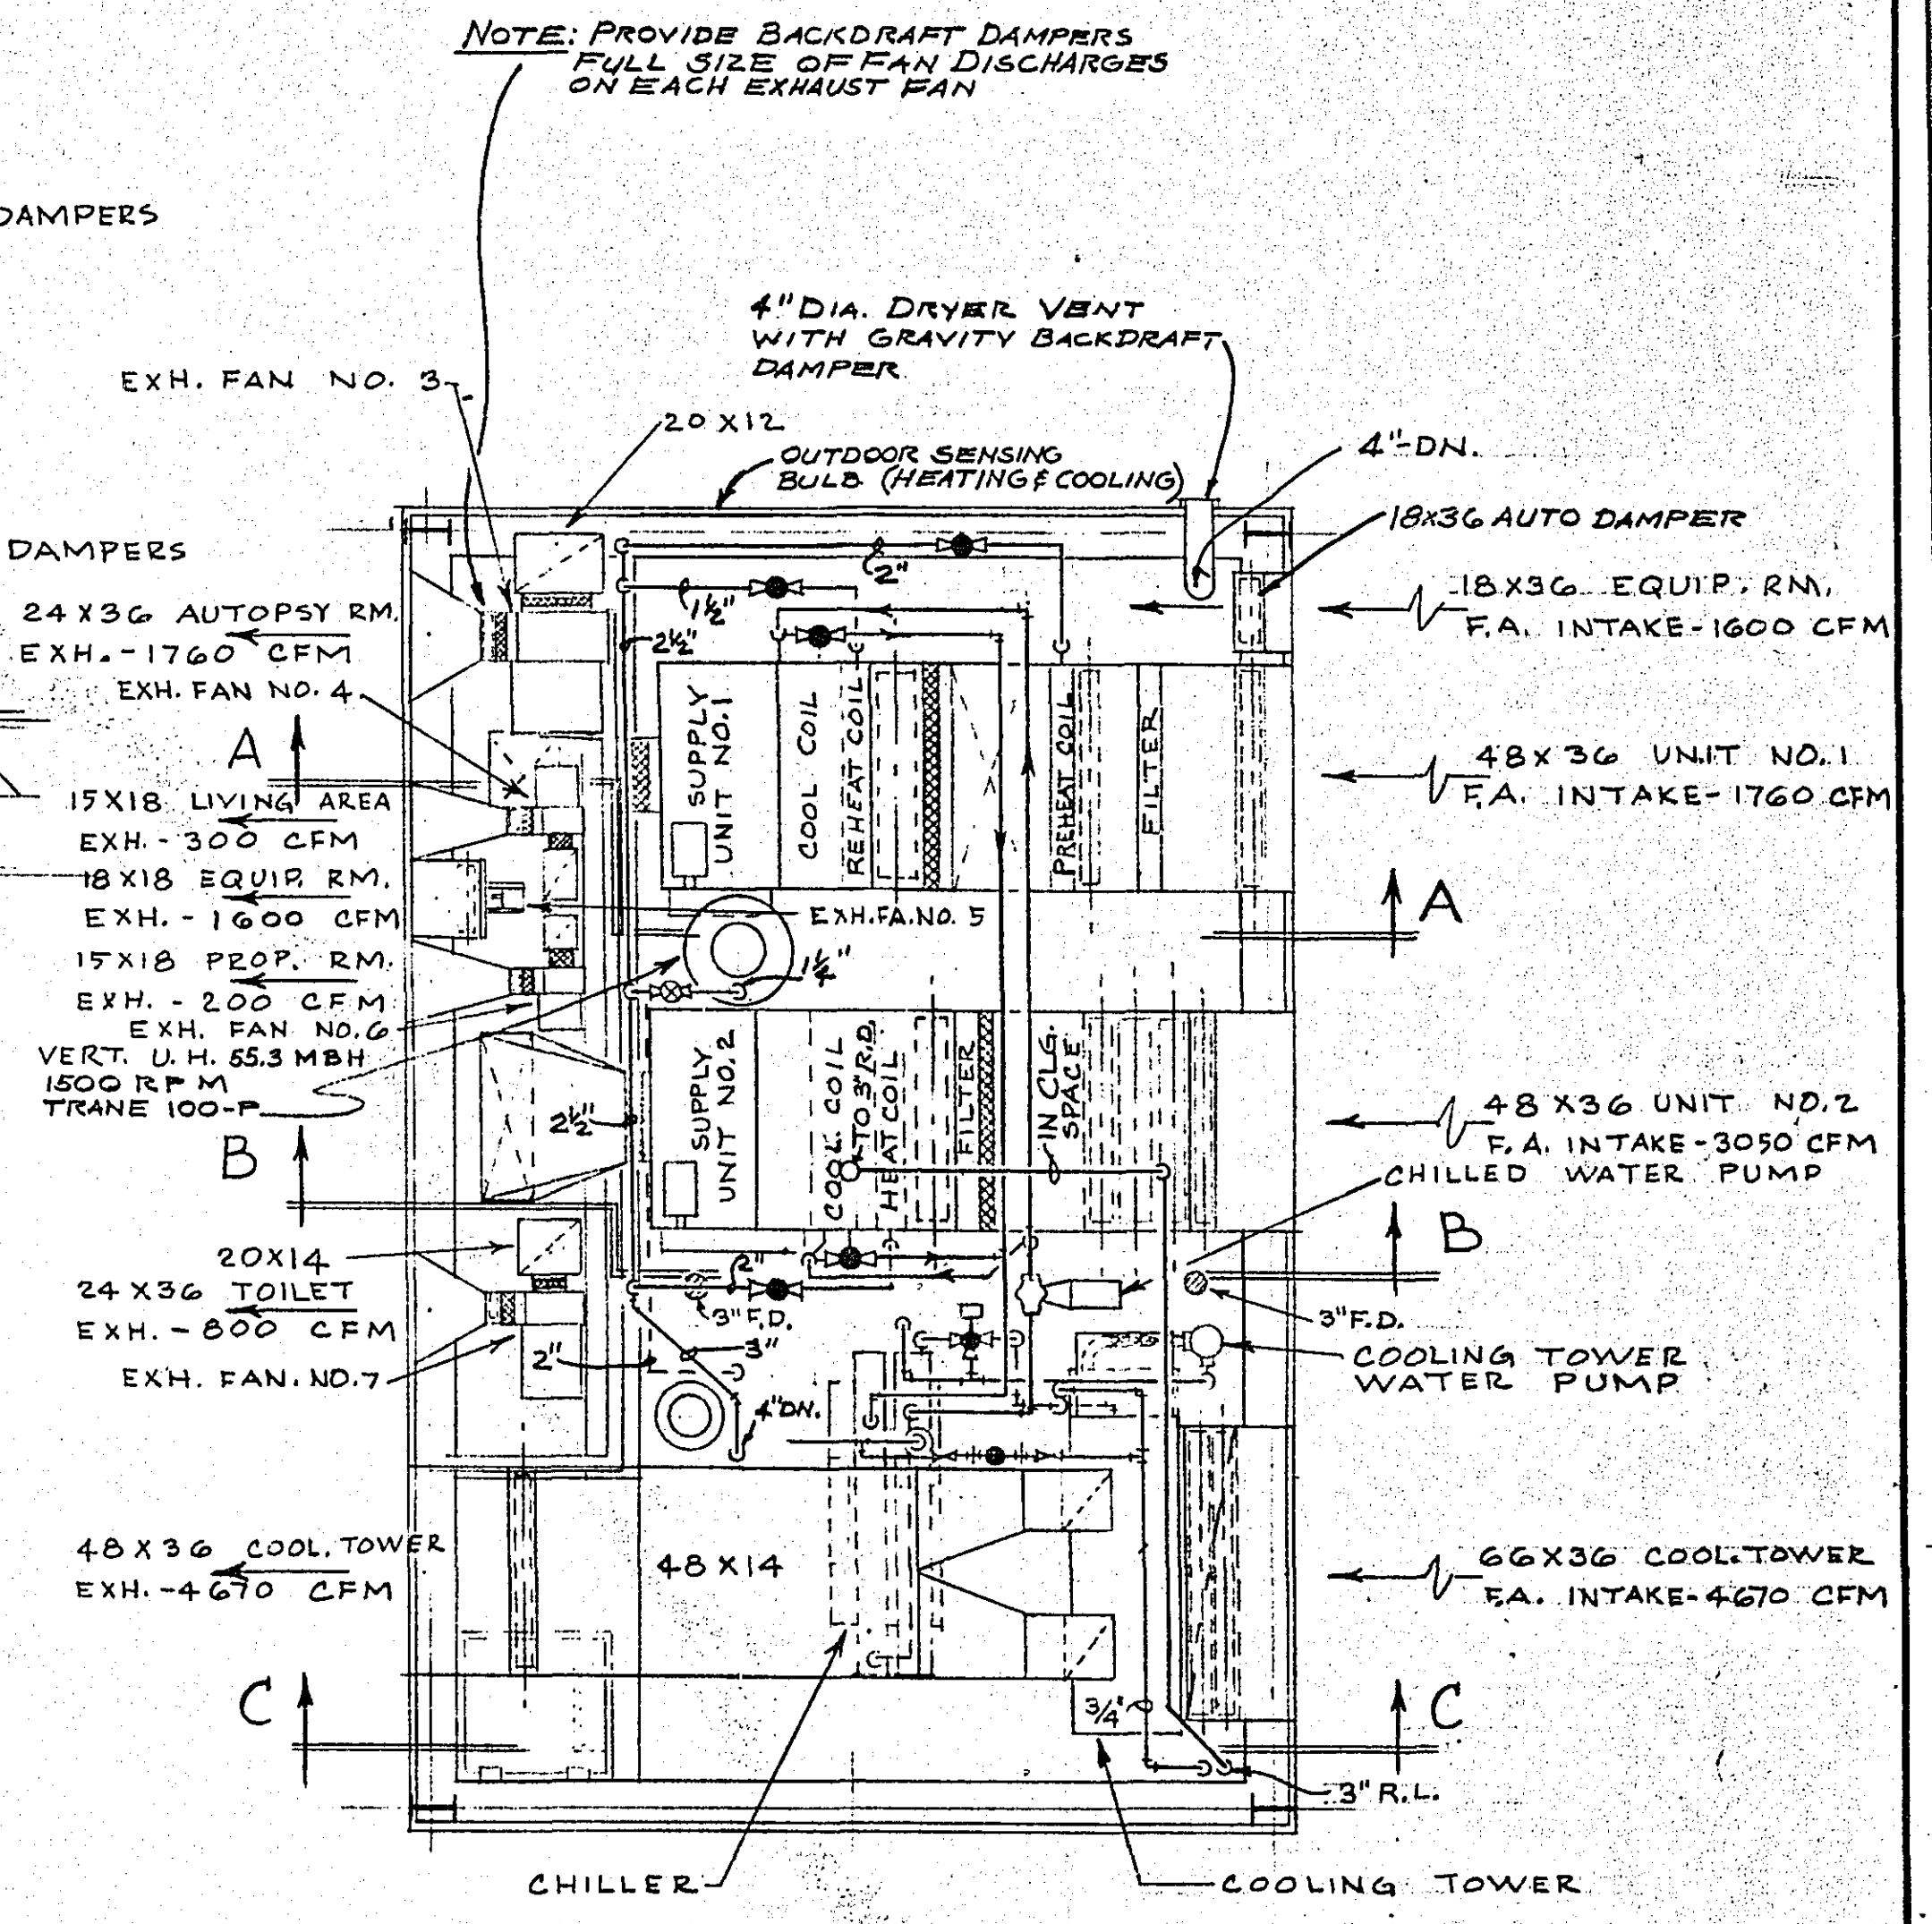


MECH. EQUIP. PENTHOUSE
SCALE: 1/4" = 1'-0"

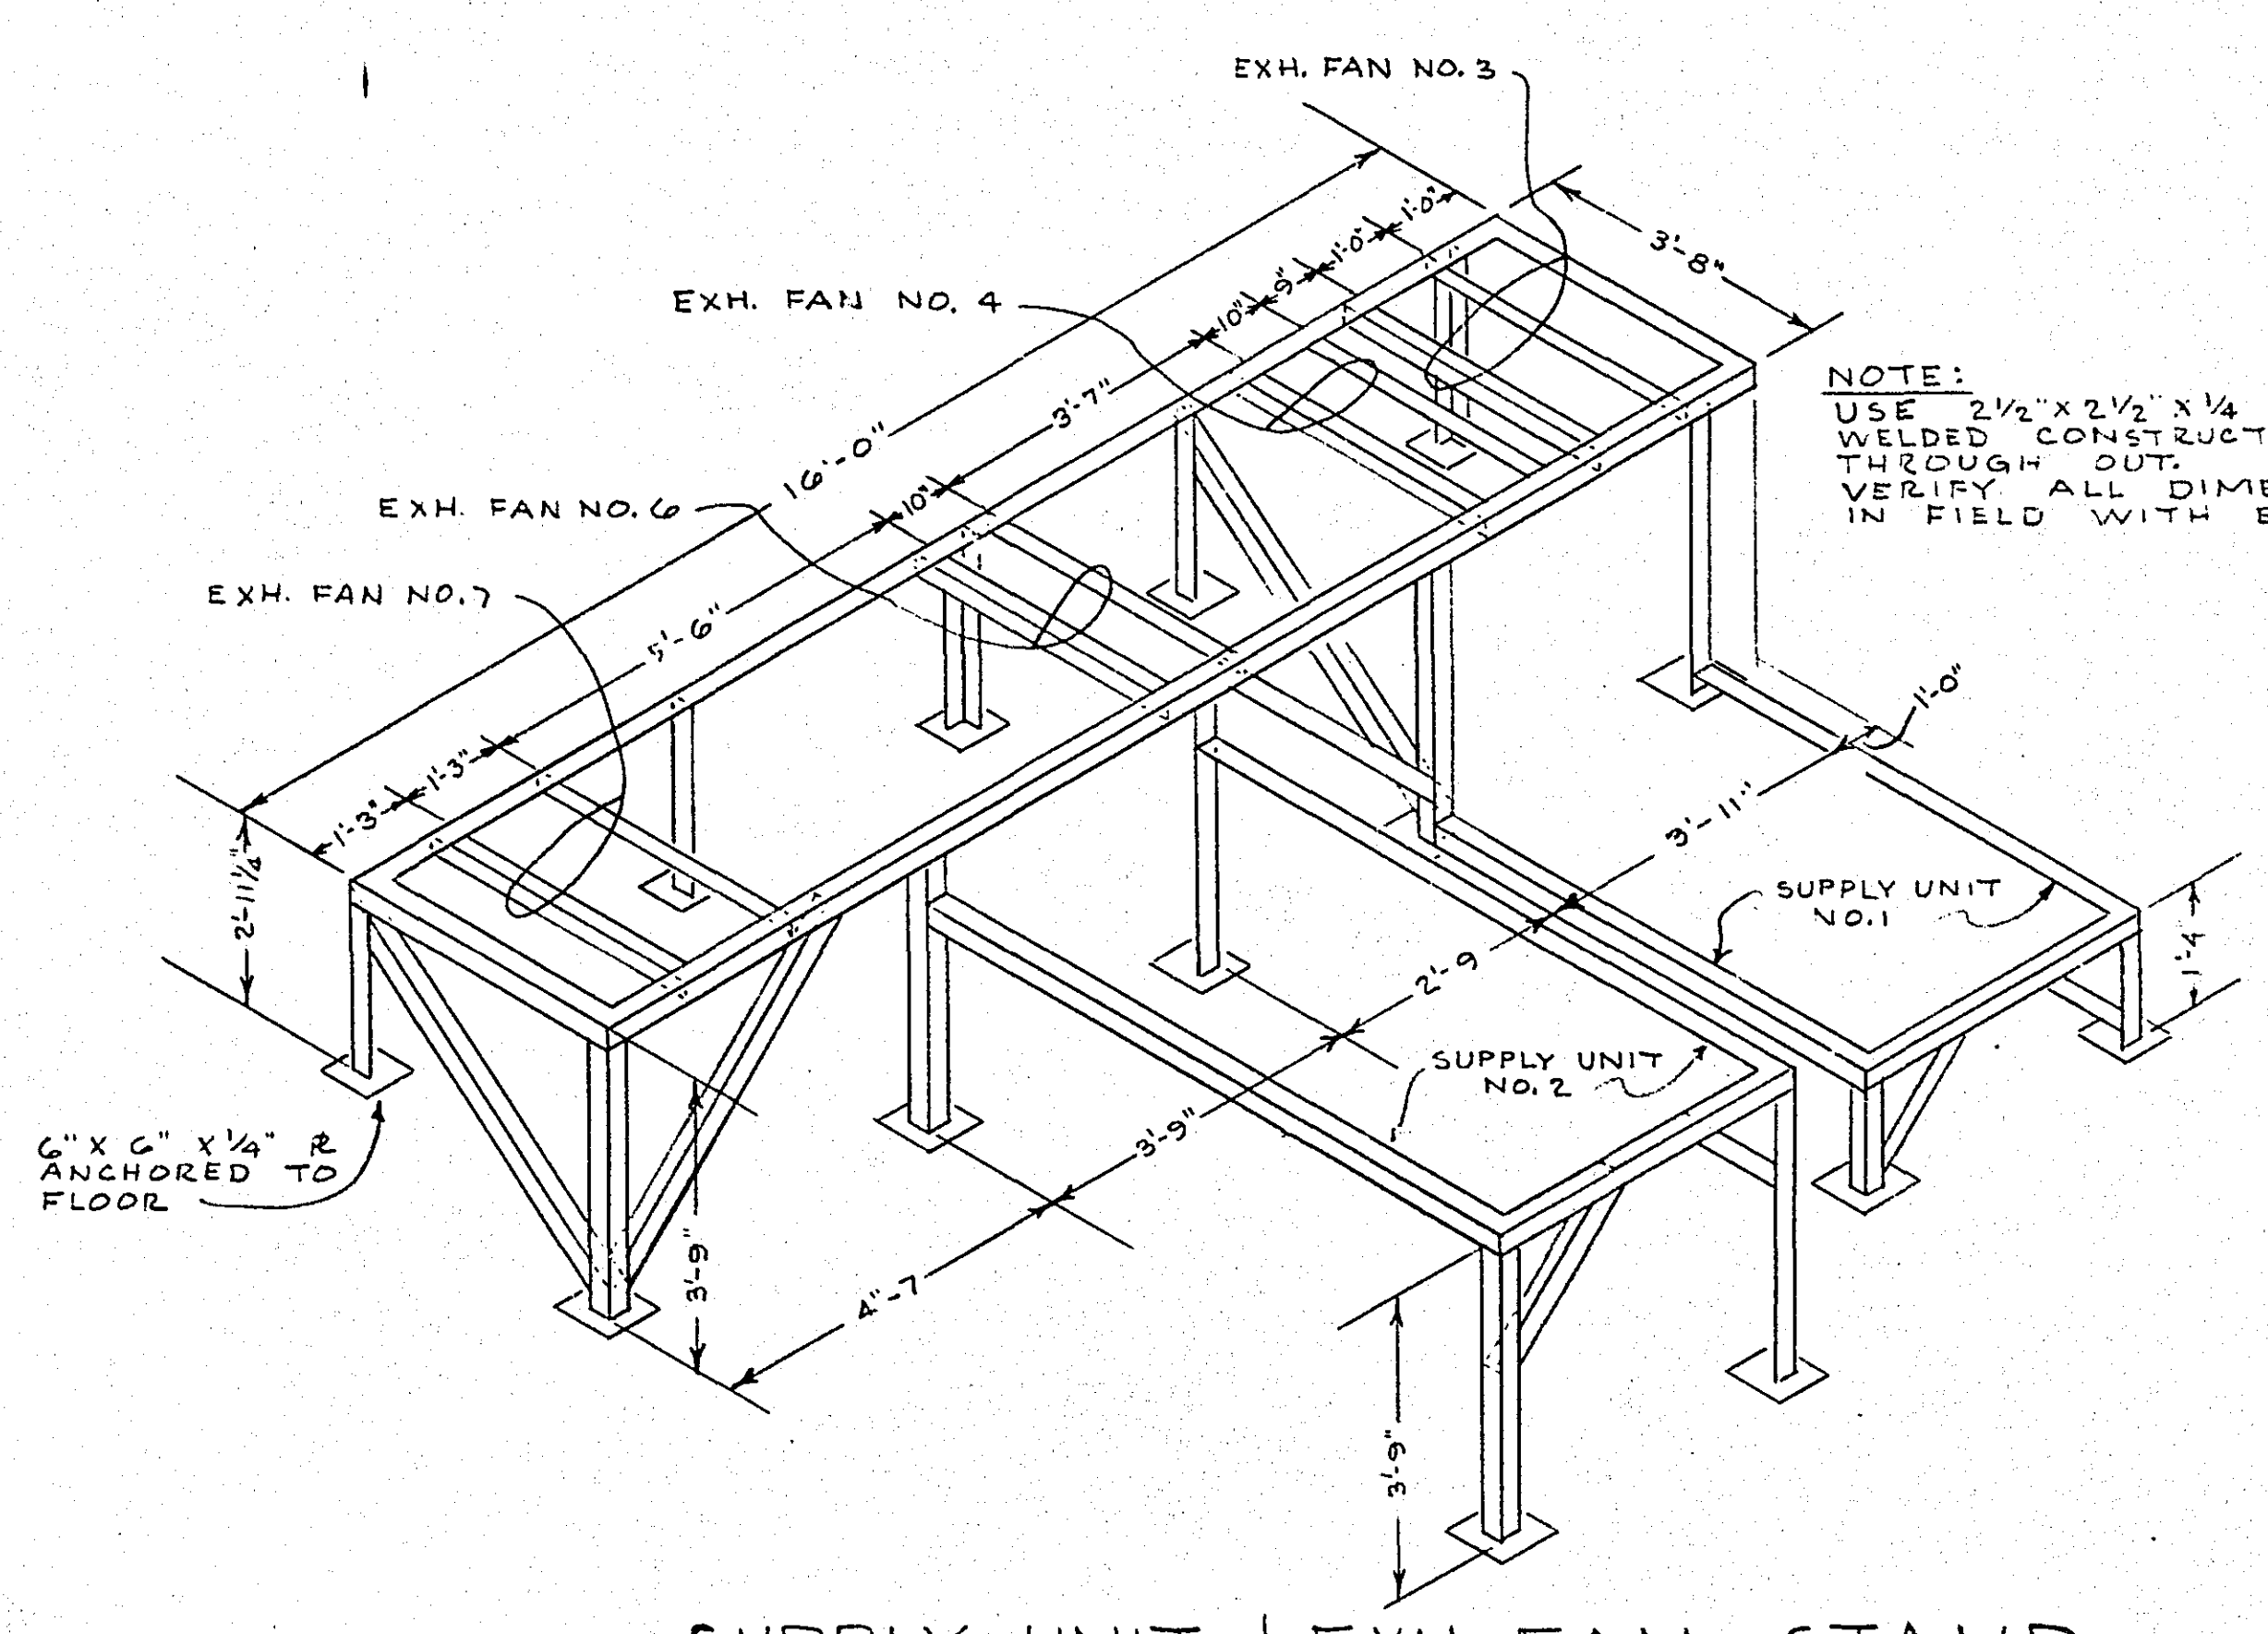

SUPPLY UNIT & EXH. FAN STAND
NO SCALE







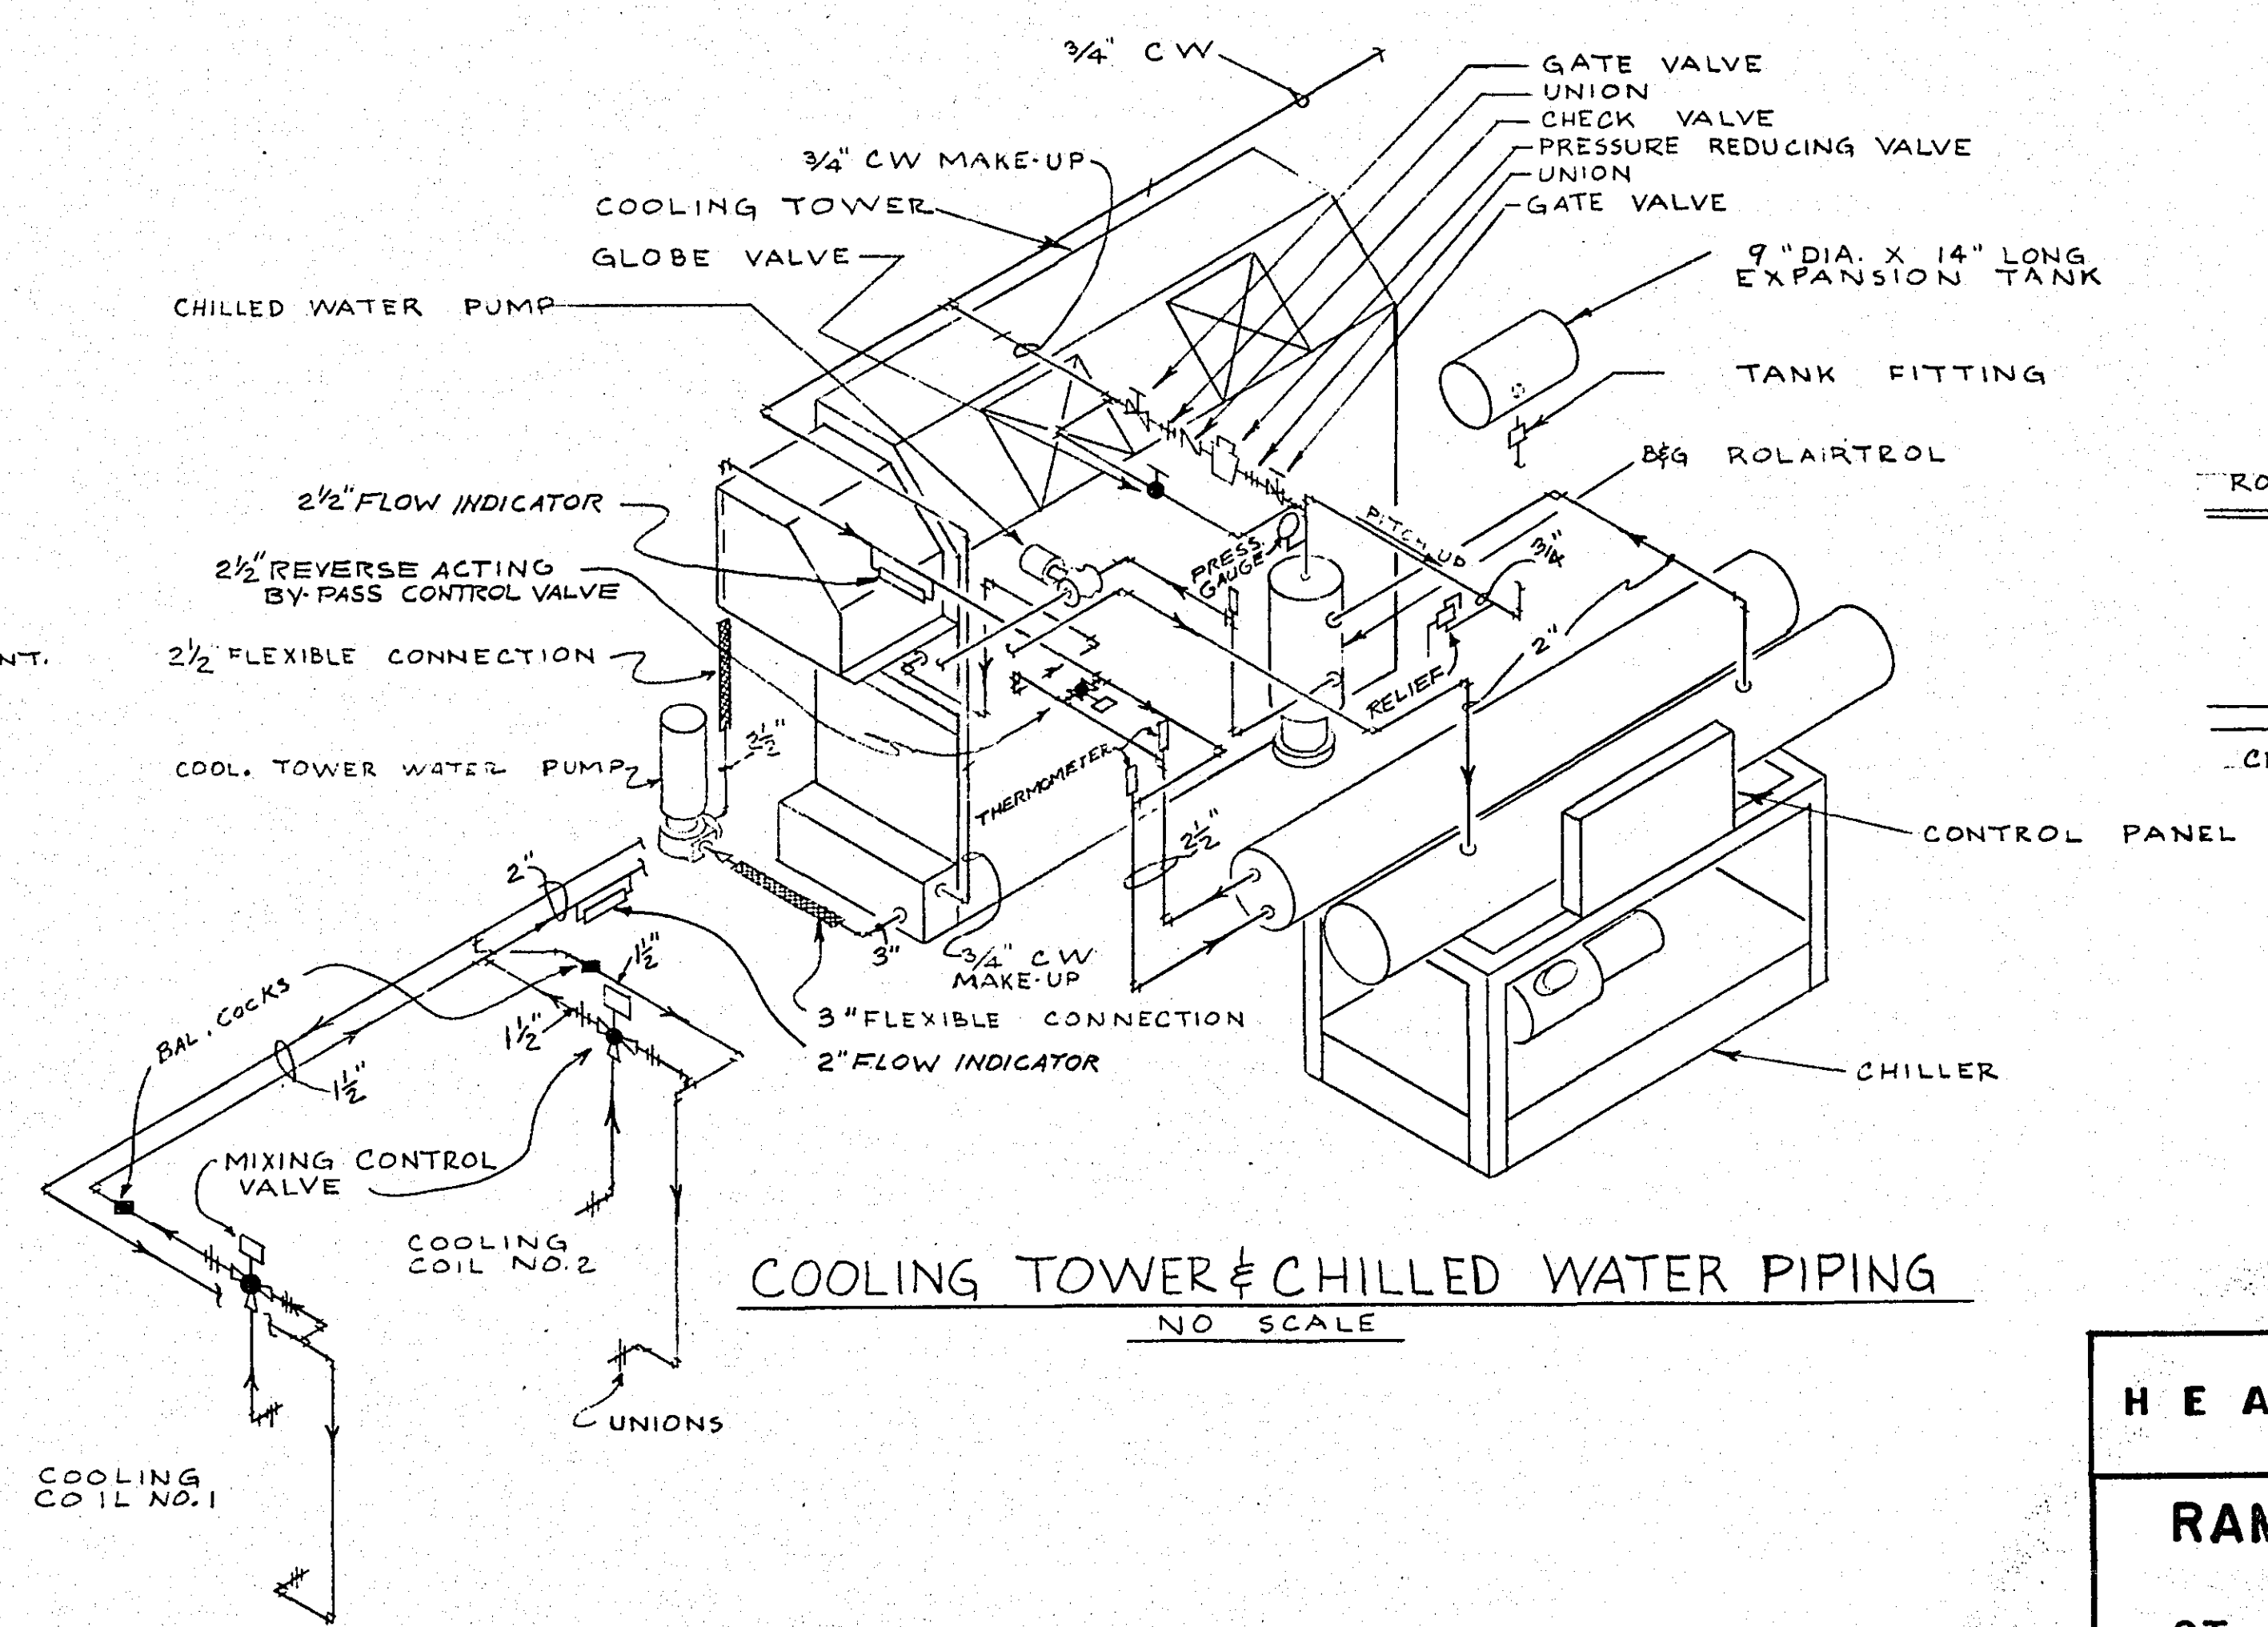


COOLING TOWER & CHILLED WATER PIPING
NO SCALE

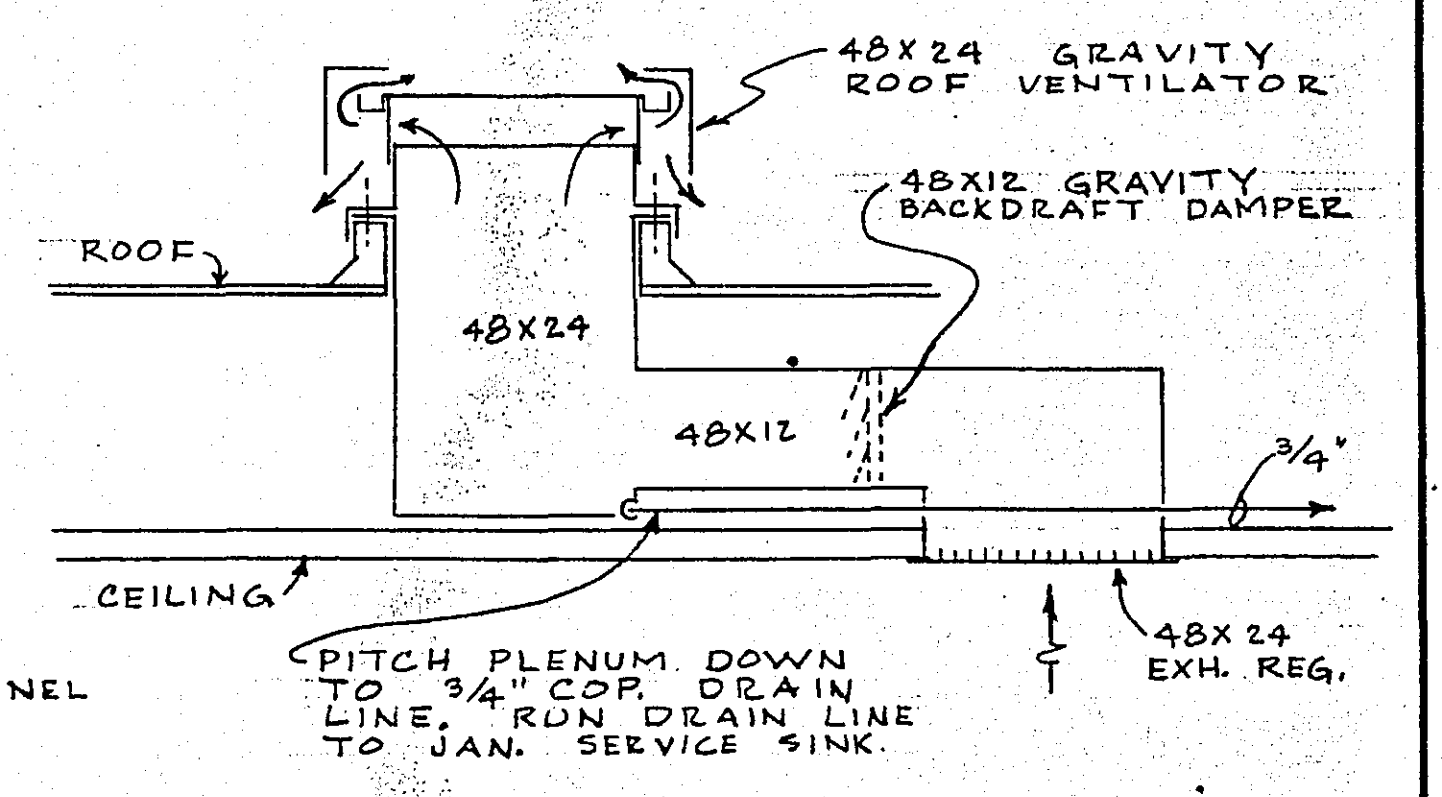

GRAVITY ROOF VENTILATOR
NO SCALE

HEATING & VENTILATING		
RAMSEY COUNTY CORONERS OFFICE		
ST. PAUL, MINNESOTA		
TOLTZ, KING, DUVAL, ANDERSON AND ASSOCIATES, INC.		
ST. PAUL, MINNESOTA ENGINEERS AND ARCHITECTS		
DESIGNED R.J.H.	I hereby certify that this plan was prepared by me or under my direct supervision and that I am a duly Registered PROFESSIONAL ENGINEER under the laws of the State of Minnesota. Date OCTOBER 7, 1963 Reg. No. 2303	COM. 4603
DRAWN R.J.H.		DRG.
CHECKED O.L.L.		M-2

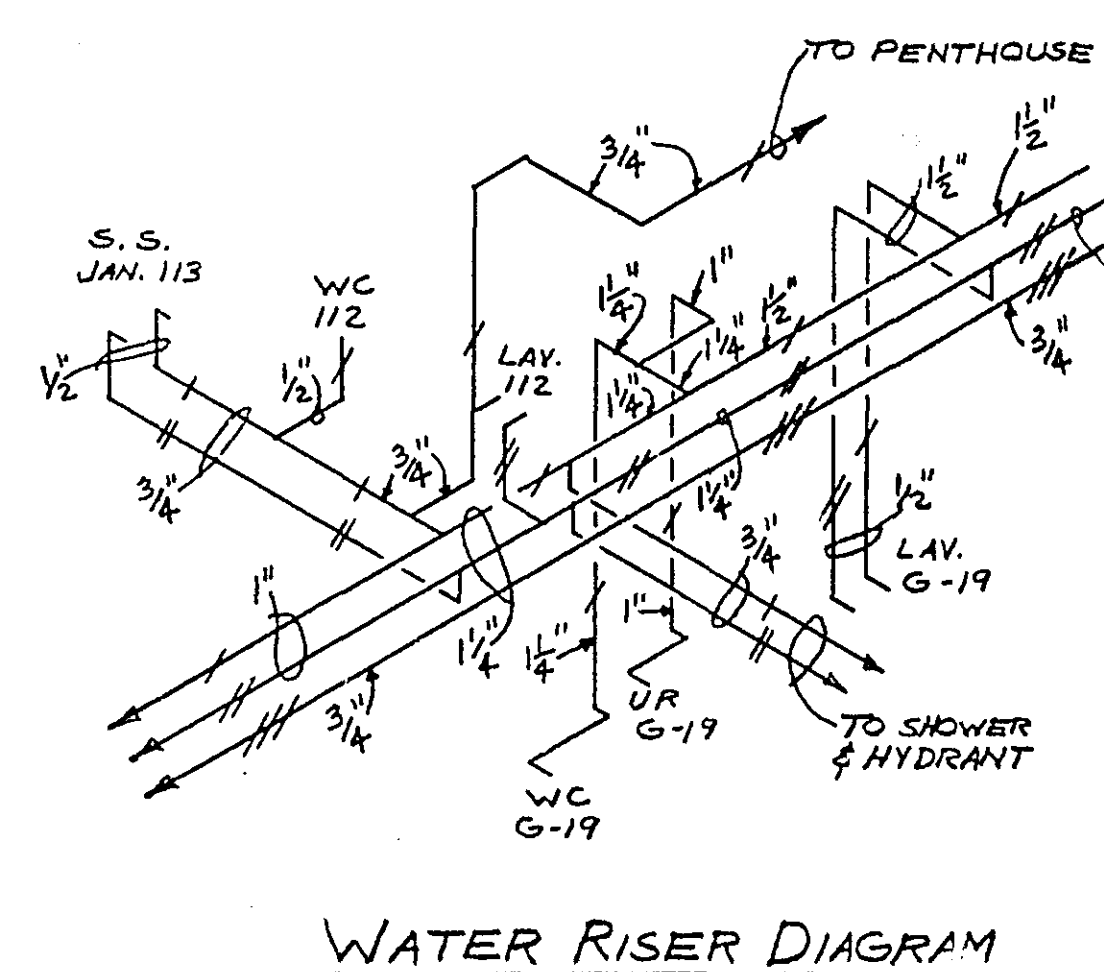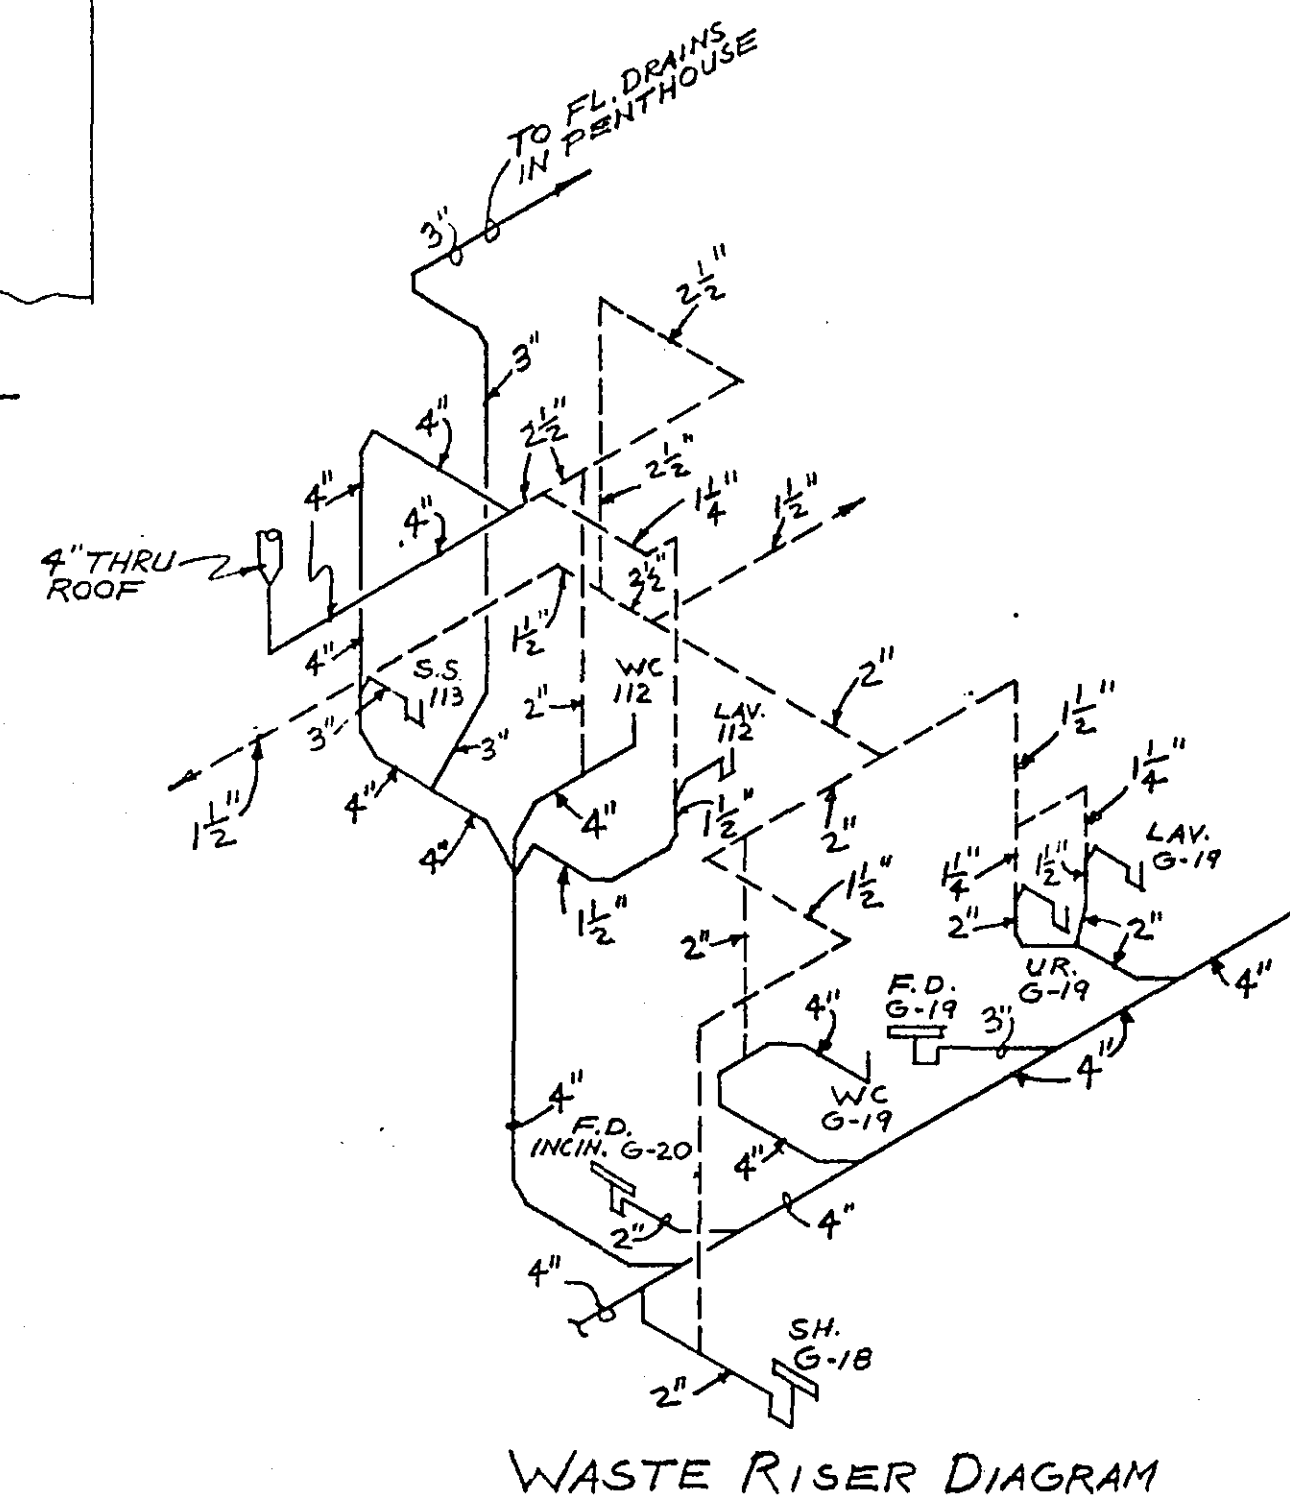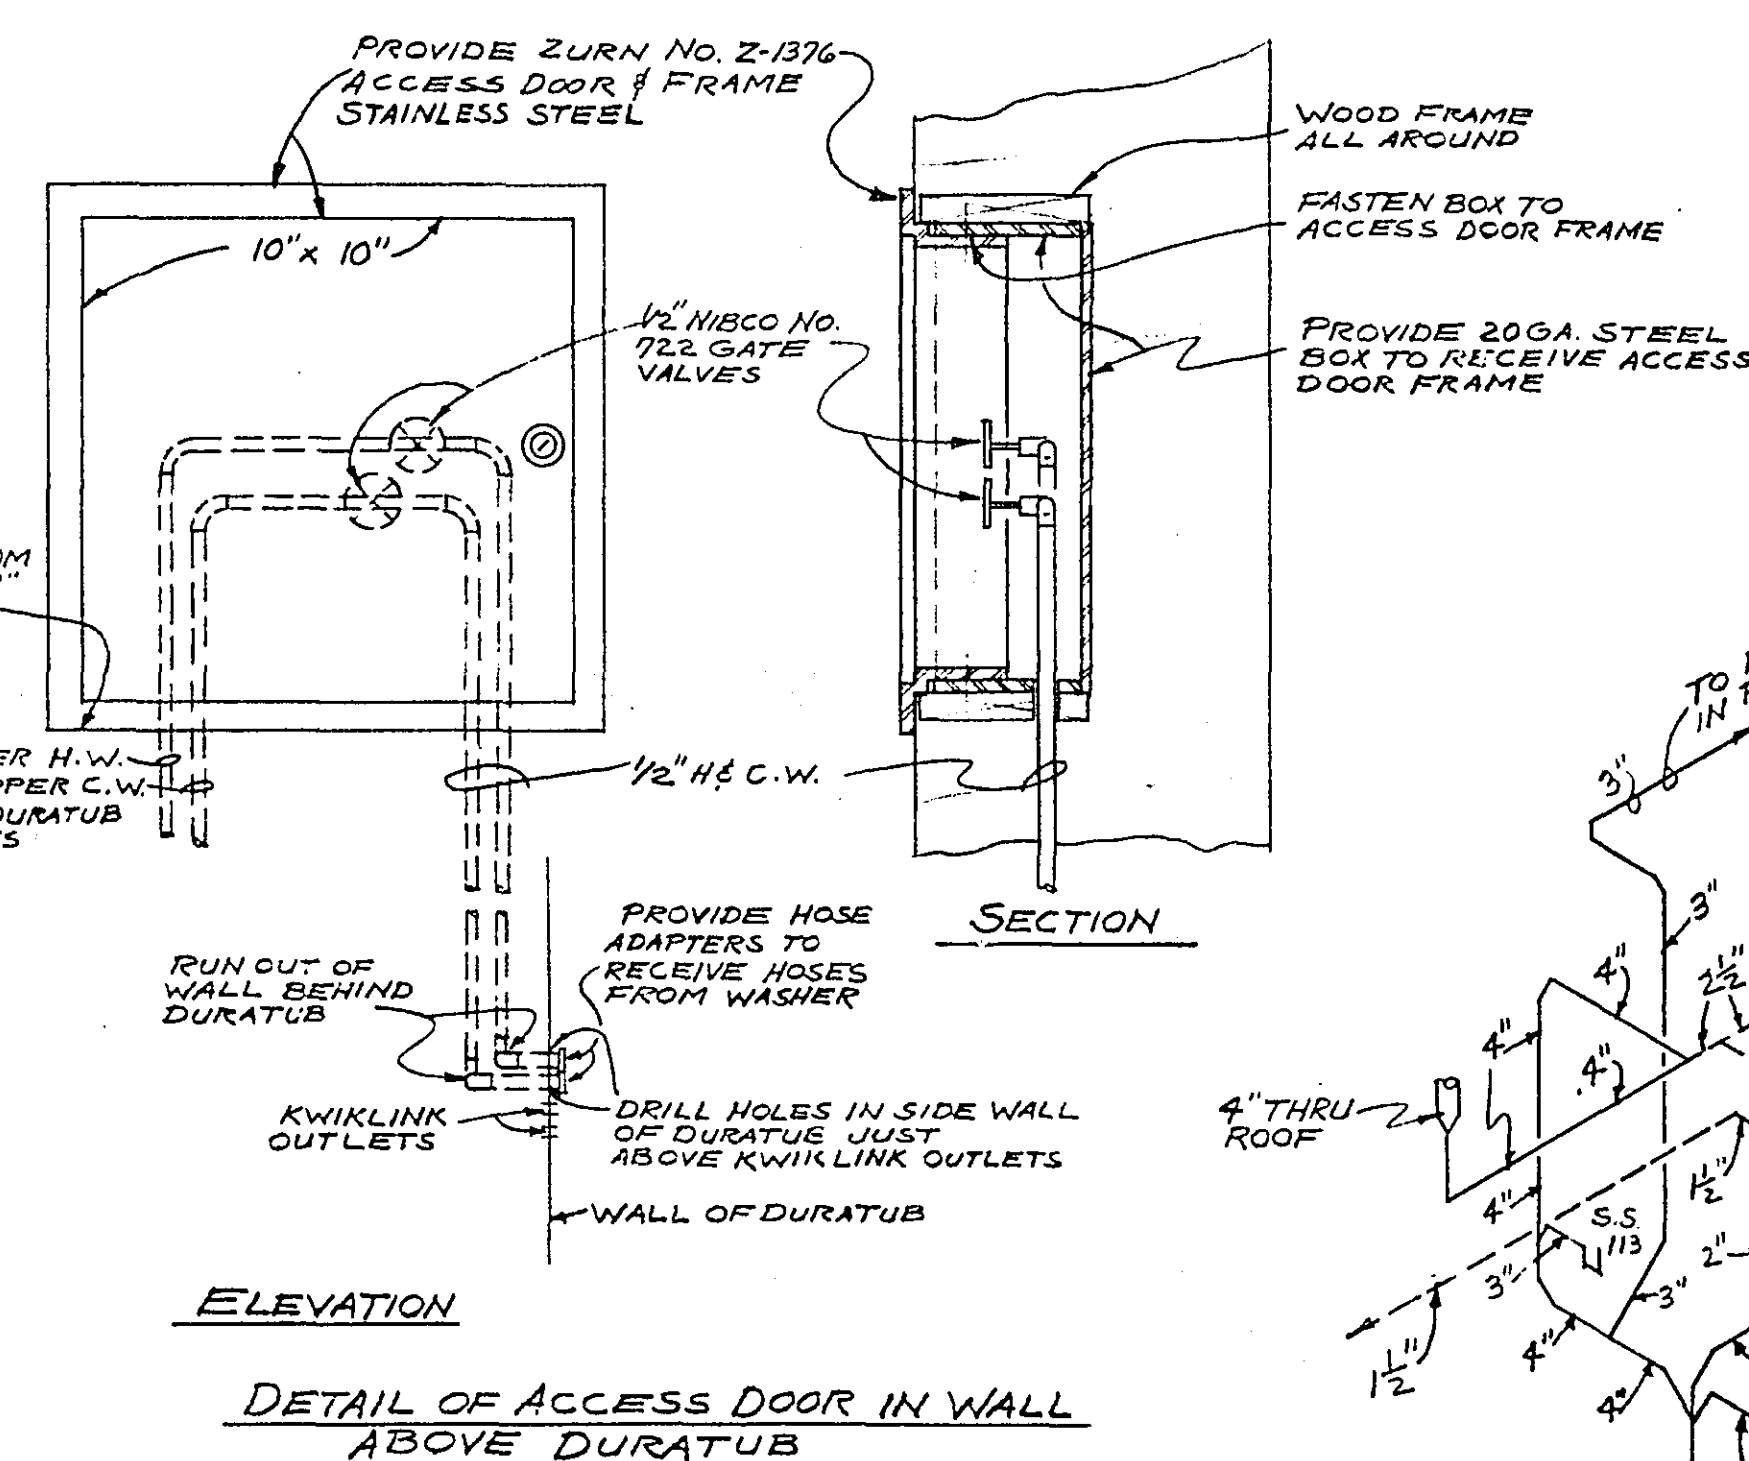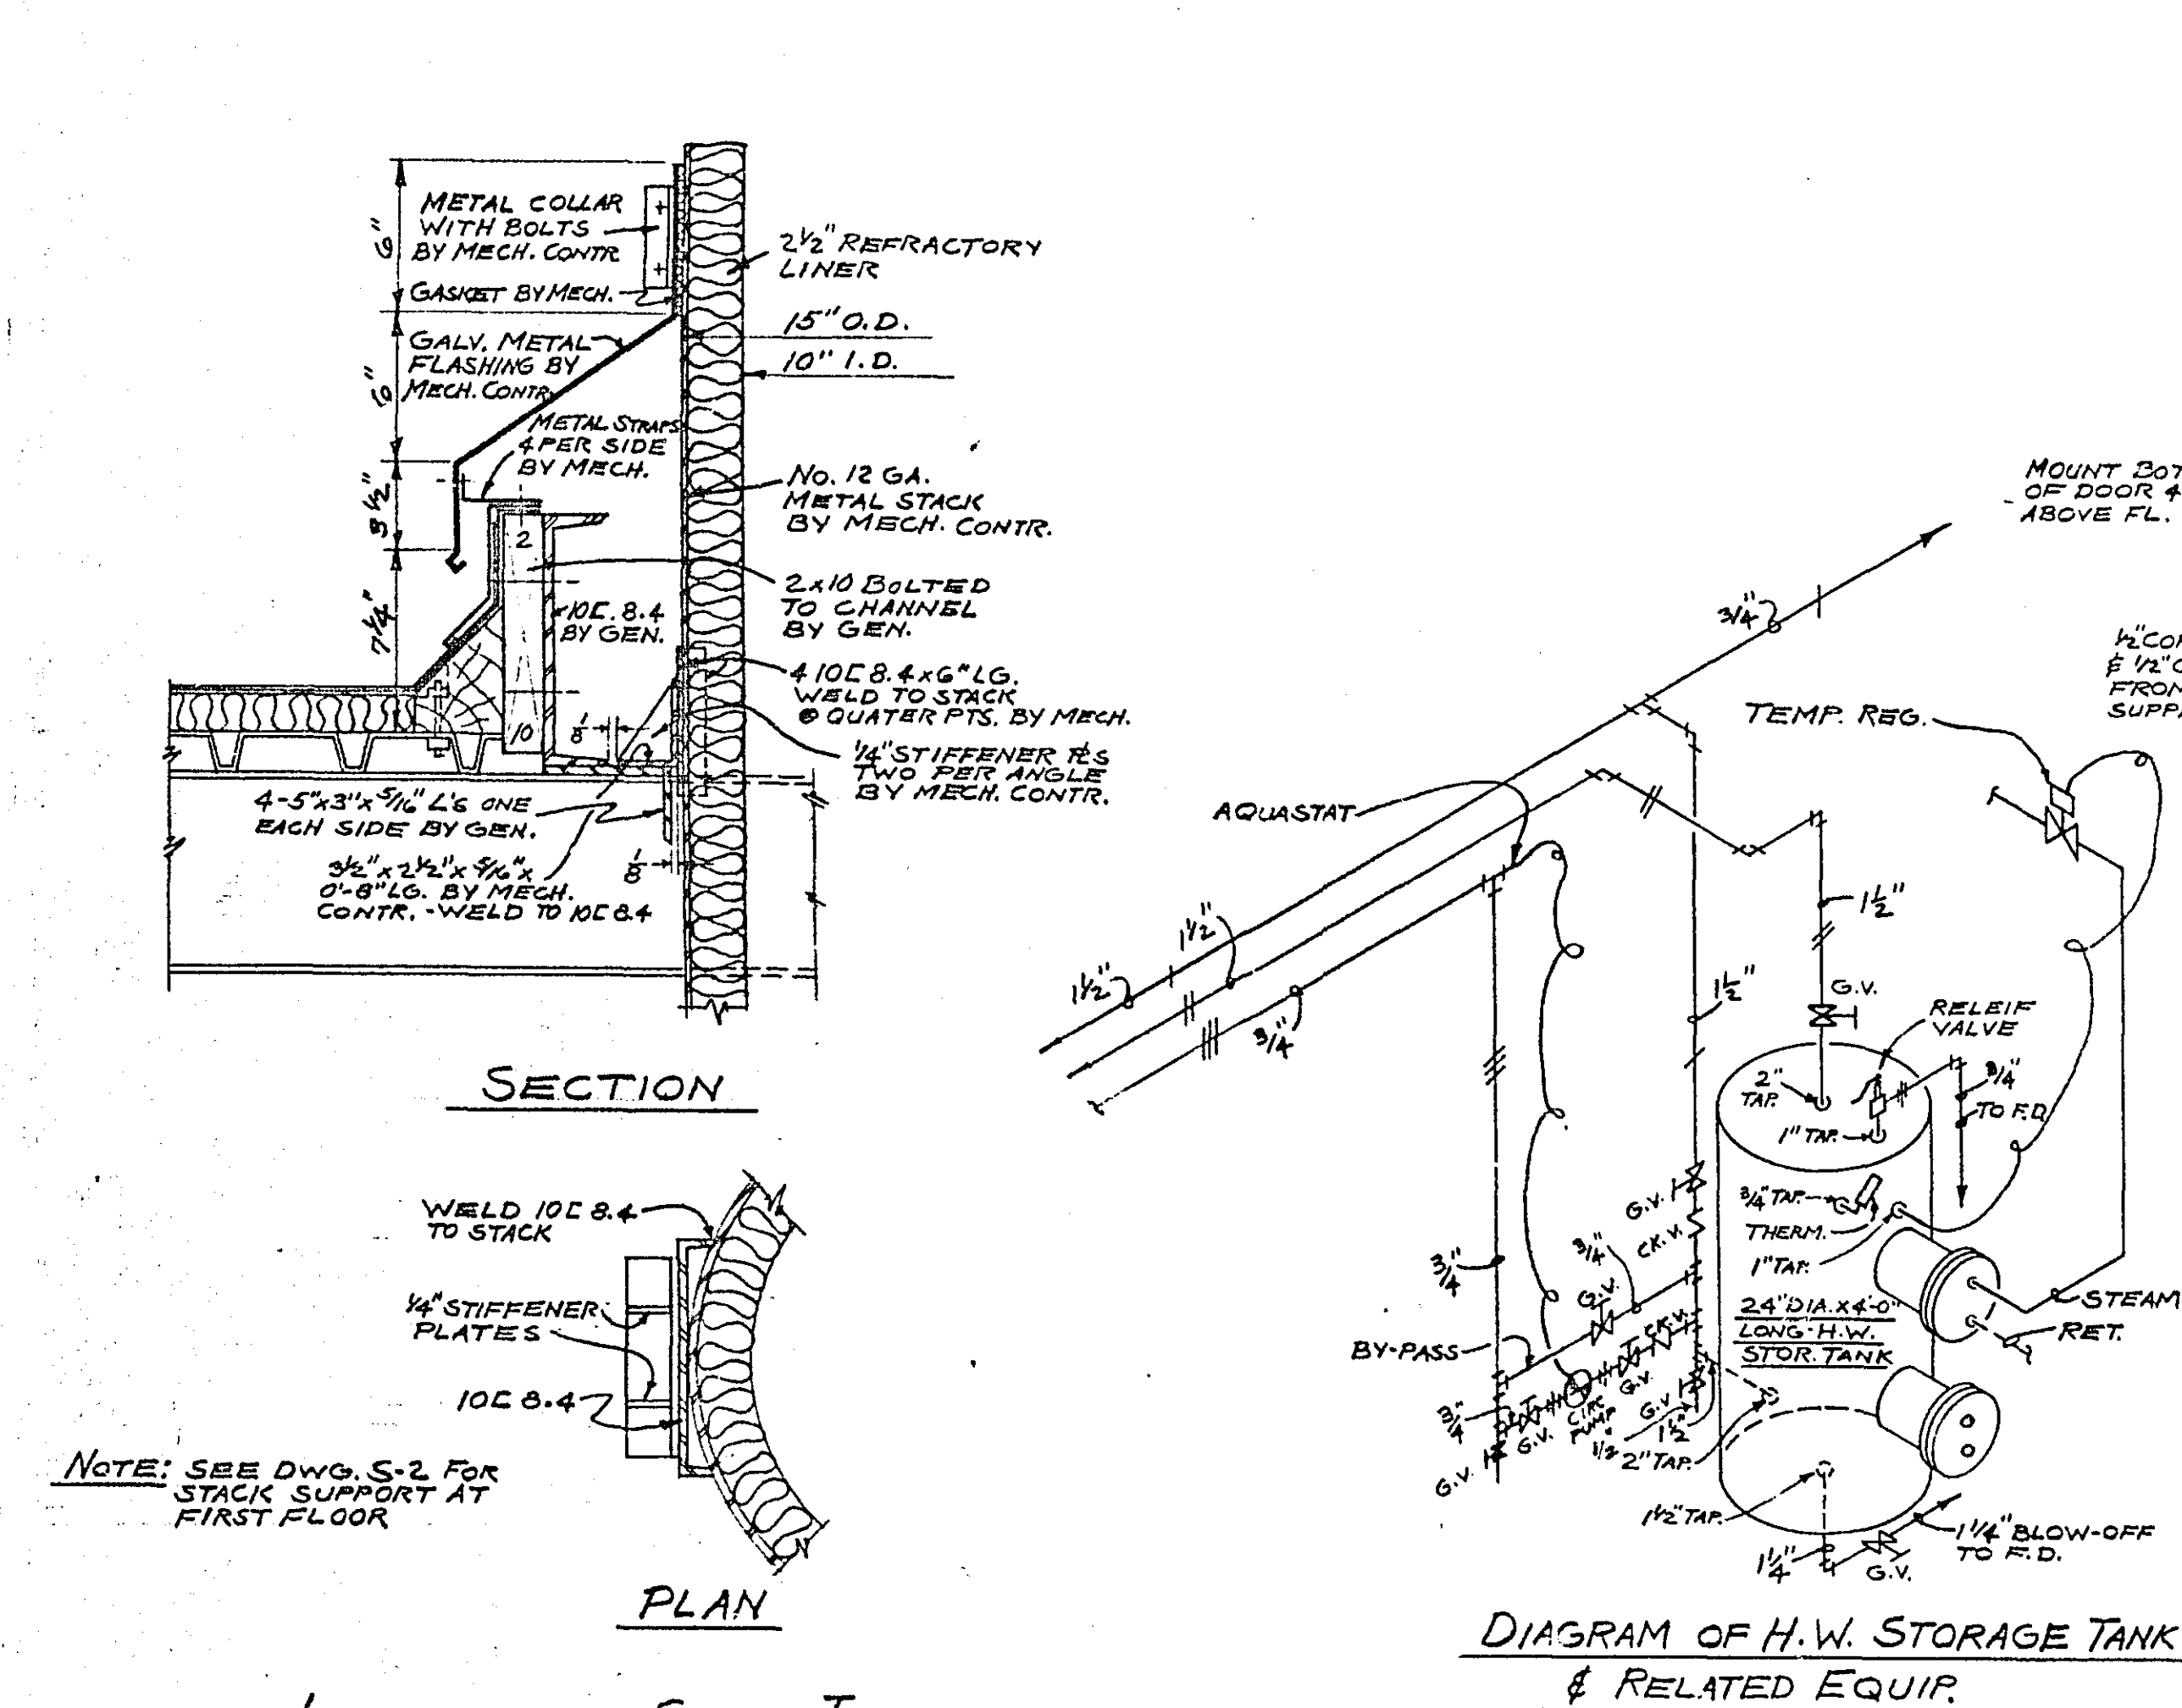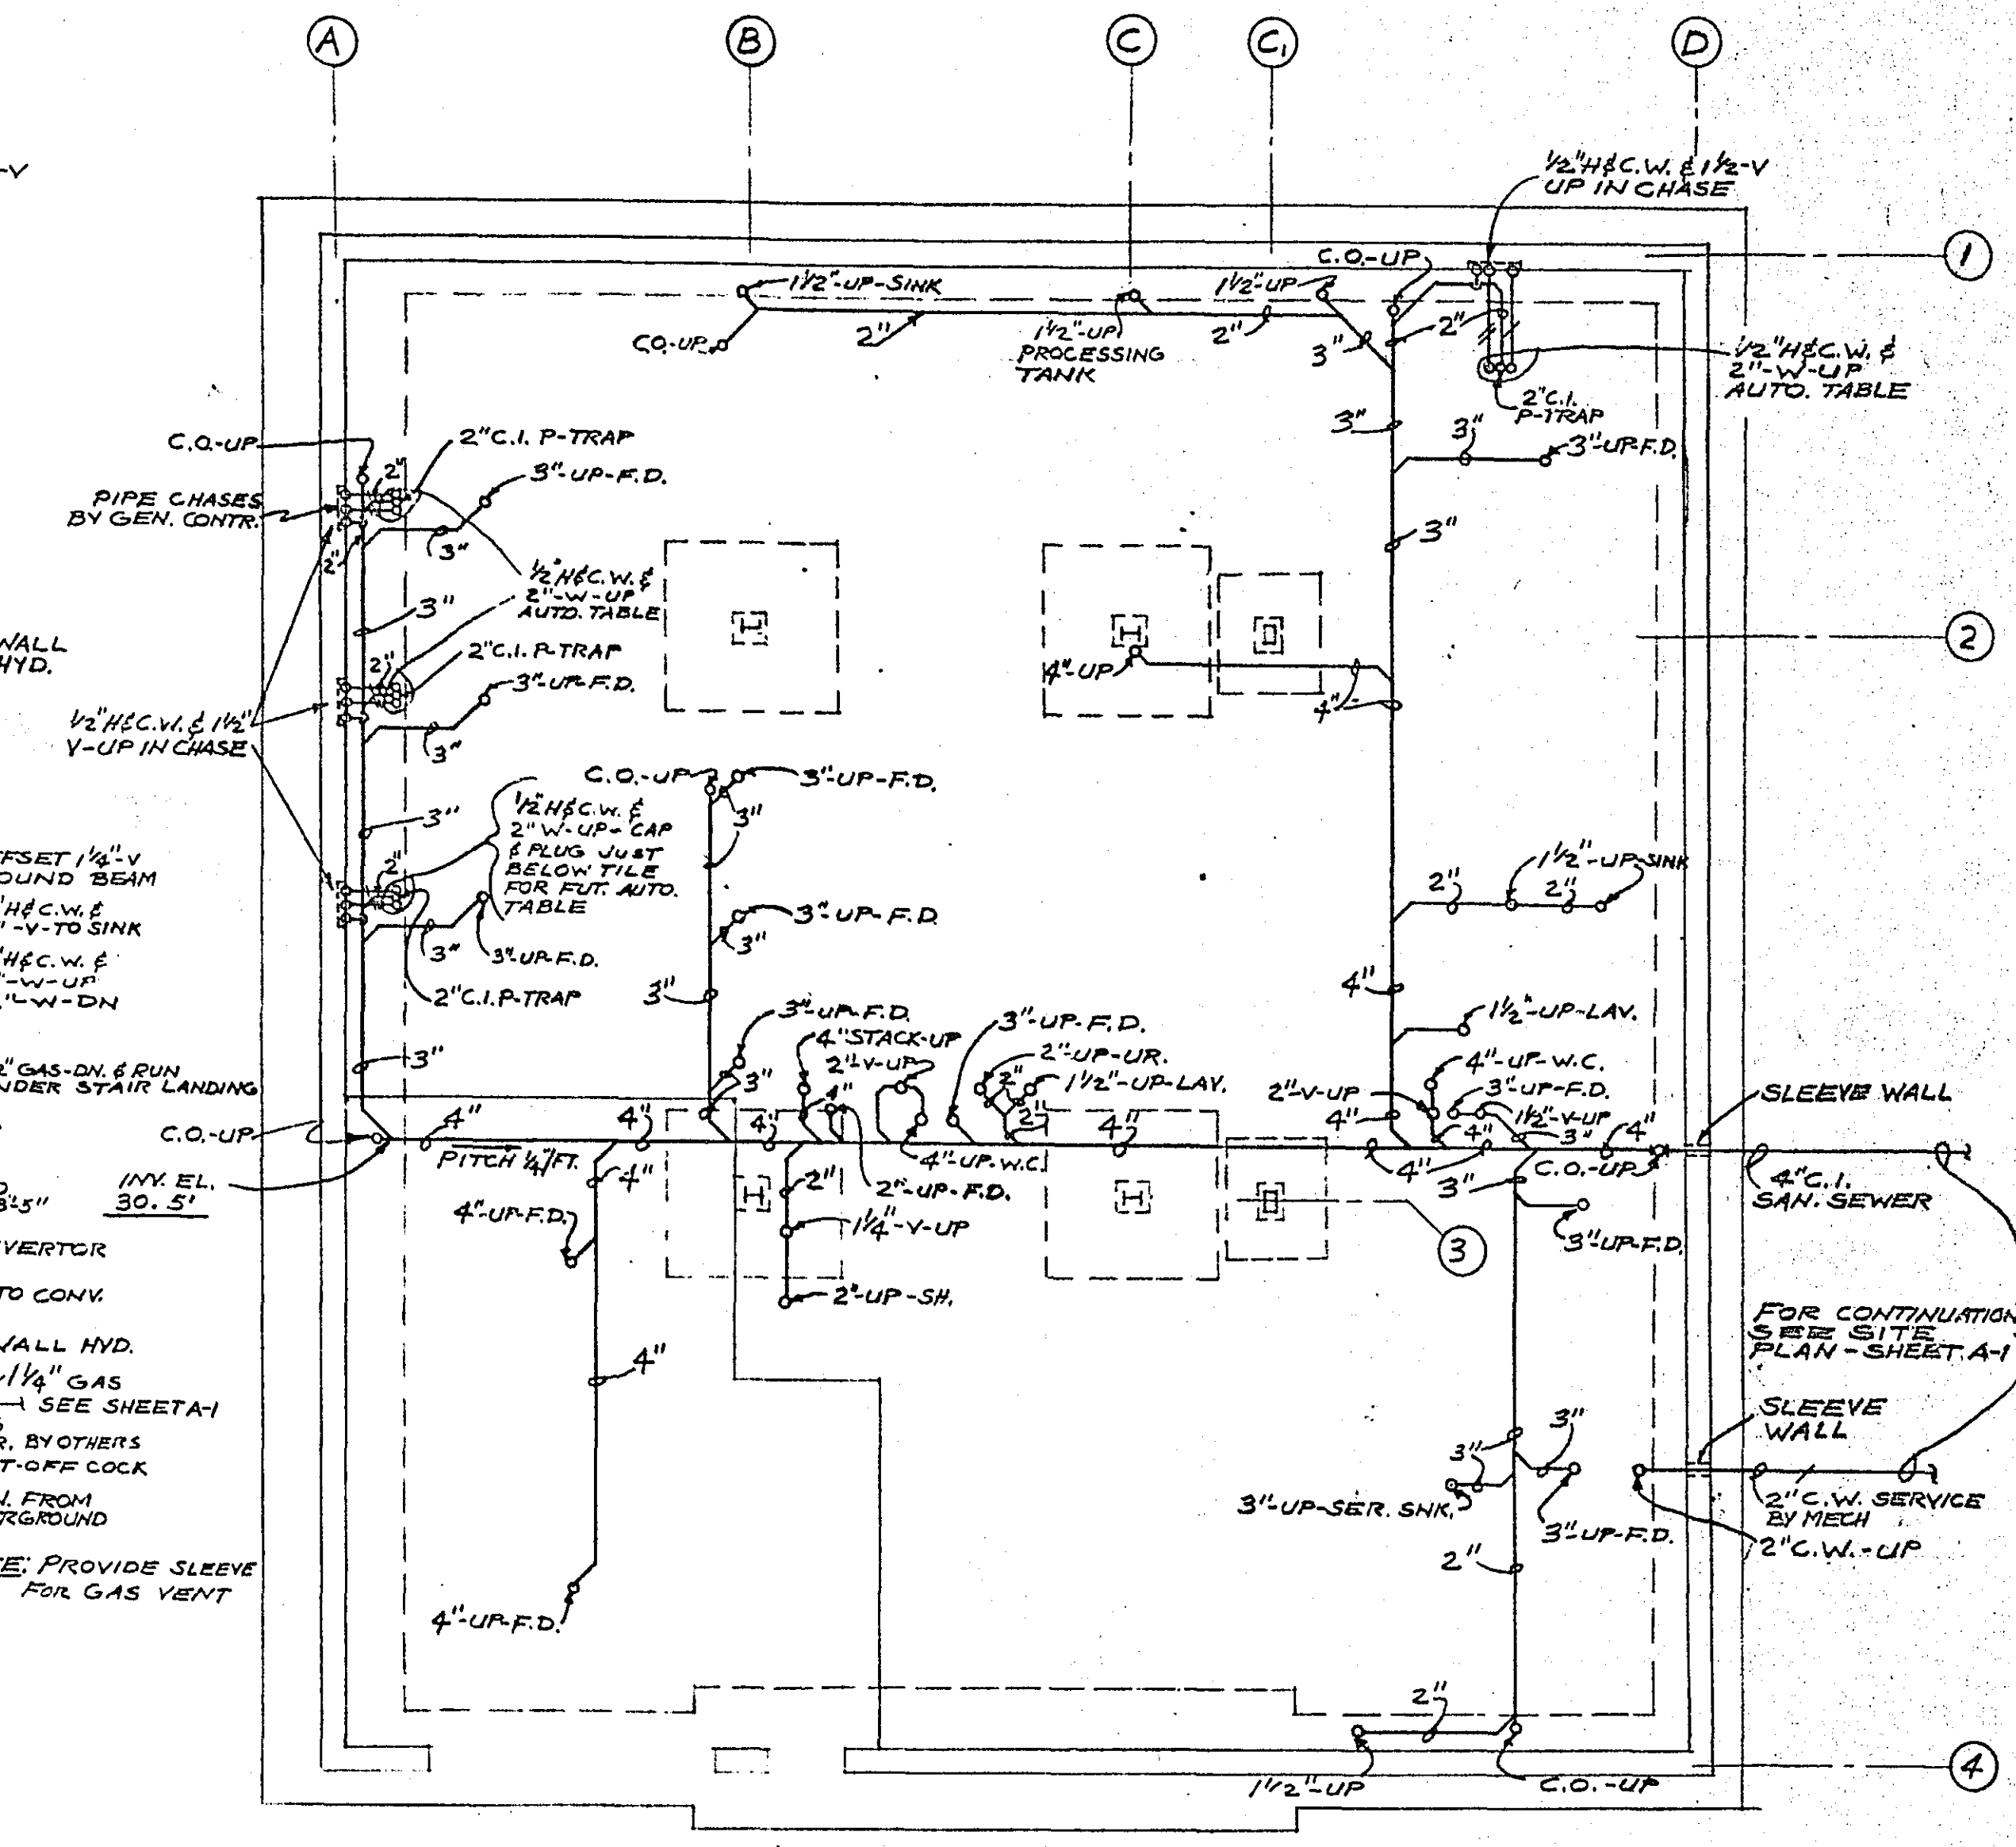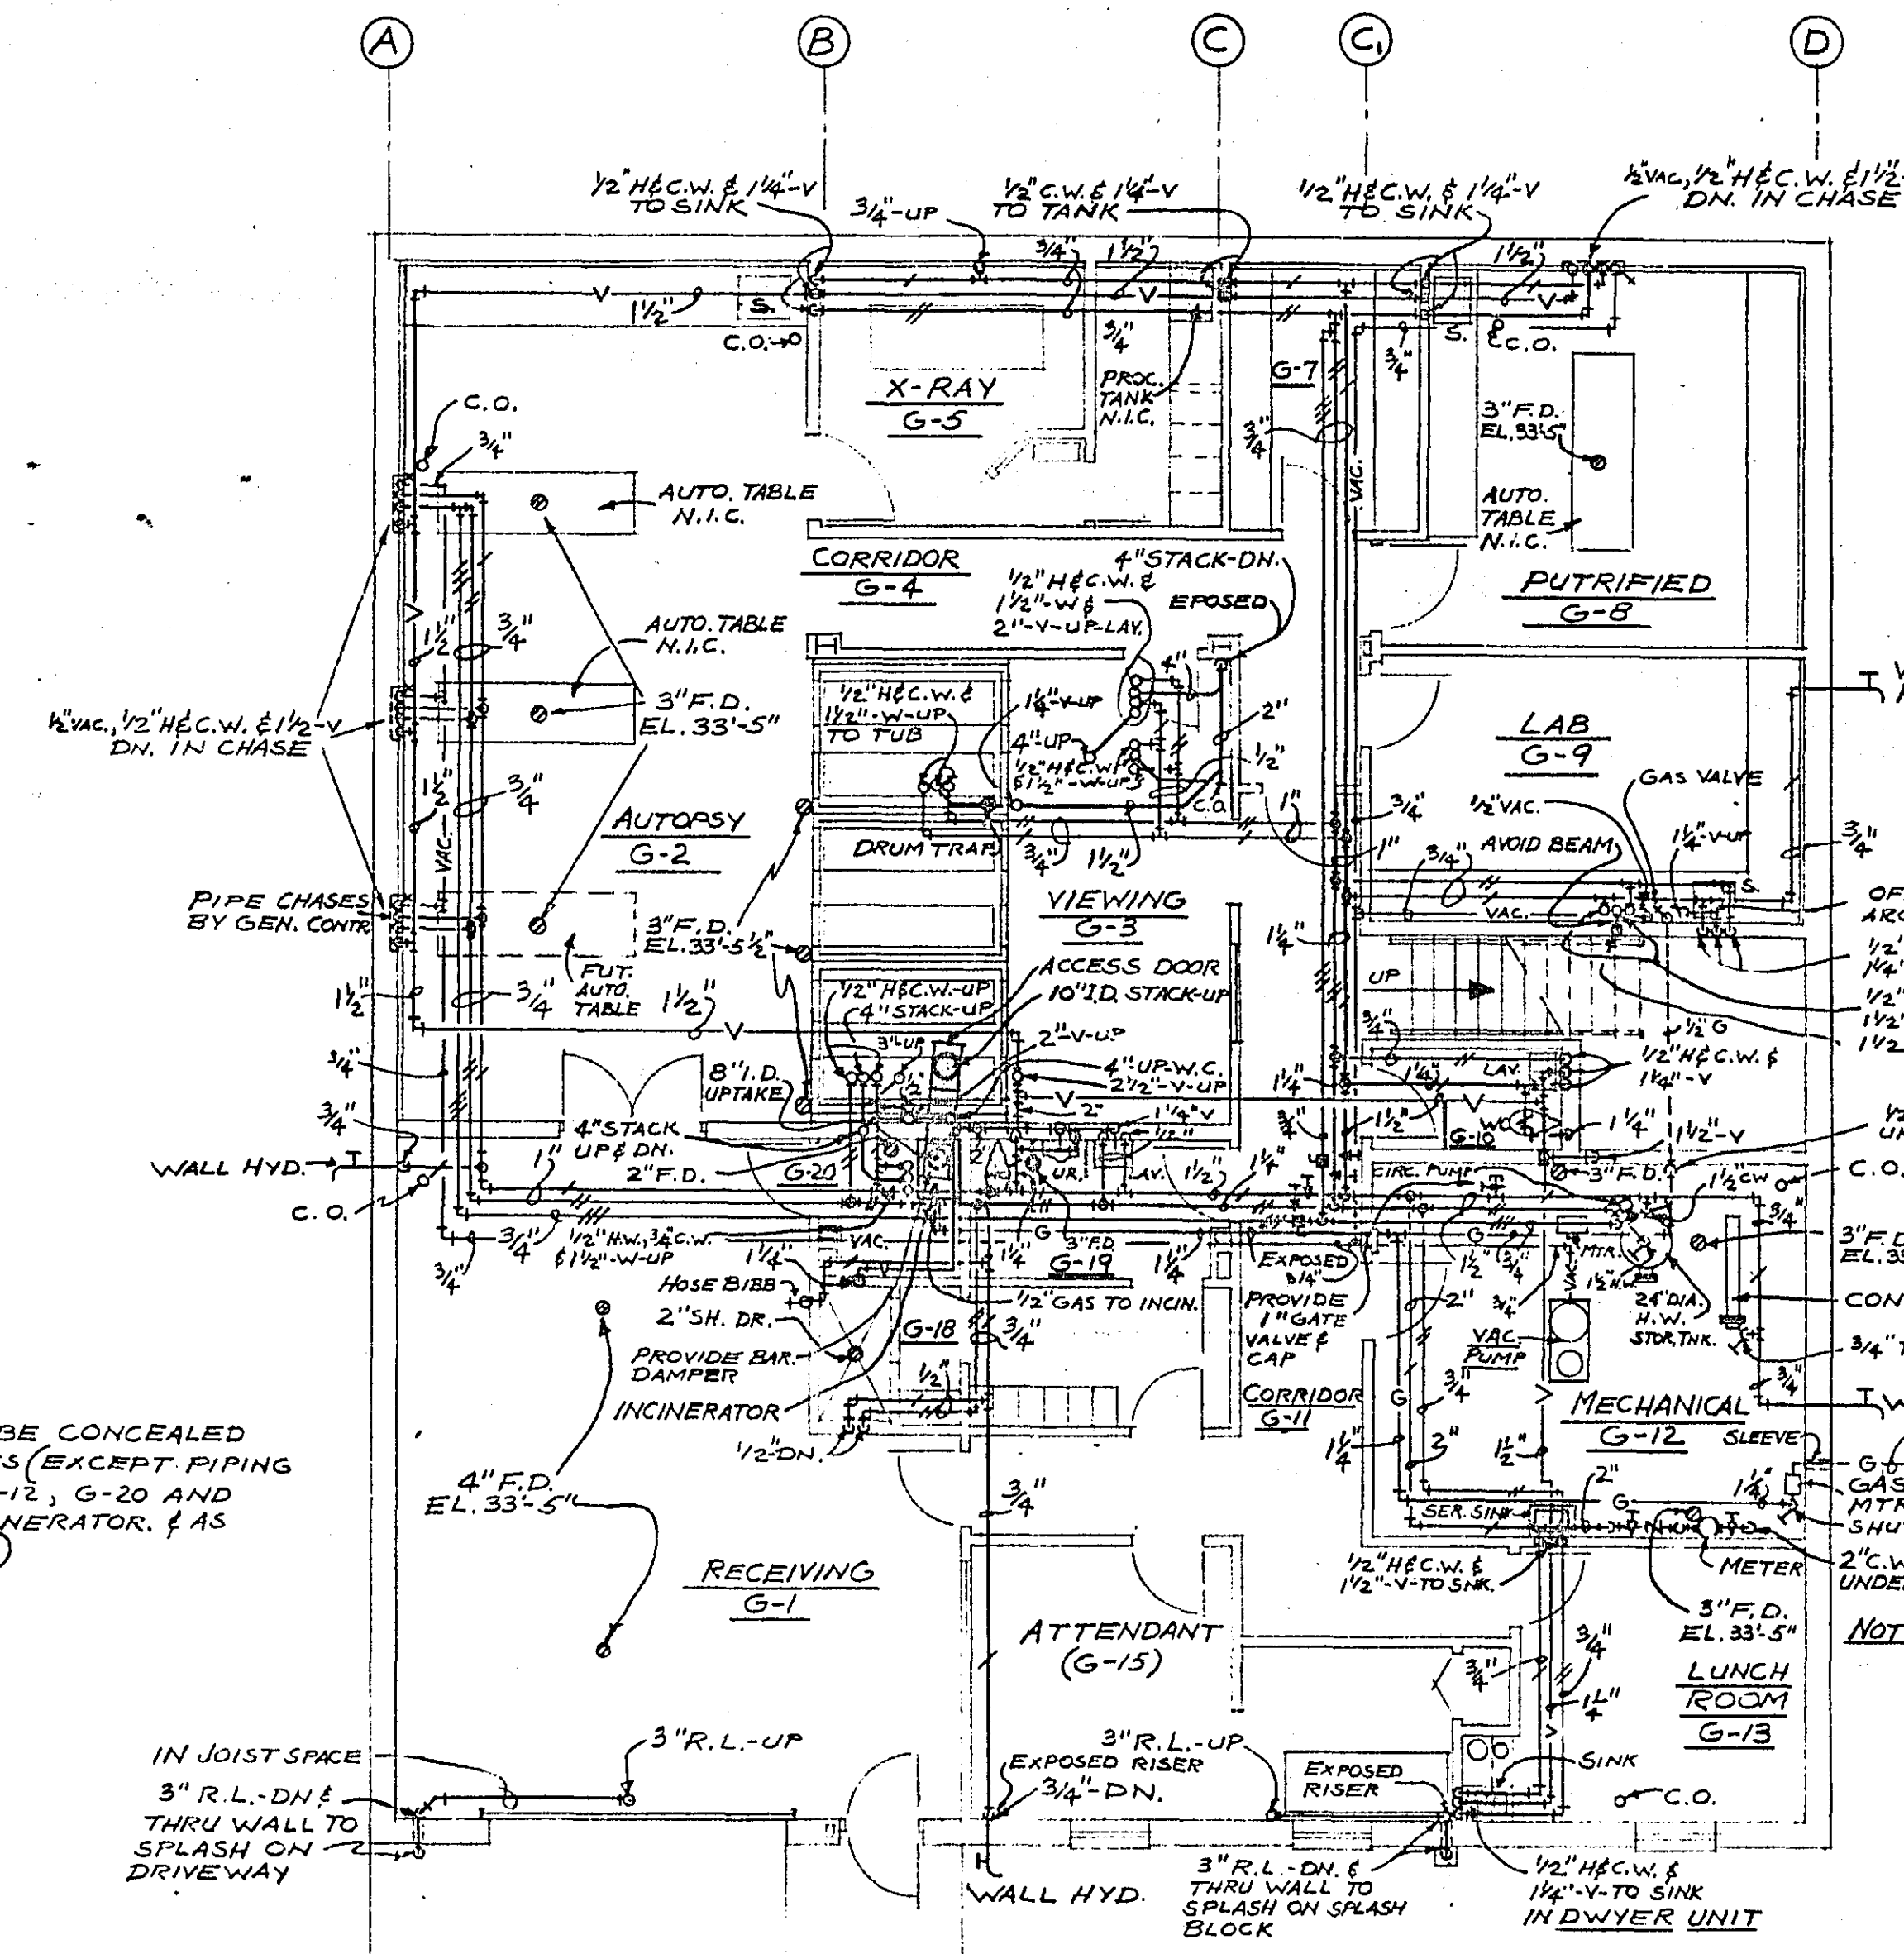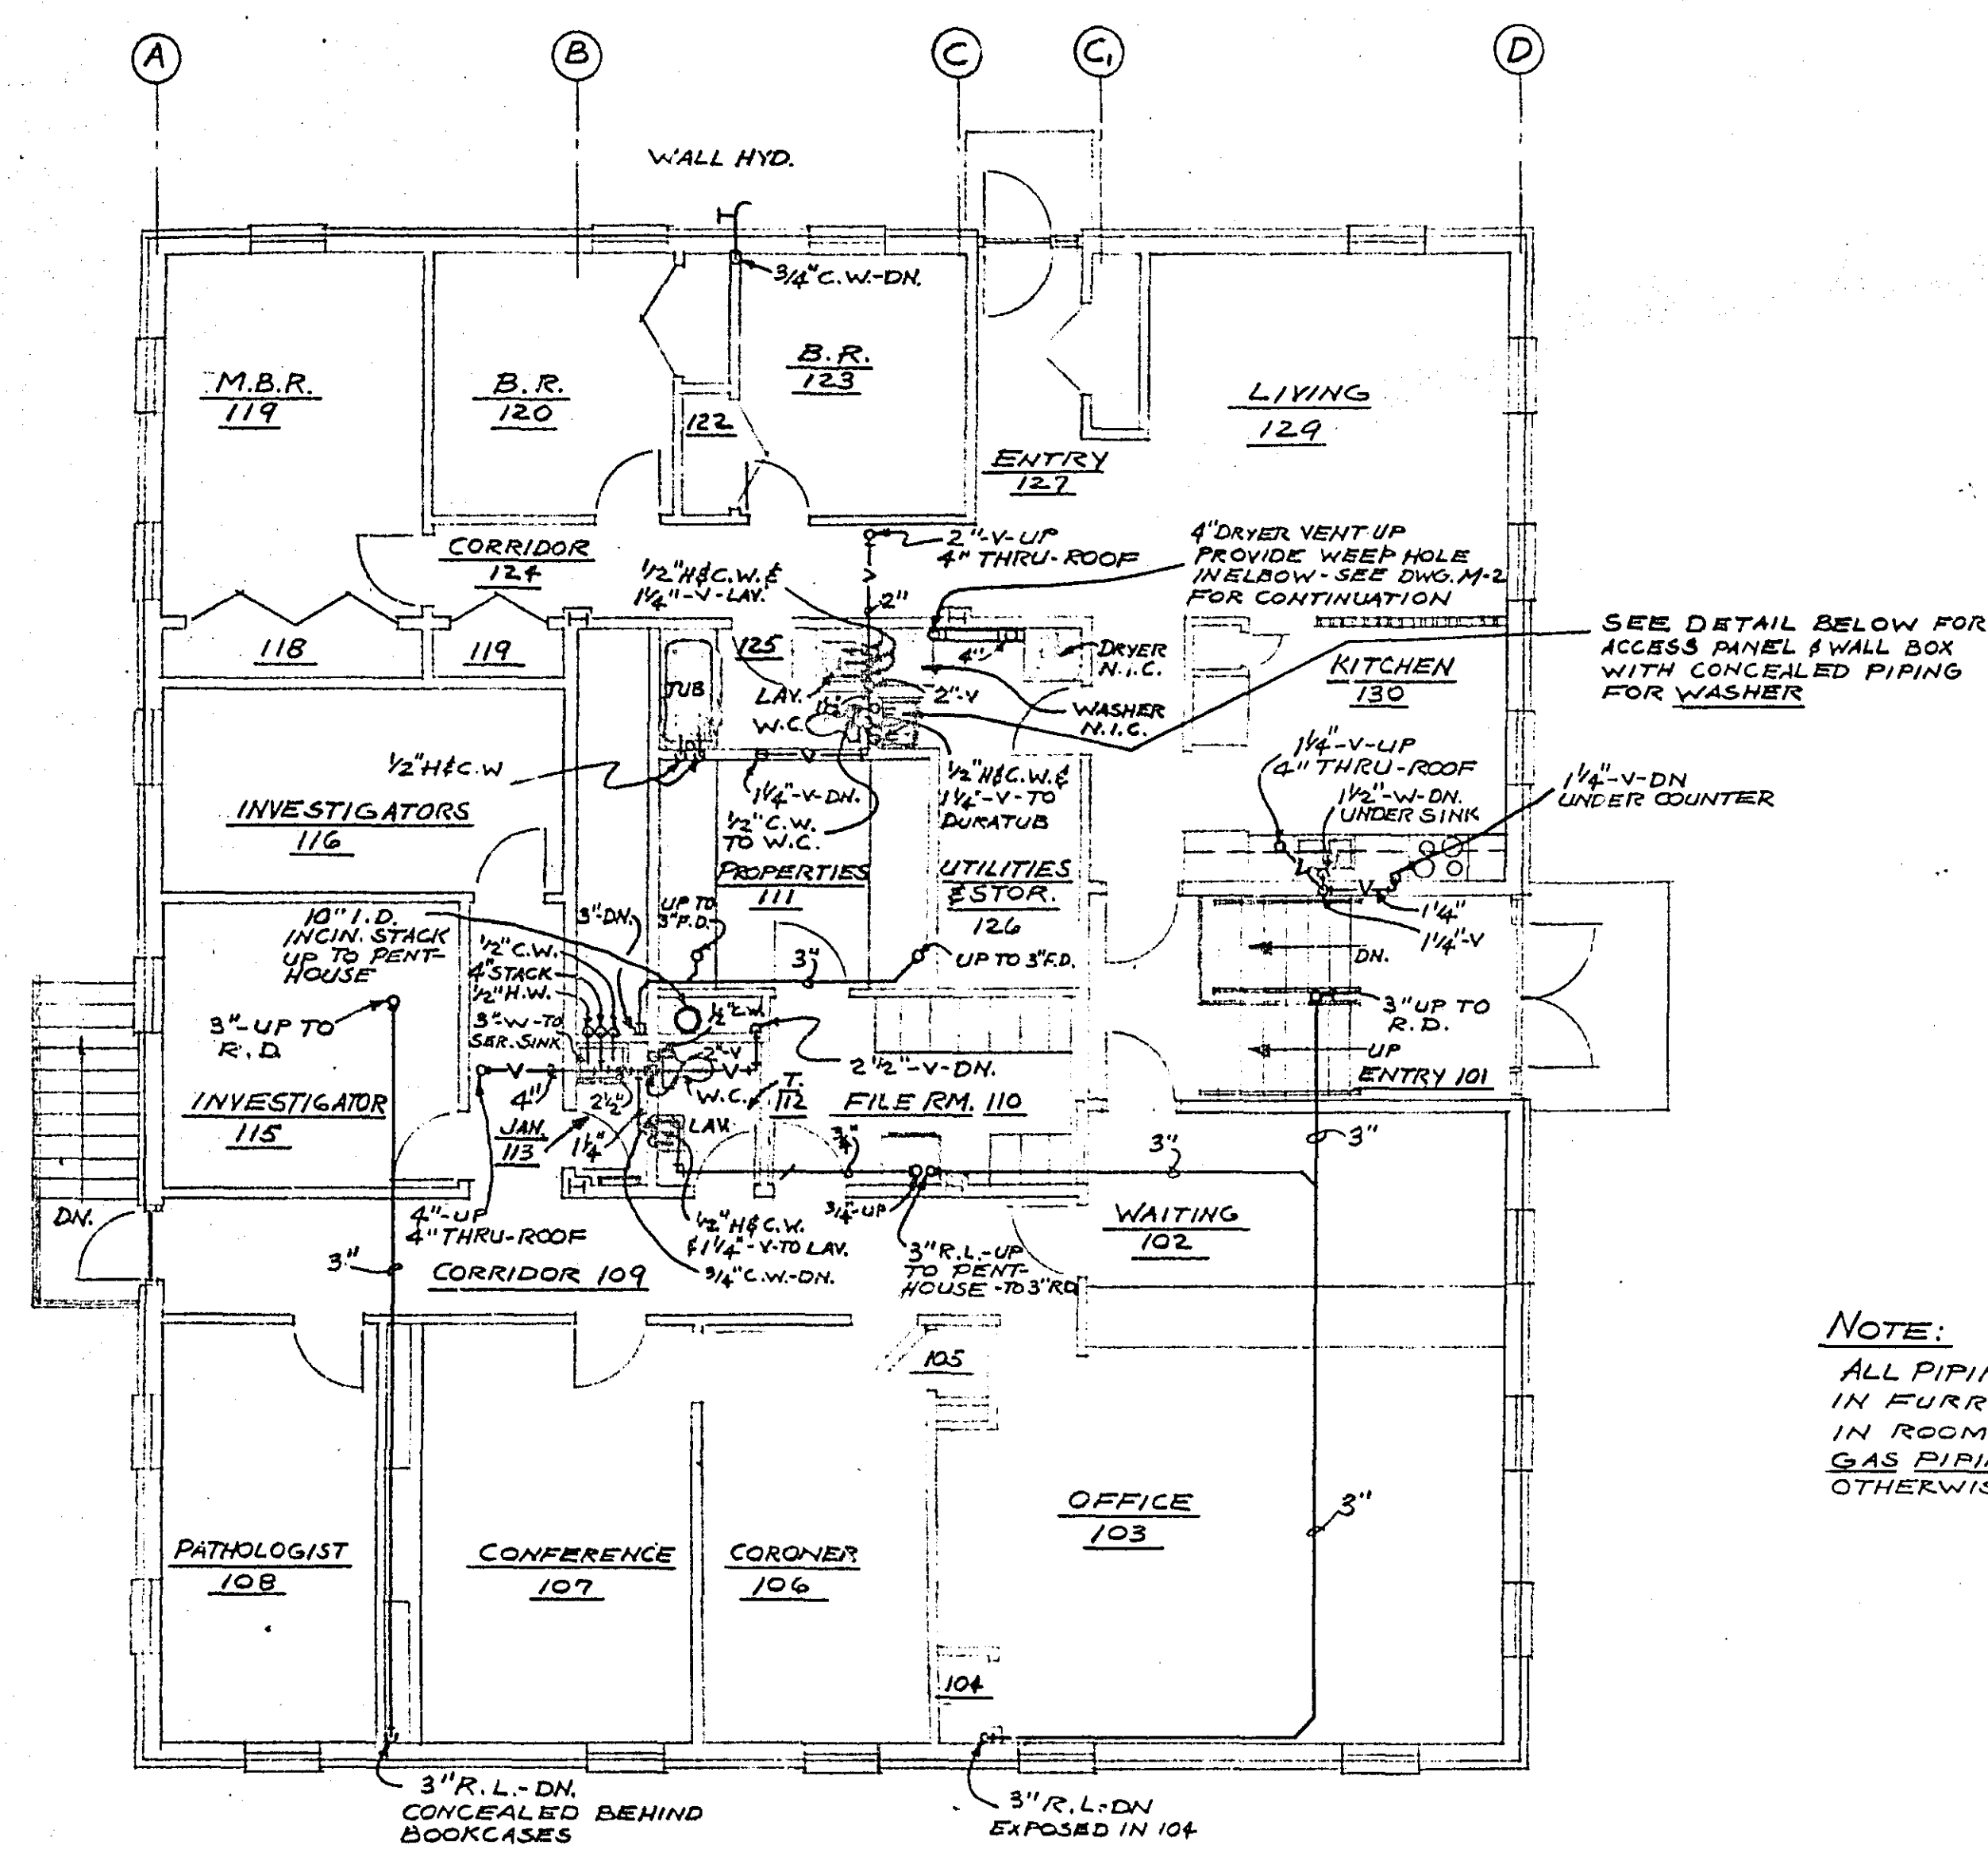

PLUMBING

RAMSEY COUNTY CORONERS OFFICE

ST. PAUL, MINNESOTA

**TOLTZ, KING, DUVALL, ANDERSON
AND ASSOCIATES, INC.** MICROF
ST. PAUL, MINNESOTA RAMSEY C
ENGINEERS AND ARCHITECTS

DESIGNED
G.F.D.
DRAWN
G.F.D.
CHECKED
O.L.L.




I hereby certify that this plan was prepared by me or under my direct supervision and that I am a duly
Registered **PROFESSIONAL ENGINEER**
under the laws of the State of Minnesota.

Date **OCTOBER 7, 1963** Reg. No. **2303**

O. L. Lello

COM.
4603
DRG.
M-3


- ① CONNECT WIRING IN JUNCTION BOXES ON TOP OF CRAYST SECTION, PROVIDED BY OTHERS. INTERNAL CONNECTIONS TO FAN UNIT AND LIGHT FIXTURE ARE MADE BY MANUFACTURER.
- ② MULTIPLE DOOR SIGNALS 7'-6" UP. SEE SPECS.
- ③ PROVIDE CEILING OUTLET WITH CIRCUIT AND BLANK COVER. NO WALL SWITCH PROVIDED.
- ④ SEE ARCHITECTURAL DRAWING A-6 FOR LOCATION OF EXTERIOR ENTRANCE LIGHT, BELL BUTTON, AND SPEAKER OUTLET. SEE DETAIL ON THIS DRAWING FOR SPEAKER OUTLET.

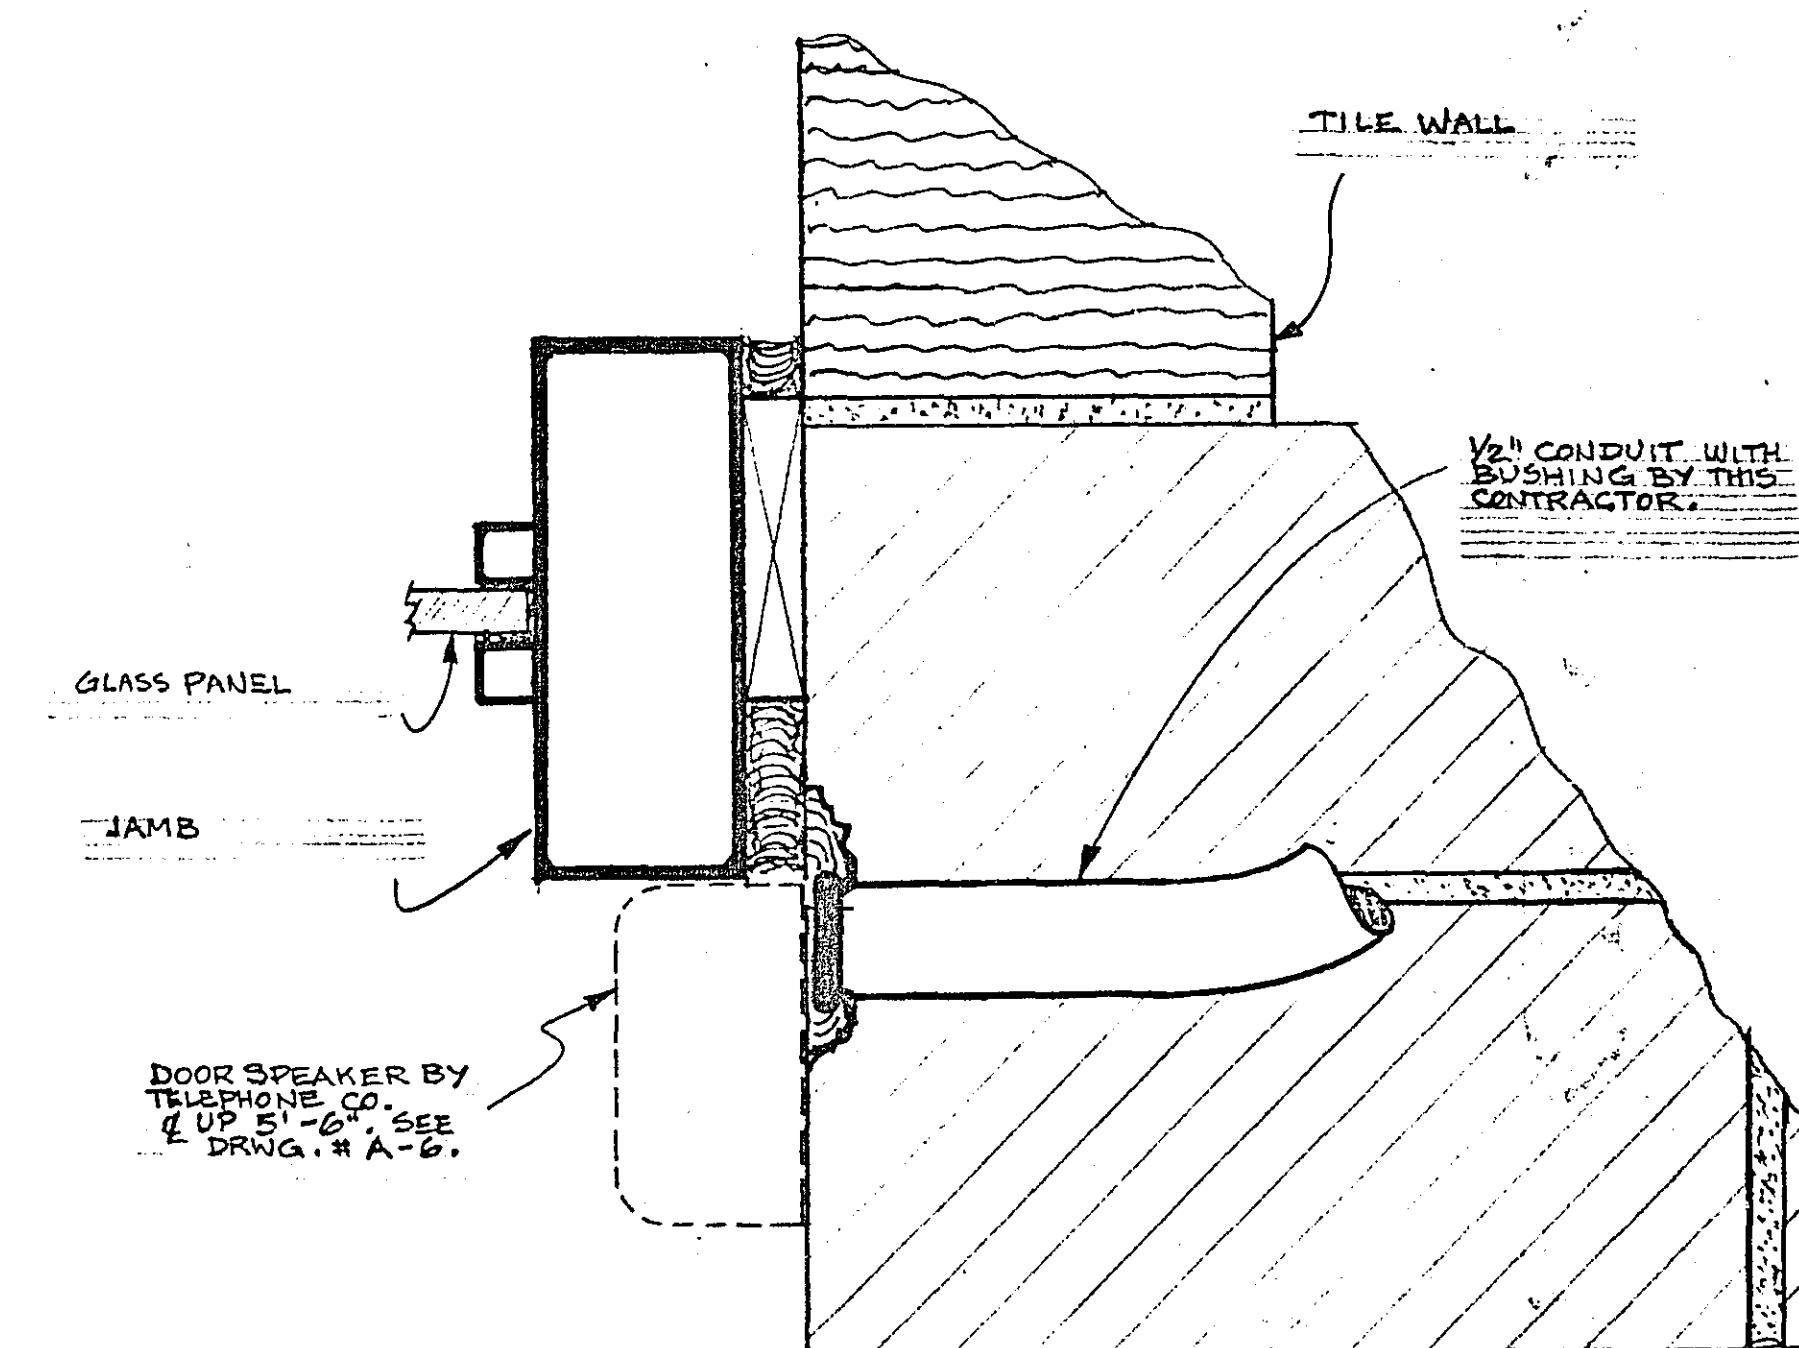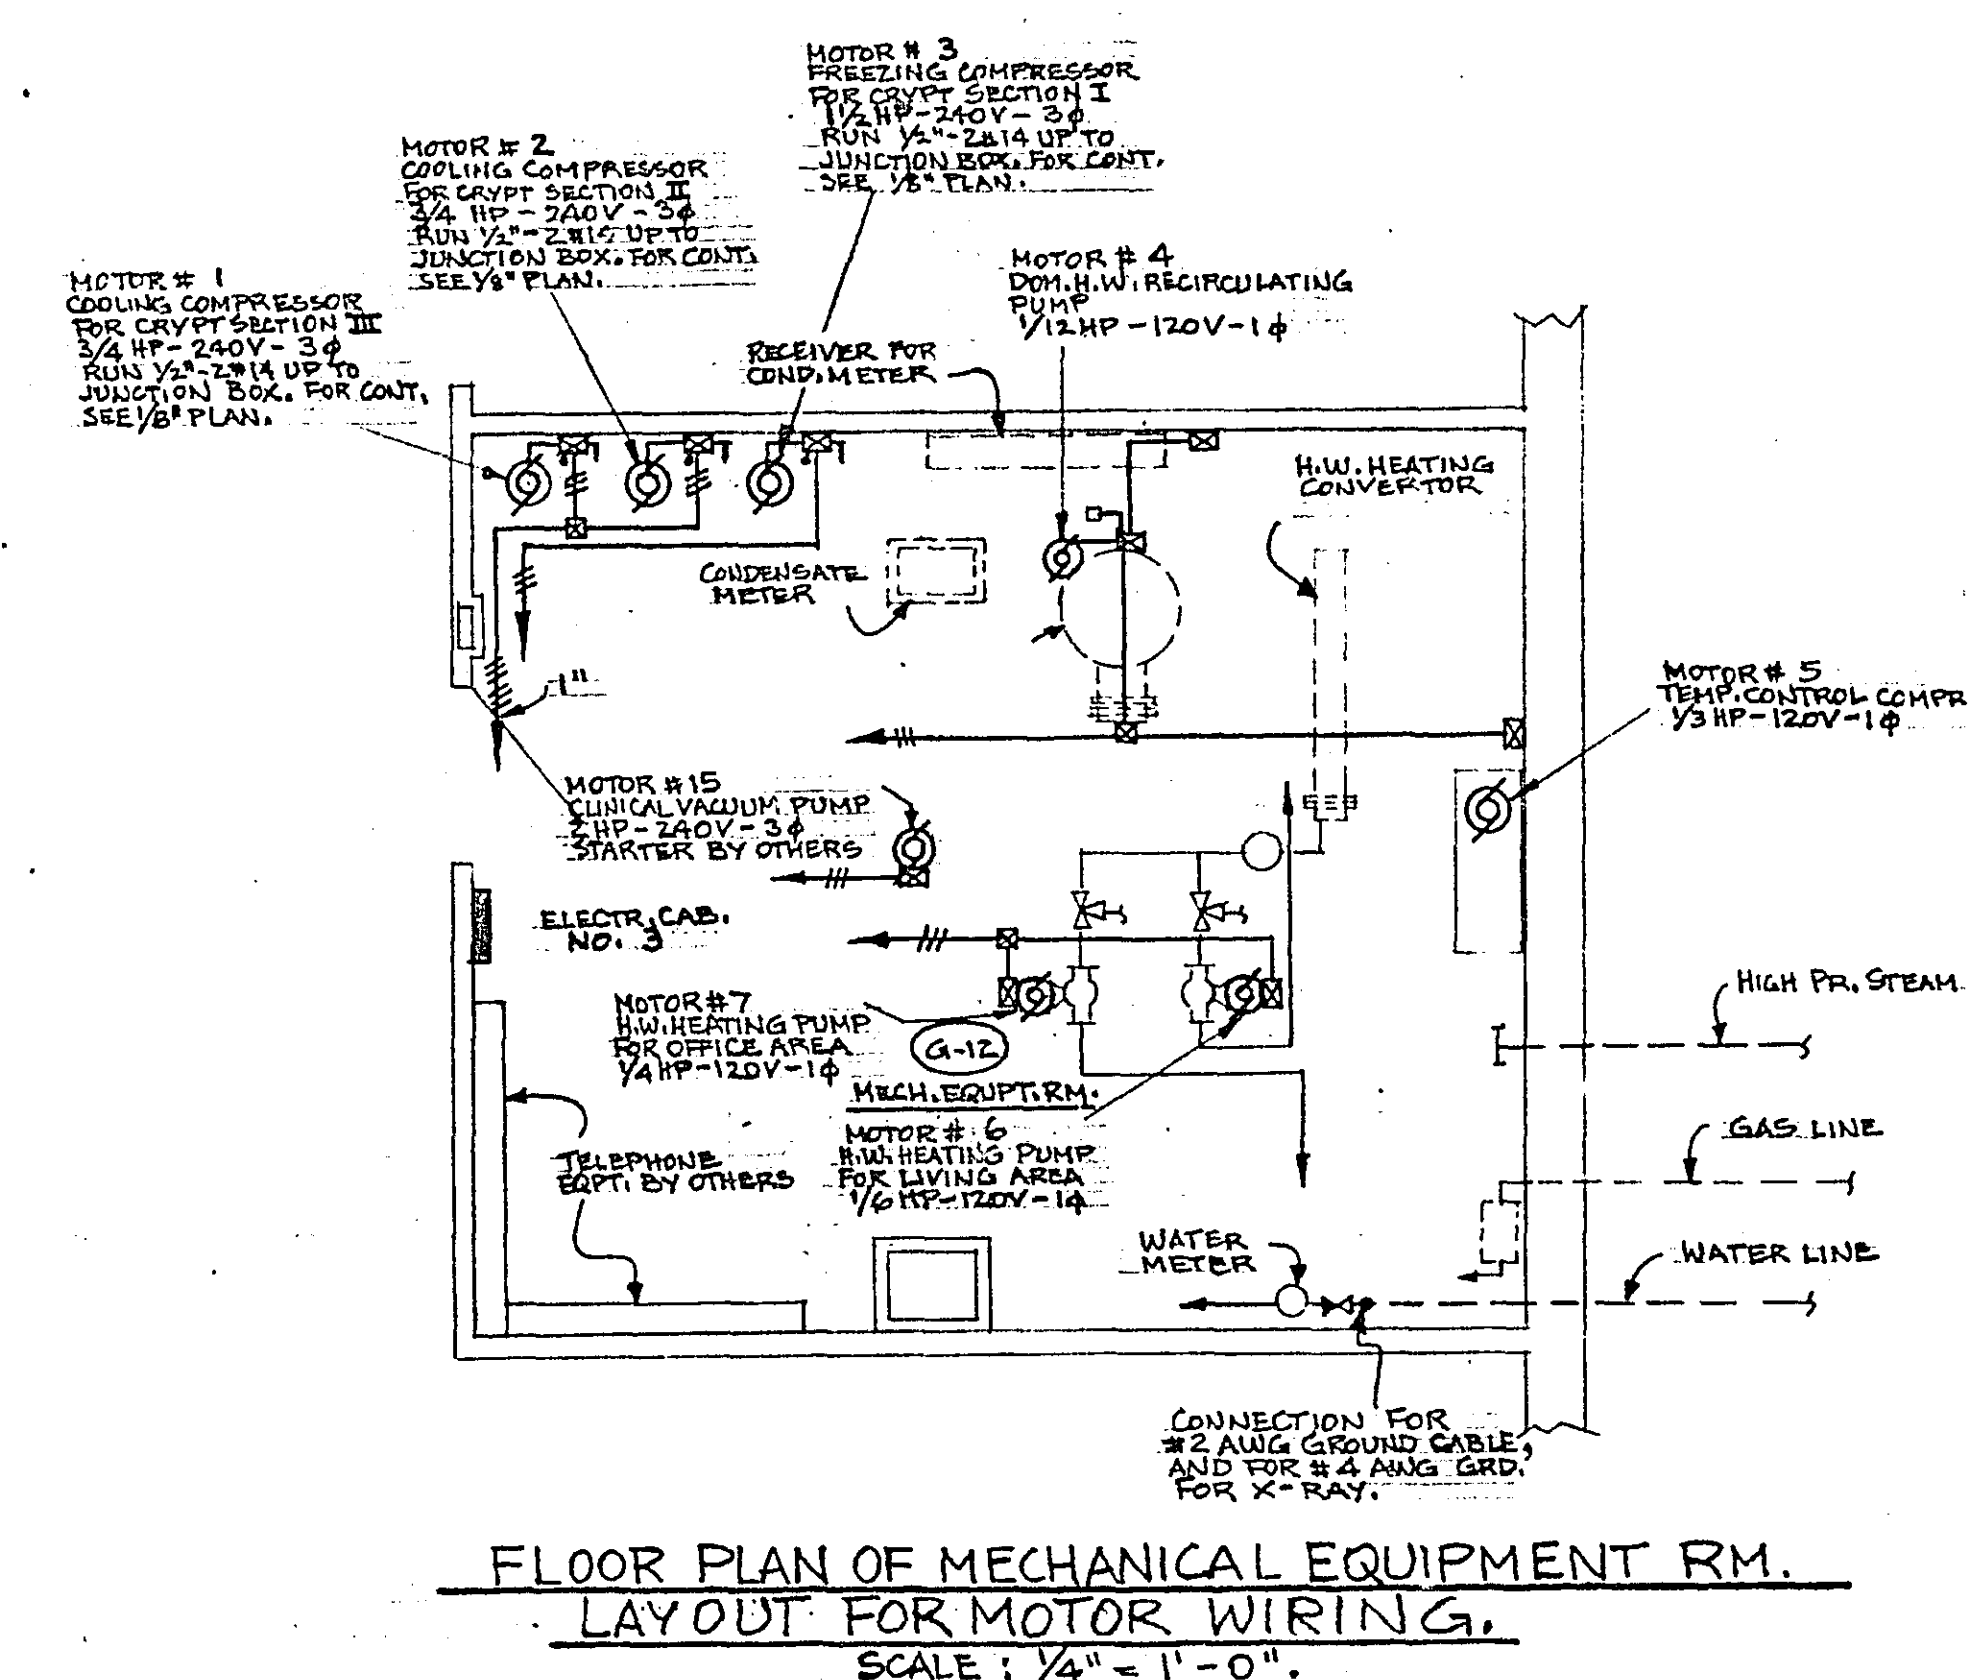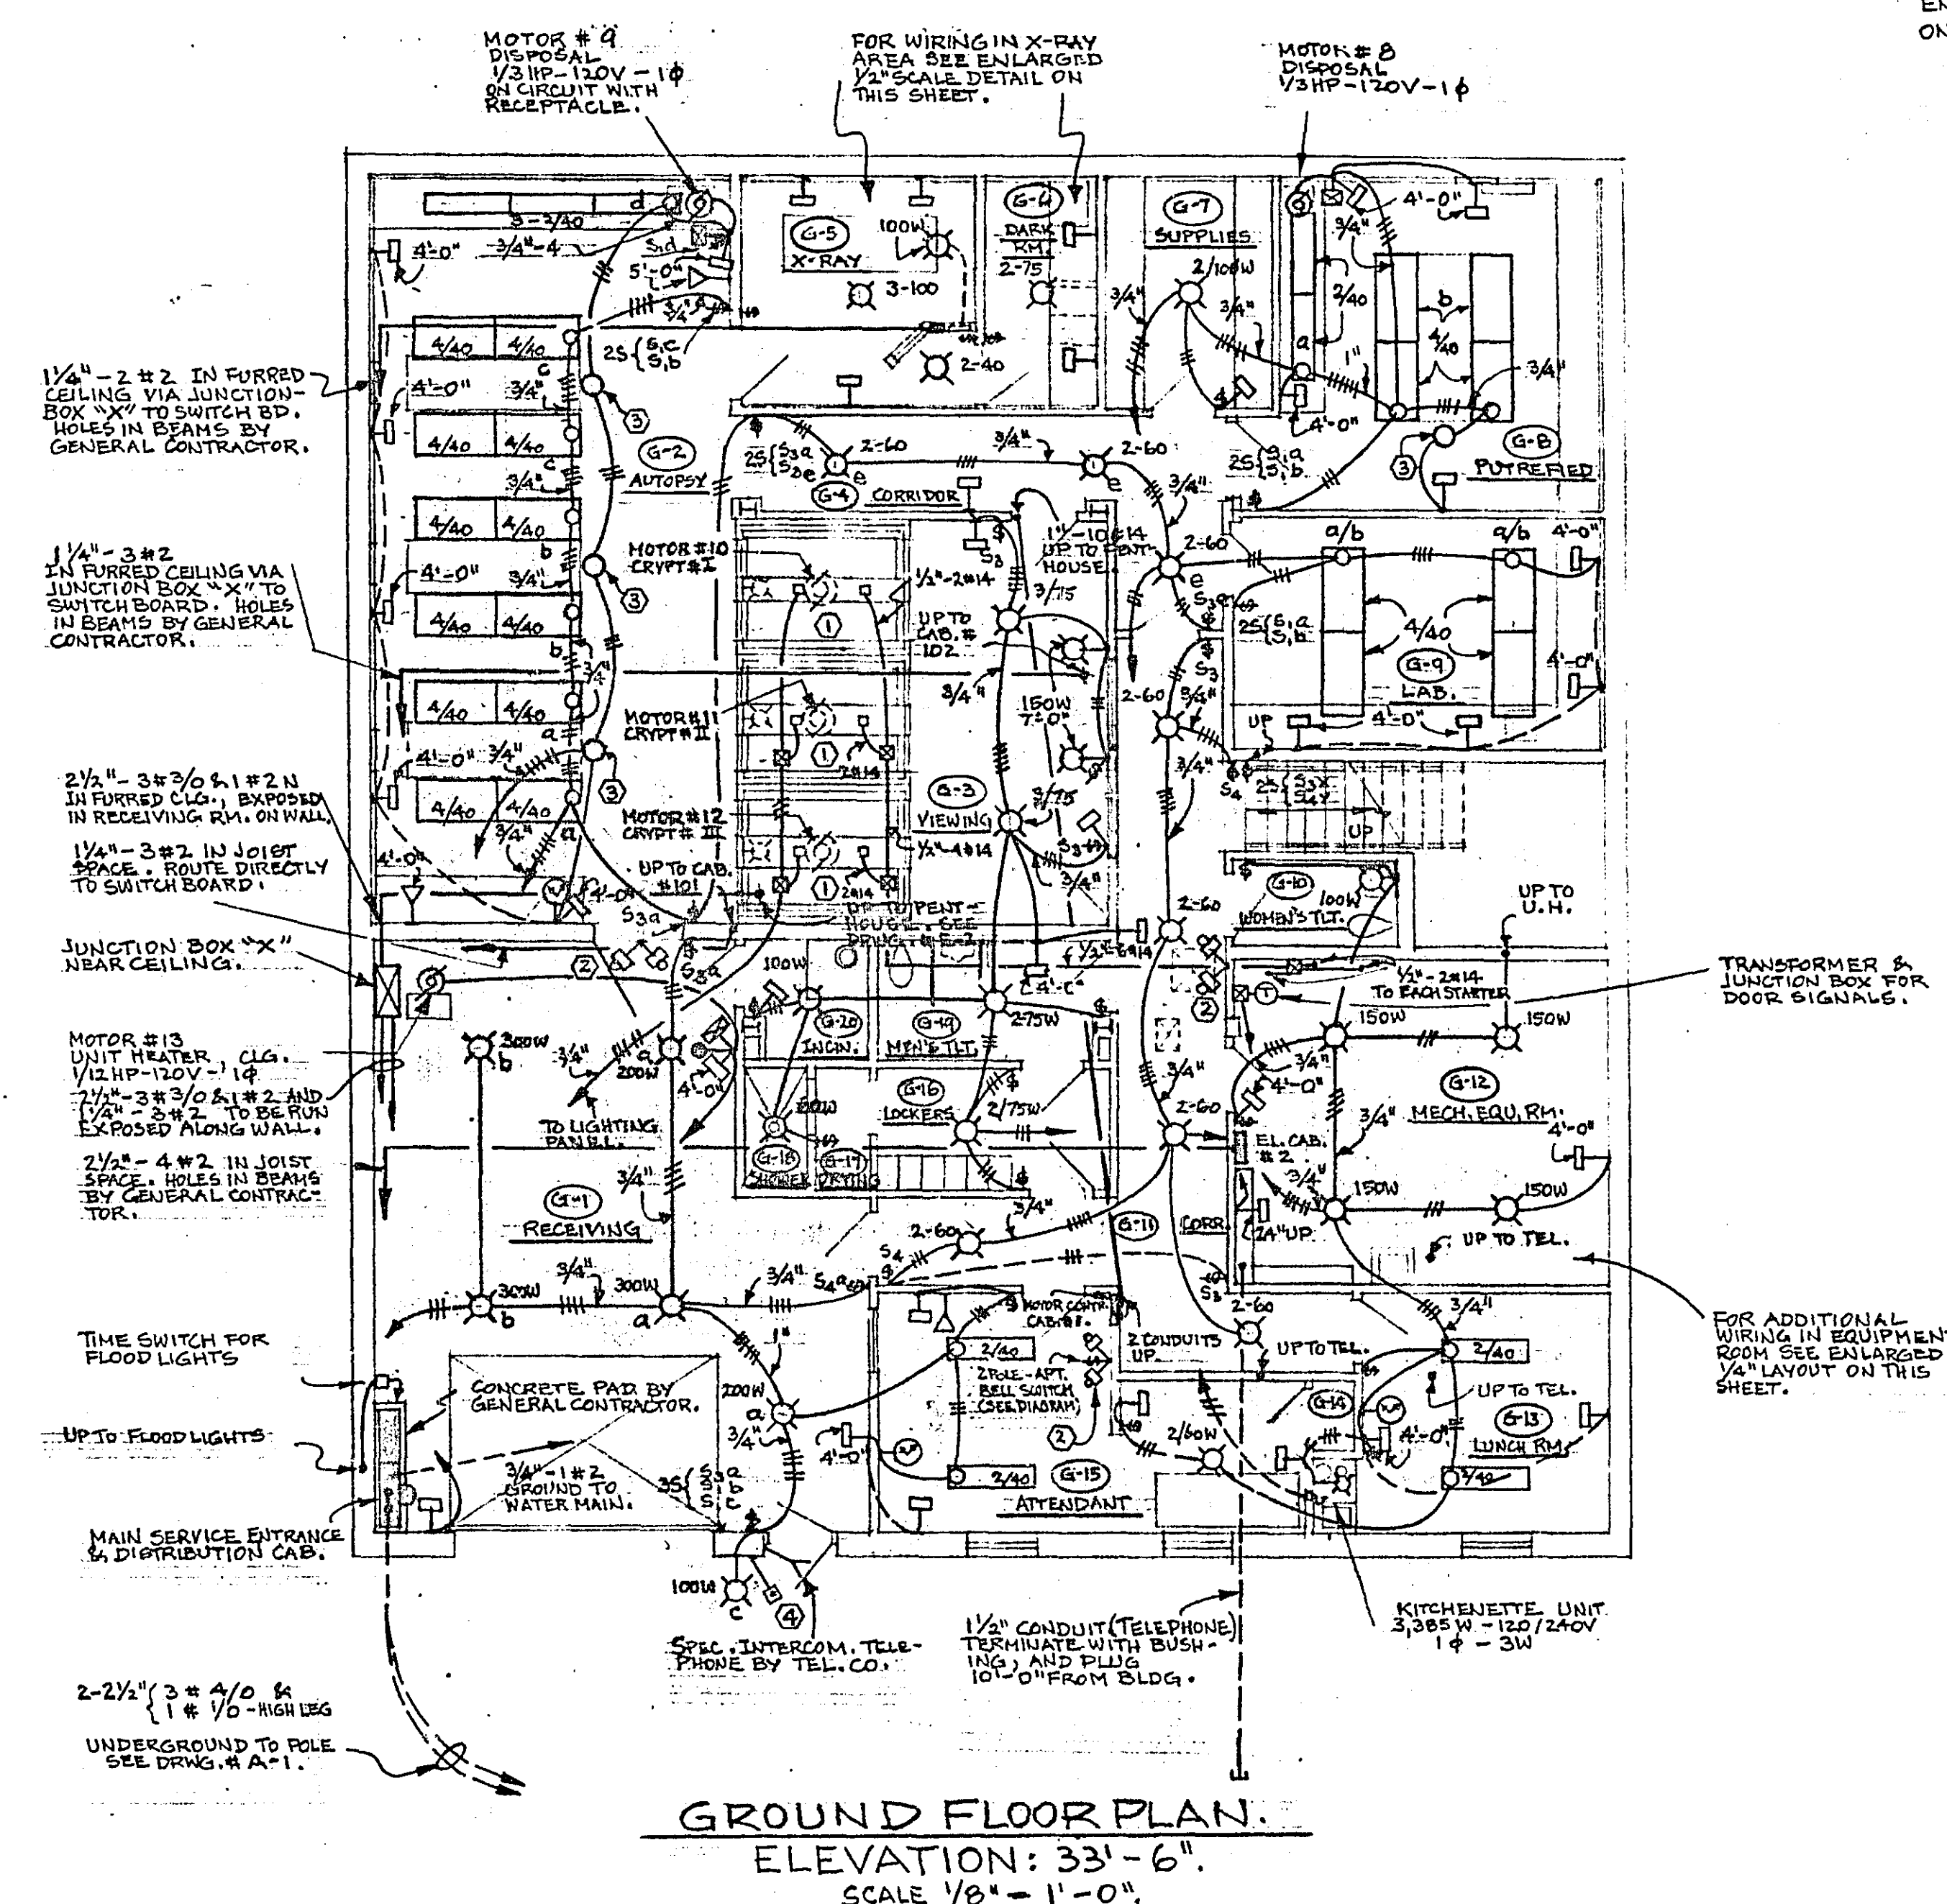


DETAIL OF CONDUIT ENTRANCE FOR INTERCOM.
AT EAST ENTRANCE (TYPICAL FOR SOUTH ENTRANCE)
SCALE 6" = 1'-0"

MICROFILMED
RAMSEY CO. ENGR


DESIGNED W.T.S.	I hereby certify that this plan was prepared by me or under my direct supervision and that I am a duly	COM.
DRAWN H.S.	Registered PROFESSIONAL ENGINEER	4603
CHECKED W.T.S.	under the laws of the State of Minnesota: <i>William T. Sheridan</i>	DRG.
	Date OCTOBER 7, 1963 Reg. No. 4607	E-1

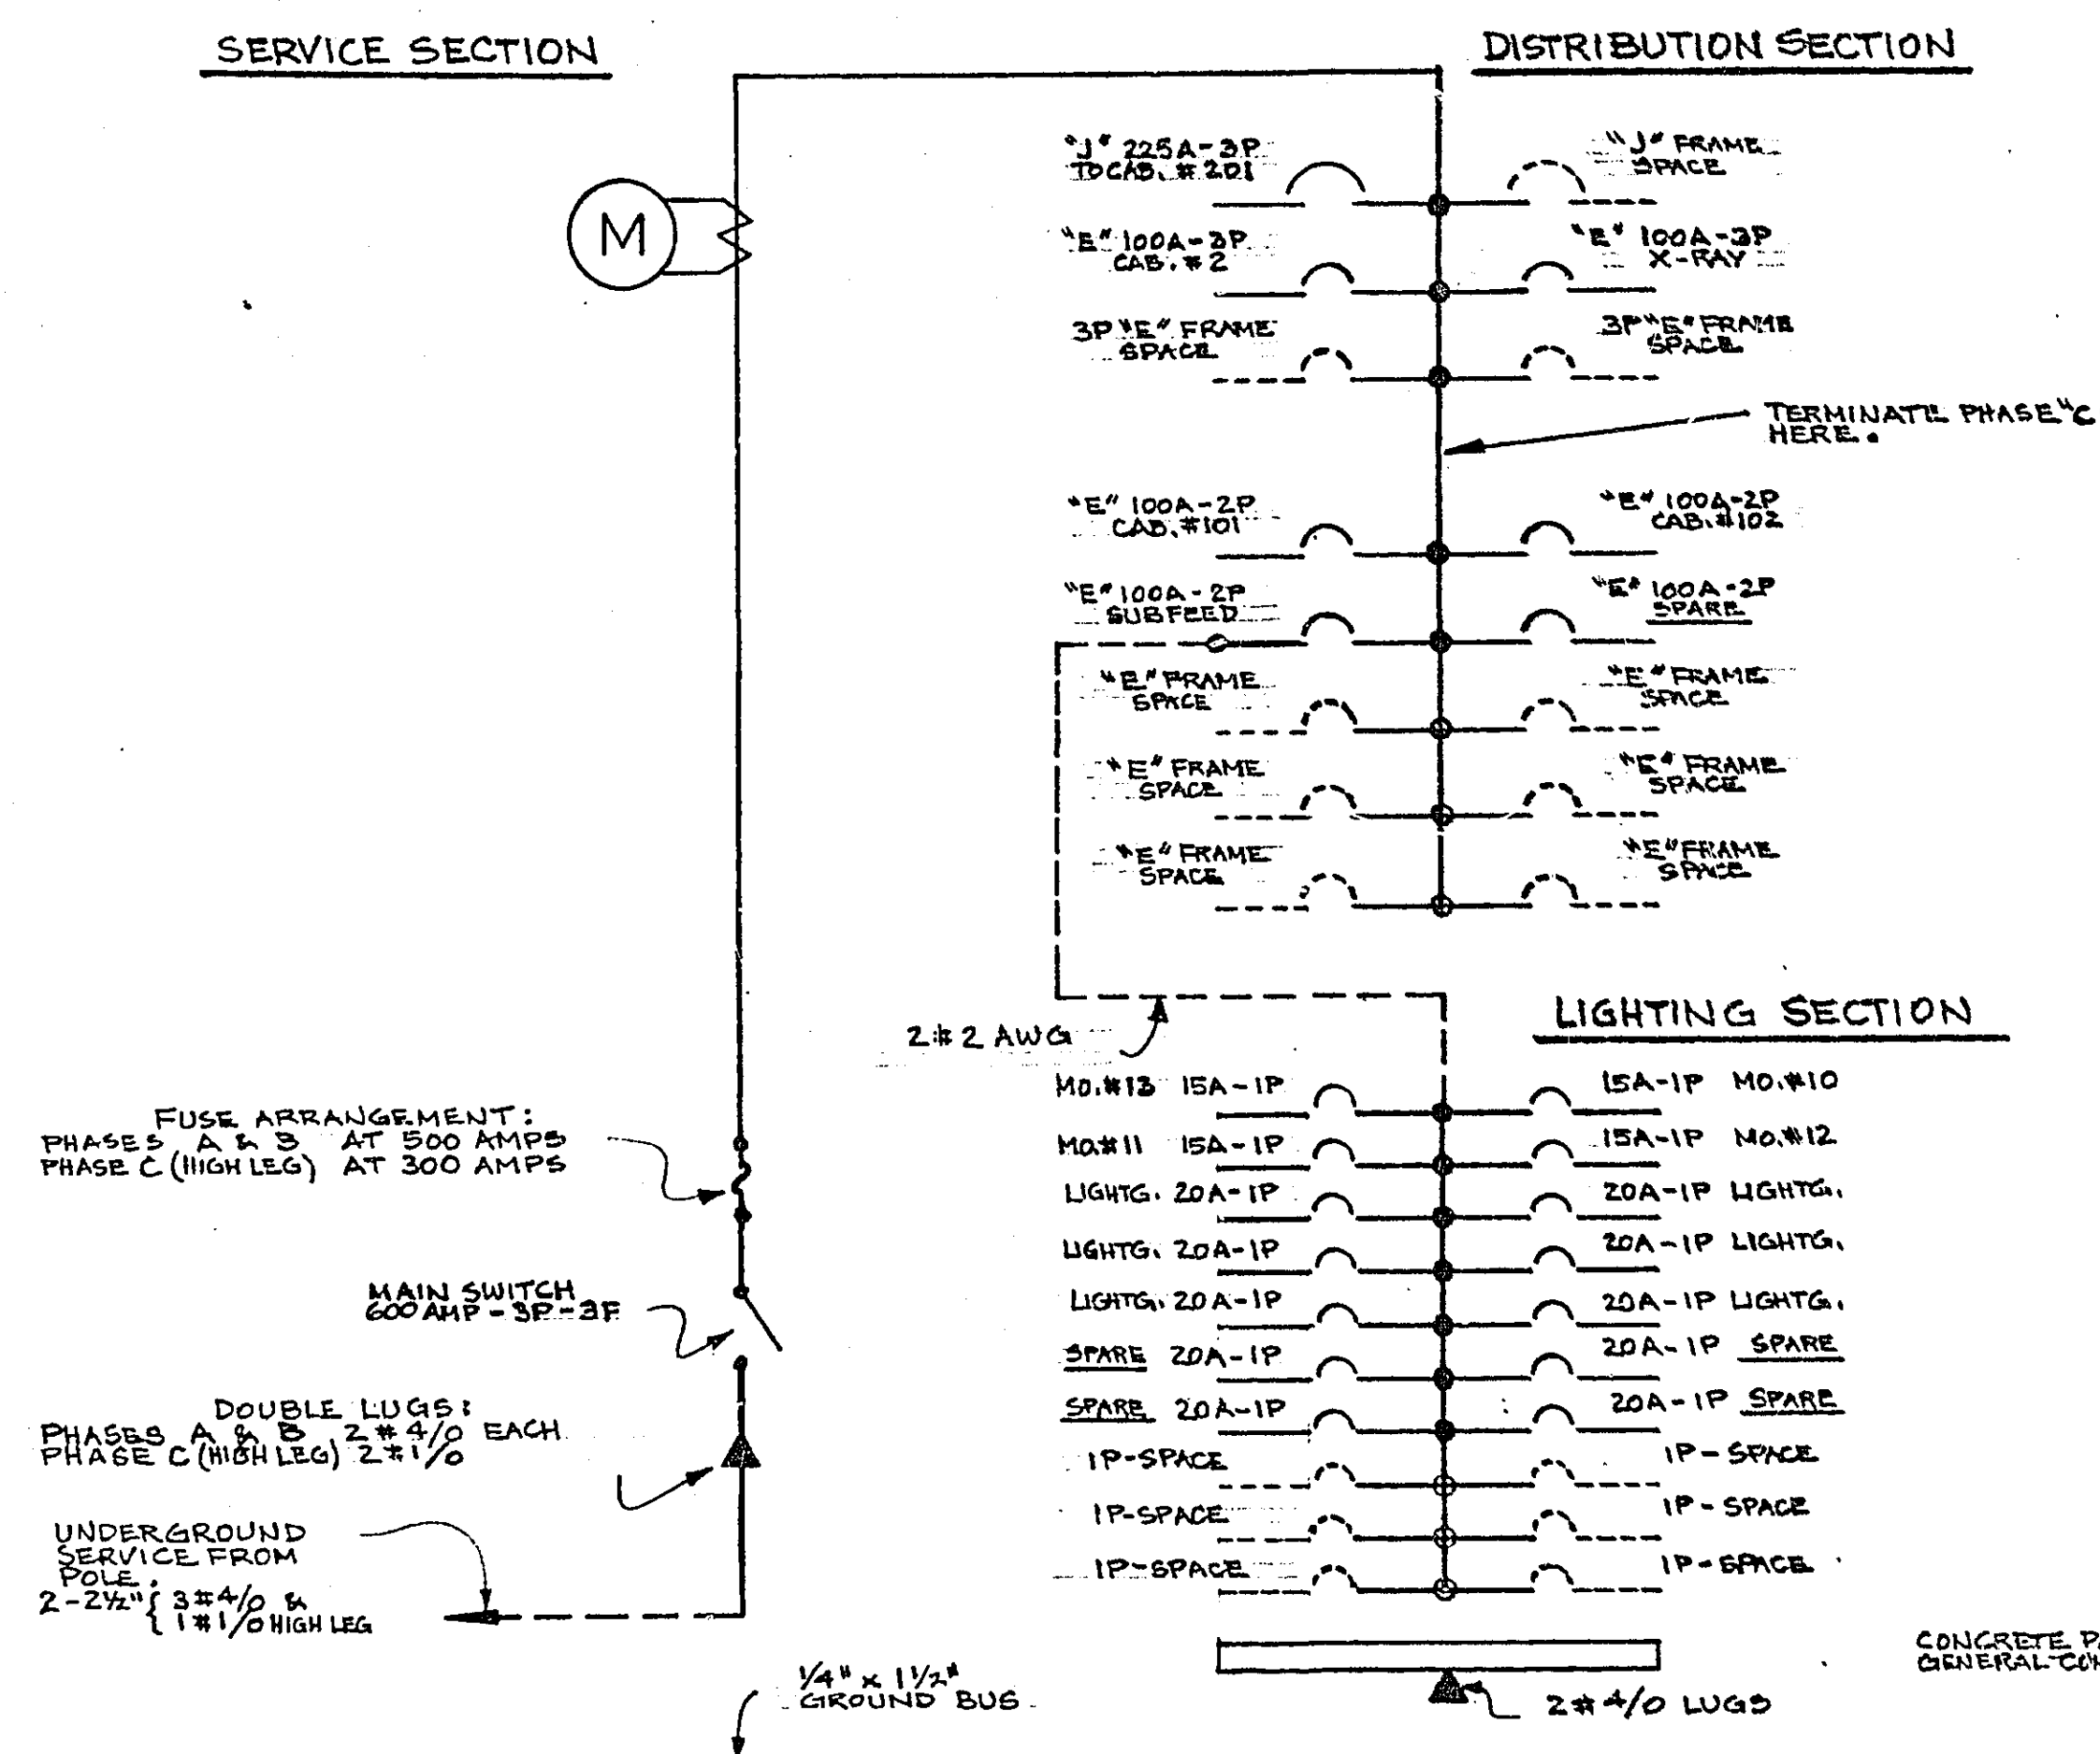





NO SCALE

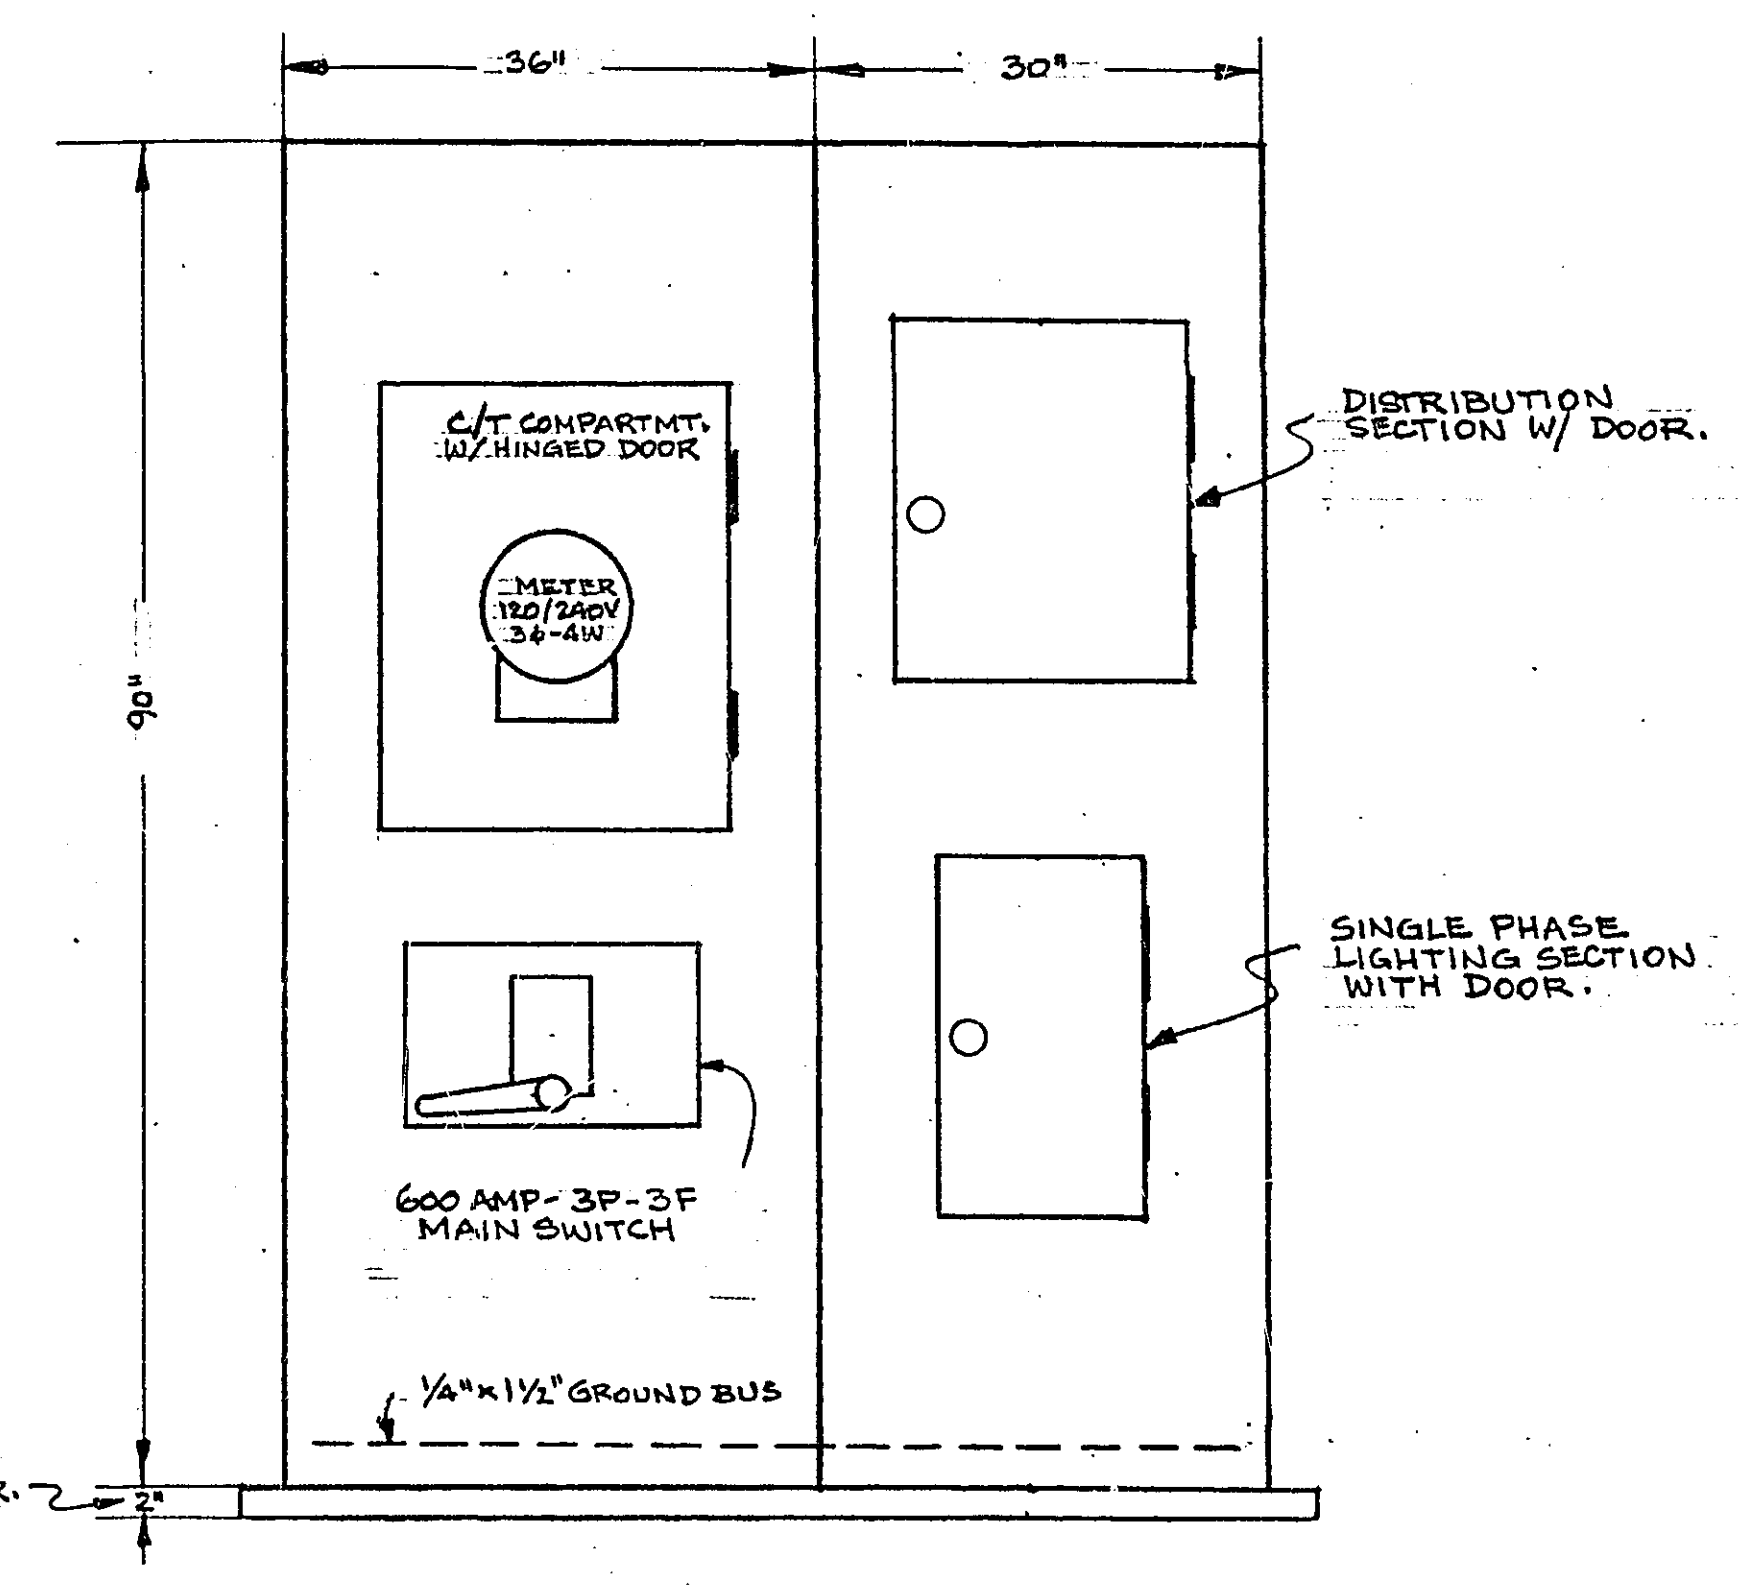

NO SCALE

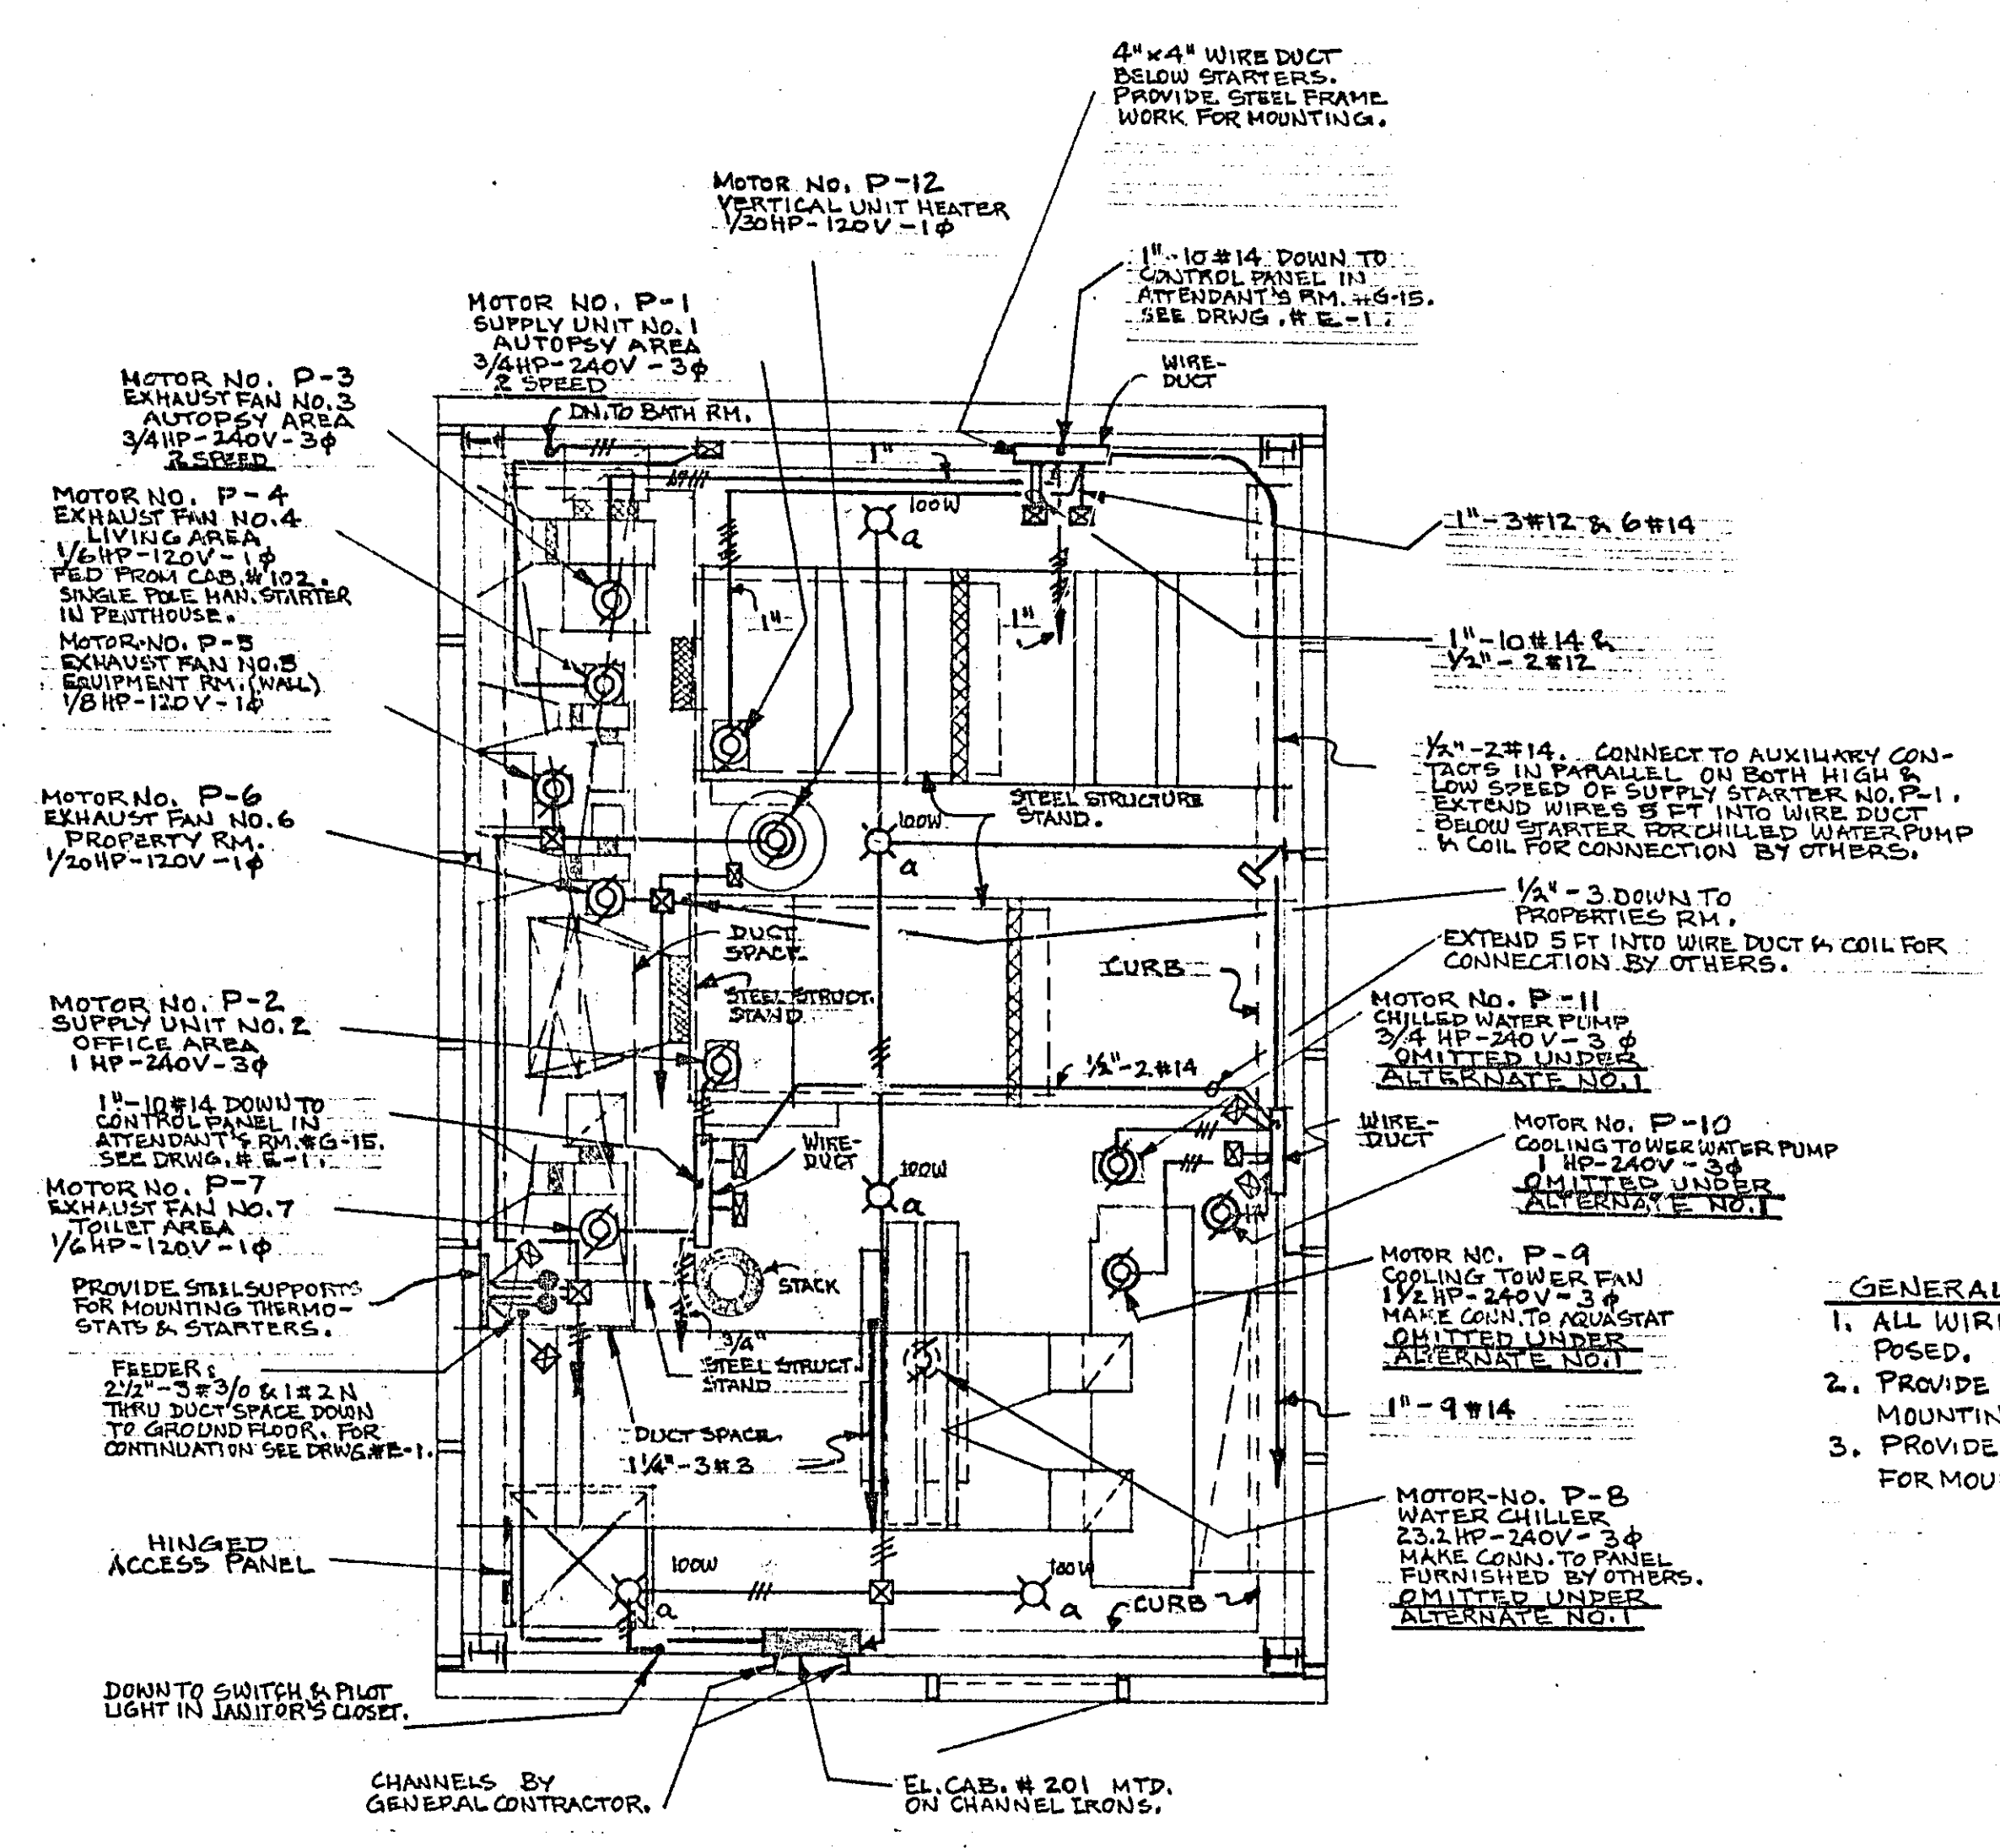

- GENERAL NOTES FOR PENTHOUSE:**
1. ALL WIRING IN PENTHOUSE TO BE EXPOSED.
 2. PROVIDE SHORT NIPPLE FOR FIXTURE MOUNTING TO CLEAR PIPING & DUCTS.
 3. PROVIDE STEEL SUPPORTS AS REQUIRED FOR MOUNTING STARTERS & WIRE DUCTS.

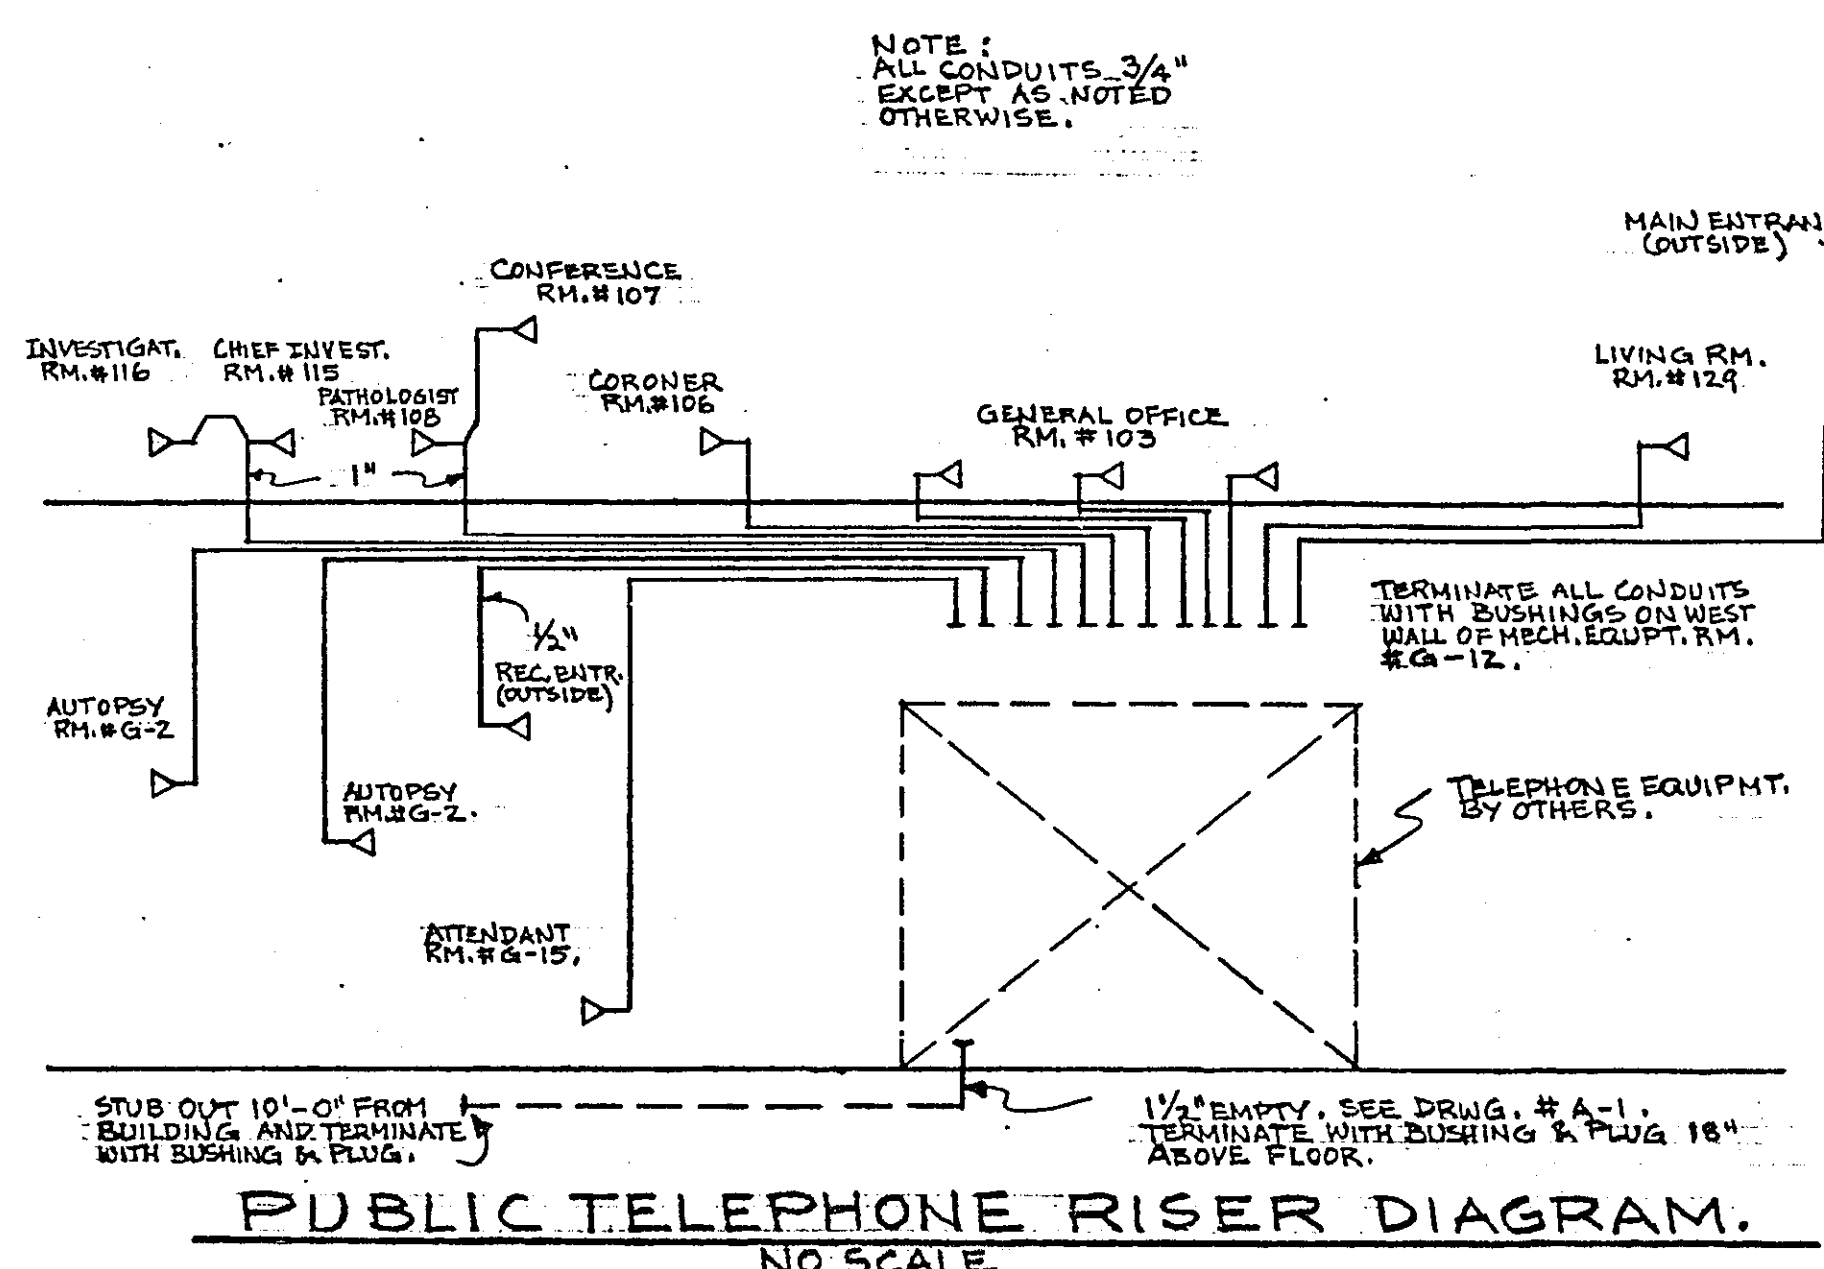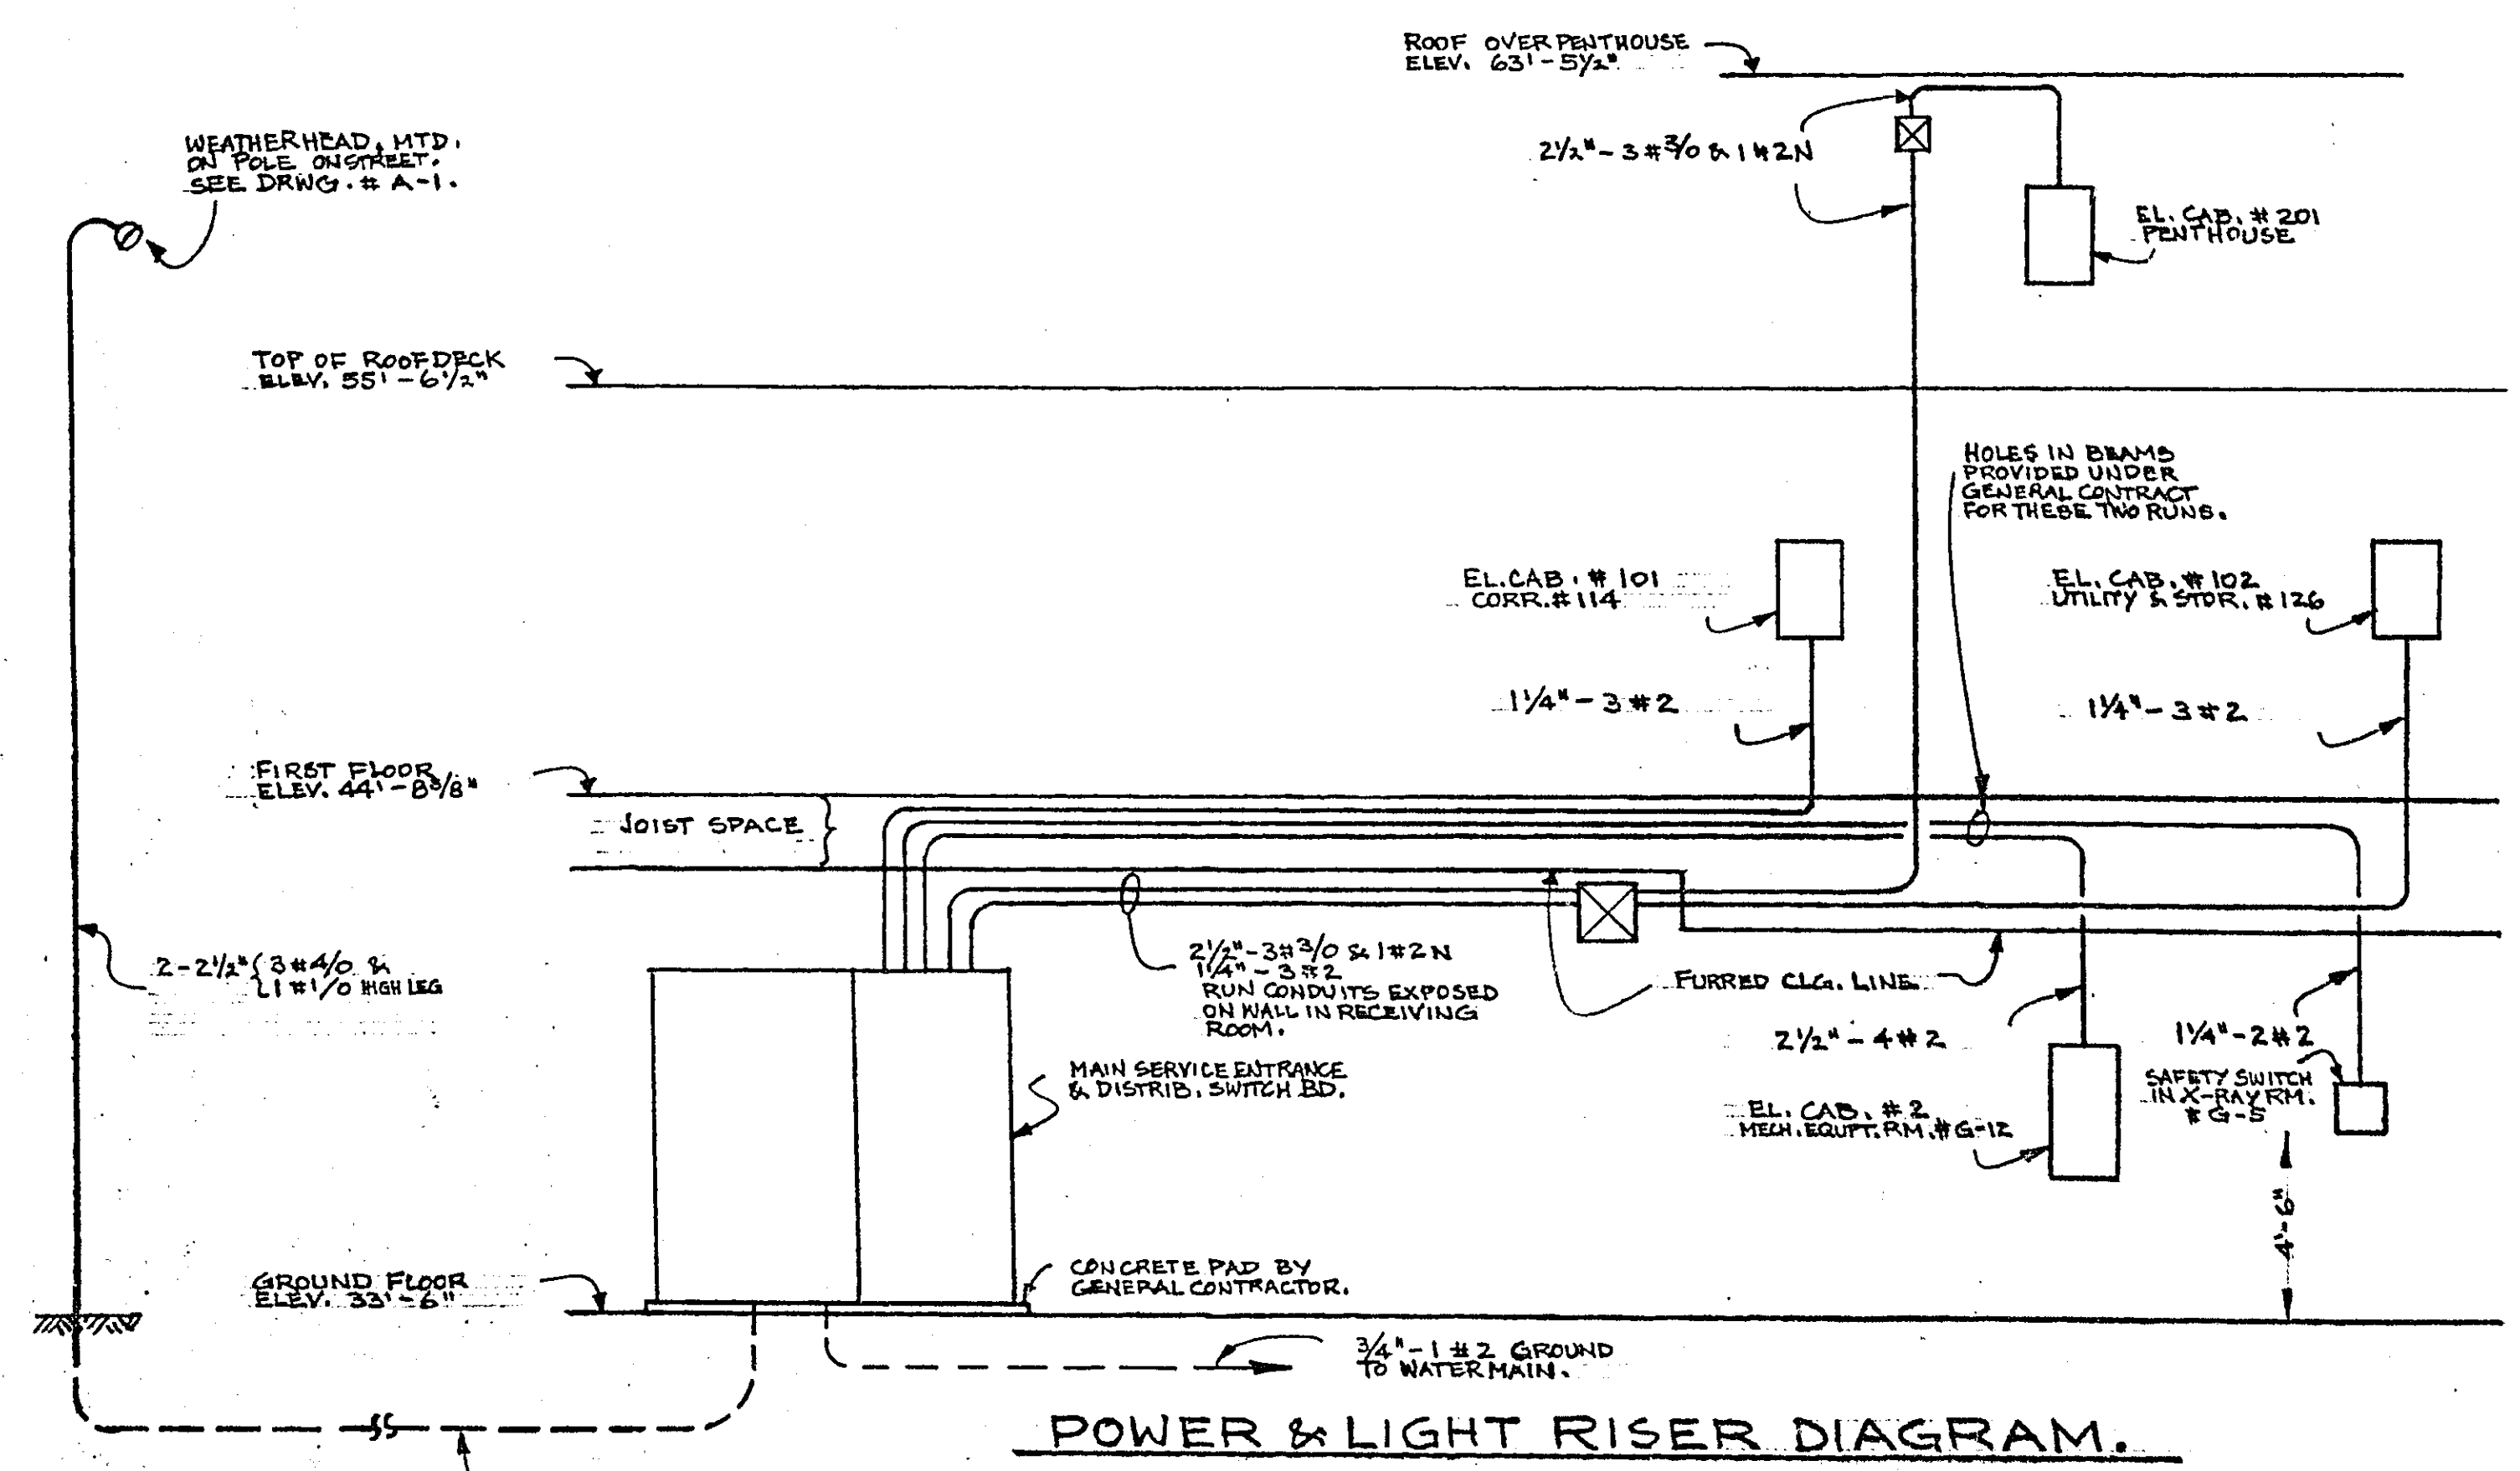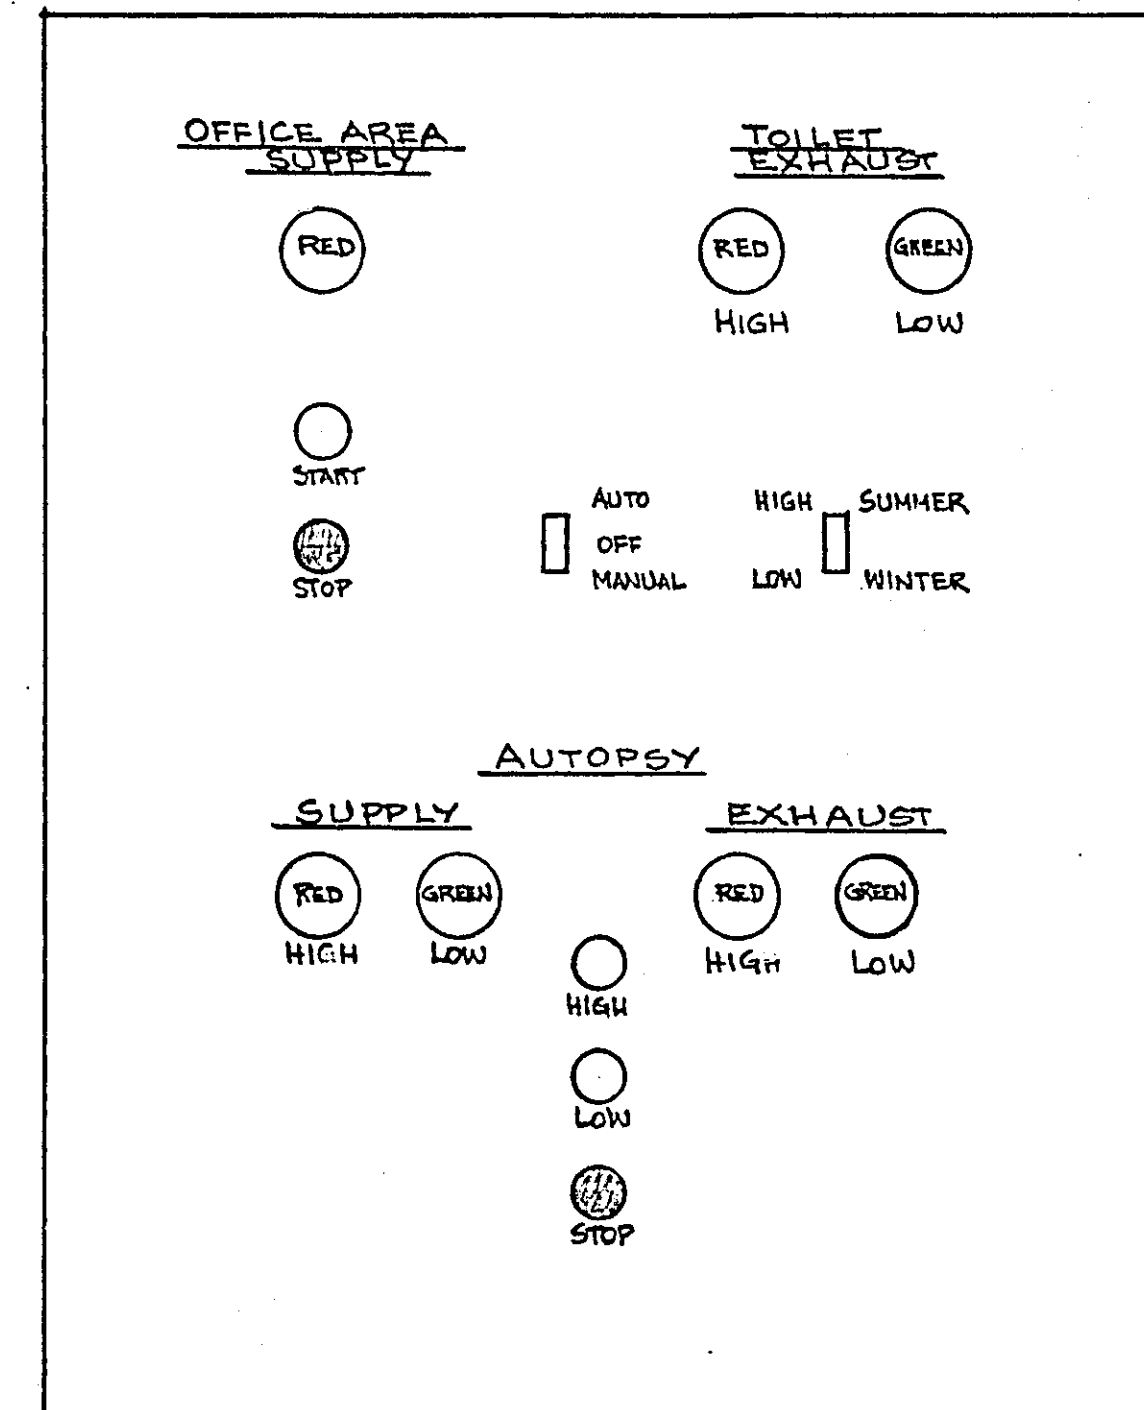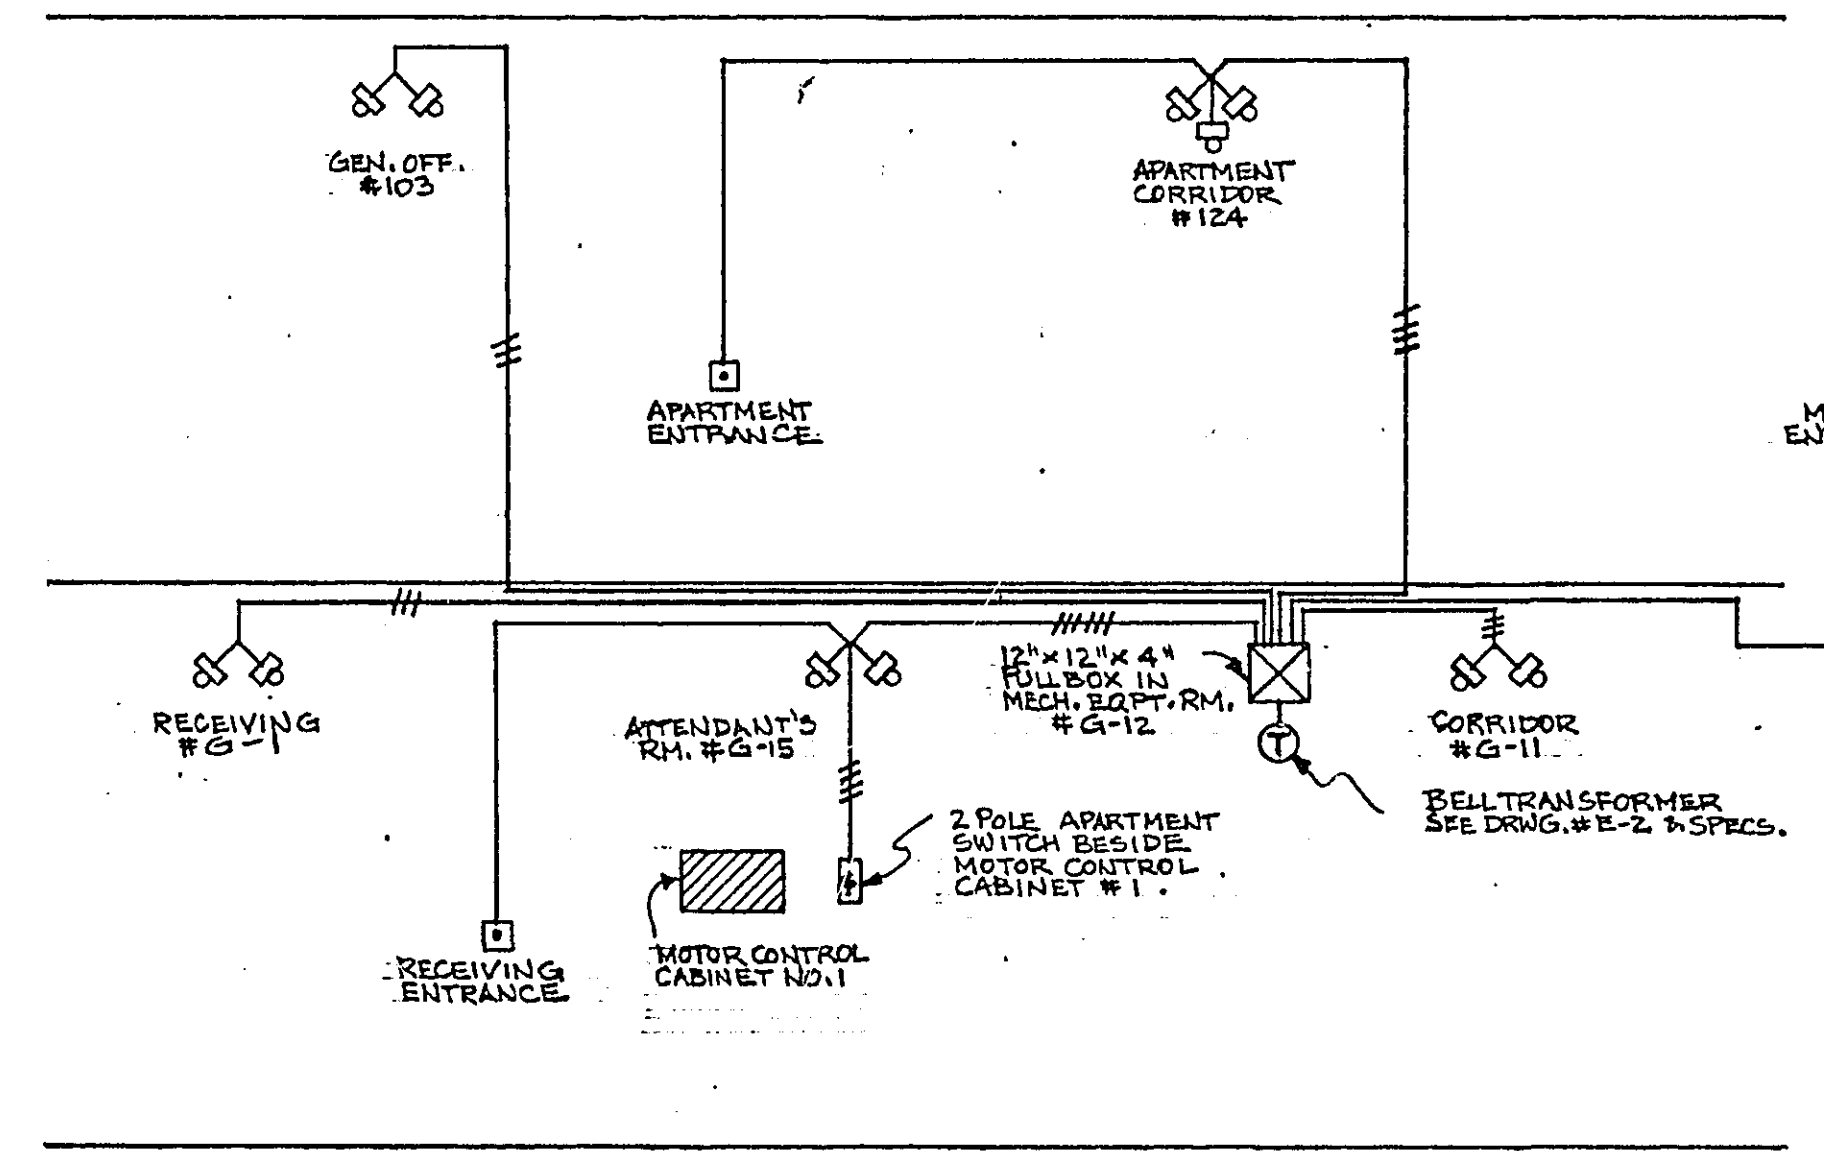

RAMSEY COUNTY CORONERS OFFICE

ST. PAUL, MINNESOTA

TOLTZ, KING, DUVALL, ANDERSON AND ASSOCIATES, INC.

ST. PAUL, MINNESOTA

ENGINEERS AND ARCHITECTS

DESIGNED BY: W.T.S.

DRAWN BY: H.J.S.

CHECKED BY: W.T.S.

DATE: OCTOBER 7, 1963

REG. NO. 4607

COM. 4603

DRG. E-2