




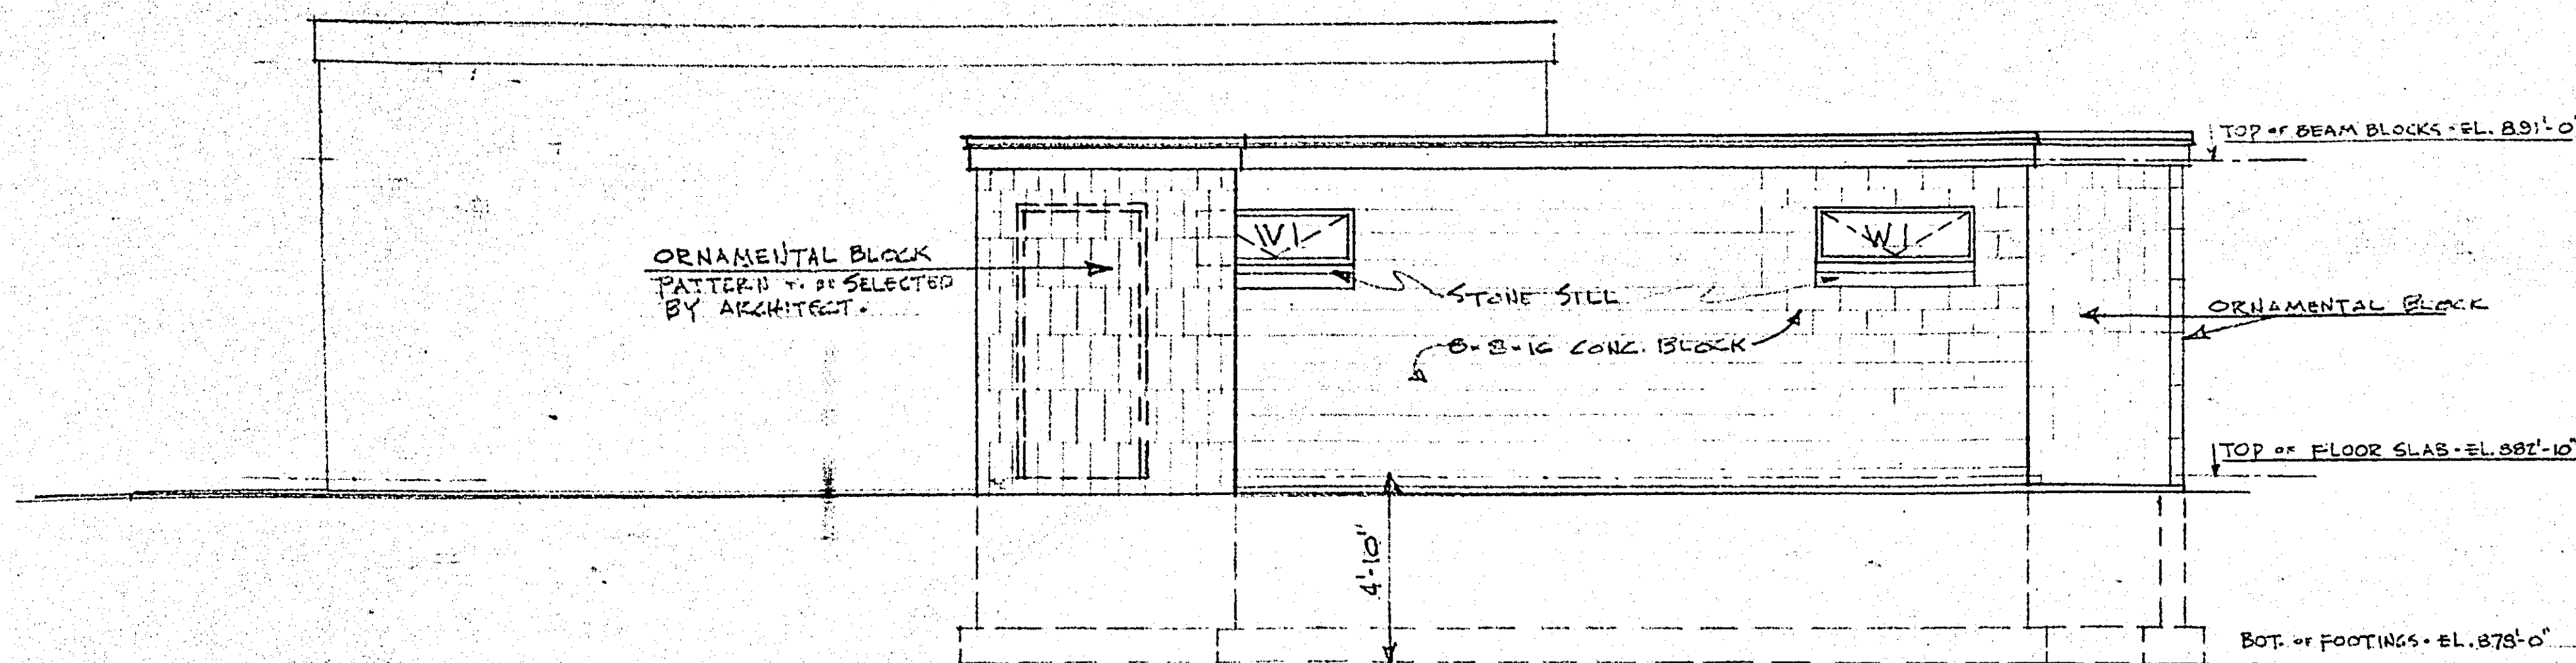


NORTH ELEVATION  
1/4" = 1' - 0"

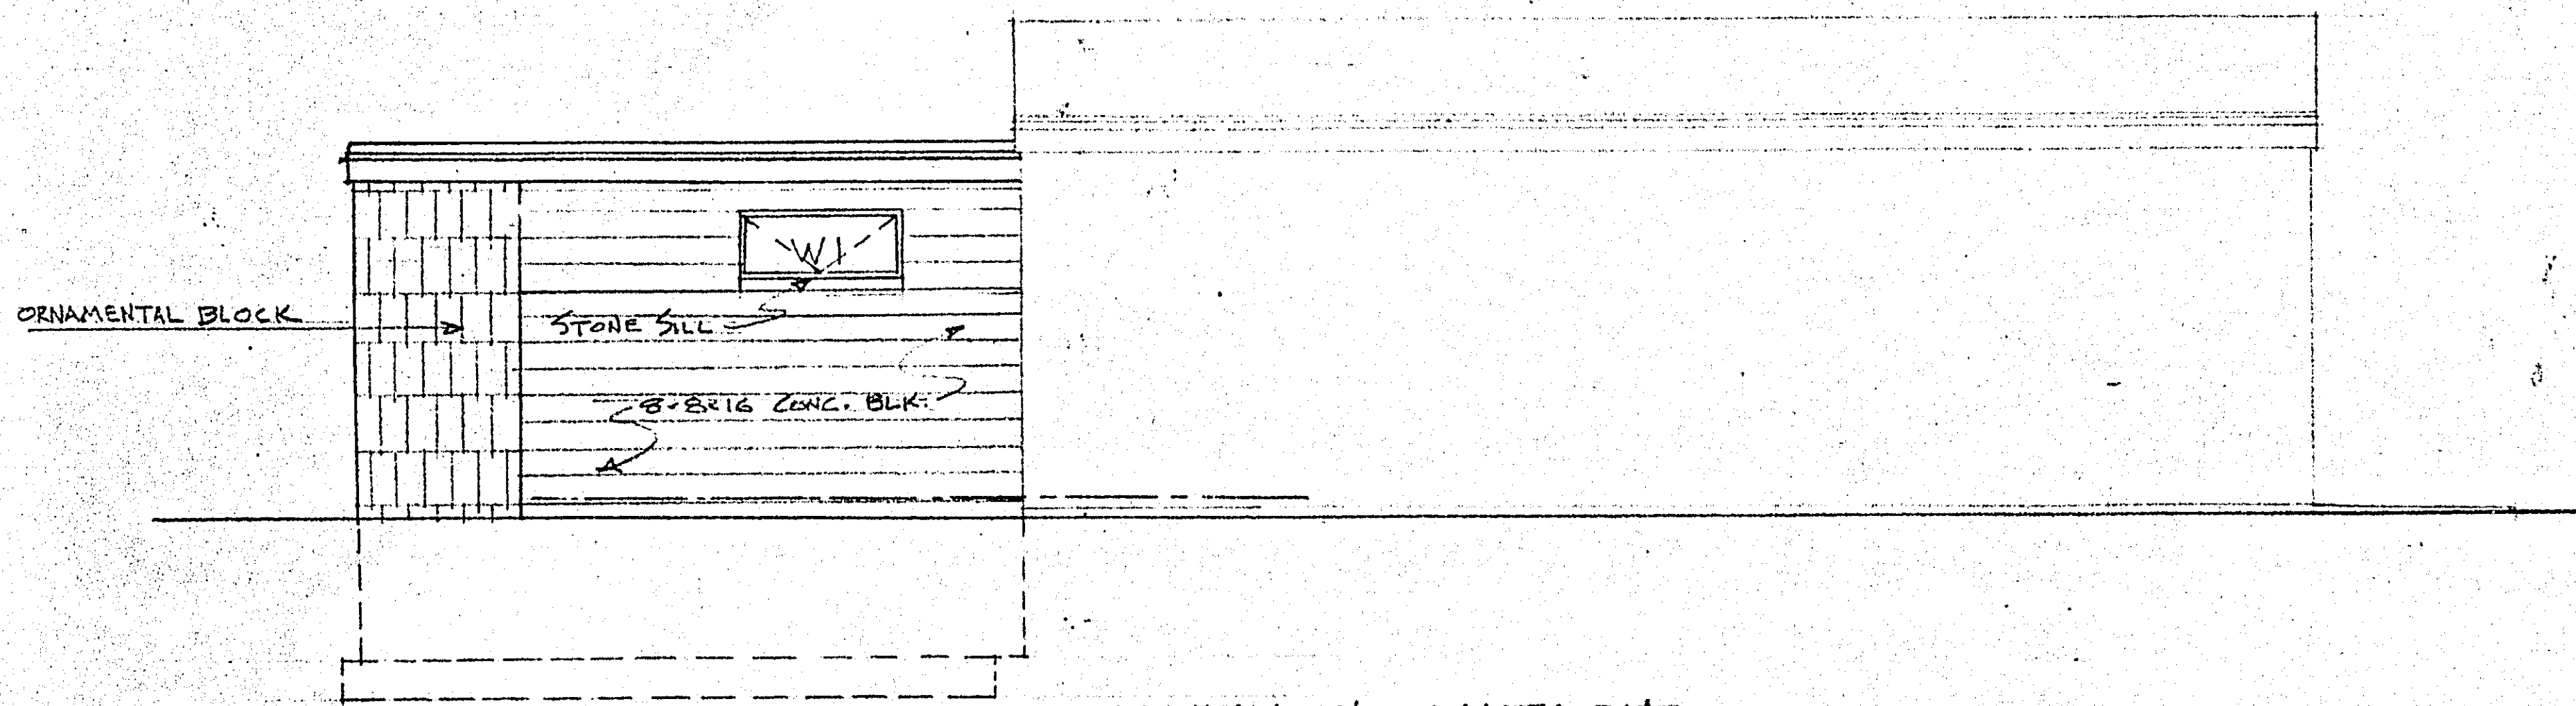



SOUTH ELEVATION  
1/4" = 1' - 0"

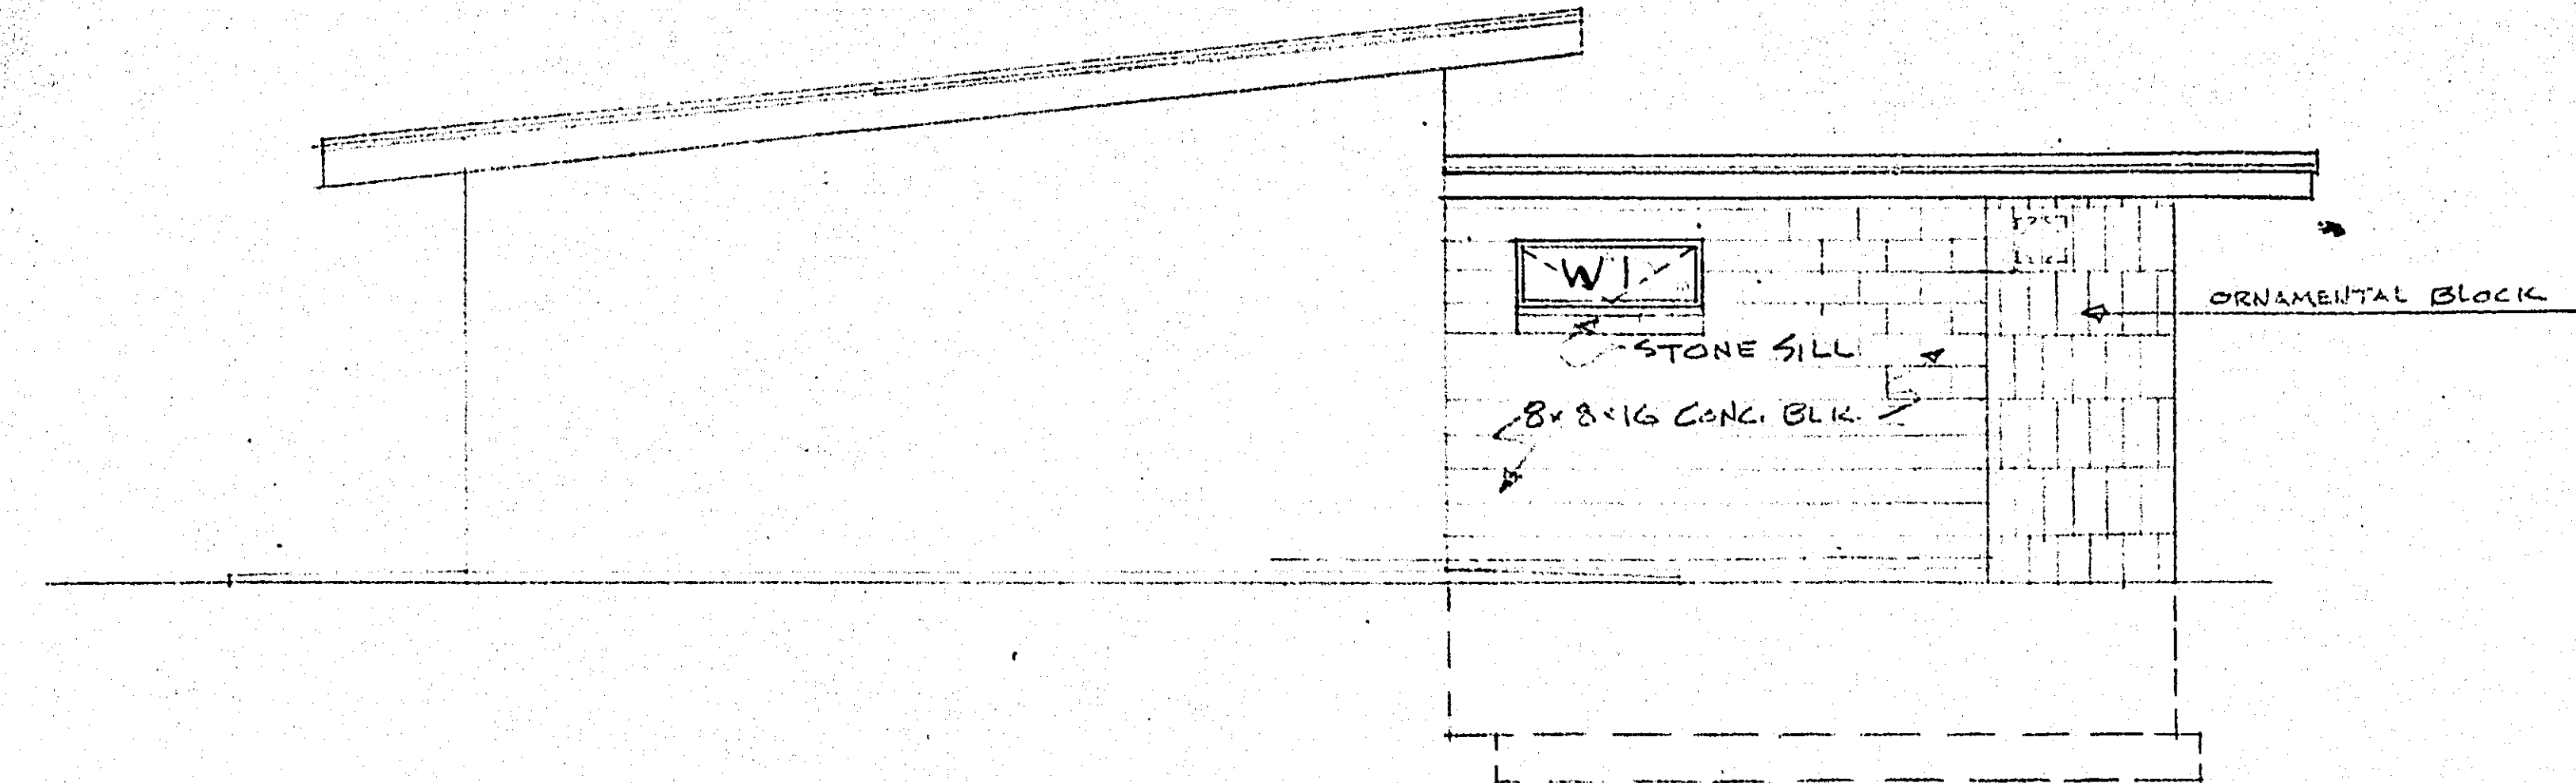


EAST ELEVATION  
1/4" = 1' - 0"

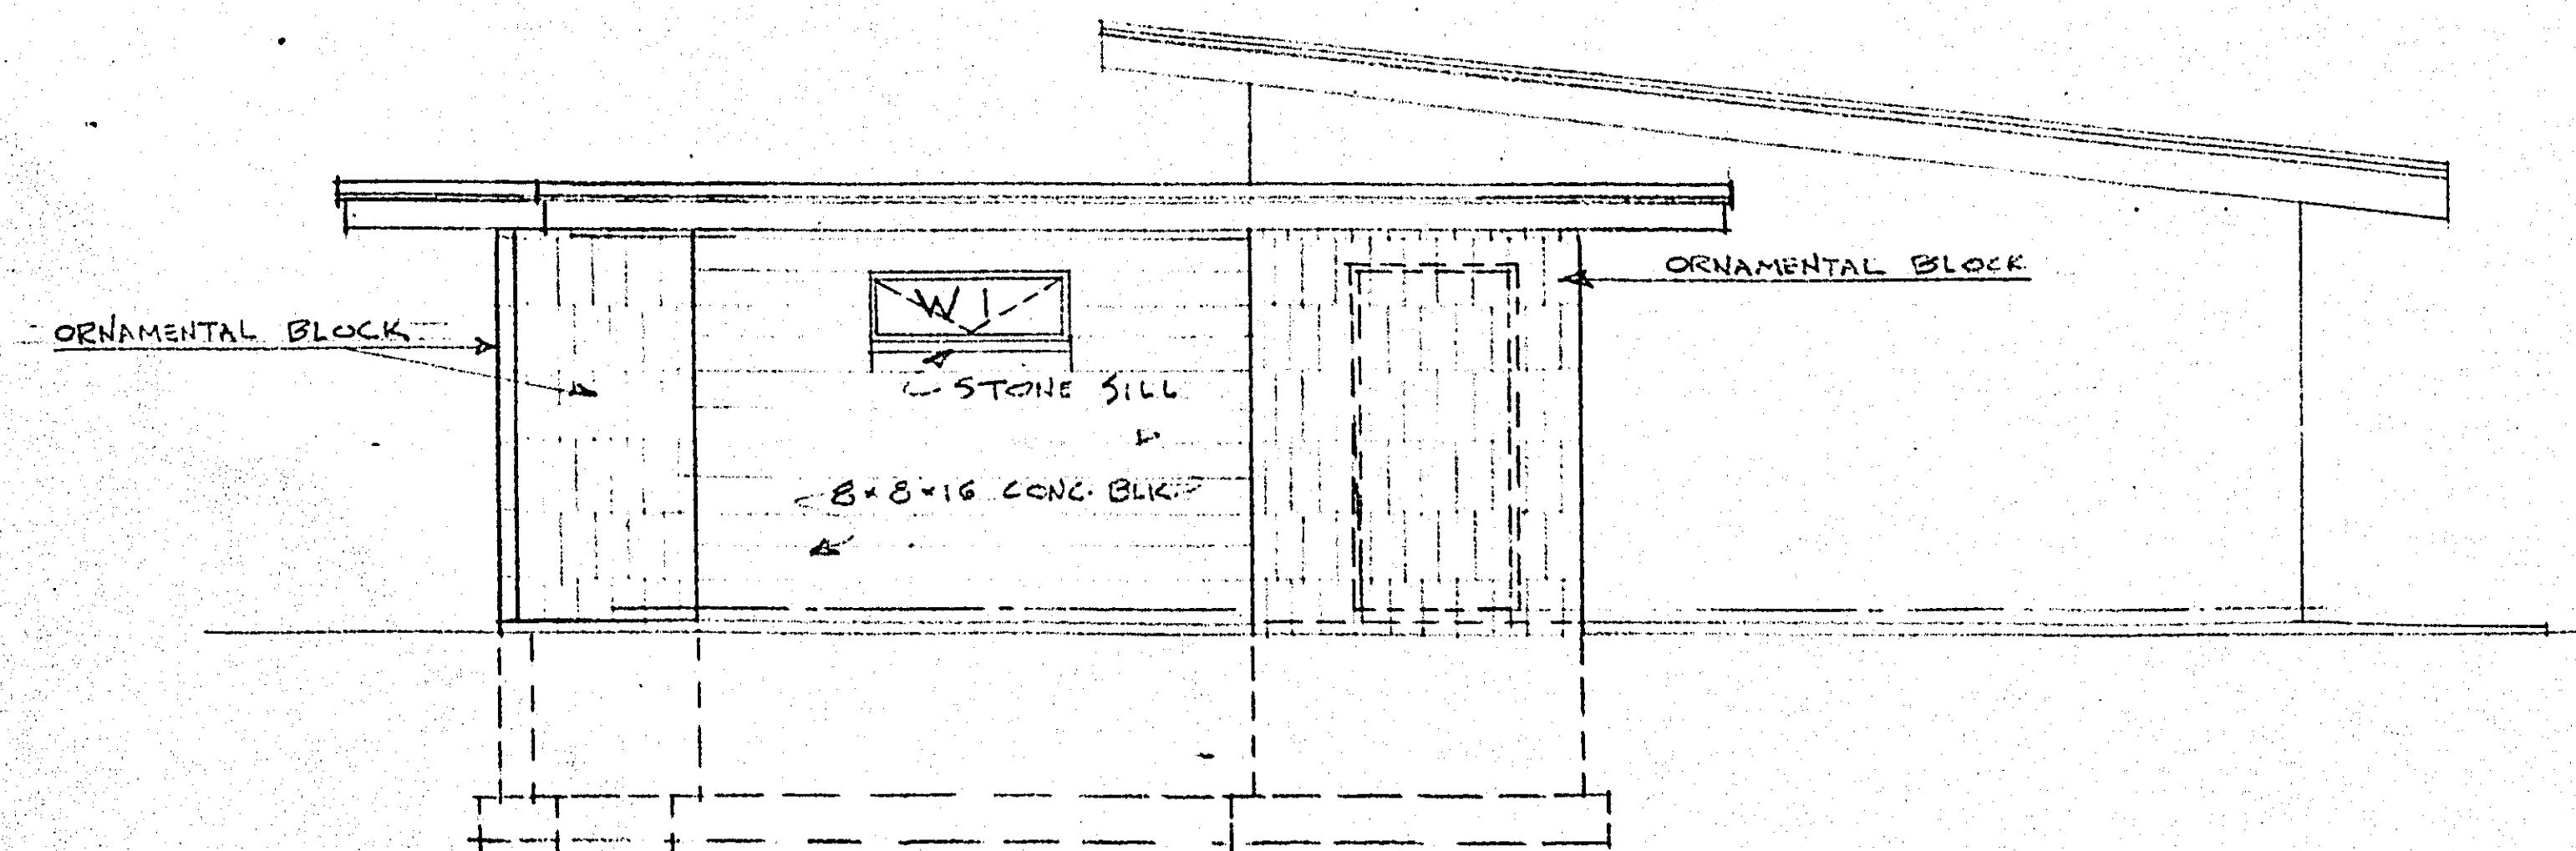


WEST ELEVATION  
1/4" = 1' - 0"

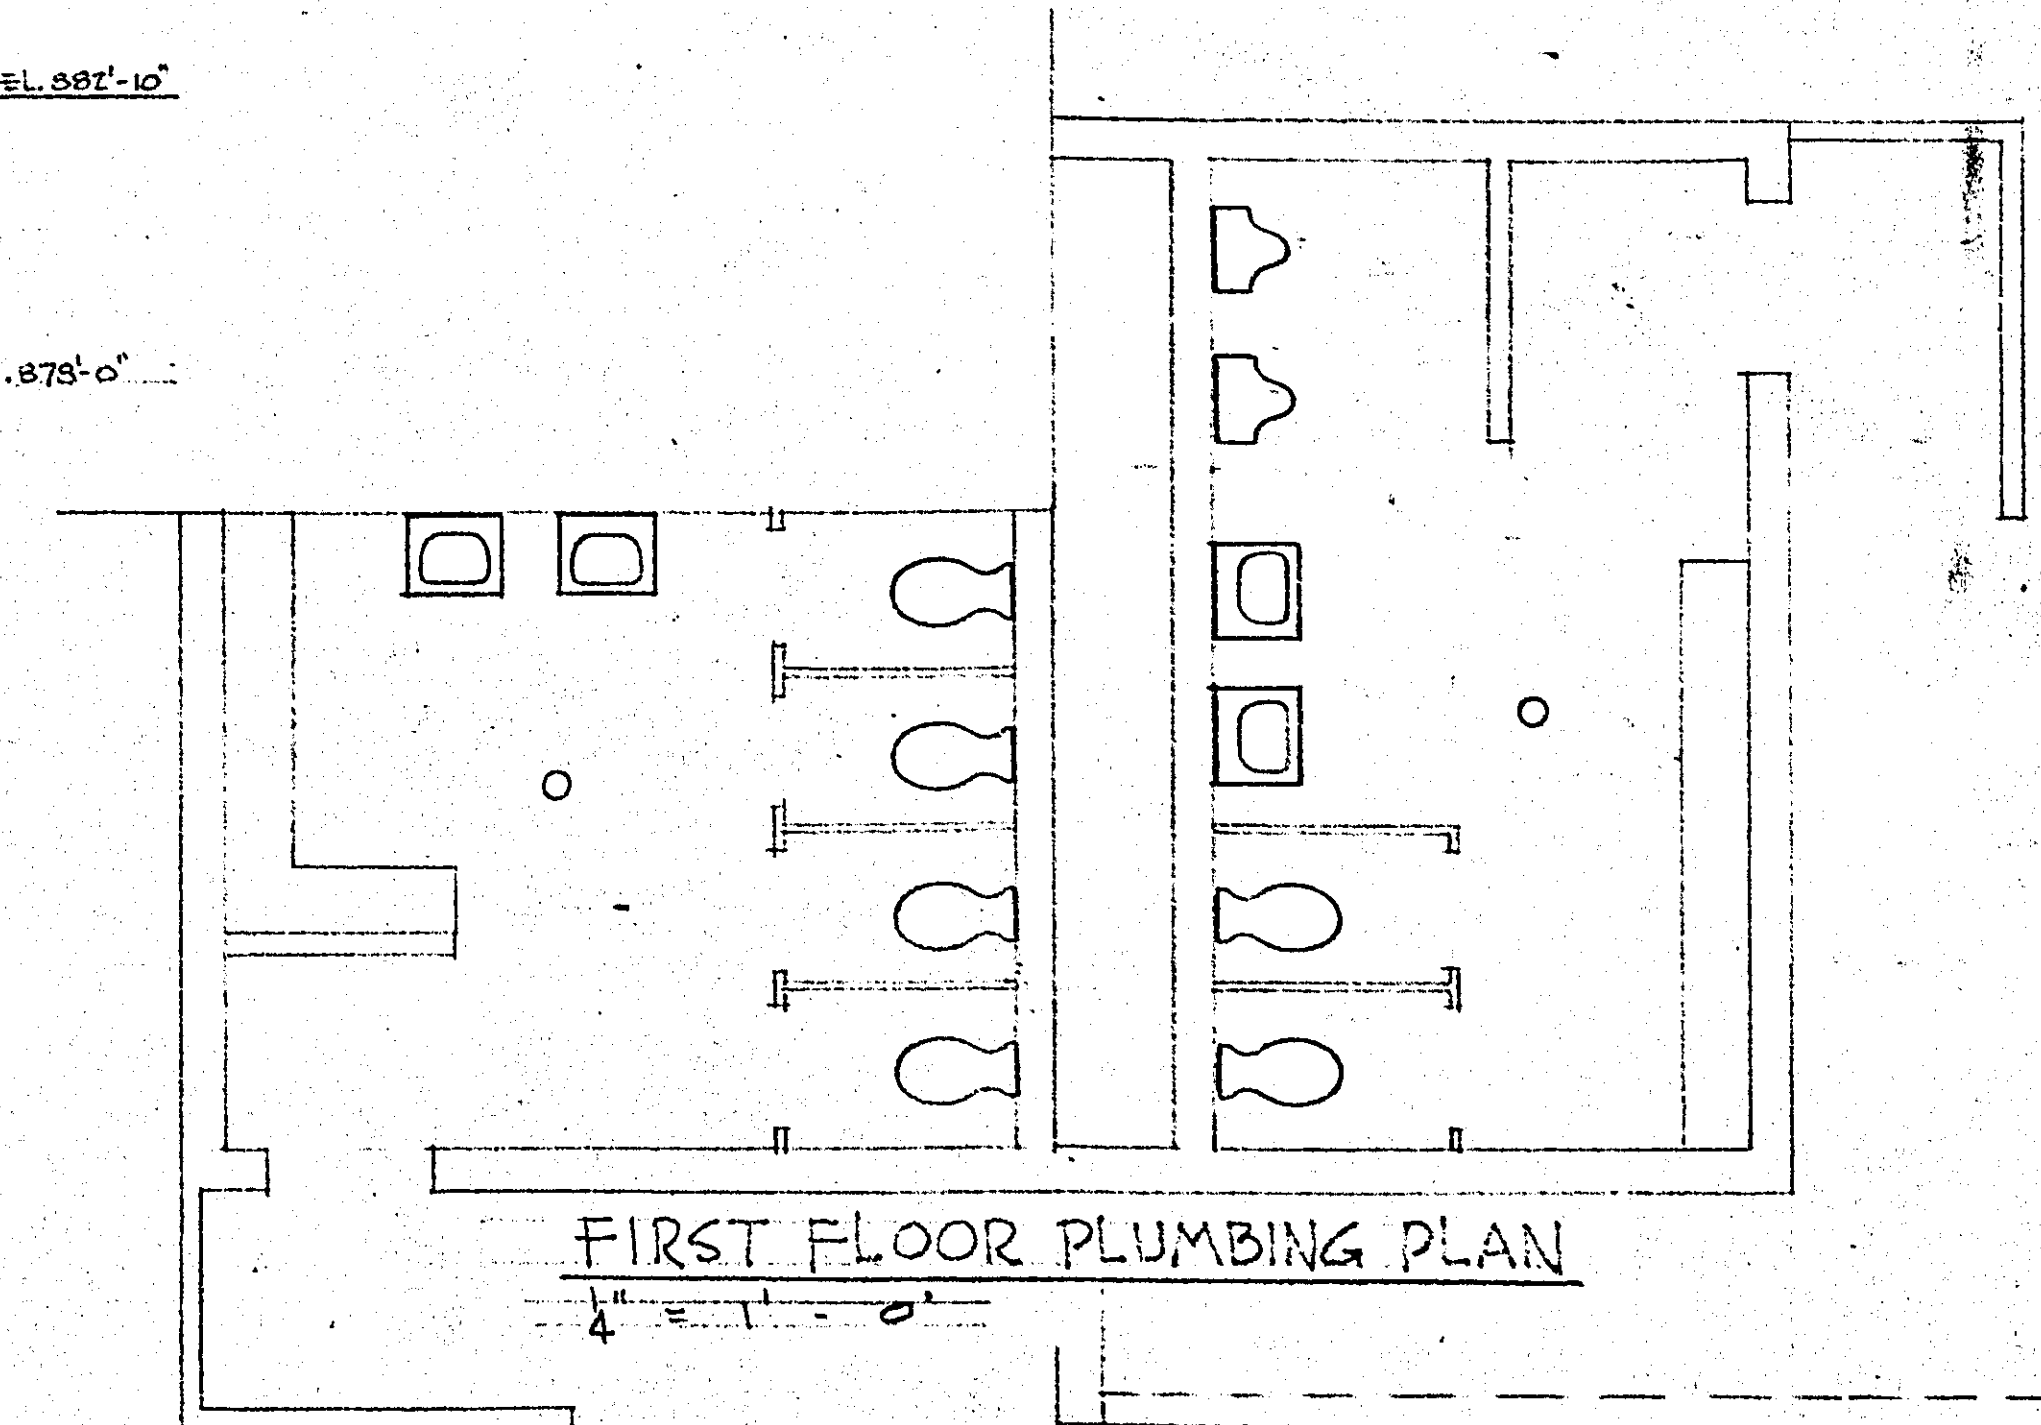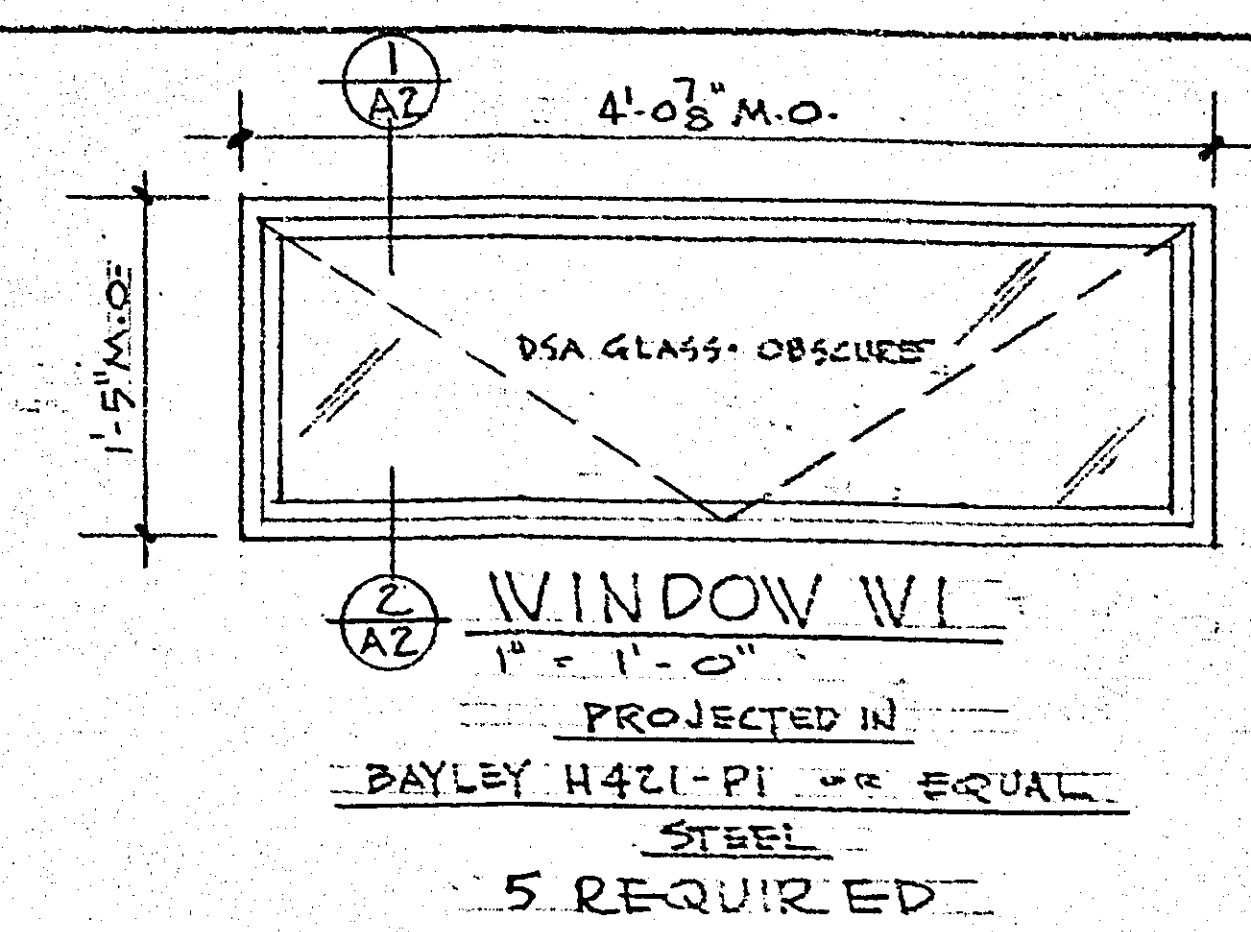

FIRST FLOOR PLUMBING PLAN  
1/4" = 1' - 0"

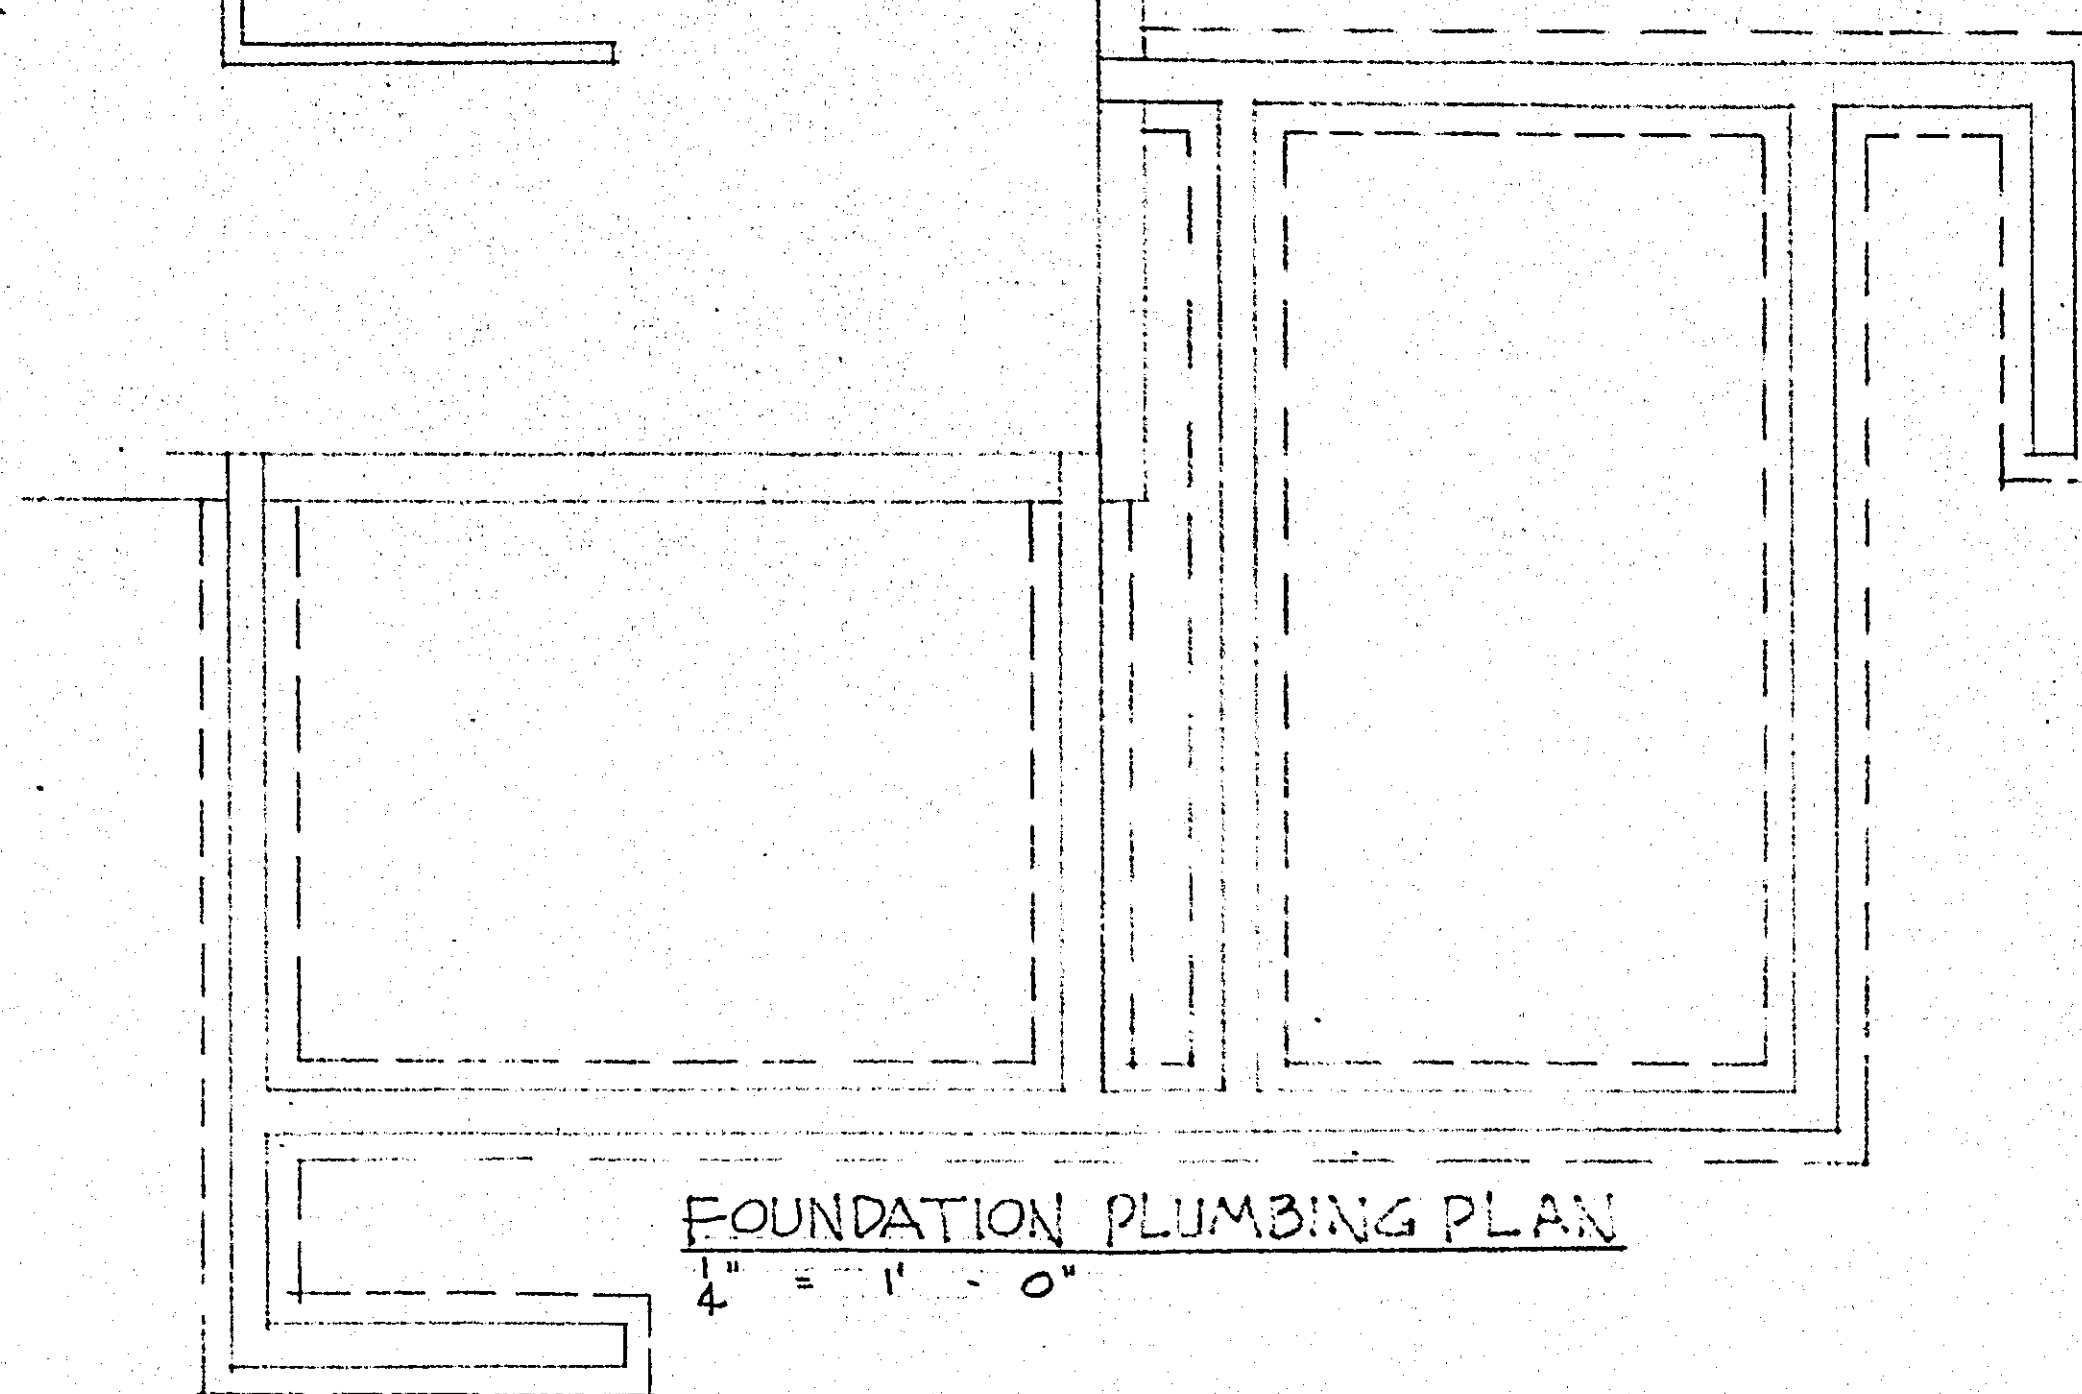

FOUNDATION PLUMBING PLAN  
1/4" = 1' - 0"

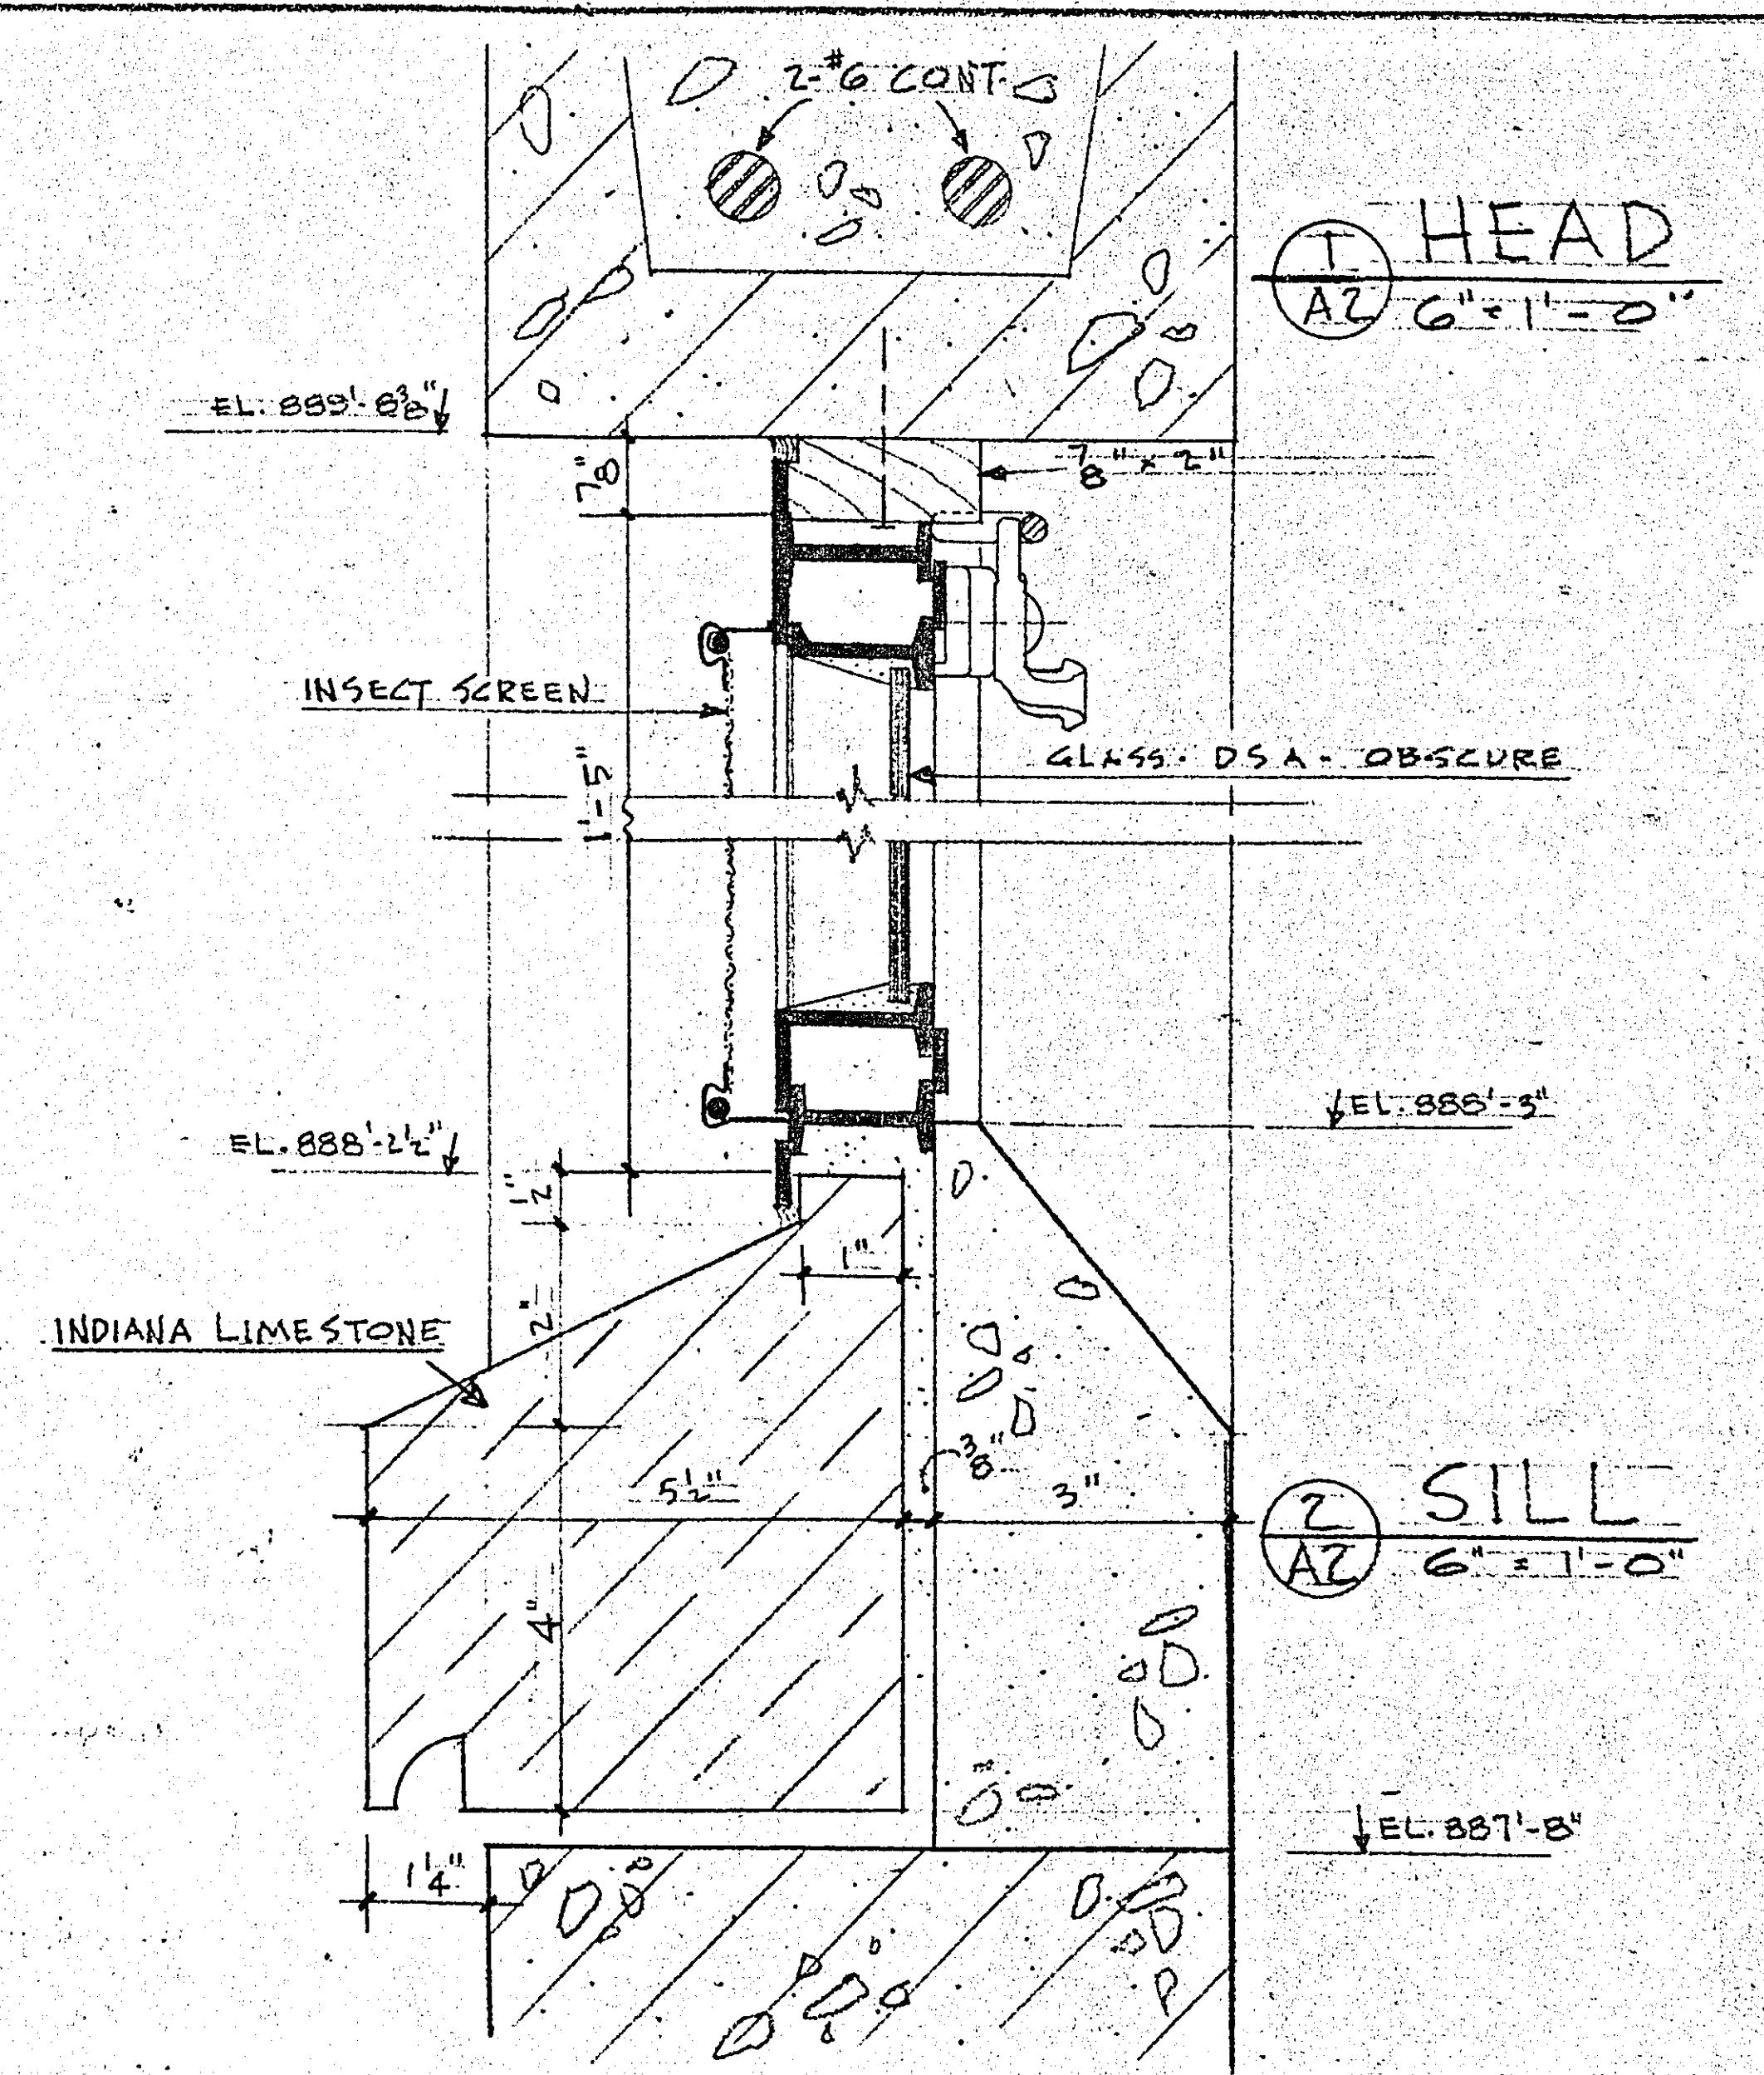

JUN 14 1965

FOR FINAL CHECKING

| NO. | DATE | REVISIONS | BY |
|-----|------|-----------|----|
|     |      |           |    |
|     |      |           |    |
ELEVATIONS & DETAILS

AN ADDITION TO  
LAKE JOHANNA REFECTORY  
RAMSEY COUNTY  
MINNESOTA

MICROFILMED  
RAMSEY CO. ENGR.

| GAUGER & ASSOCIATES - ARCHITECTS & ENGINEERS<br>FIRST FEDERAL BLDG. - ST. PAUL - MINN. |            |         |         |             |
|----------------------------------------------------------------------------------------|------------|---------|---------|-------------|
| DRAWN BY                                                                               | CHECKED BY | DATE    | JOB NO. | DRAWING NO. |
| H.R.B.                                                                                 | P.R.G.     | 6-14-65 | 218A-2  |             |



