




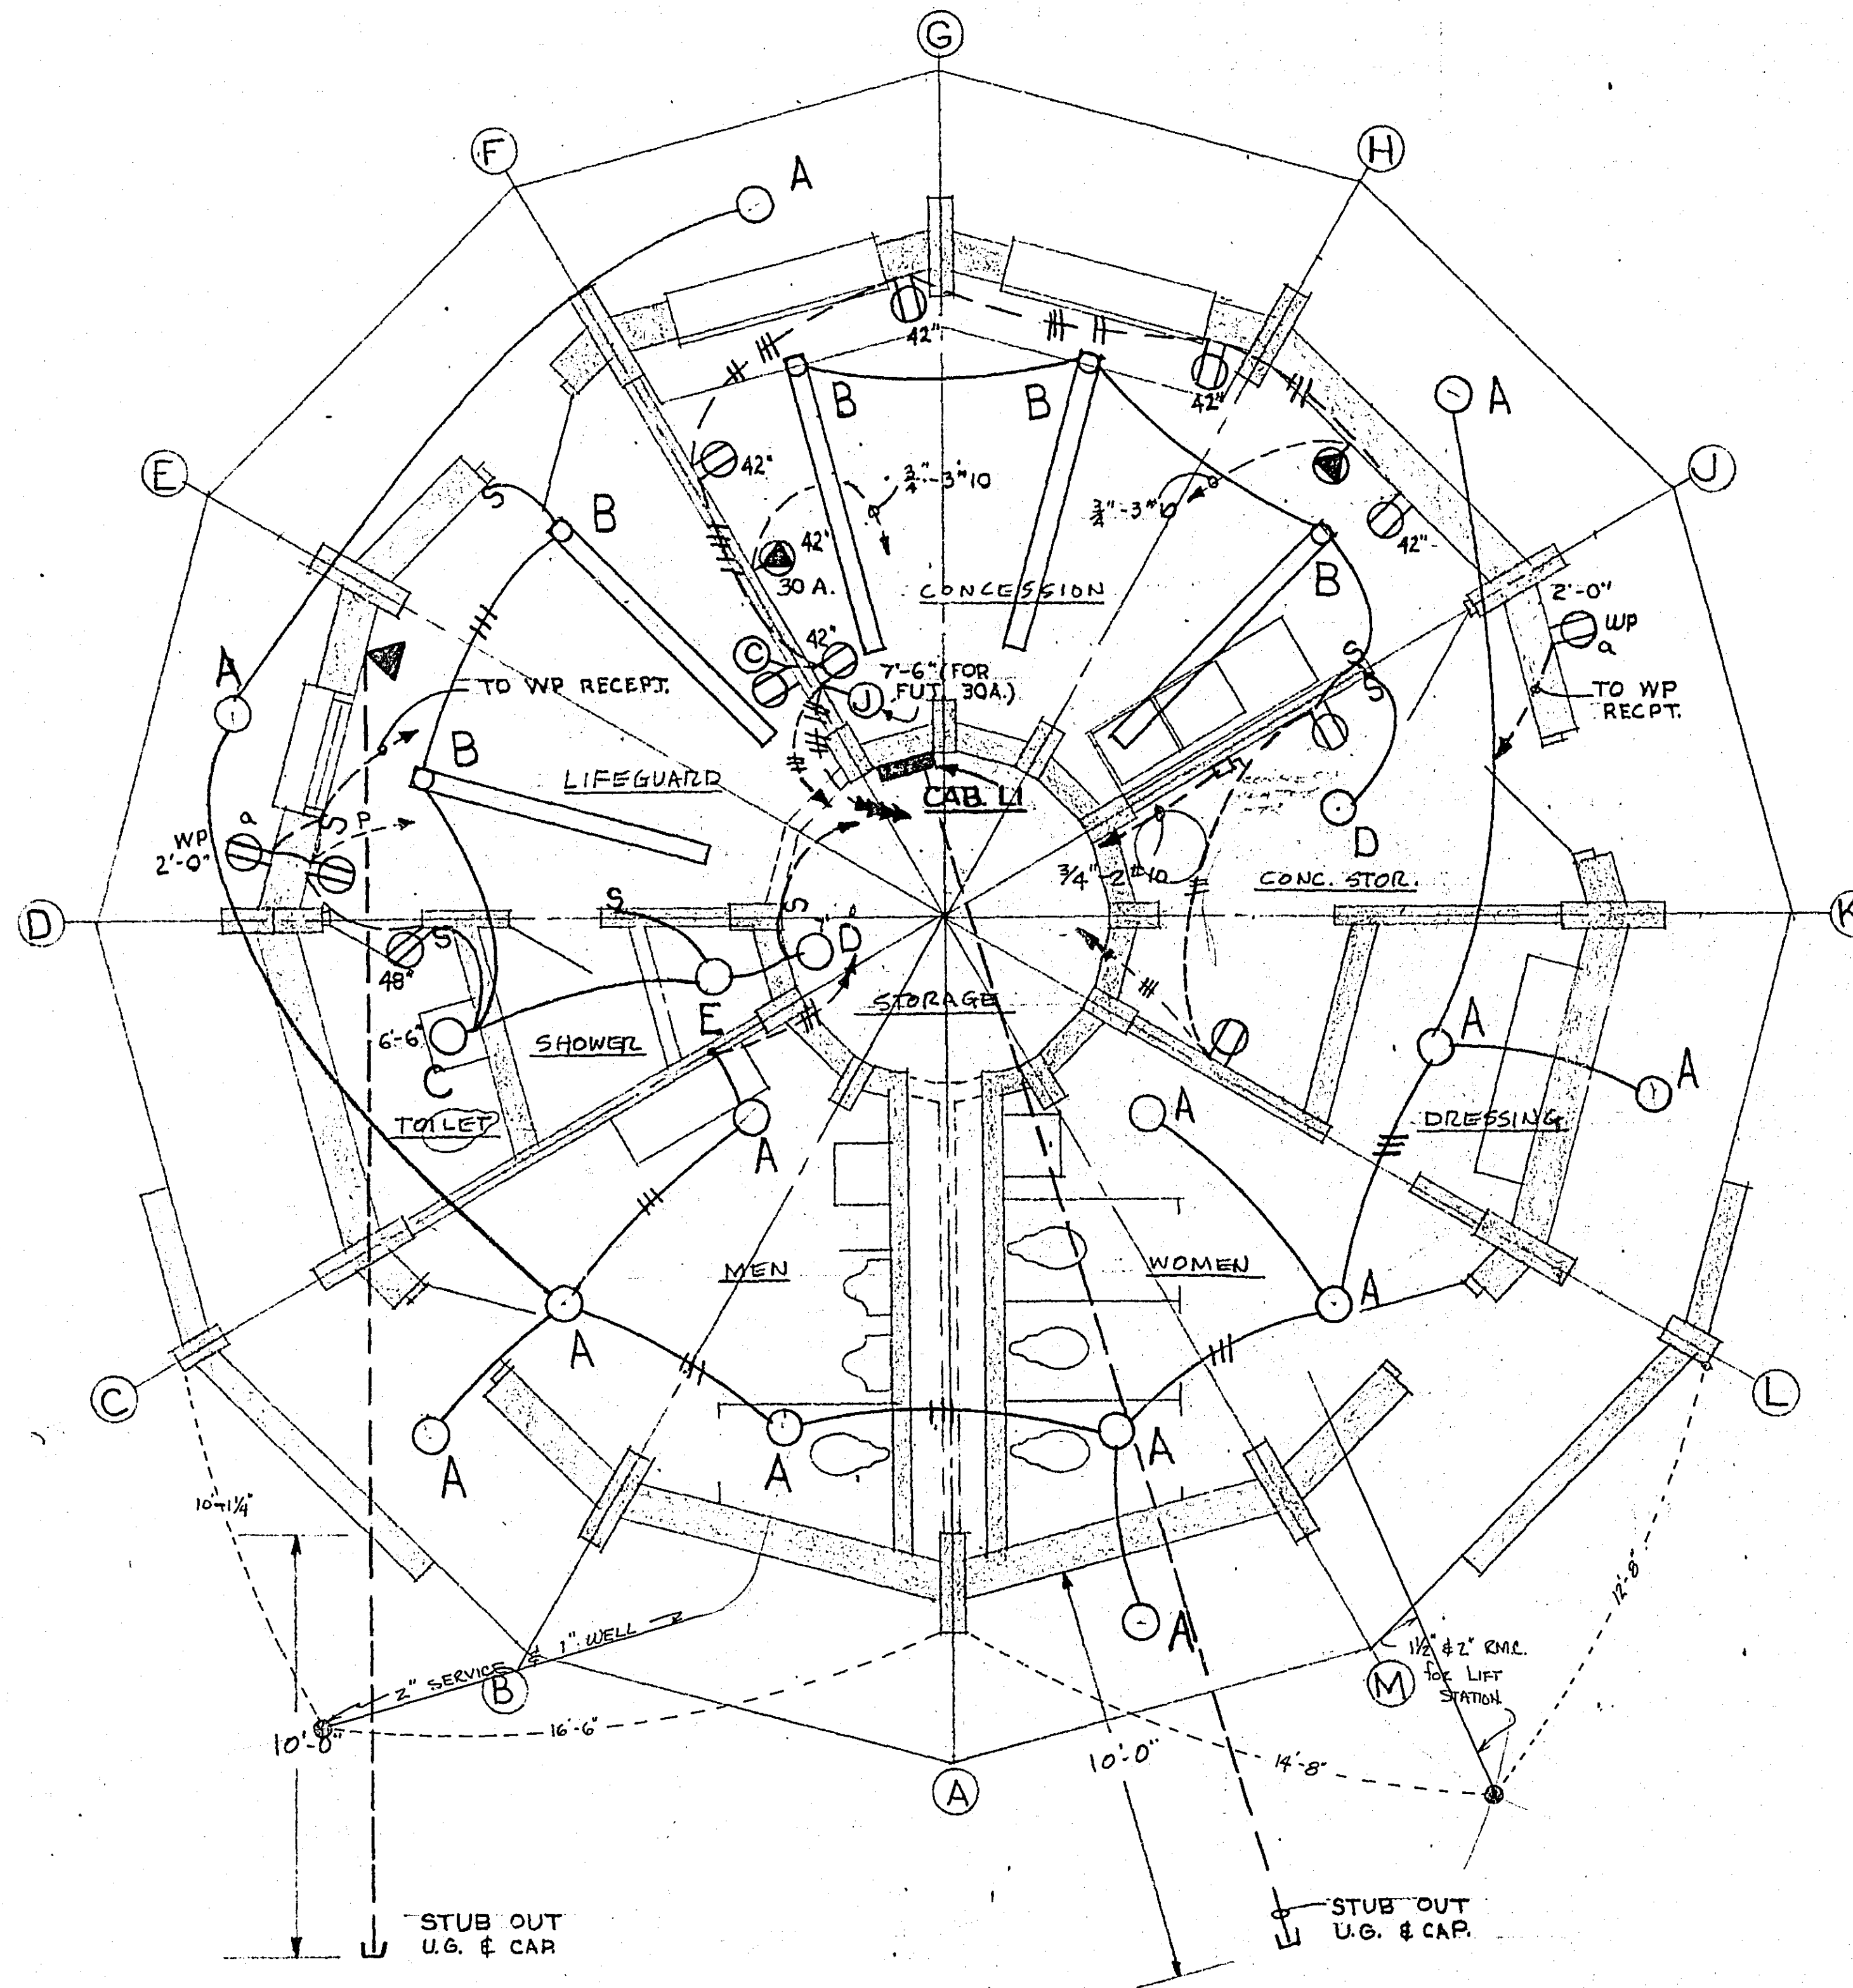


FLOOR PLAN
SCALE 1/4" = 1'-0"

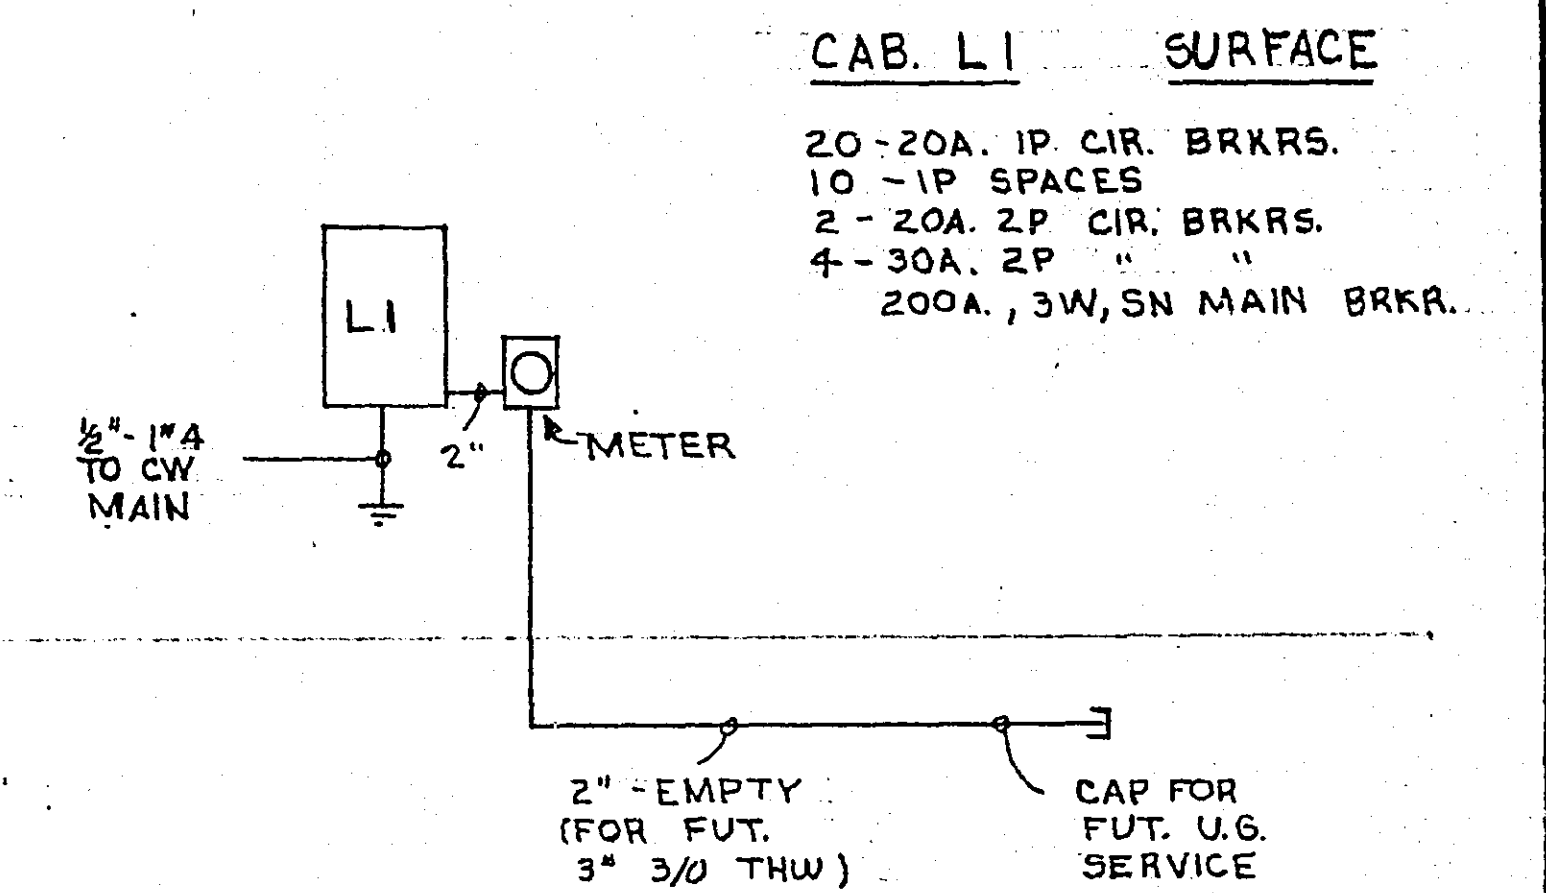


ELECTRIC RISER
NO SCALE

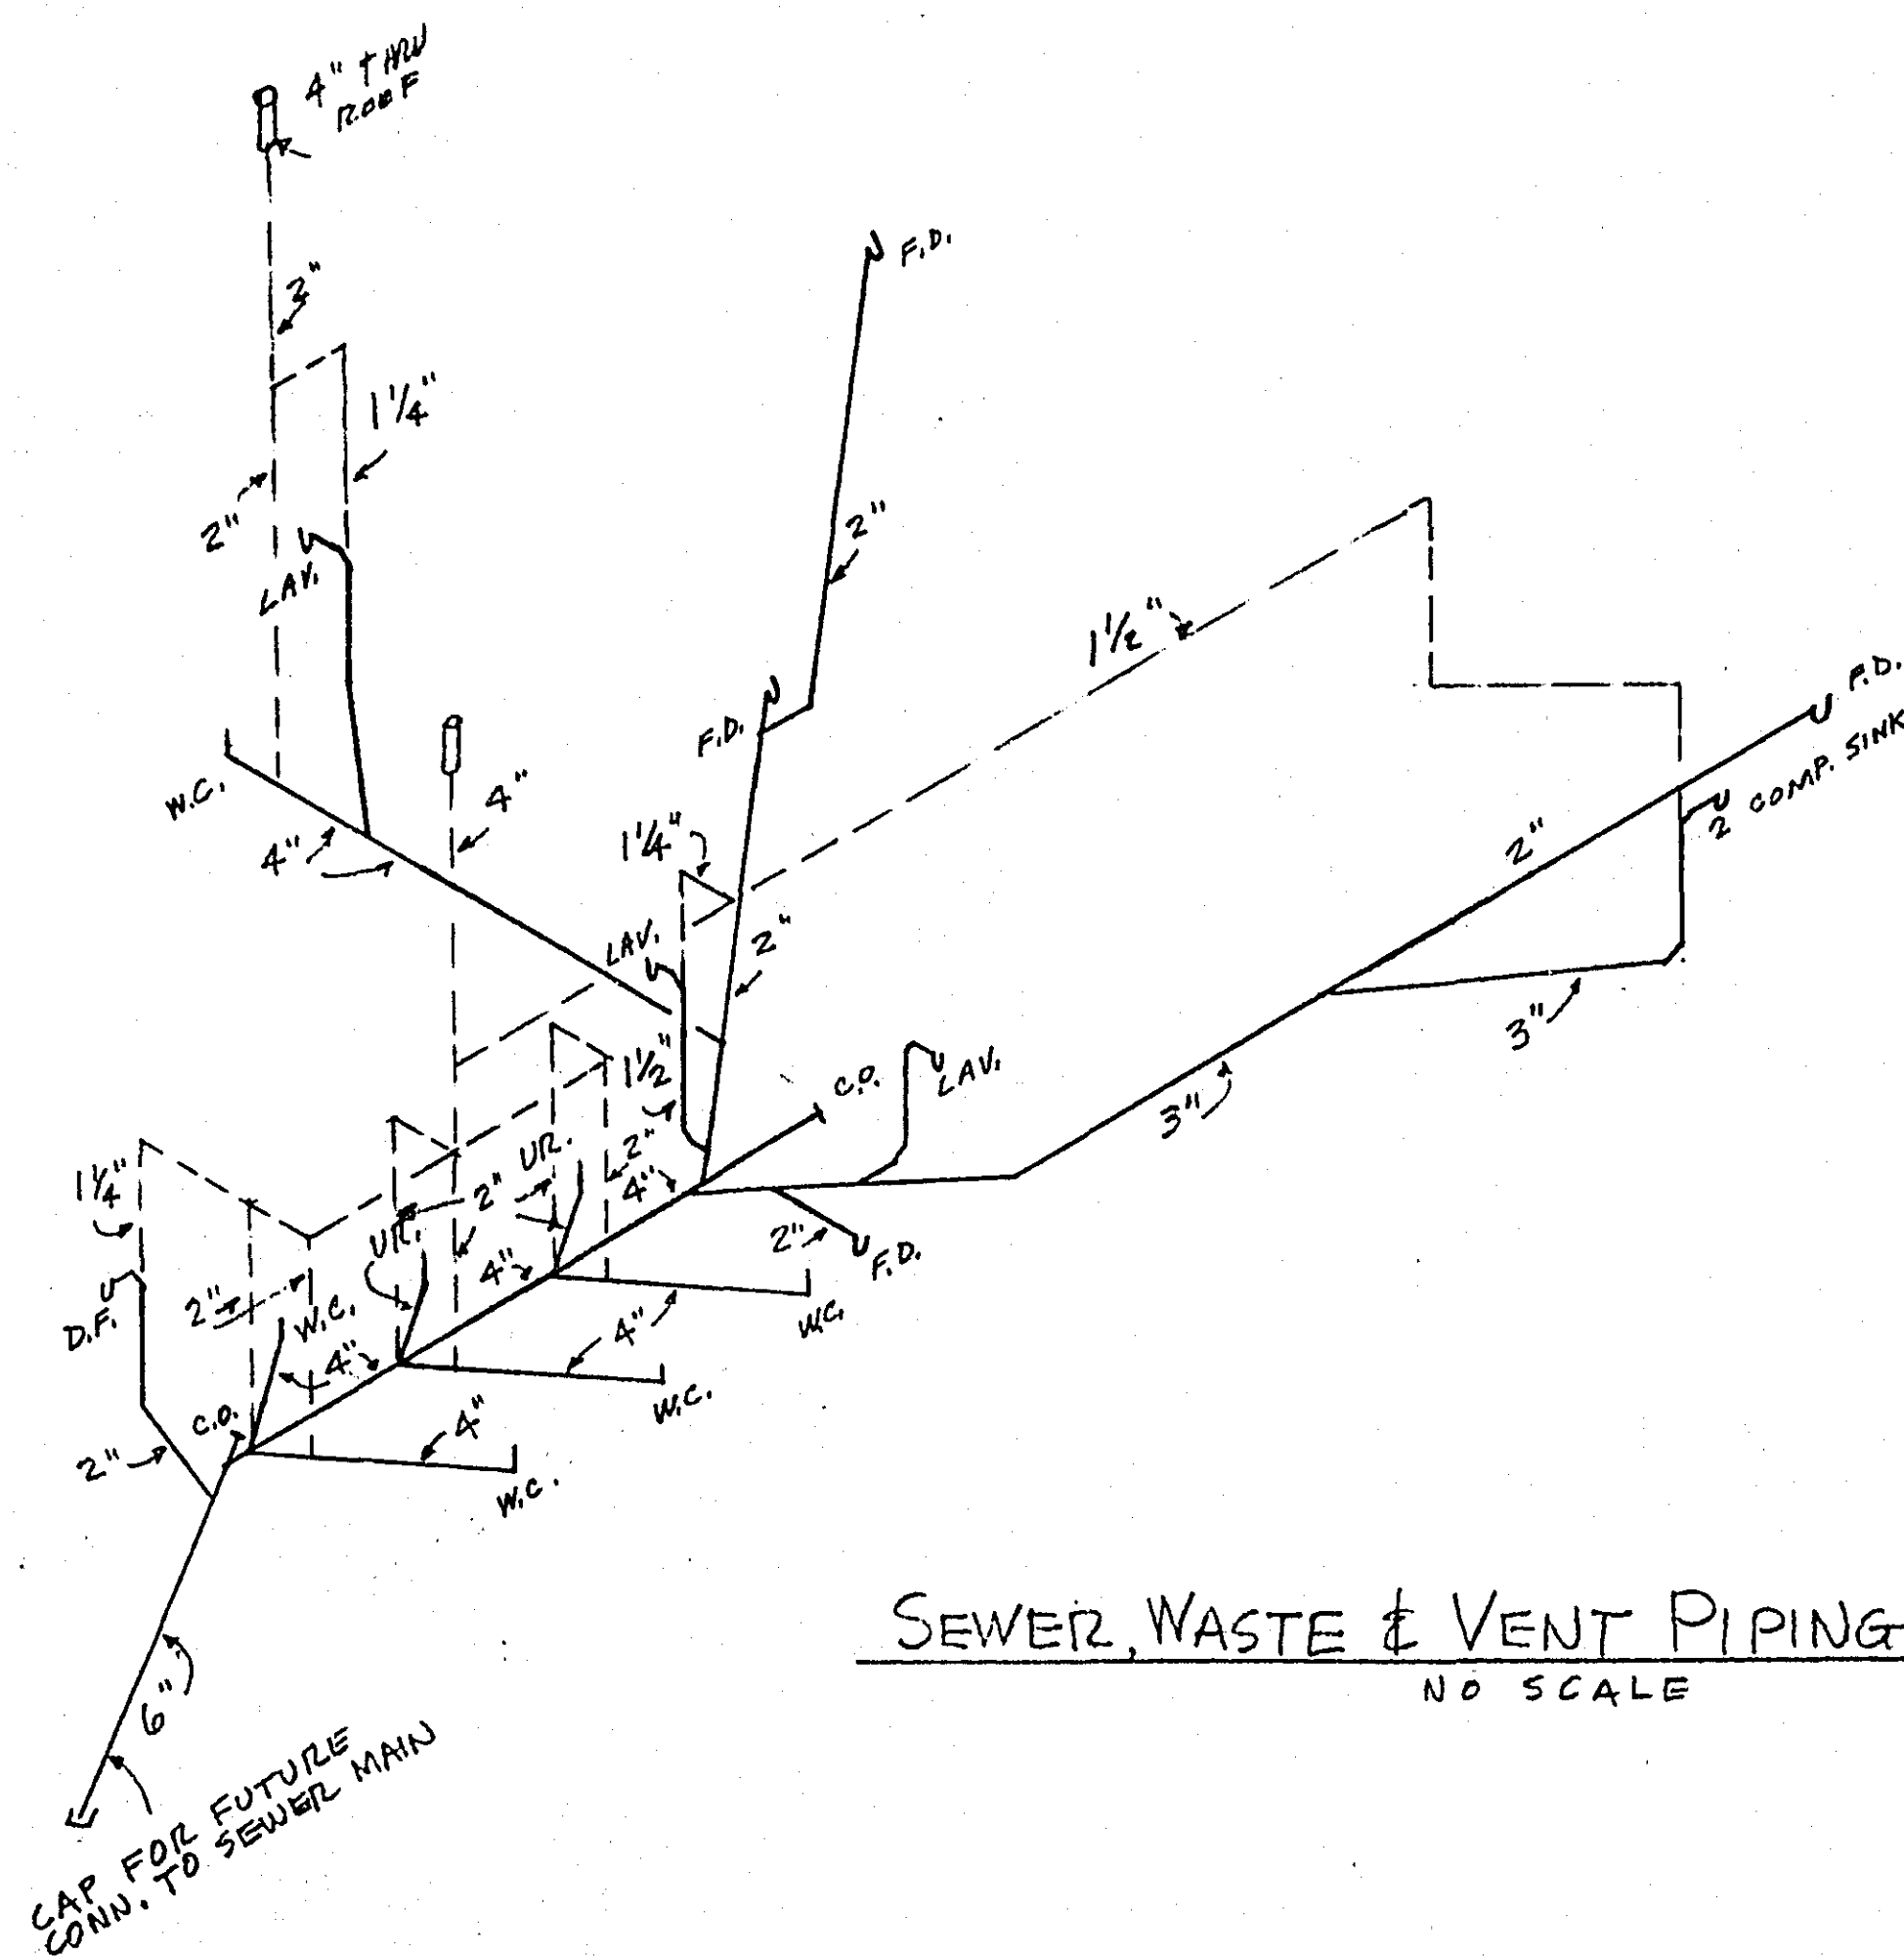


SEWER, WASTE & VENT PIPING RISER
NO SCALE

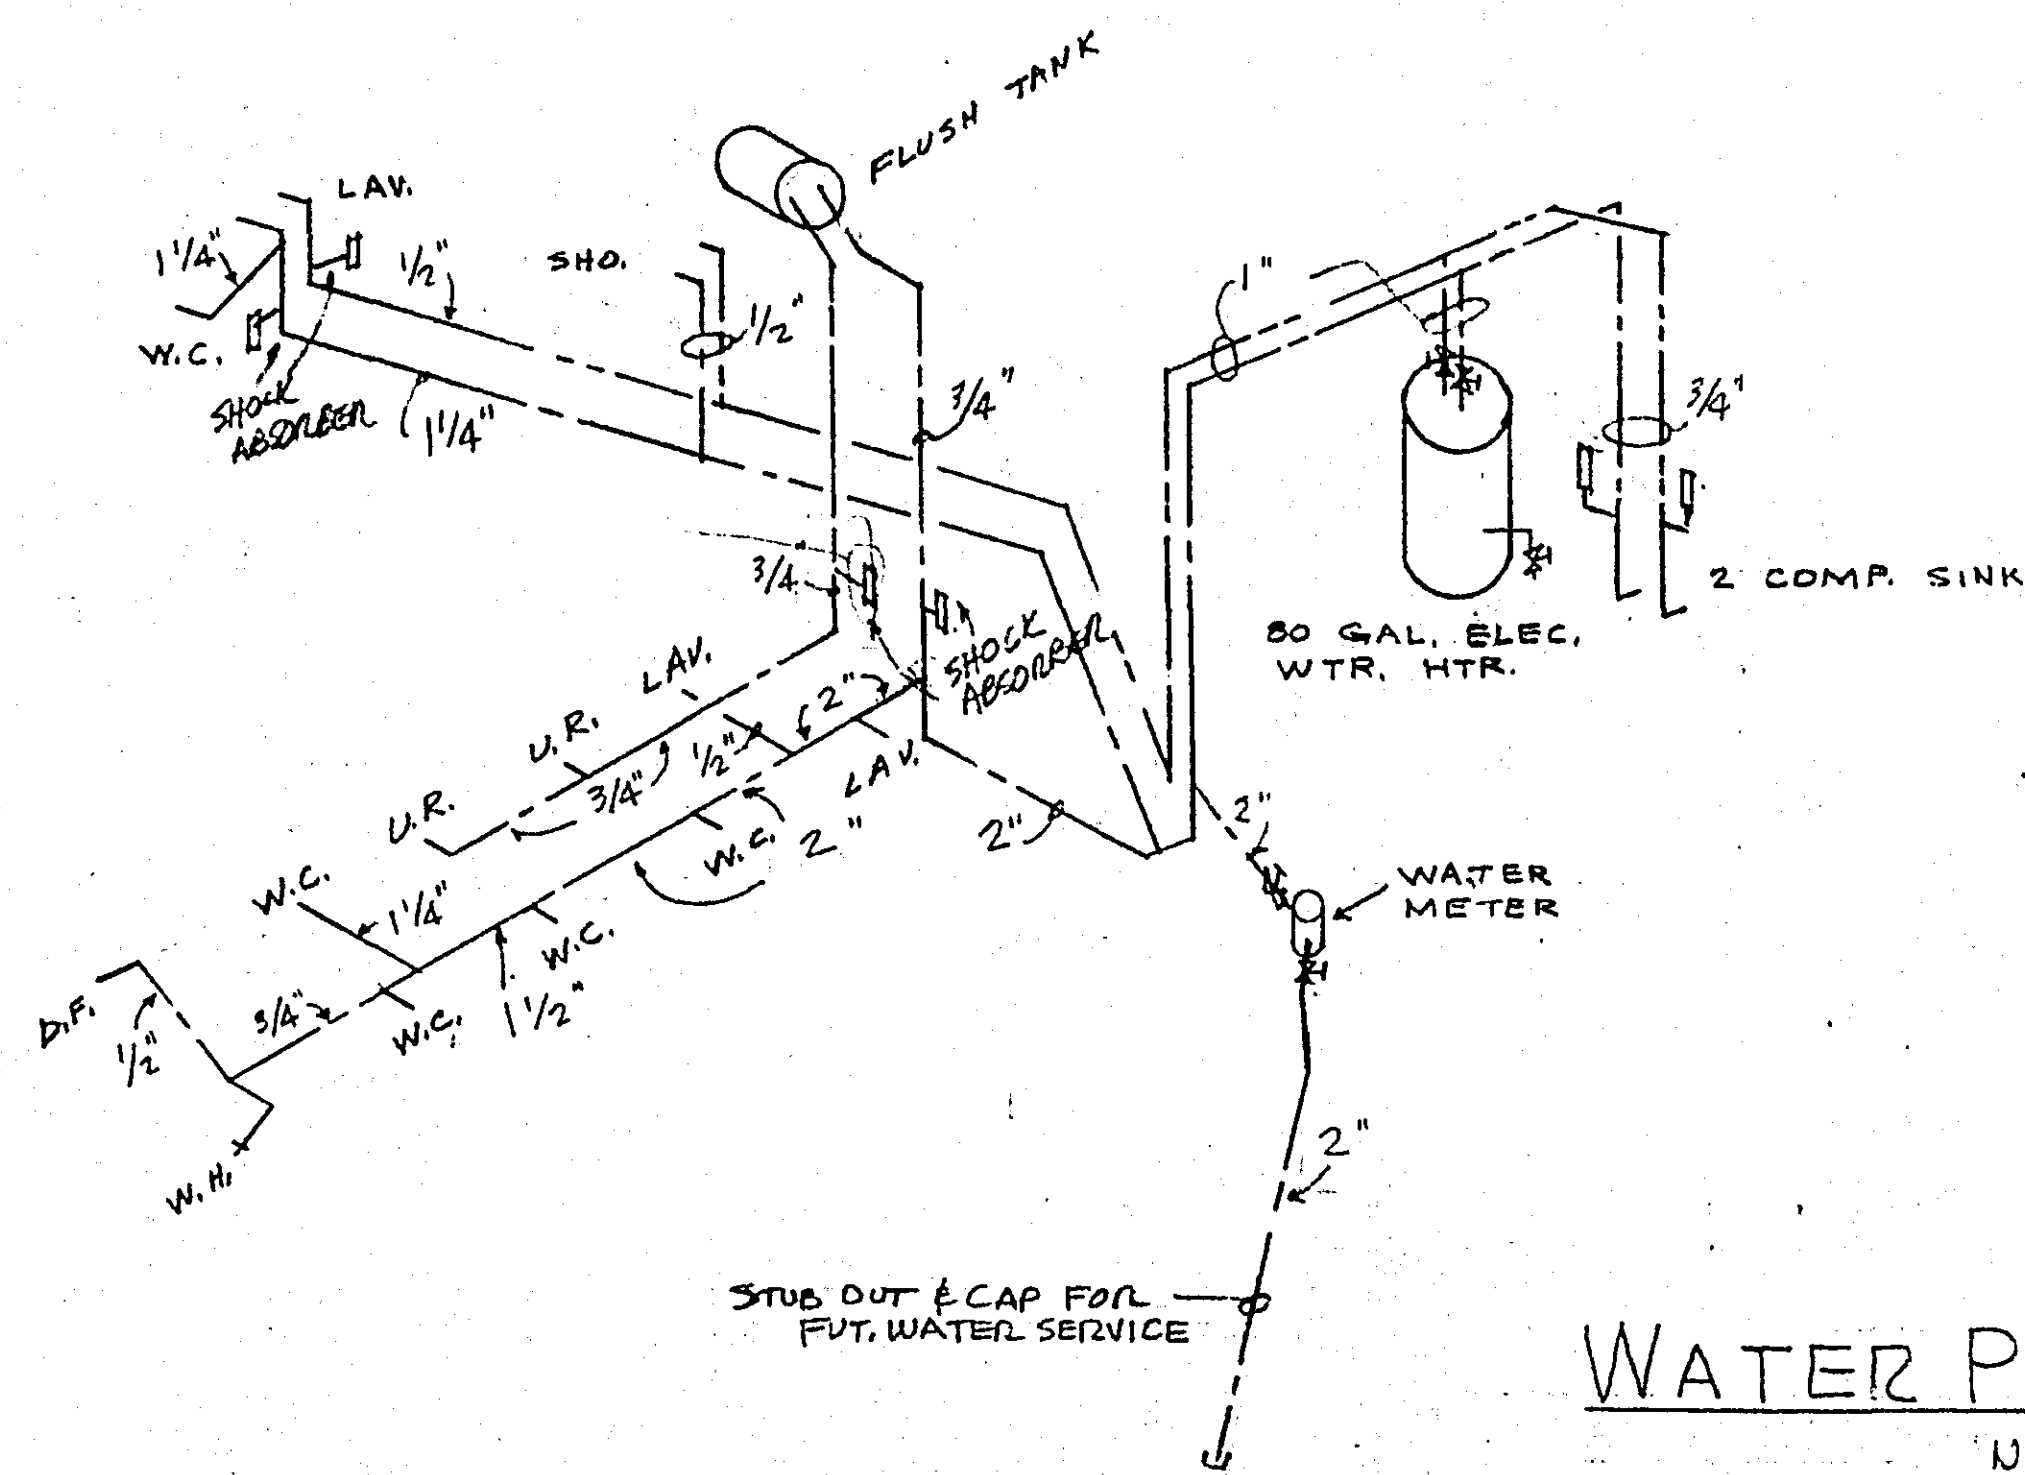

WATER PIPING RISER
NO SCALE

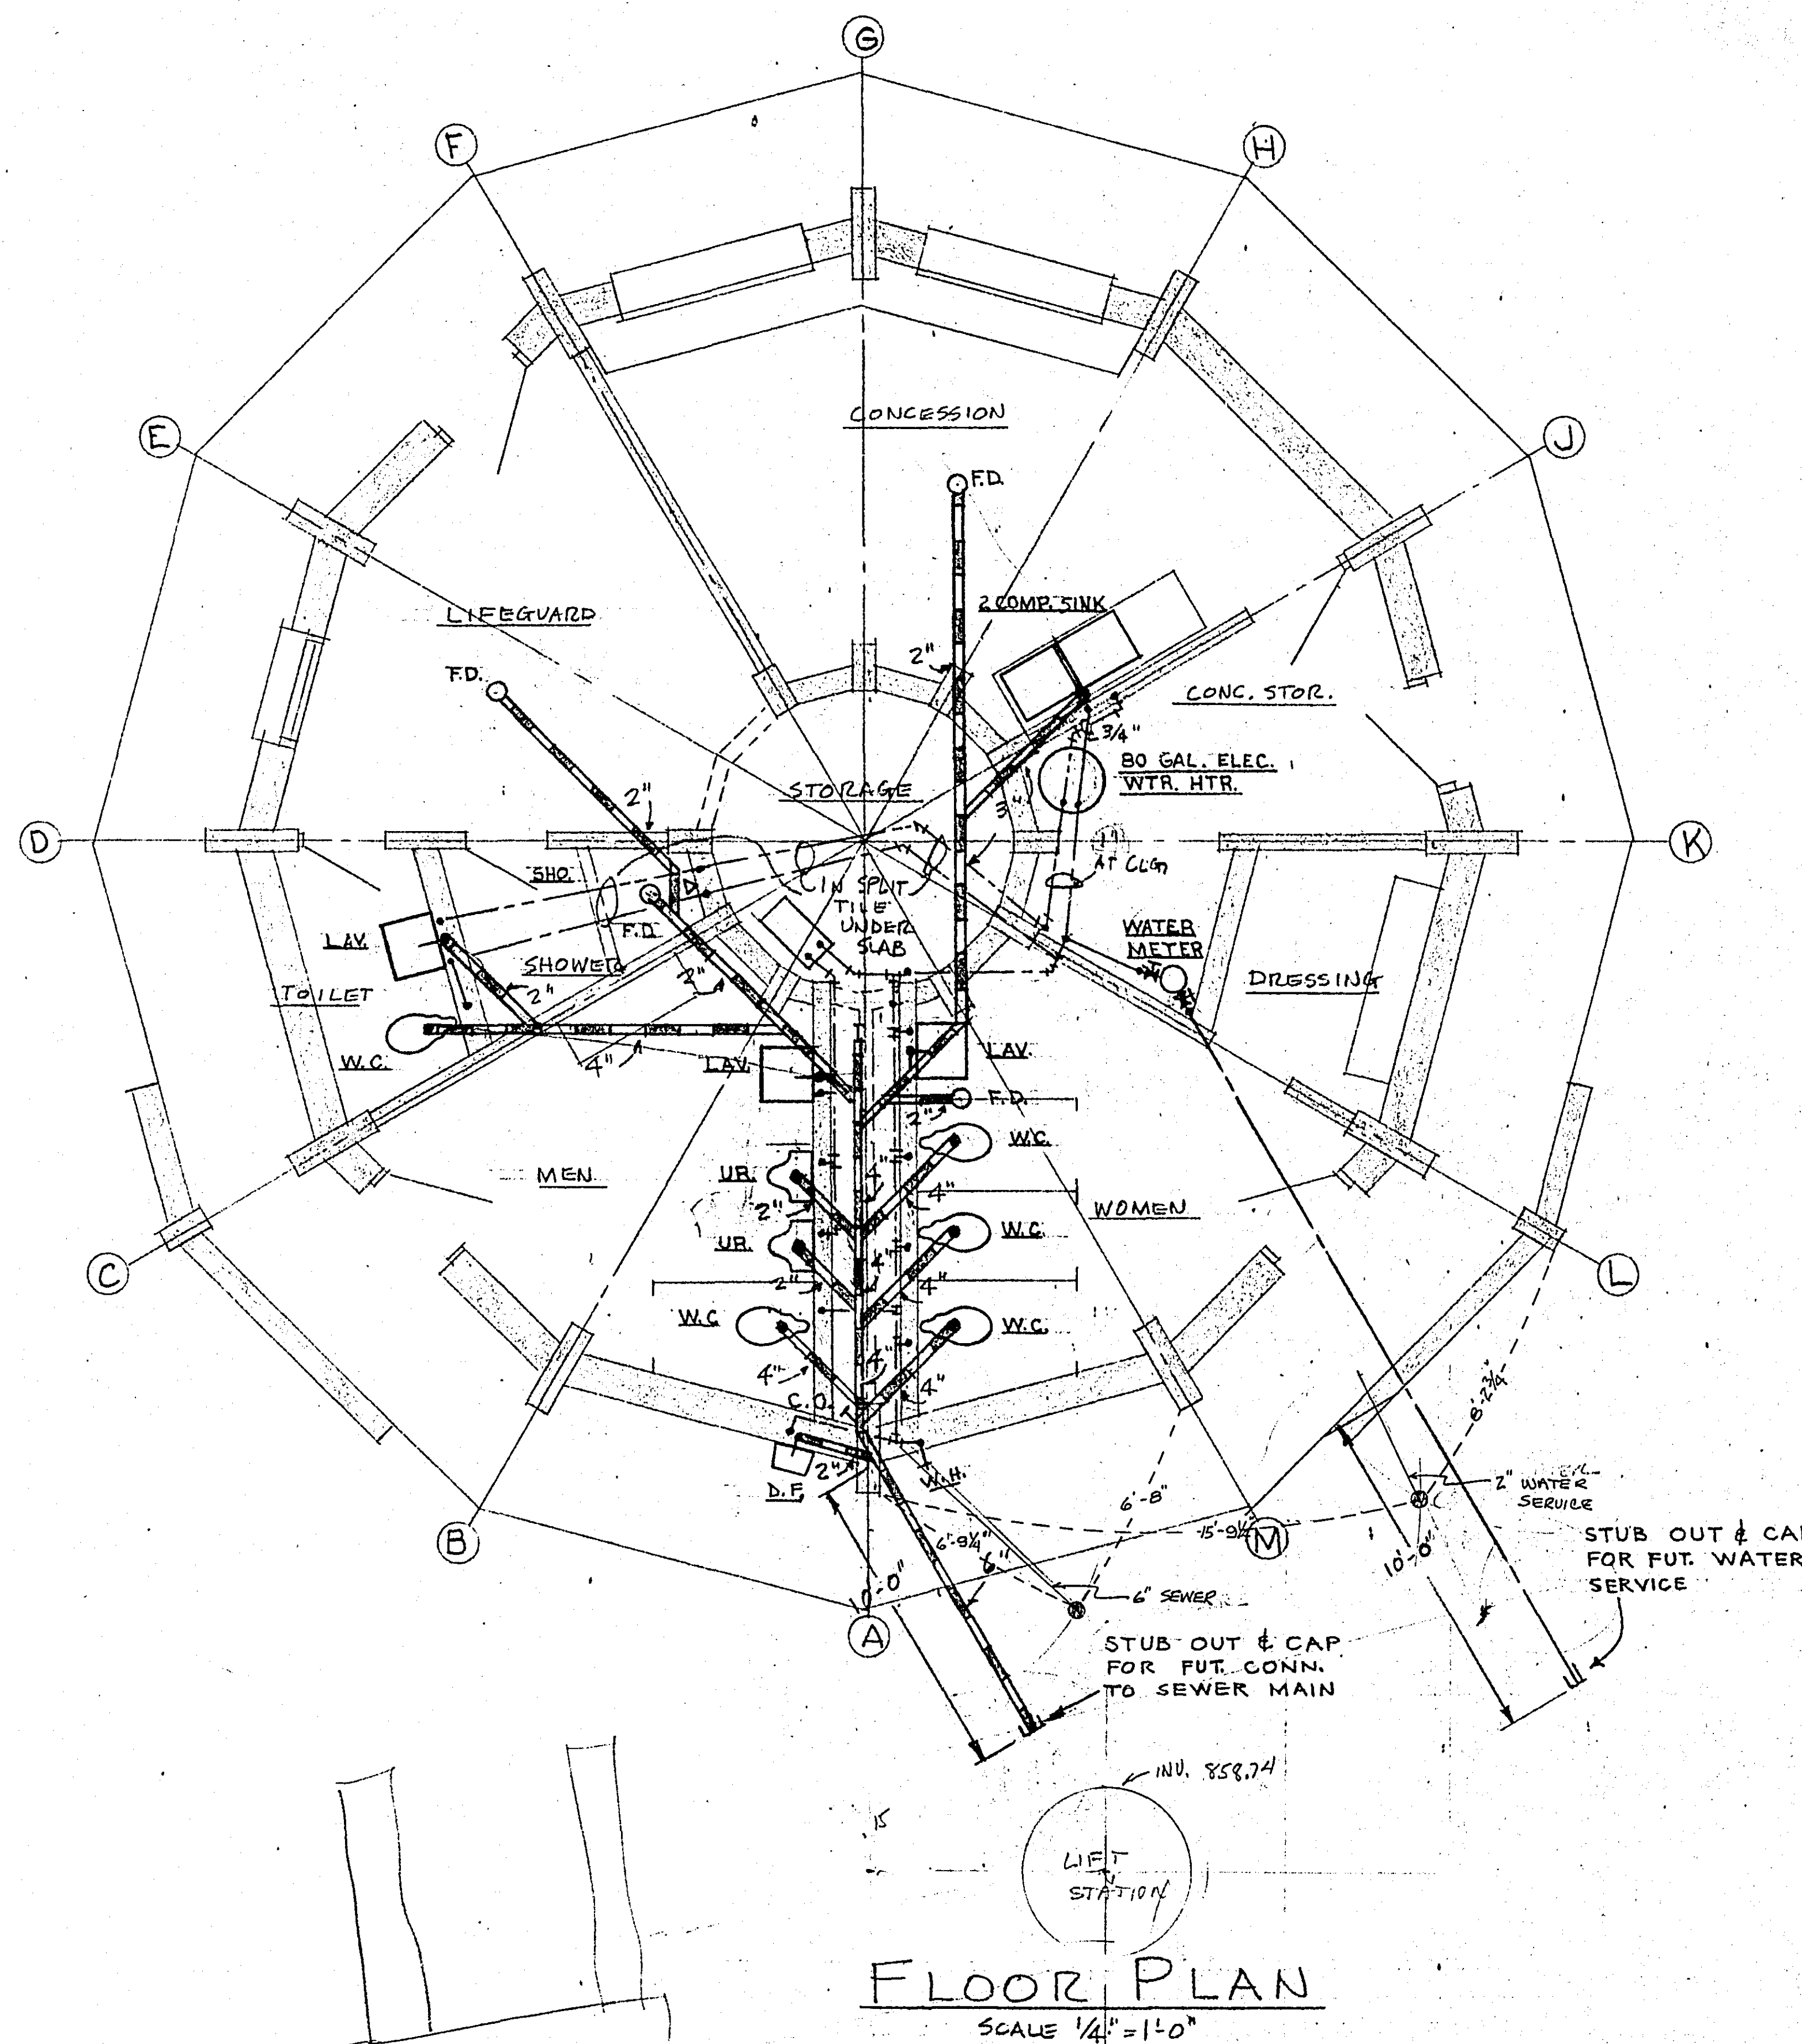

FLOOR PLAN
SCALE 1/4" = 1'-0"

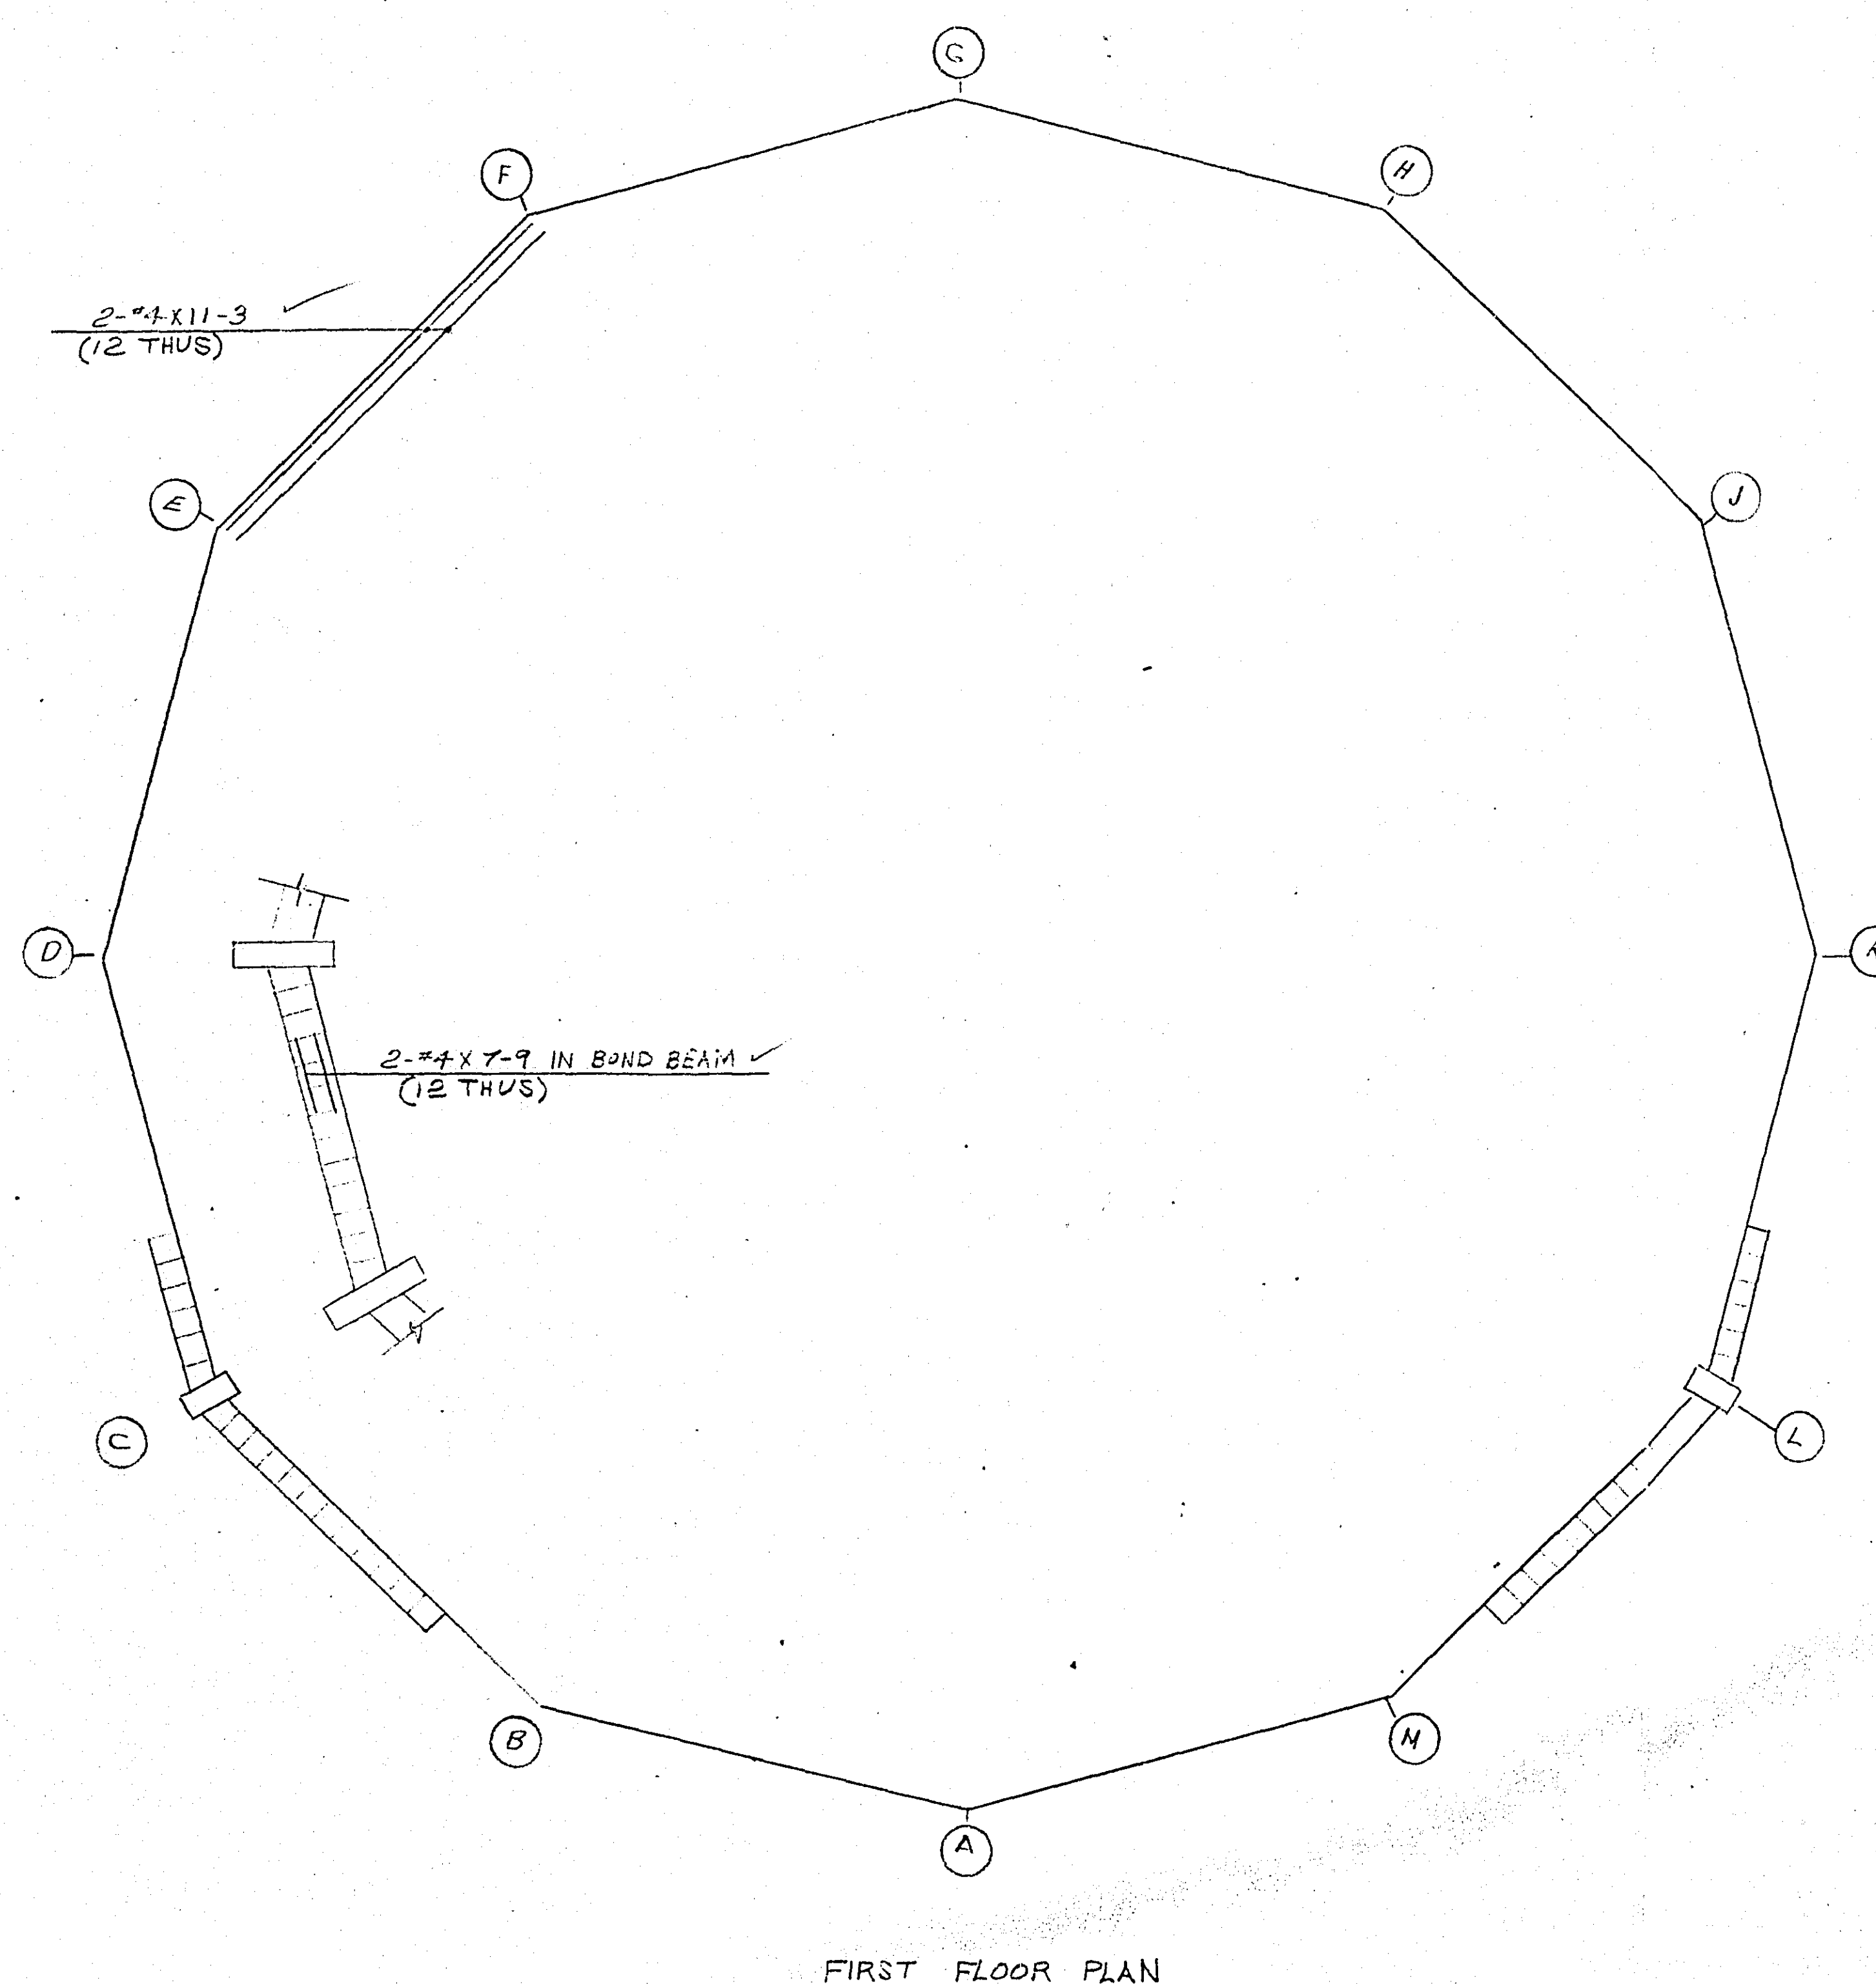

**MICROFILMED
RAMSEY CO. ENGR.**

OK'd 12-15-67 L.E.W.

ST. PAUL FOUNDRY & MANUFACTURING COMPANY
500 COMO AVENUE ST. PAUL MINNESOTA

TITLE FOUNDATION PLAN

JOB REFECTORY BLDG. FOR RAMSEY COUNTY
LOCATION ST. PAUL

ARCHITECT PLAGENS Mc GEE ANDERSON SIGVERTSEN INC
CONTRACTOR WESTLUND CONST. CO.

DR. BY 70.	REV.	1	2	3	4	ORD. NO. 61836
DATE 12-11-67	DATE					DRG. NO. 1
BY						

59-111-~~5-1-194~~