



PARKING AREA


VALVE PIT

3" IN P

3"

RAMSEY COUNTY
GOLF COURSE
No. 2

PARKING AREA

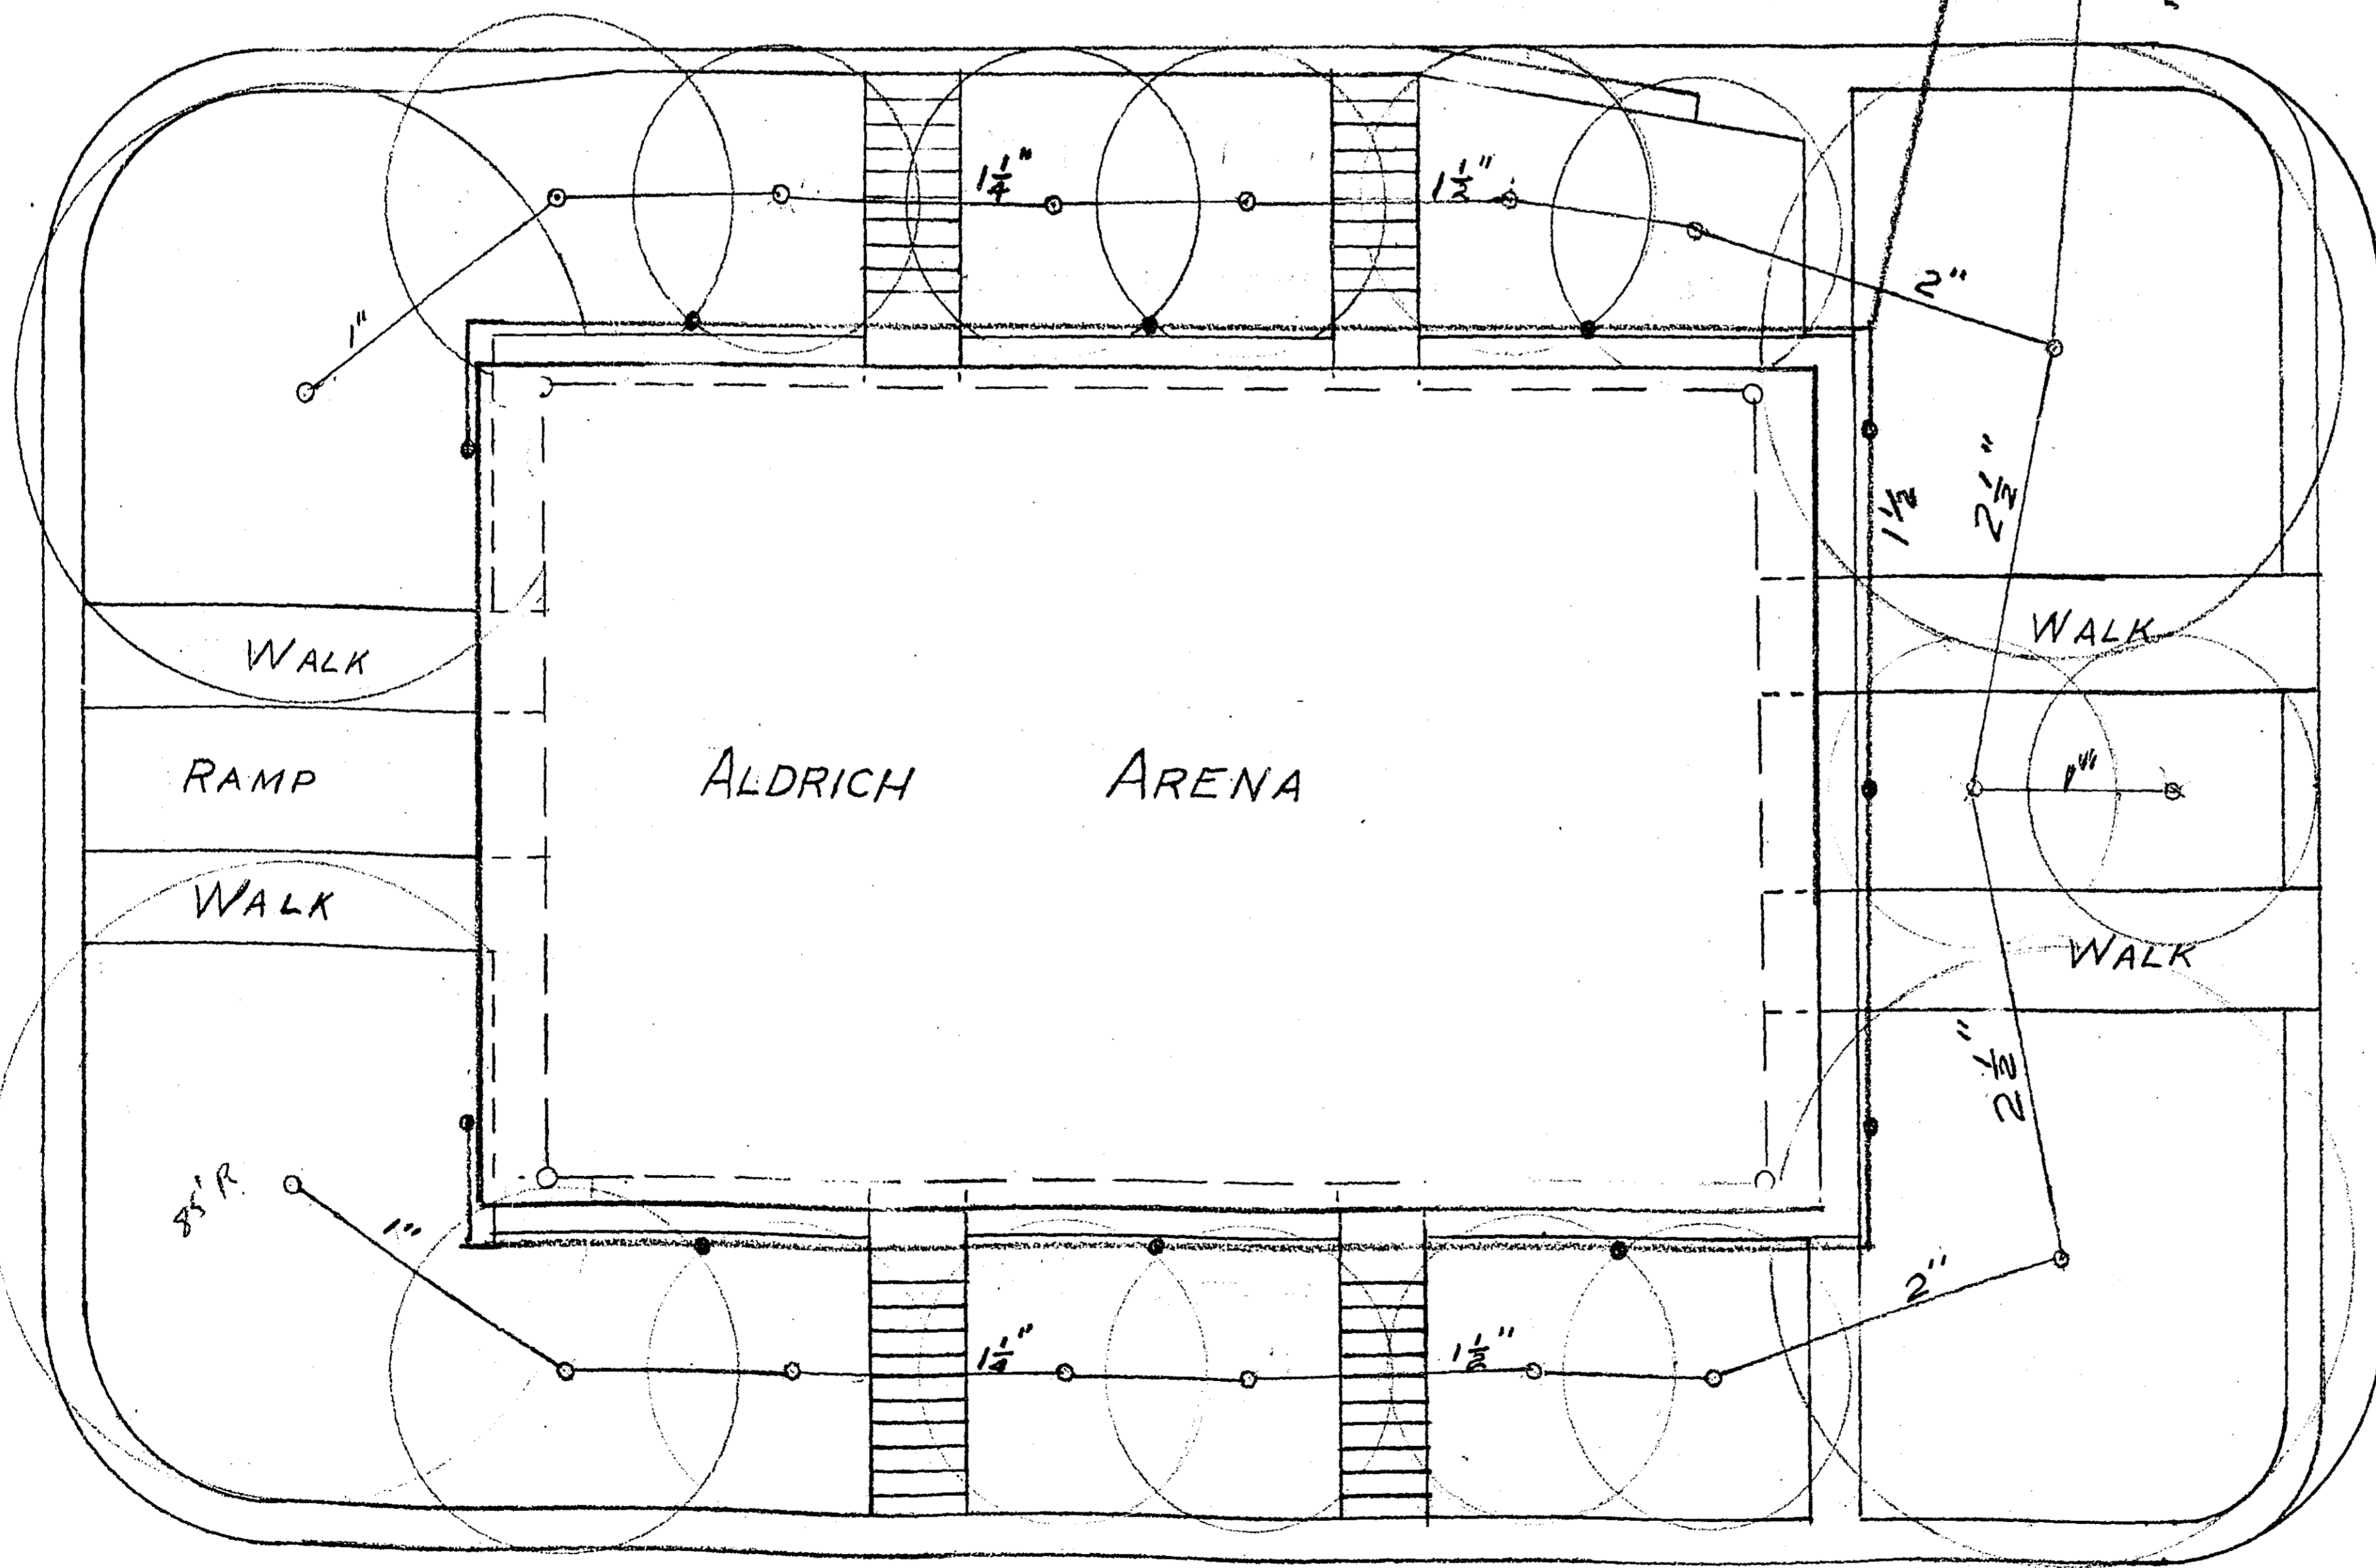

VAN DYKE STREET

BLACK. INSTALLING SPRINKLERS
18 HEADS

RED. SILLCOCKS, 11 FITTINGS
ALTERNATE SYSTEM

PIPING LAYOUT FOR SPRINKLING
SYSTEM AT ALDRICH ARENA

RAMSEY COUNTY ENGINEERING DEPT.

SCALE: 1" = 50'

DWN. BY G.H.J.

8-6-63

PARKING AREA