
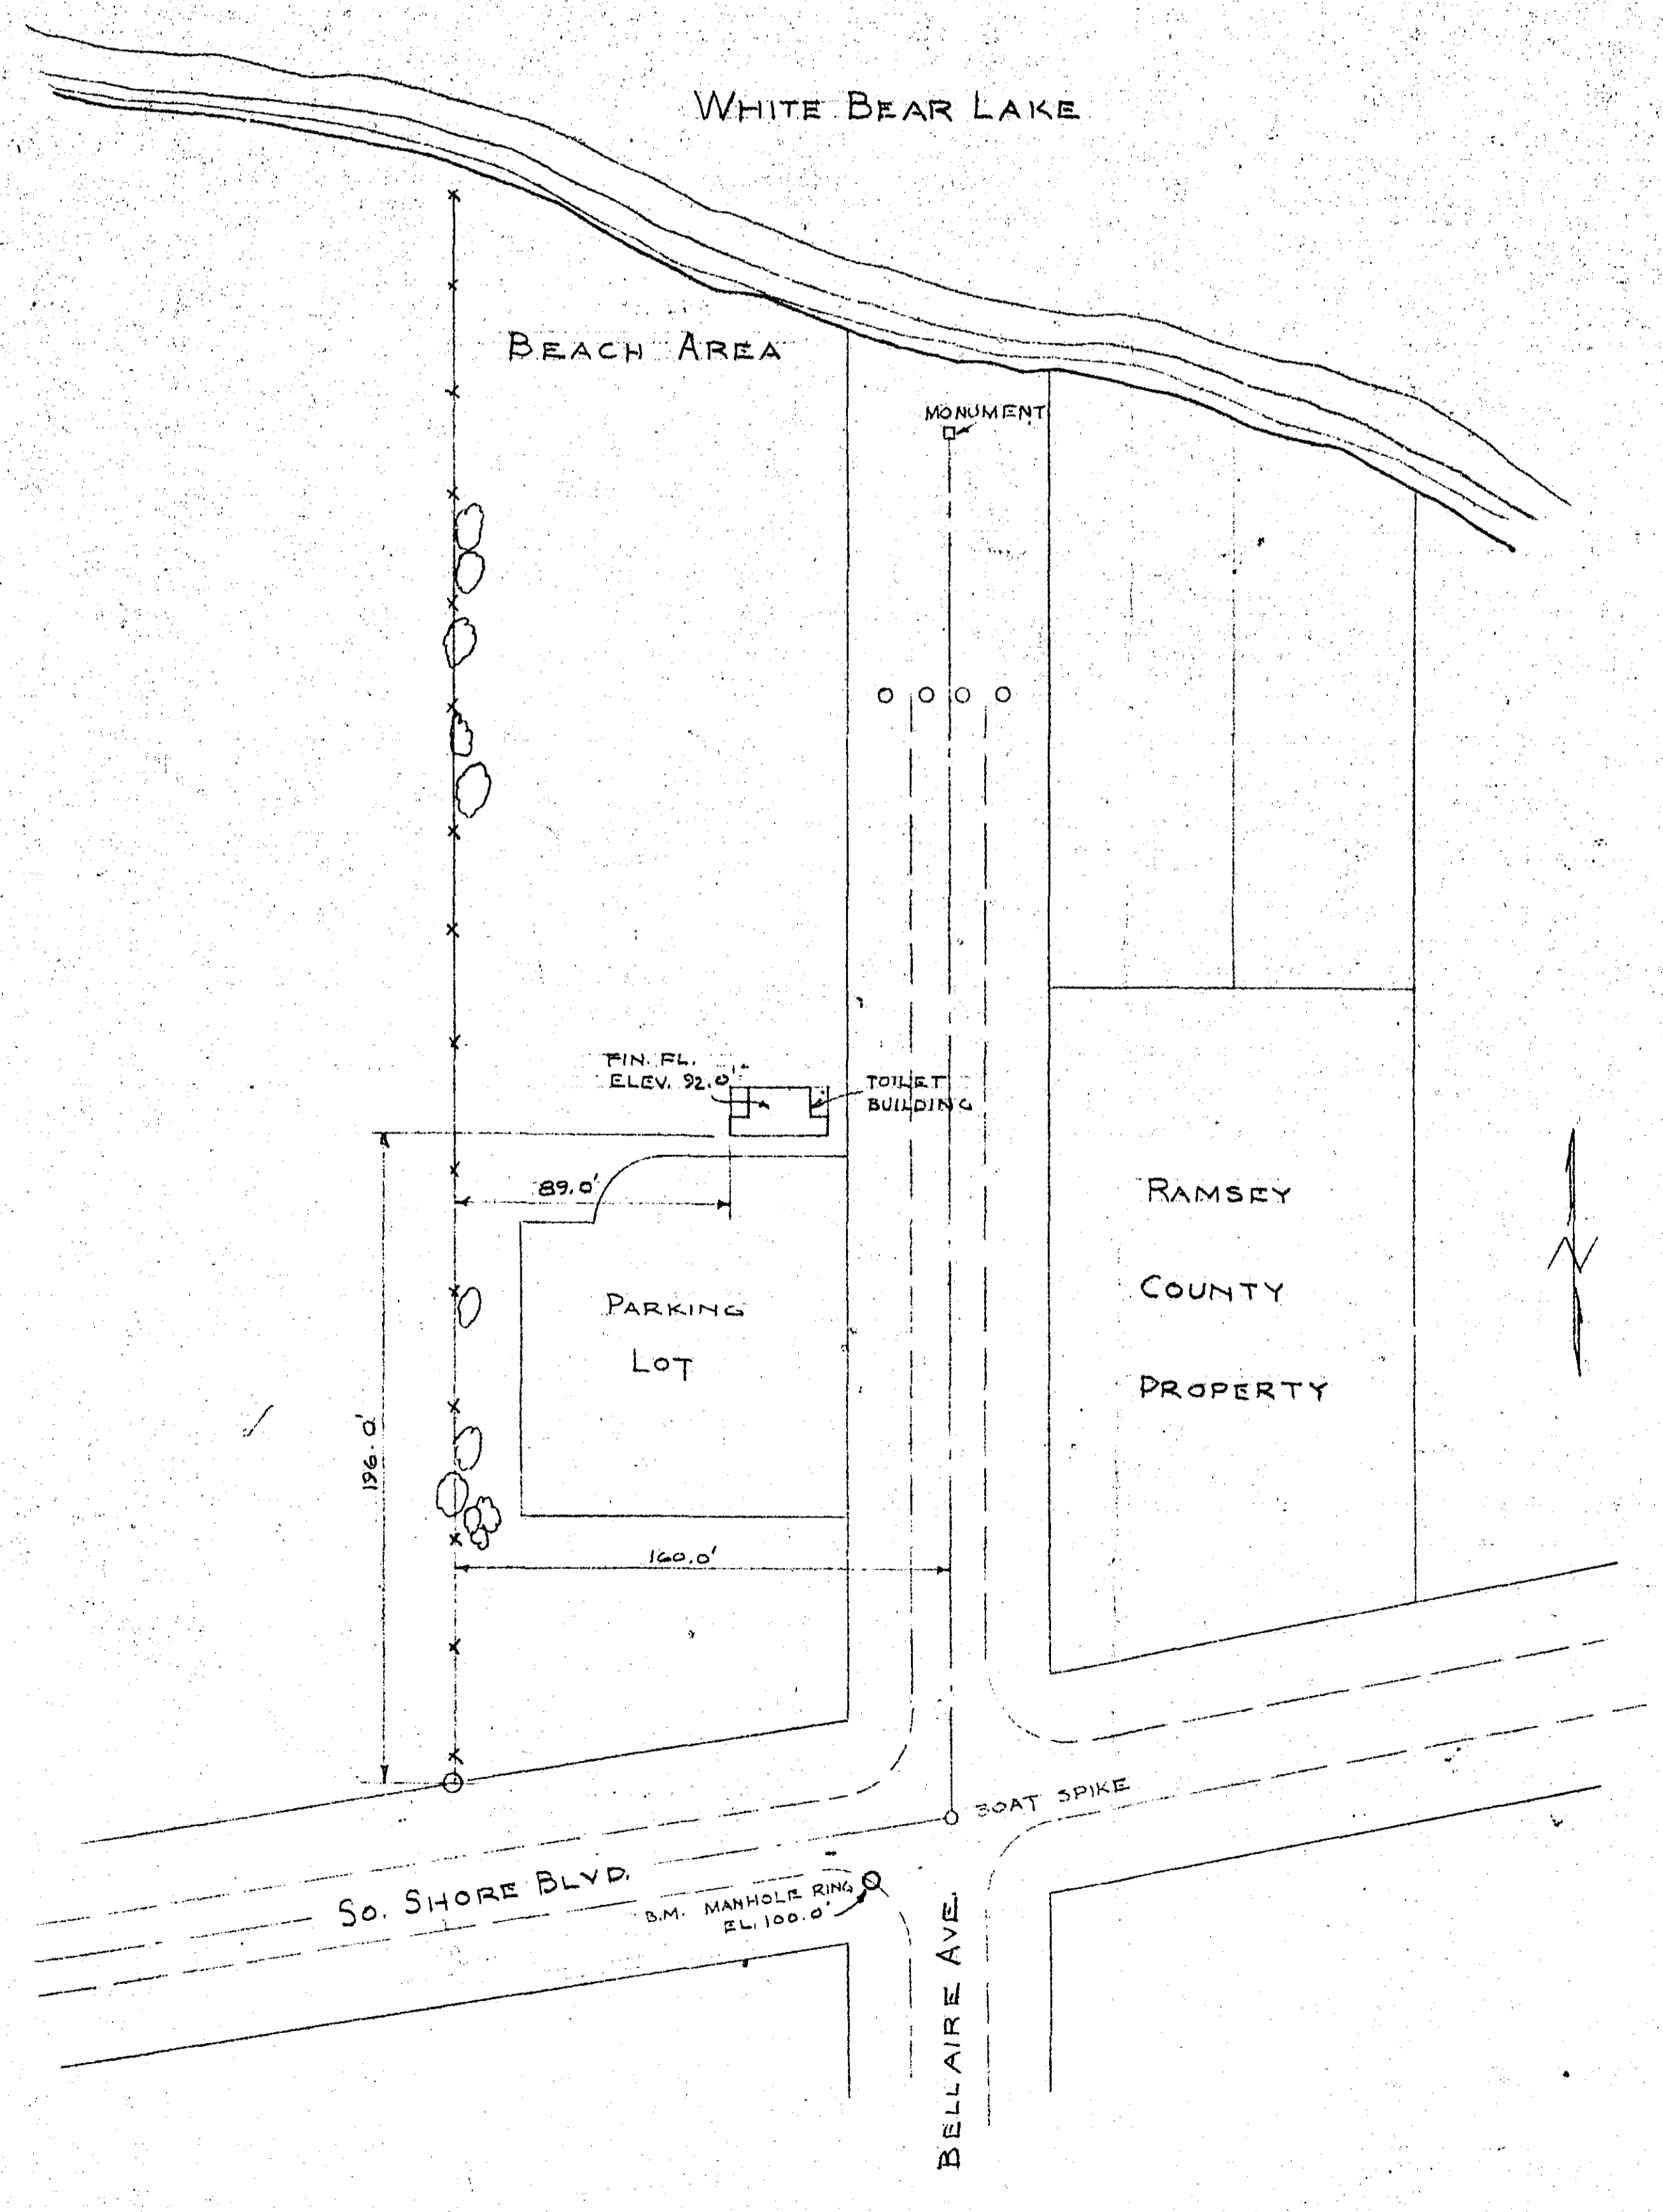
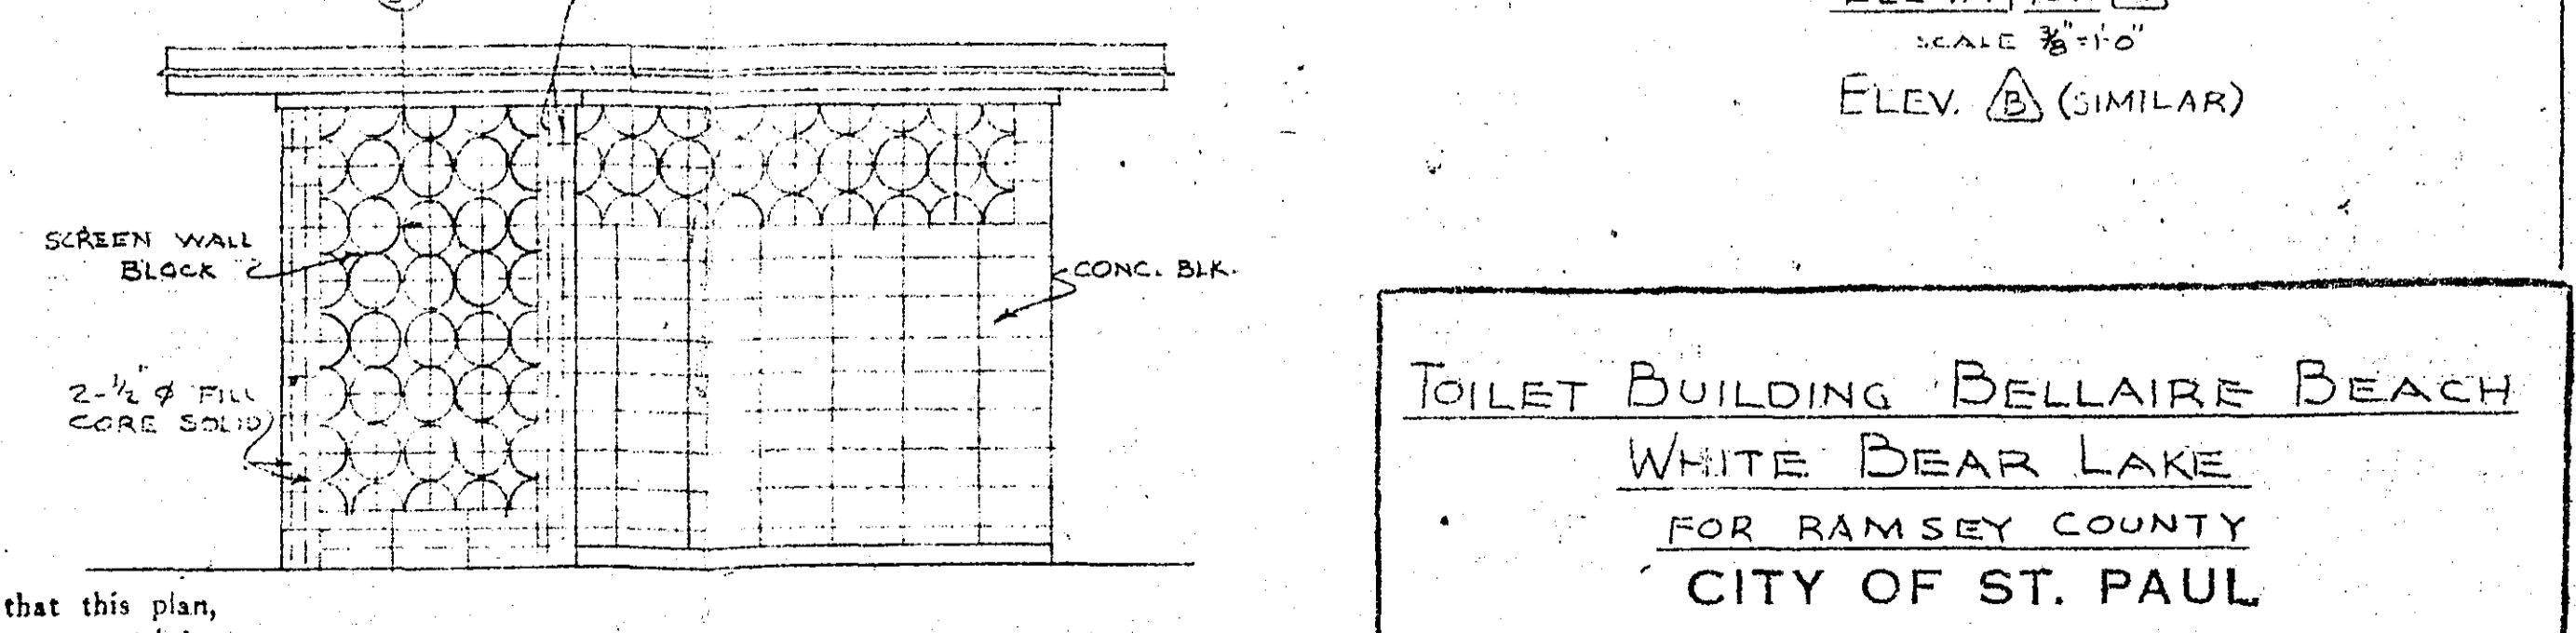
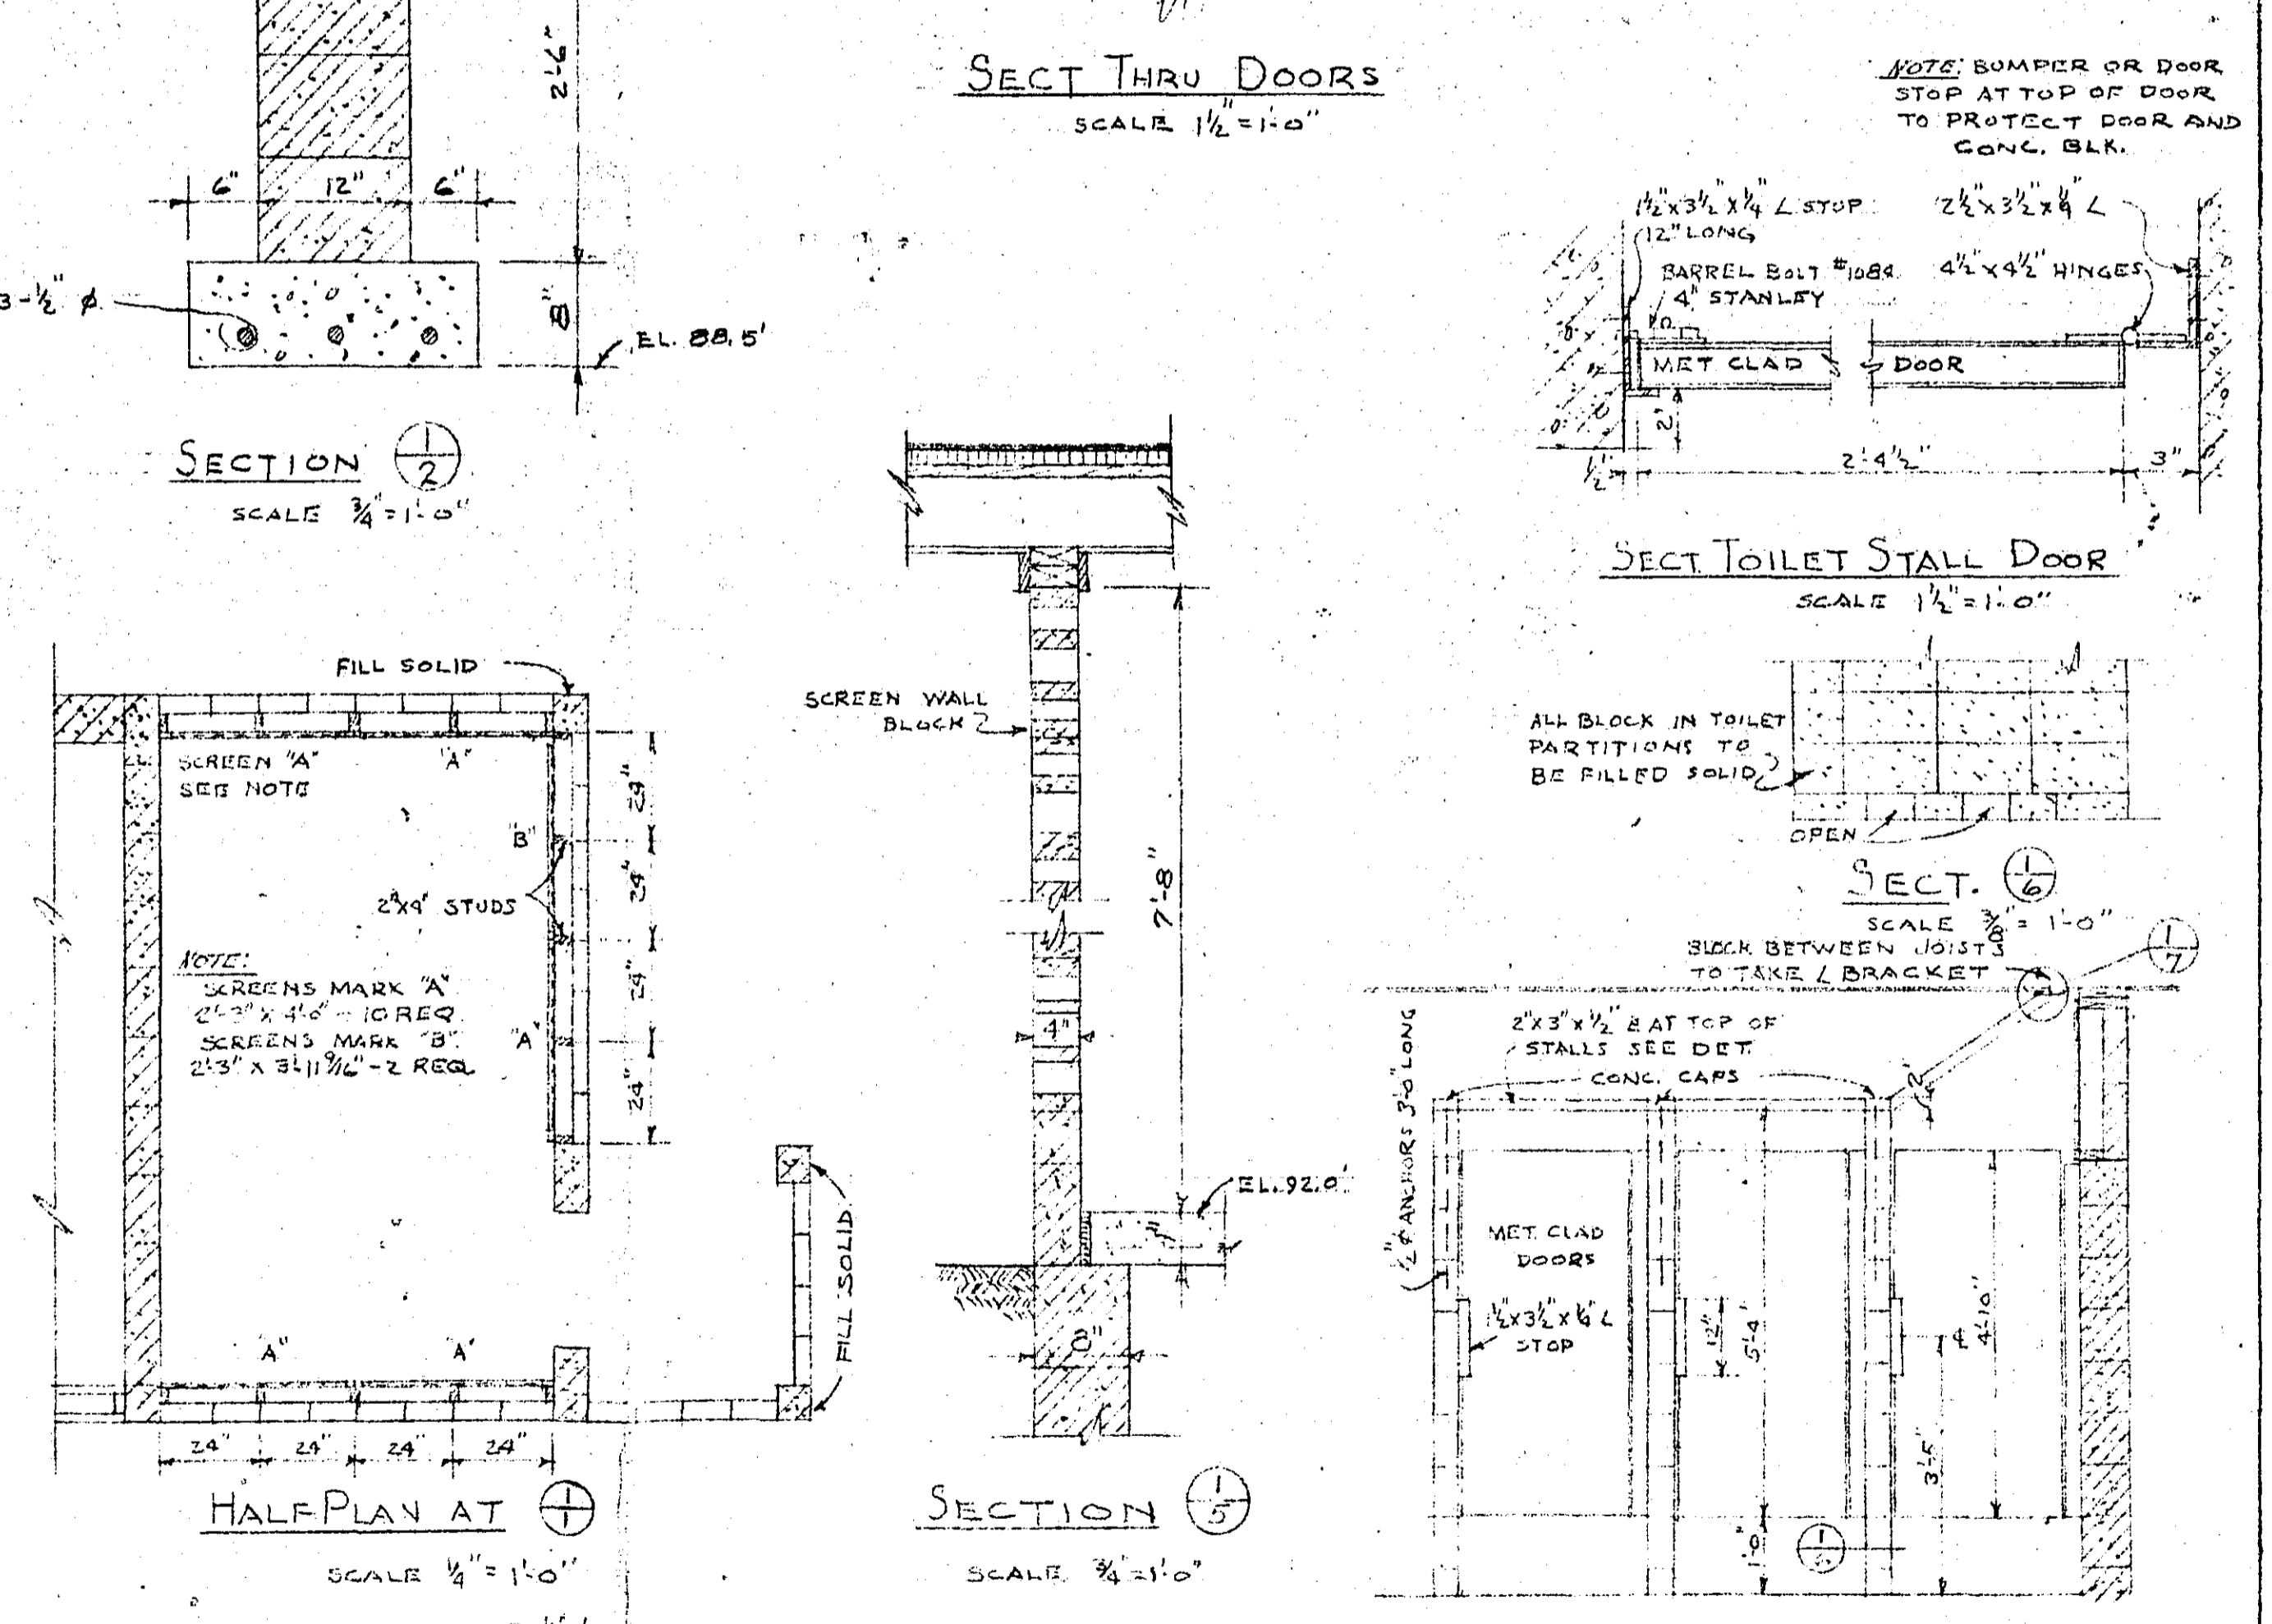
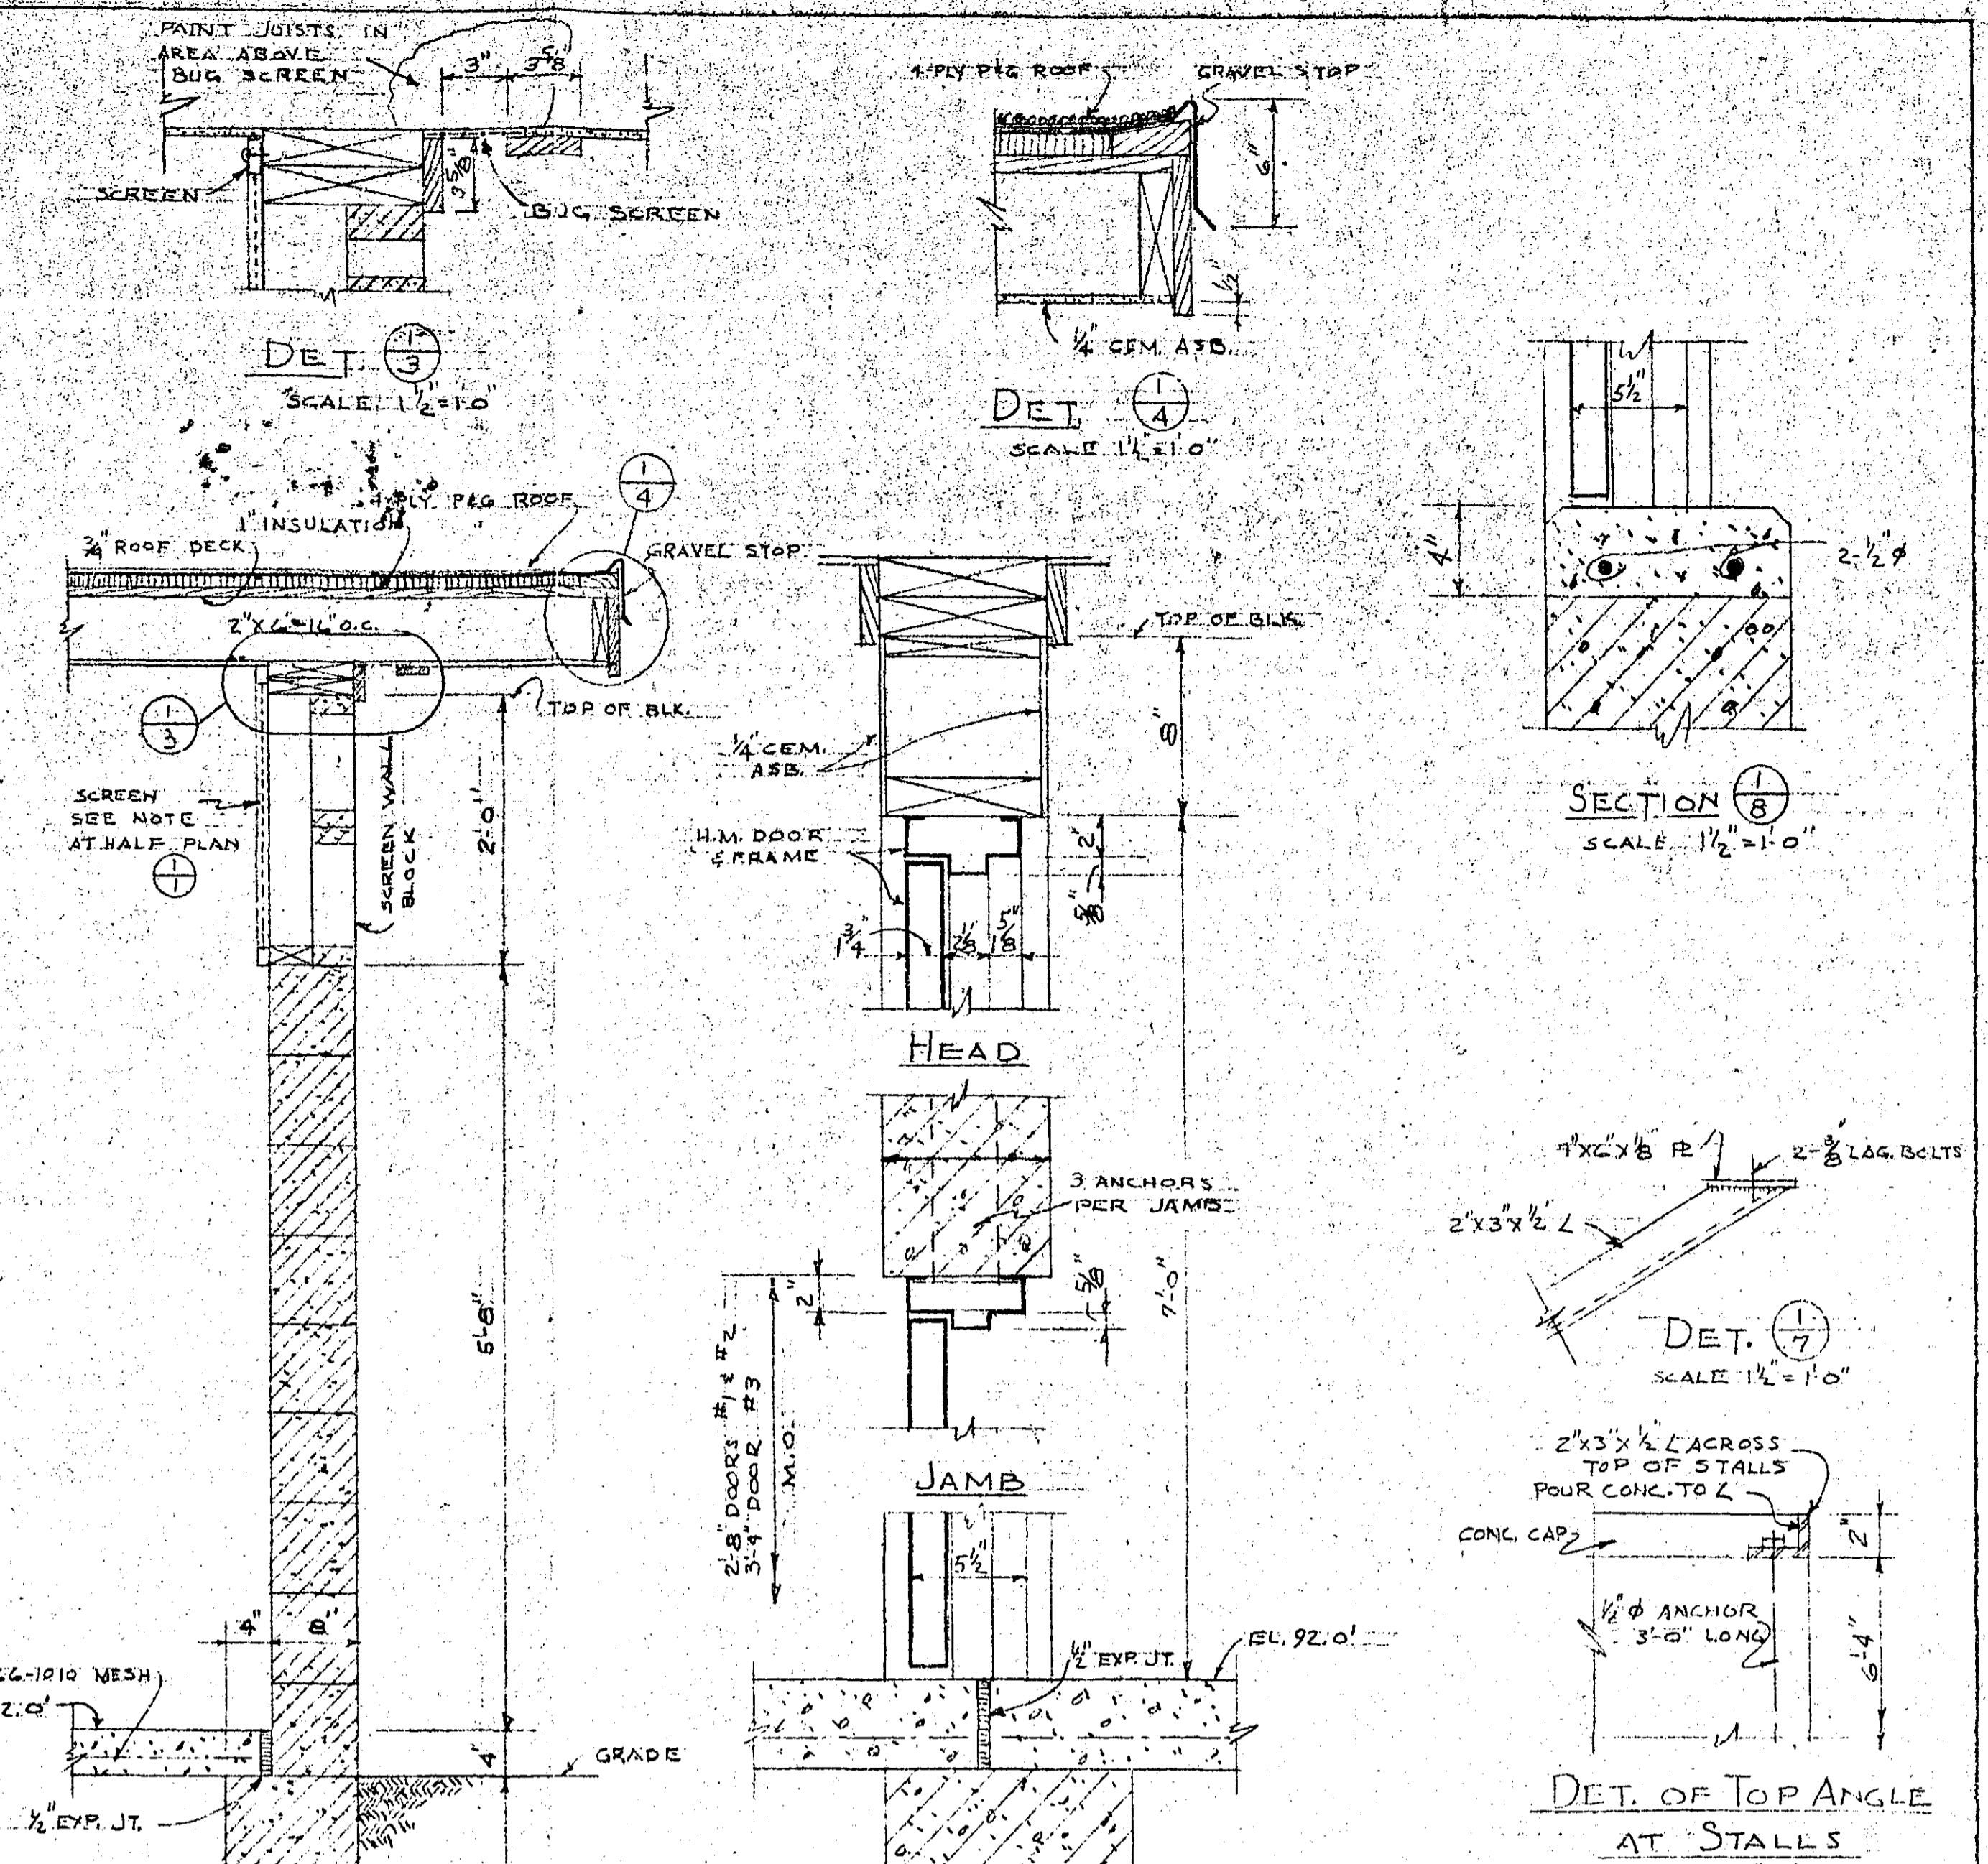
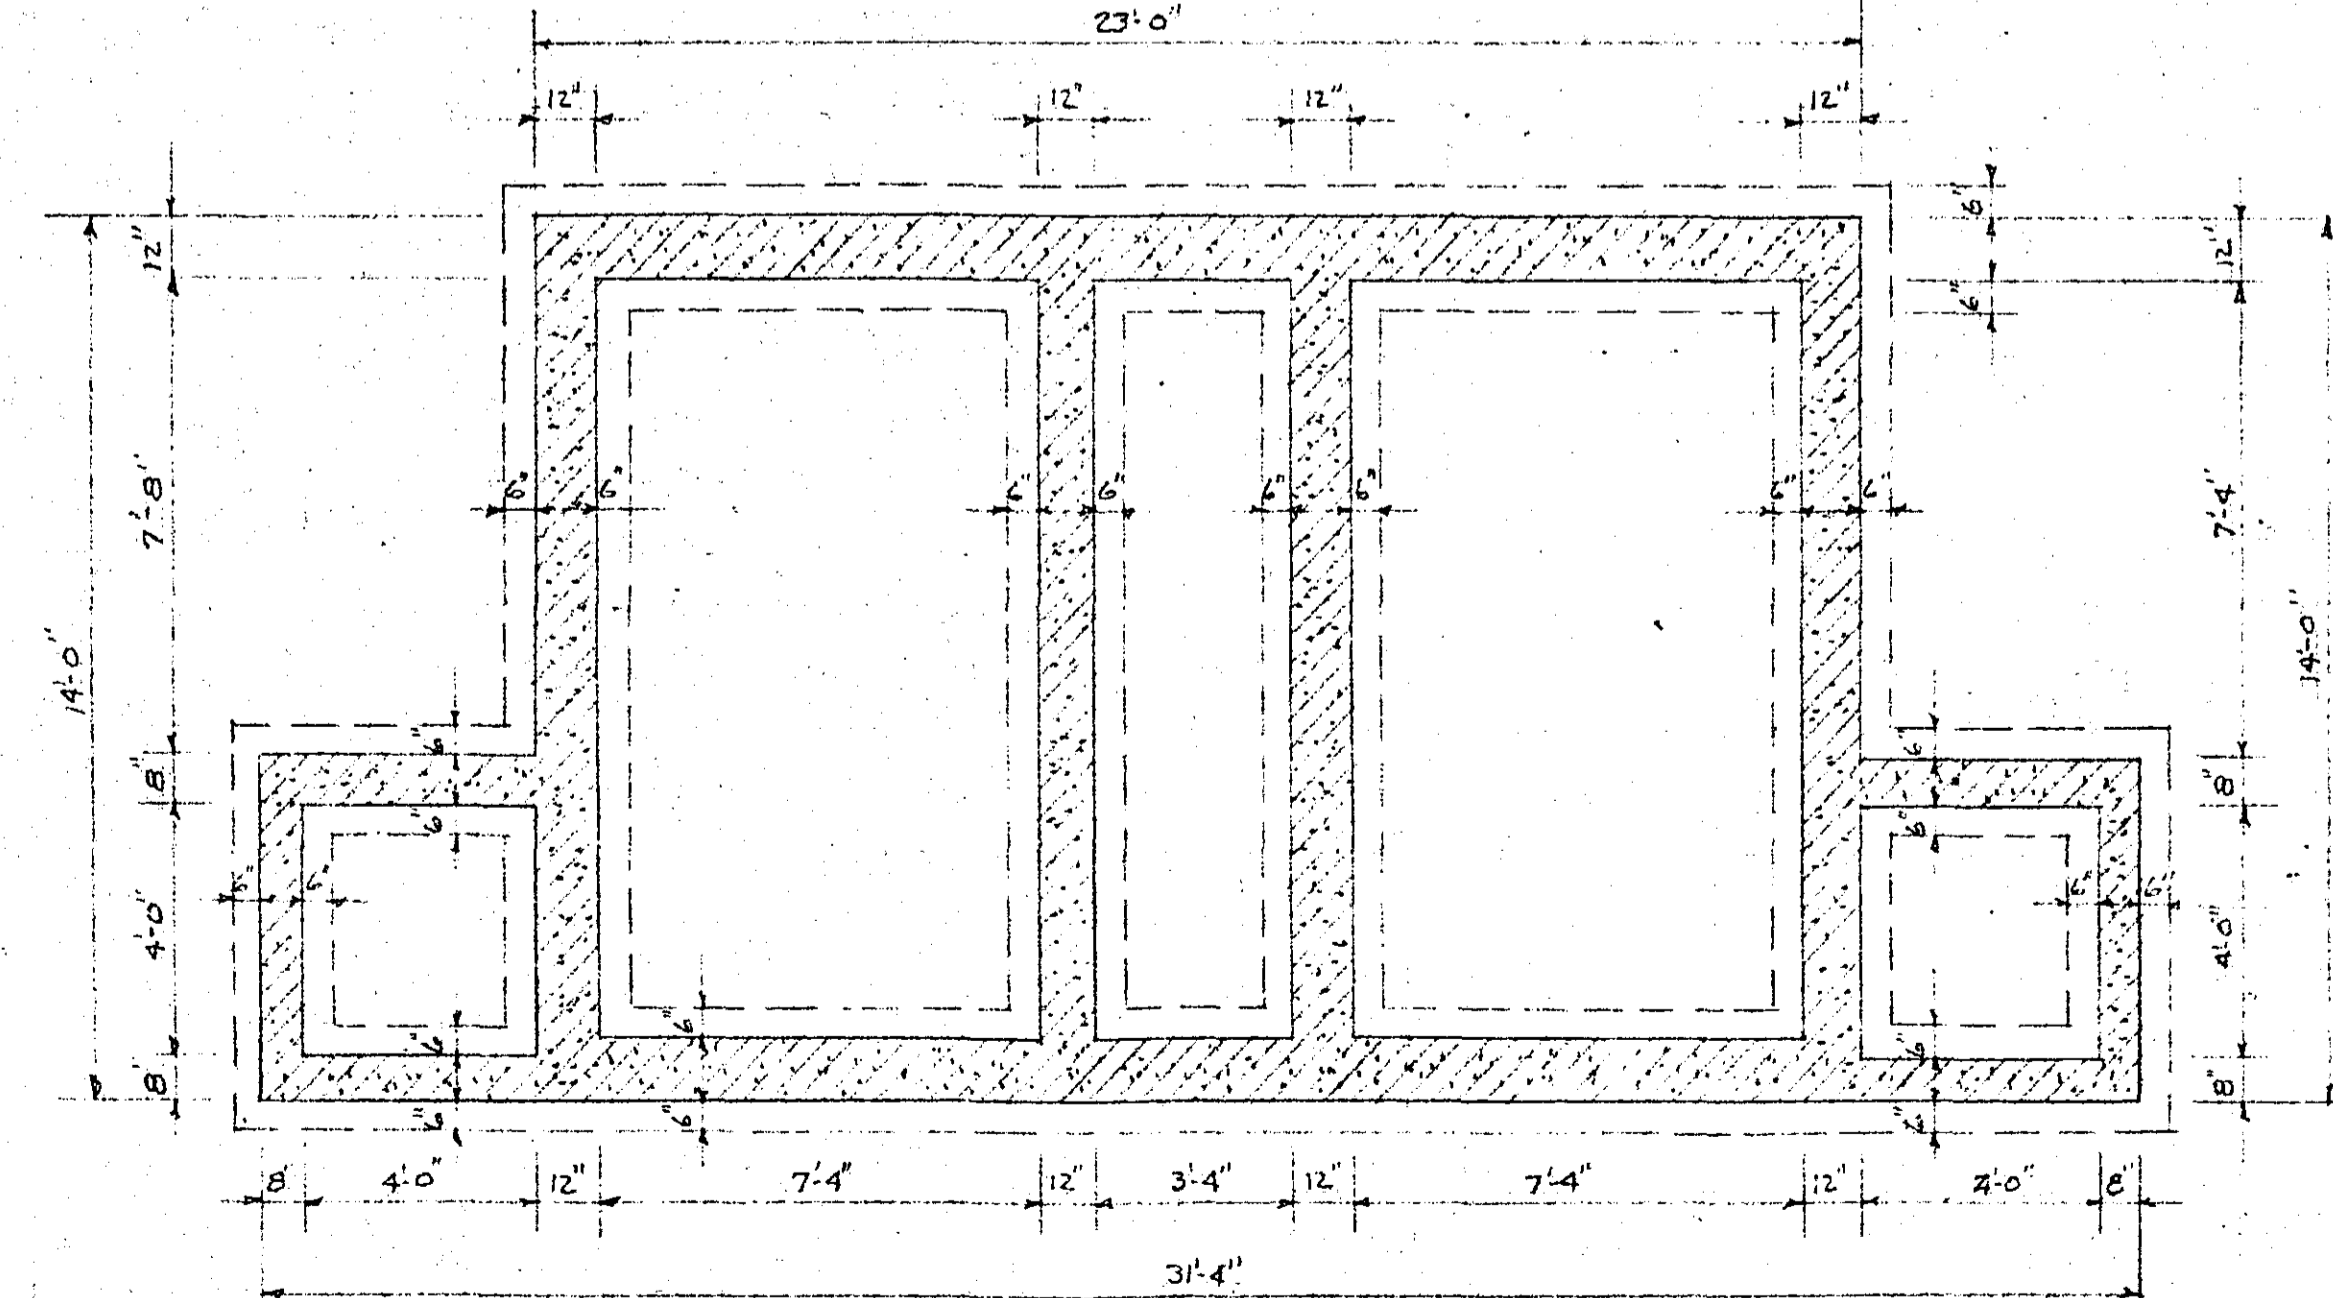
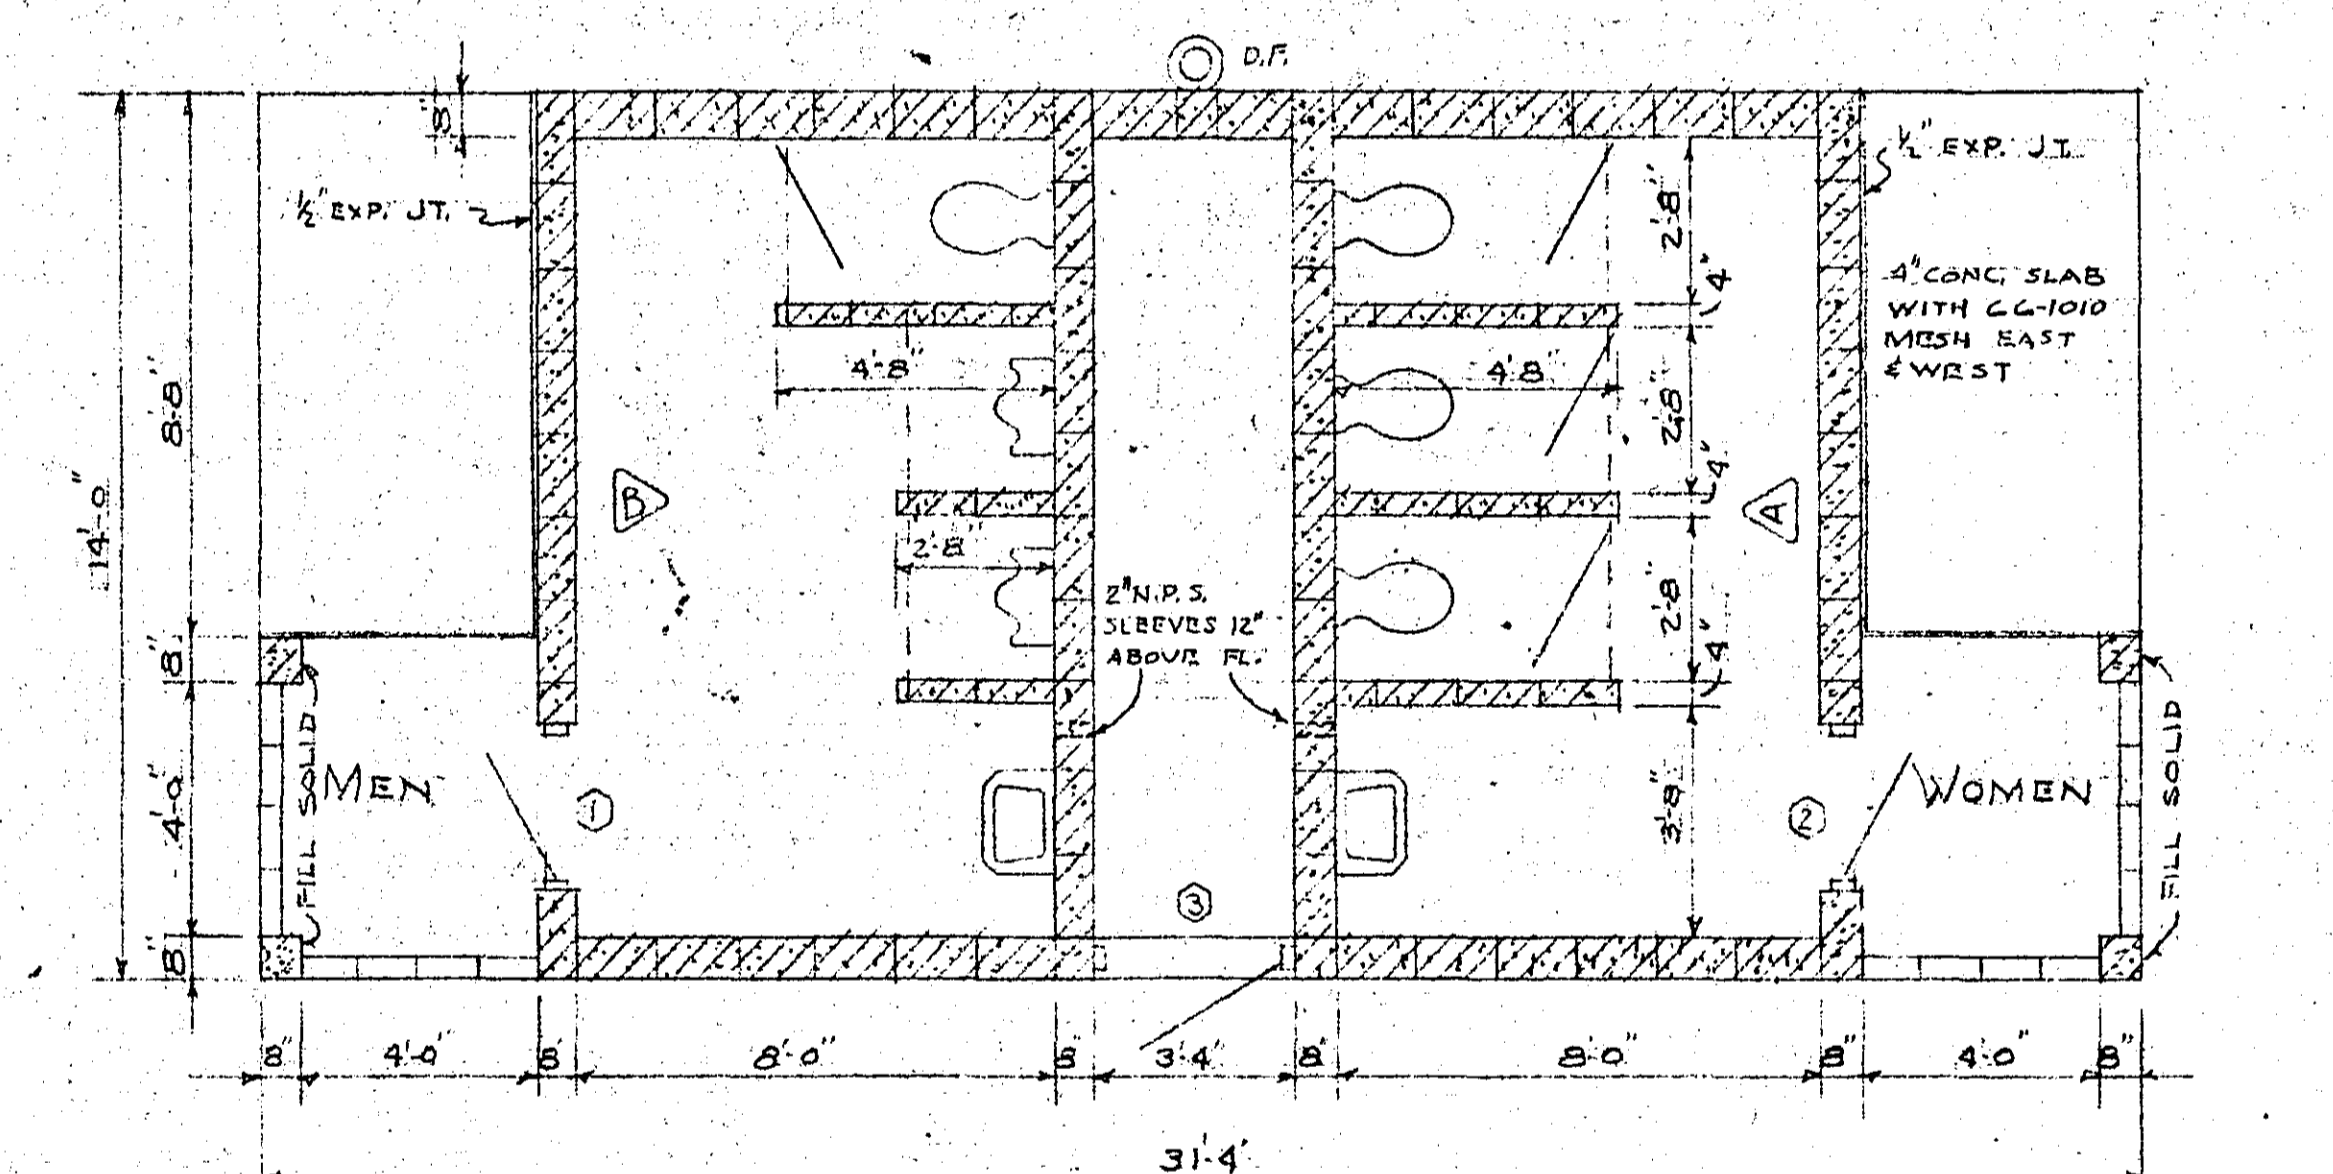
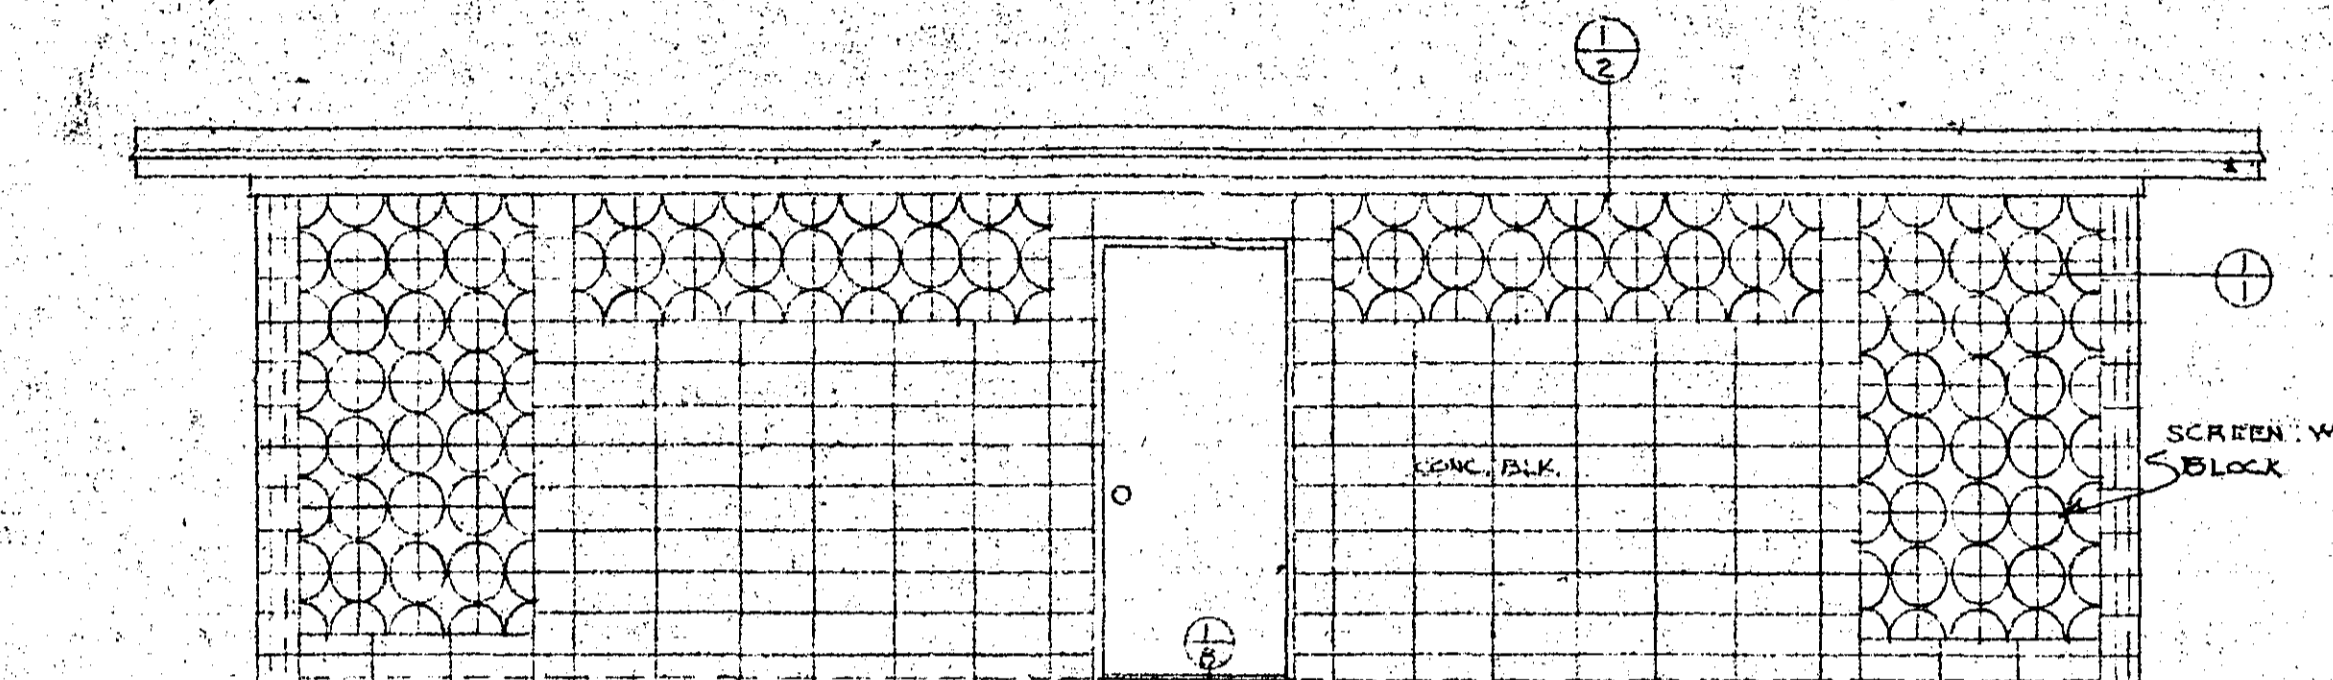
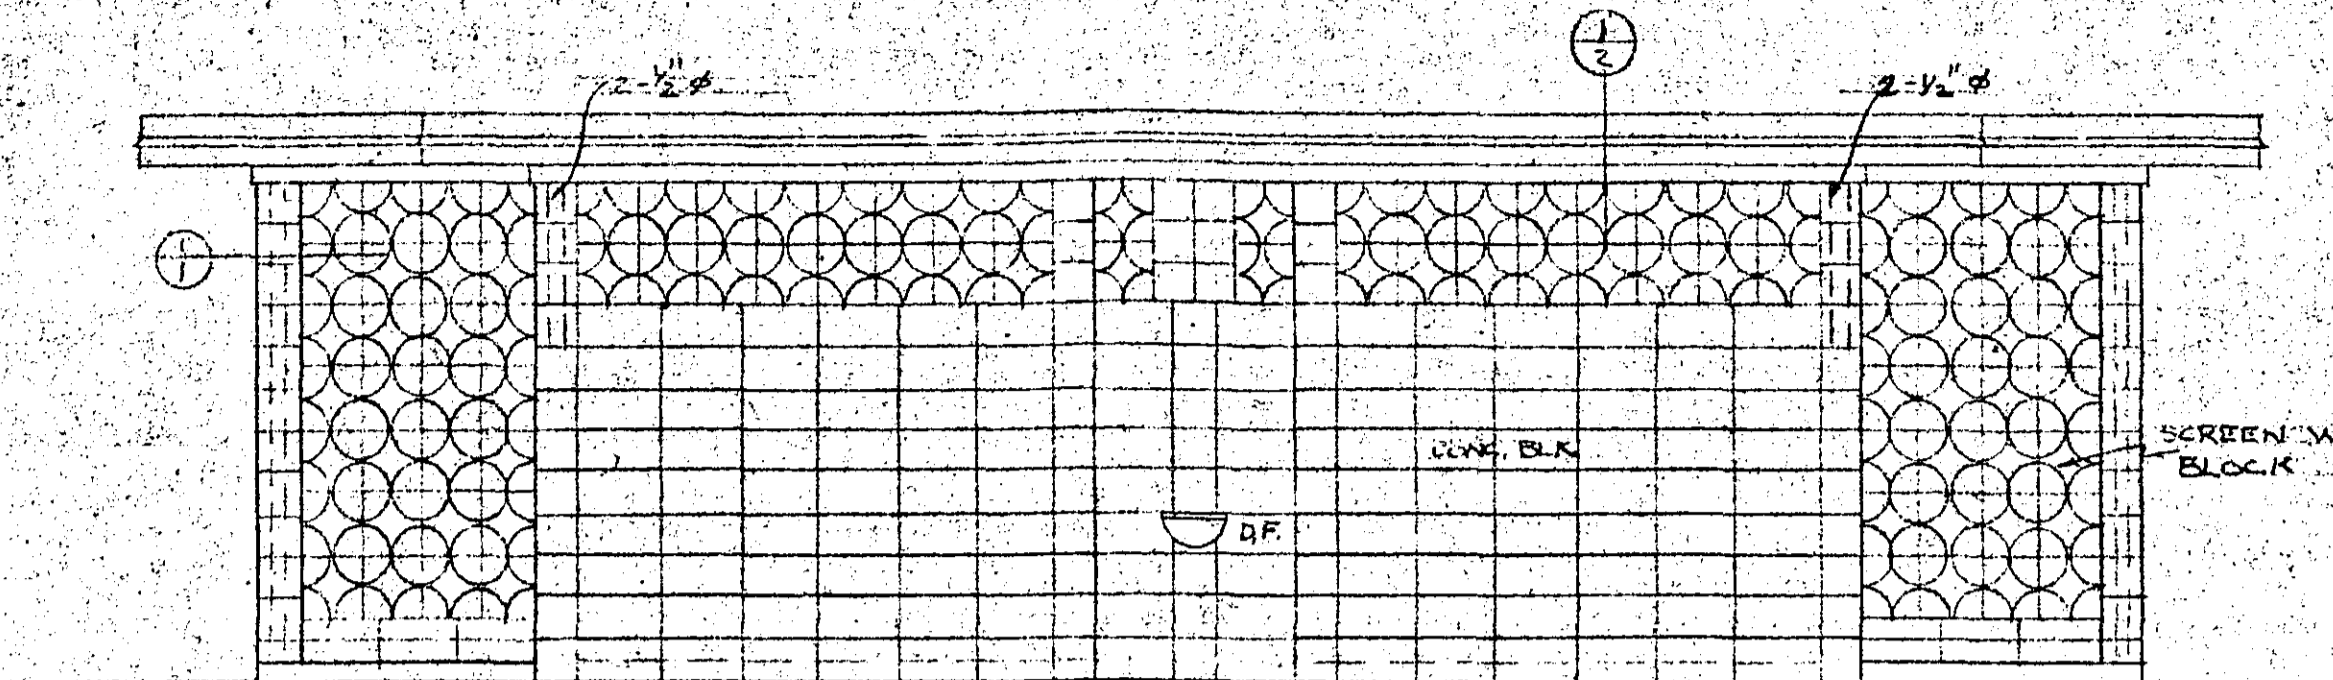


#10

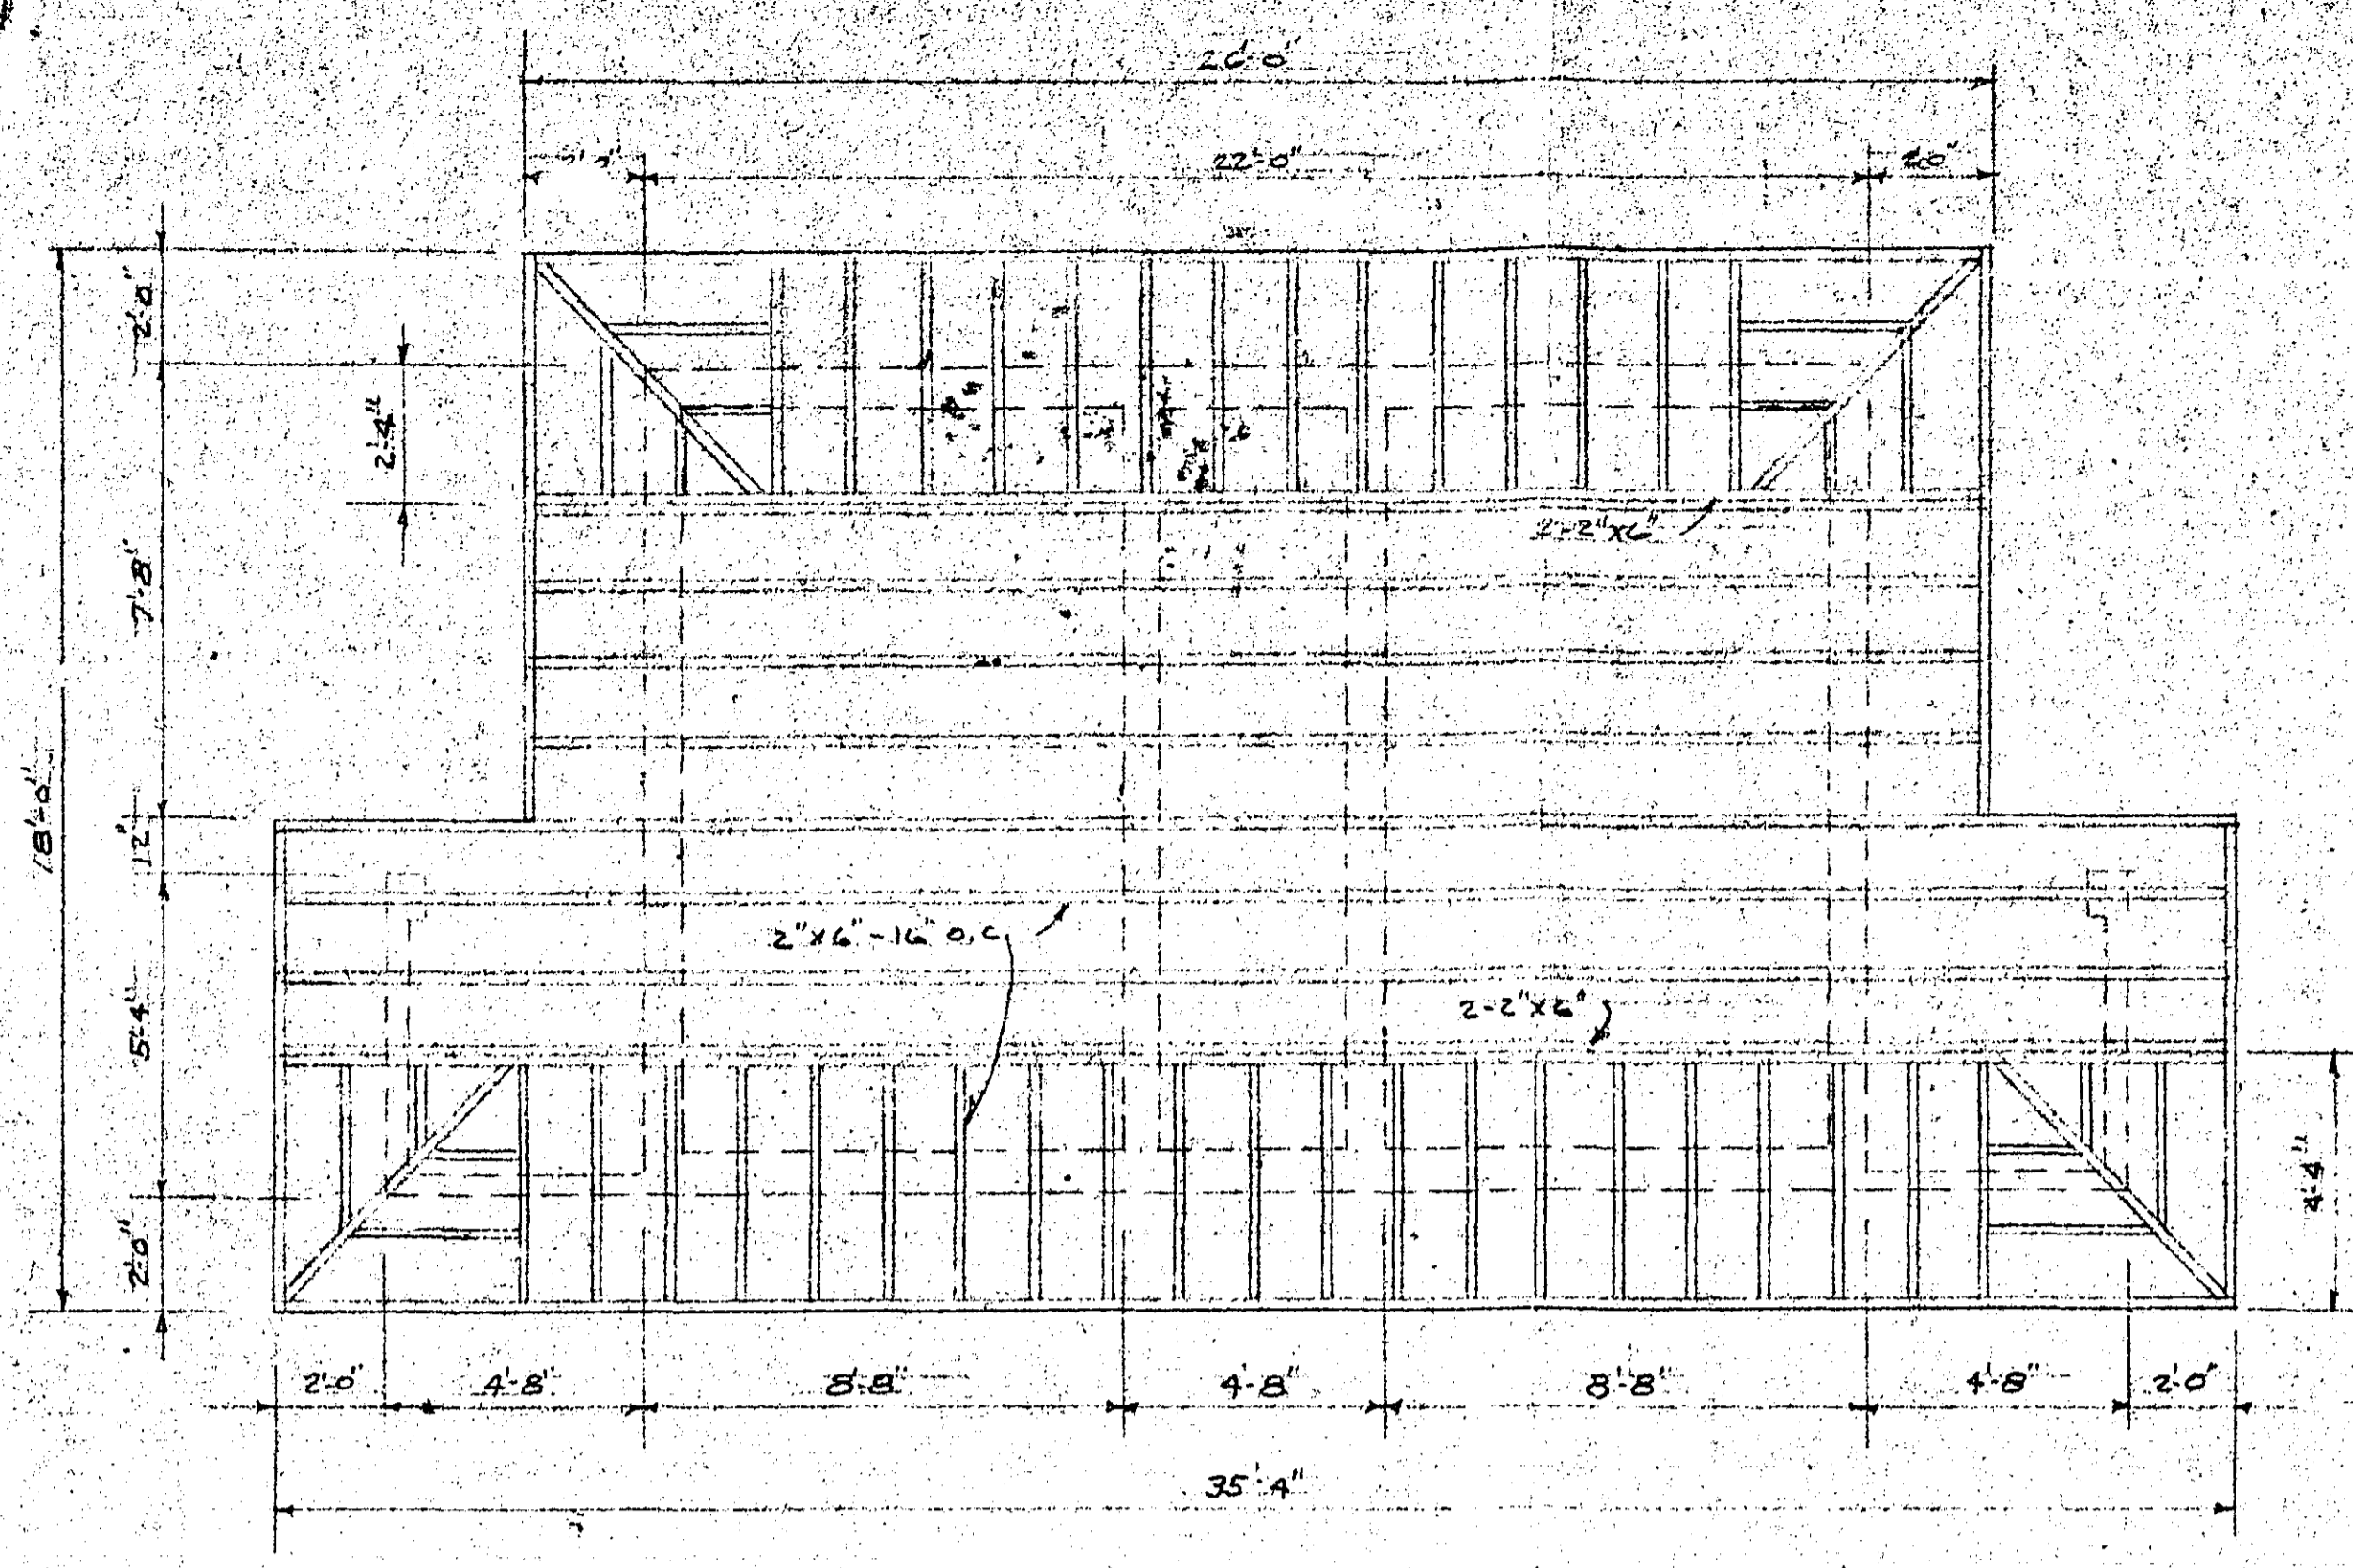


I hereby certify that this plan, specifications, or report was prepared by me or under my direct supervision and that I am duly registered professional engineer under the laws of the State of Minnesota.
Date: 11/18/63 Reg. No. 3015


TOILET BUILDING BELLAIRE BEACH WHITE BEAR LAKE FOR RAMSEY COUNTY CITY OF ST. PAUL				
DATE	REVISIONS	APPR. BY	COMMR.	JOB NO.
AUG. 6 1963				1755
SUPV.	DEPT. OF	DEPT. OF	COMMR.	SHEET
DR. J. J. K.	FRANK L. LOSS	ALFRED H. SCHROEDER	CITY ARCHT.	101

RC-7
File copy R-825


#23

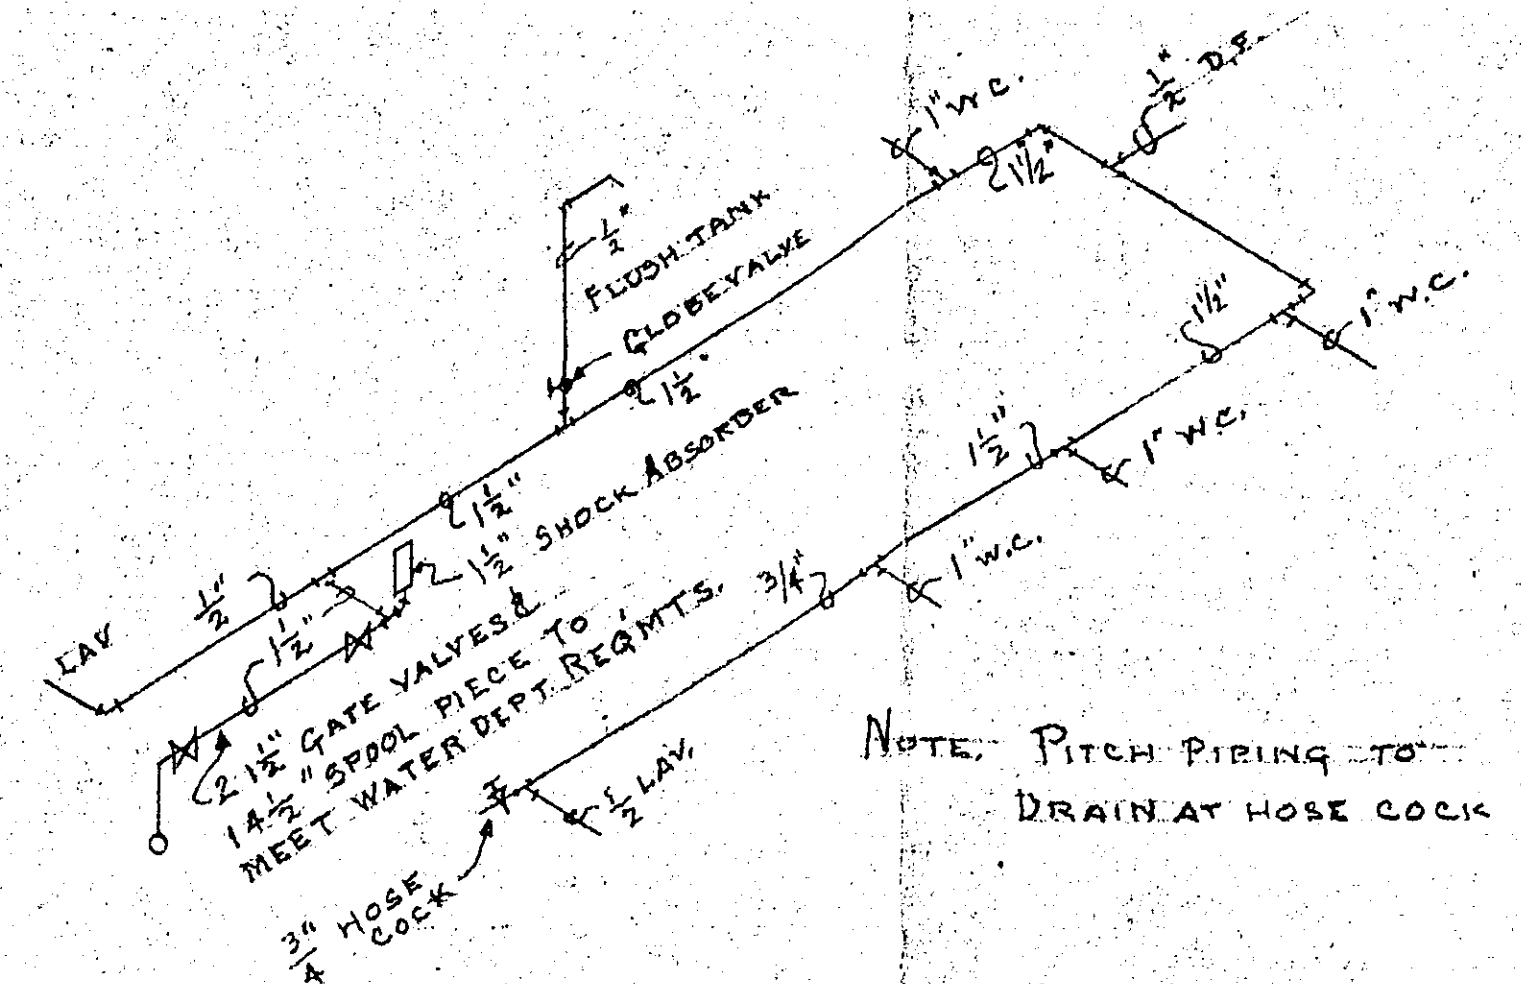


WATER PIPING DIAGRAM
NO SCALE

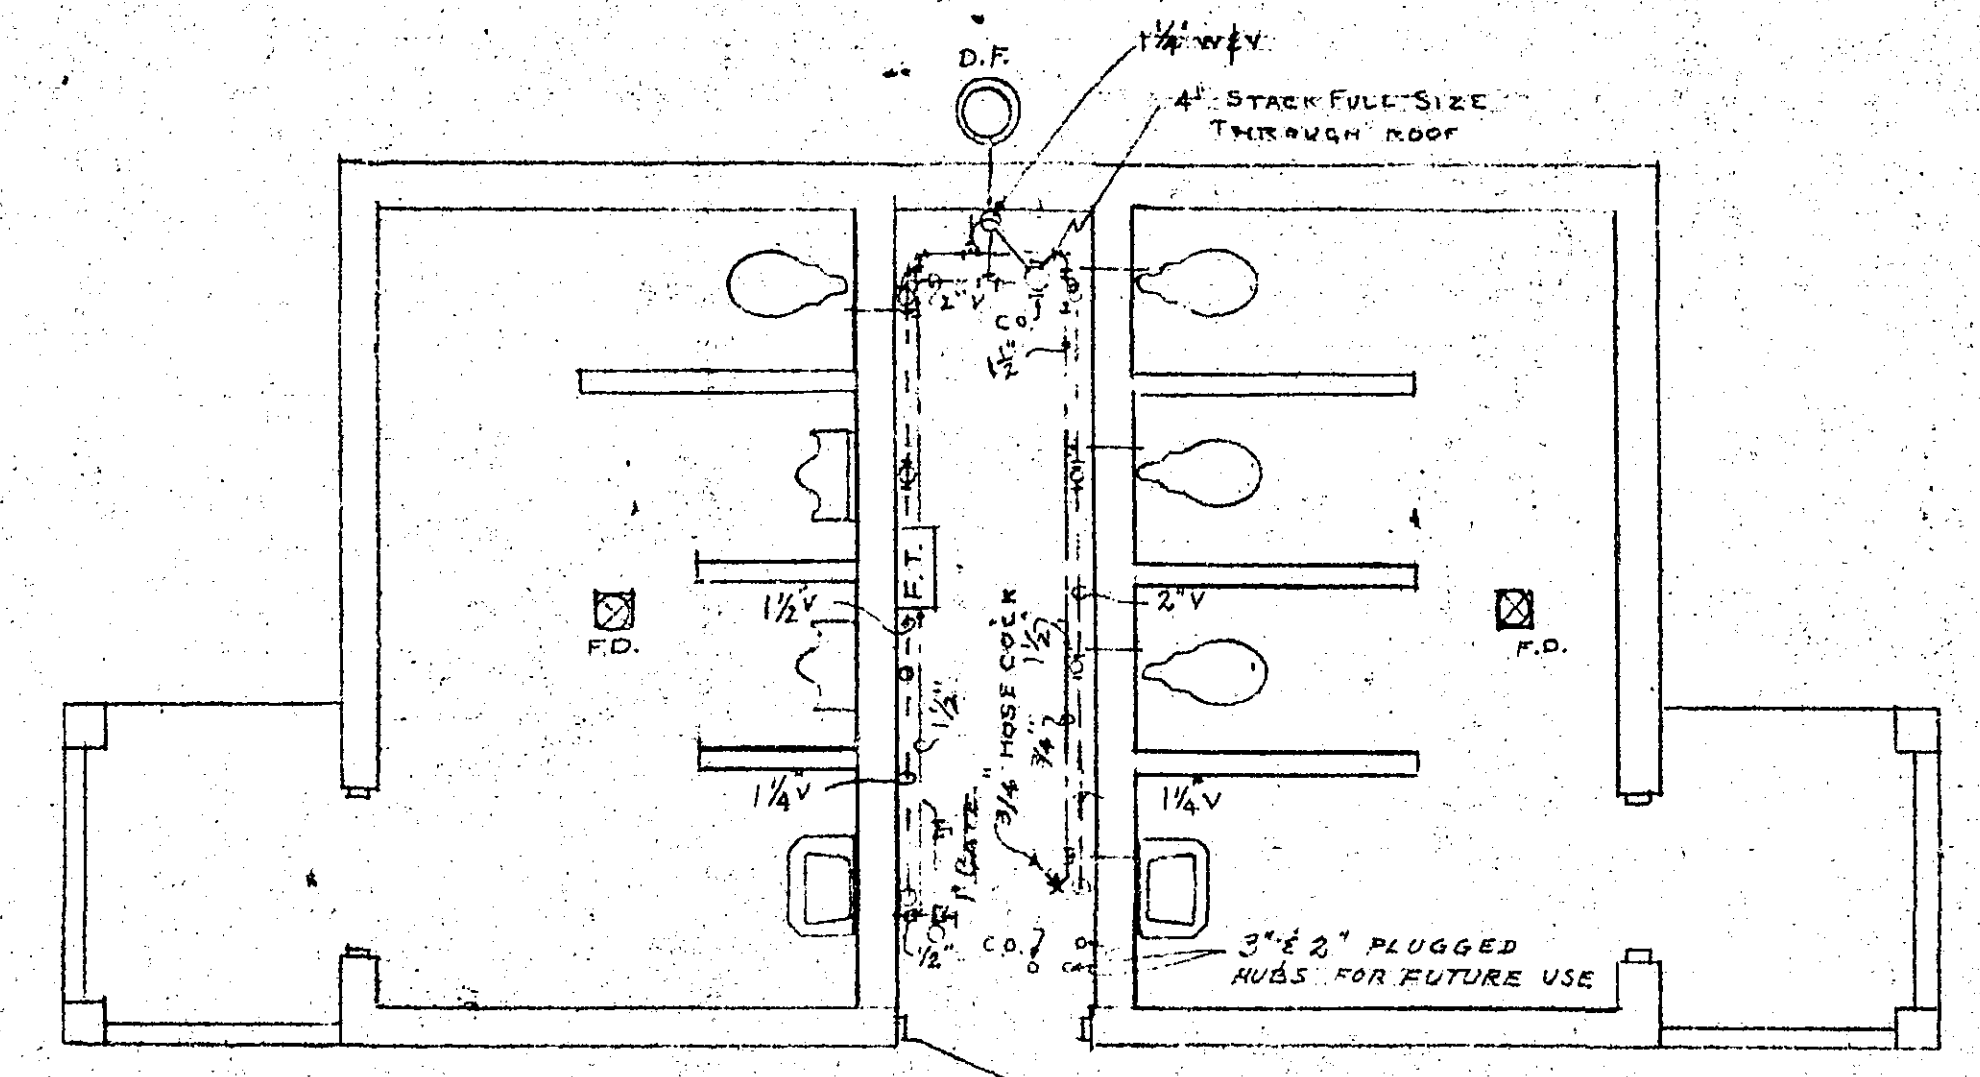


EXPOSED PIPING PLAN
SCALE 1/4"=1'-0"

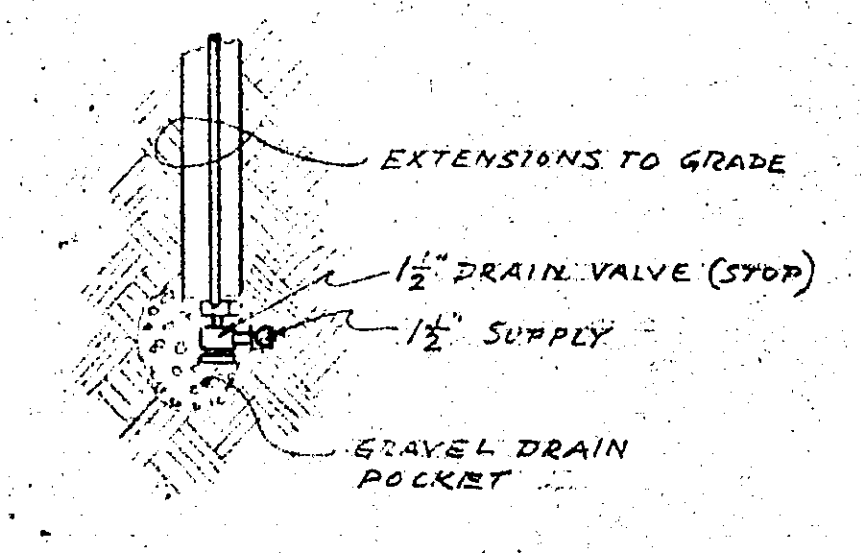


DETAIL AT DRAIN VALVE
NO SCALE

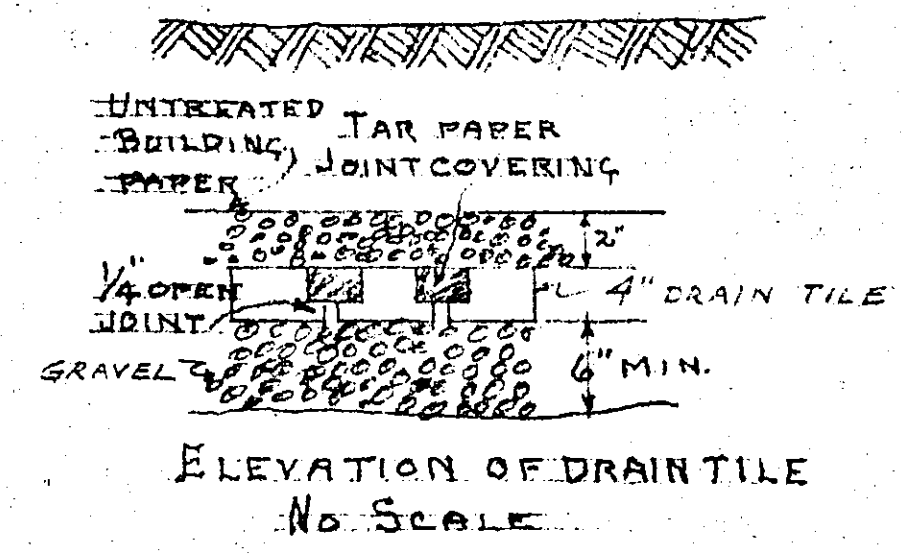


ELEVATION OF DRAINTILE
NO SCALE

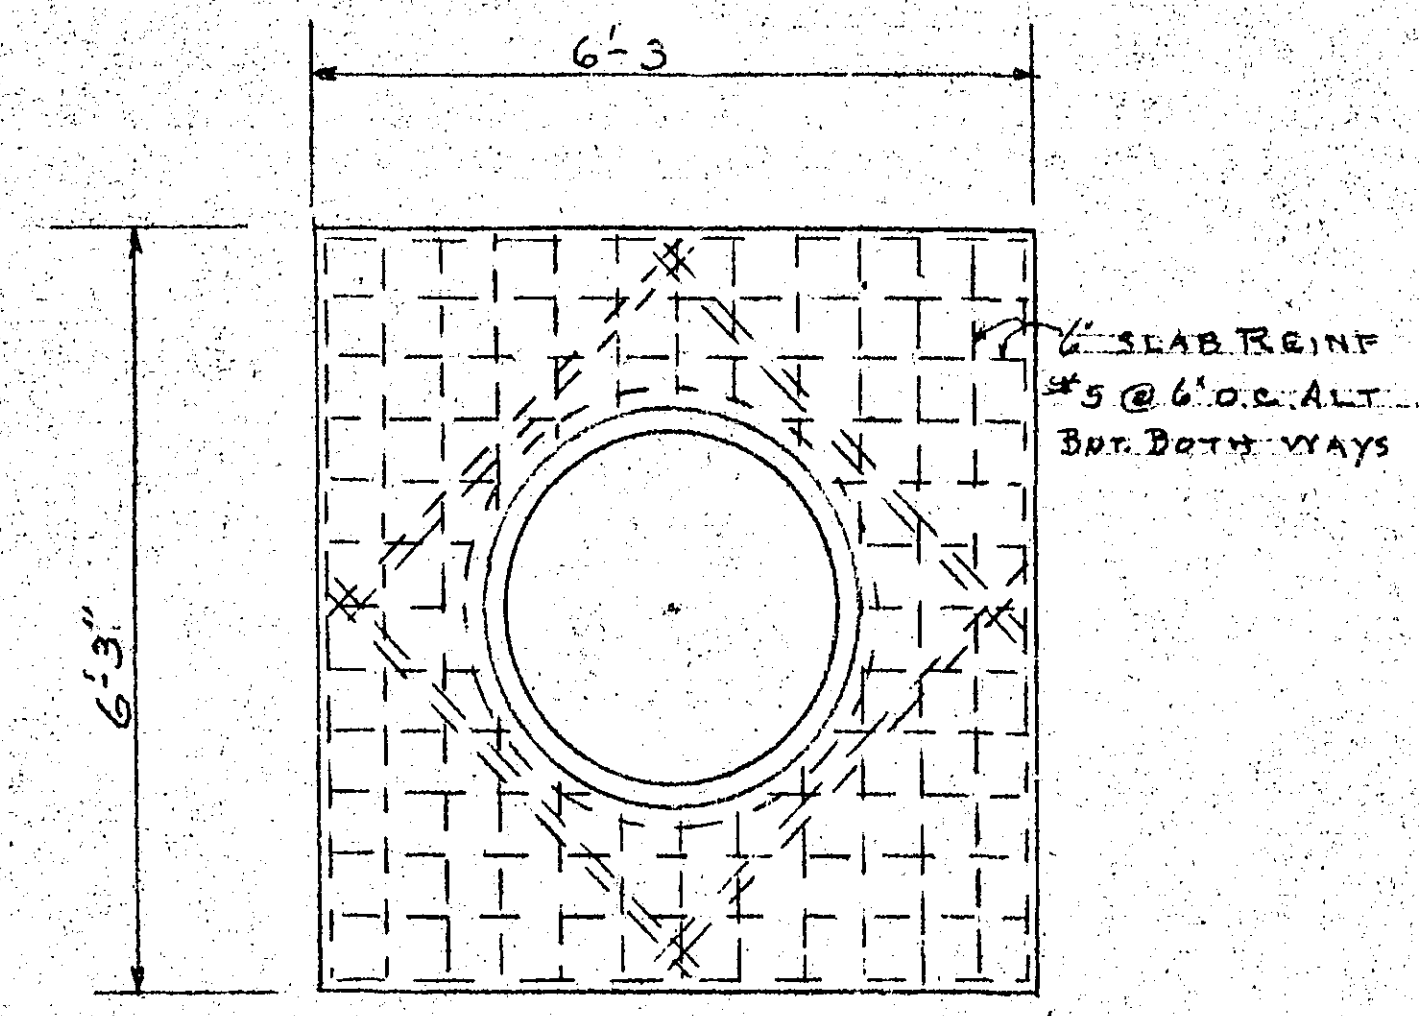


PLAN OF TOP SLAB

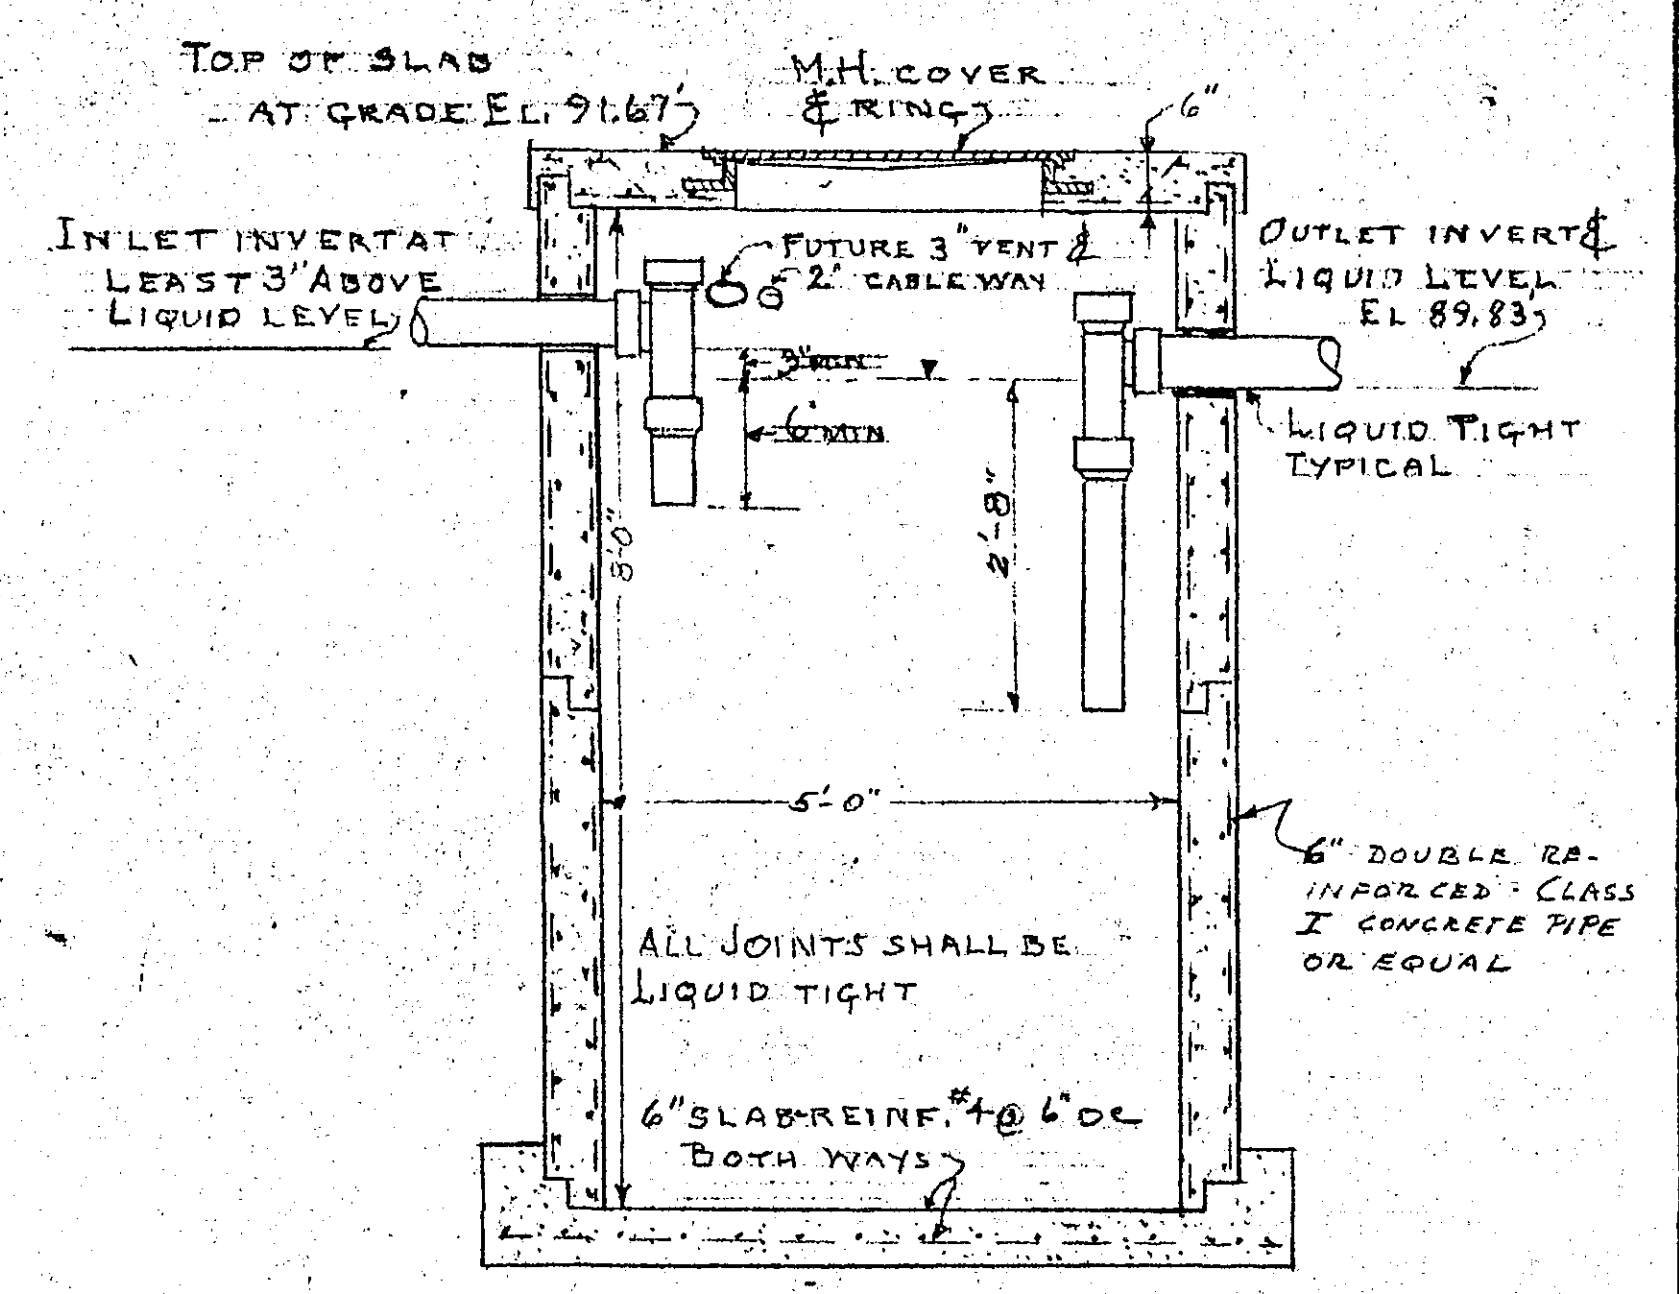


DETAIL OF SEPTIC TANK
SCALE 1/2"=1'-0"

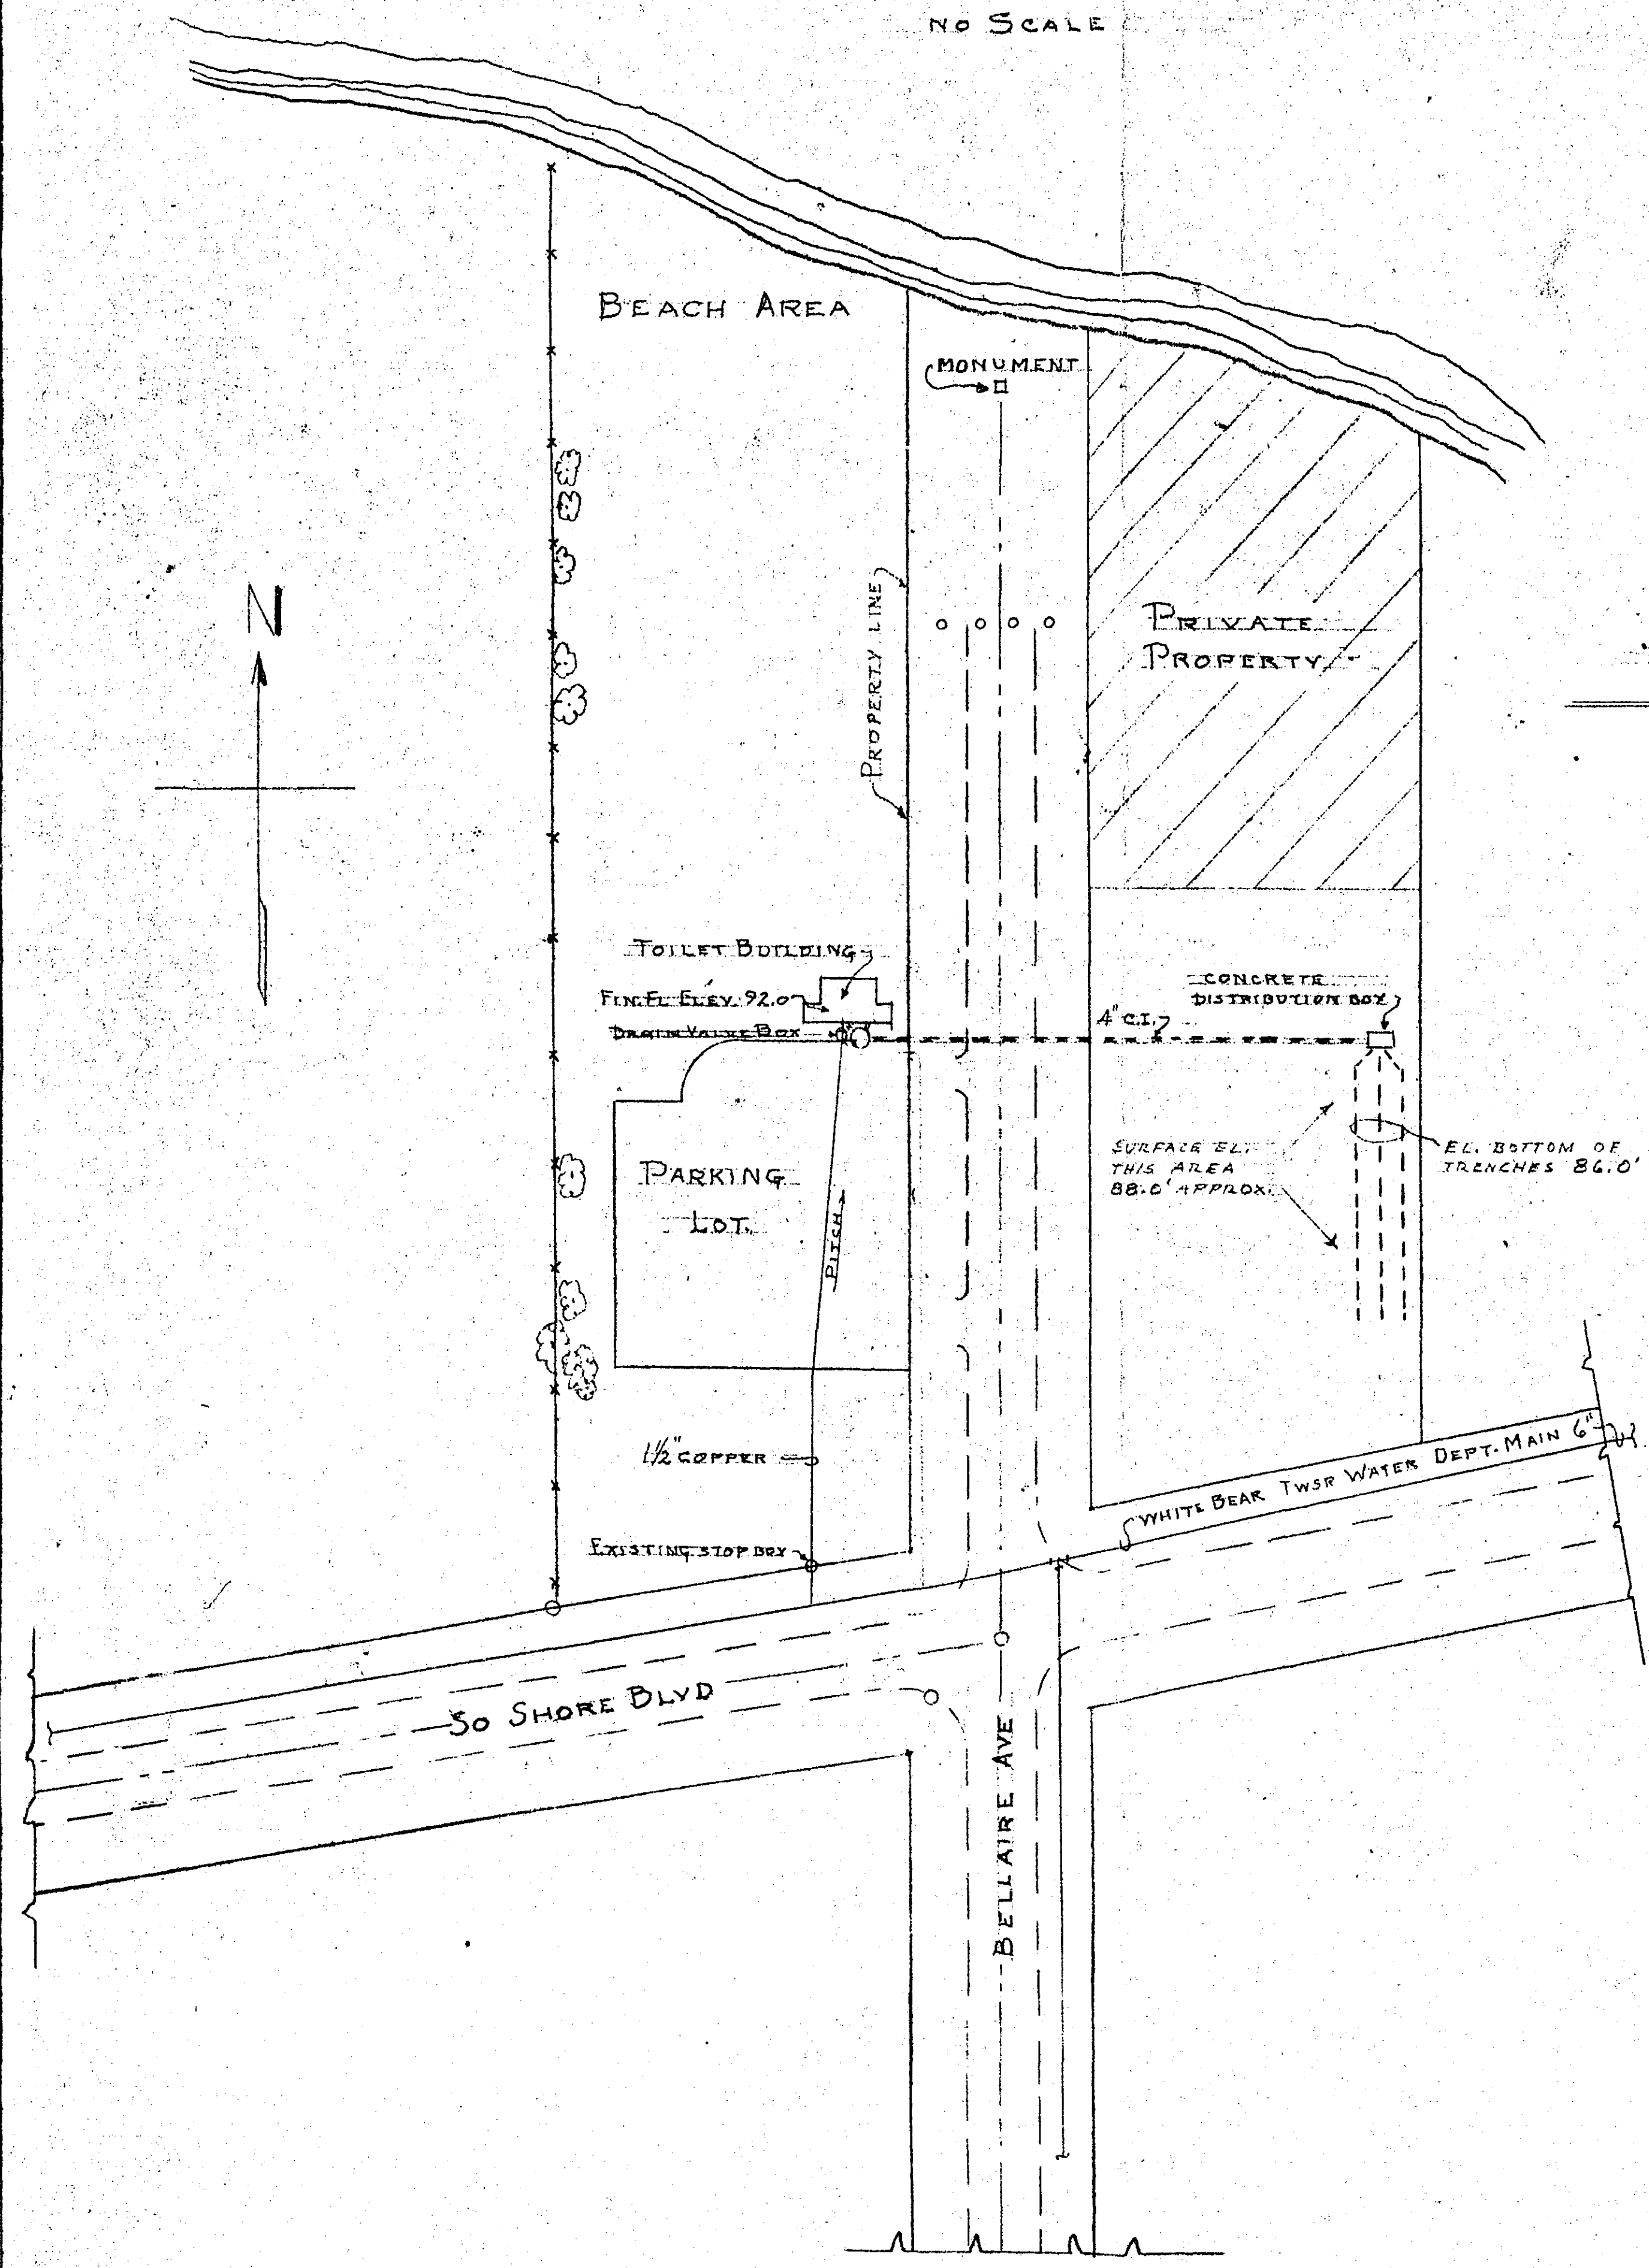

PLOT PLAN
BELLAIRE PARK
SCALE 1"=50'-0"

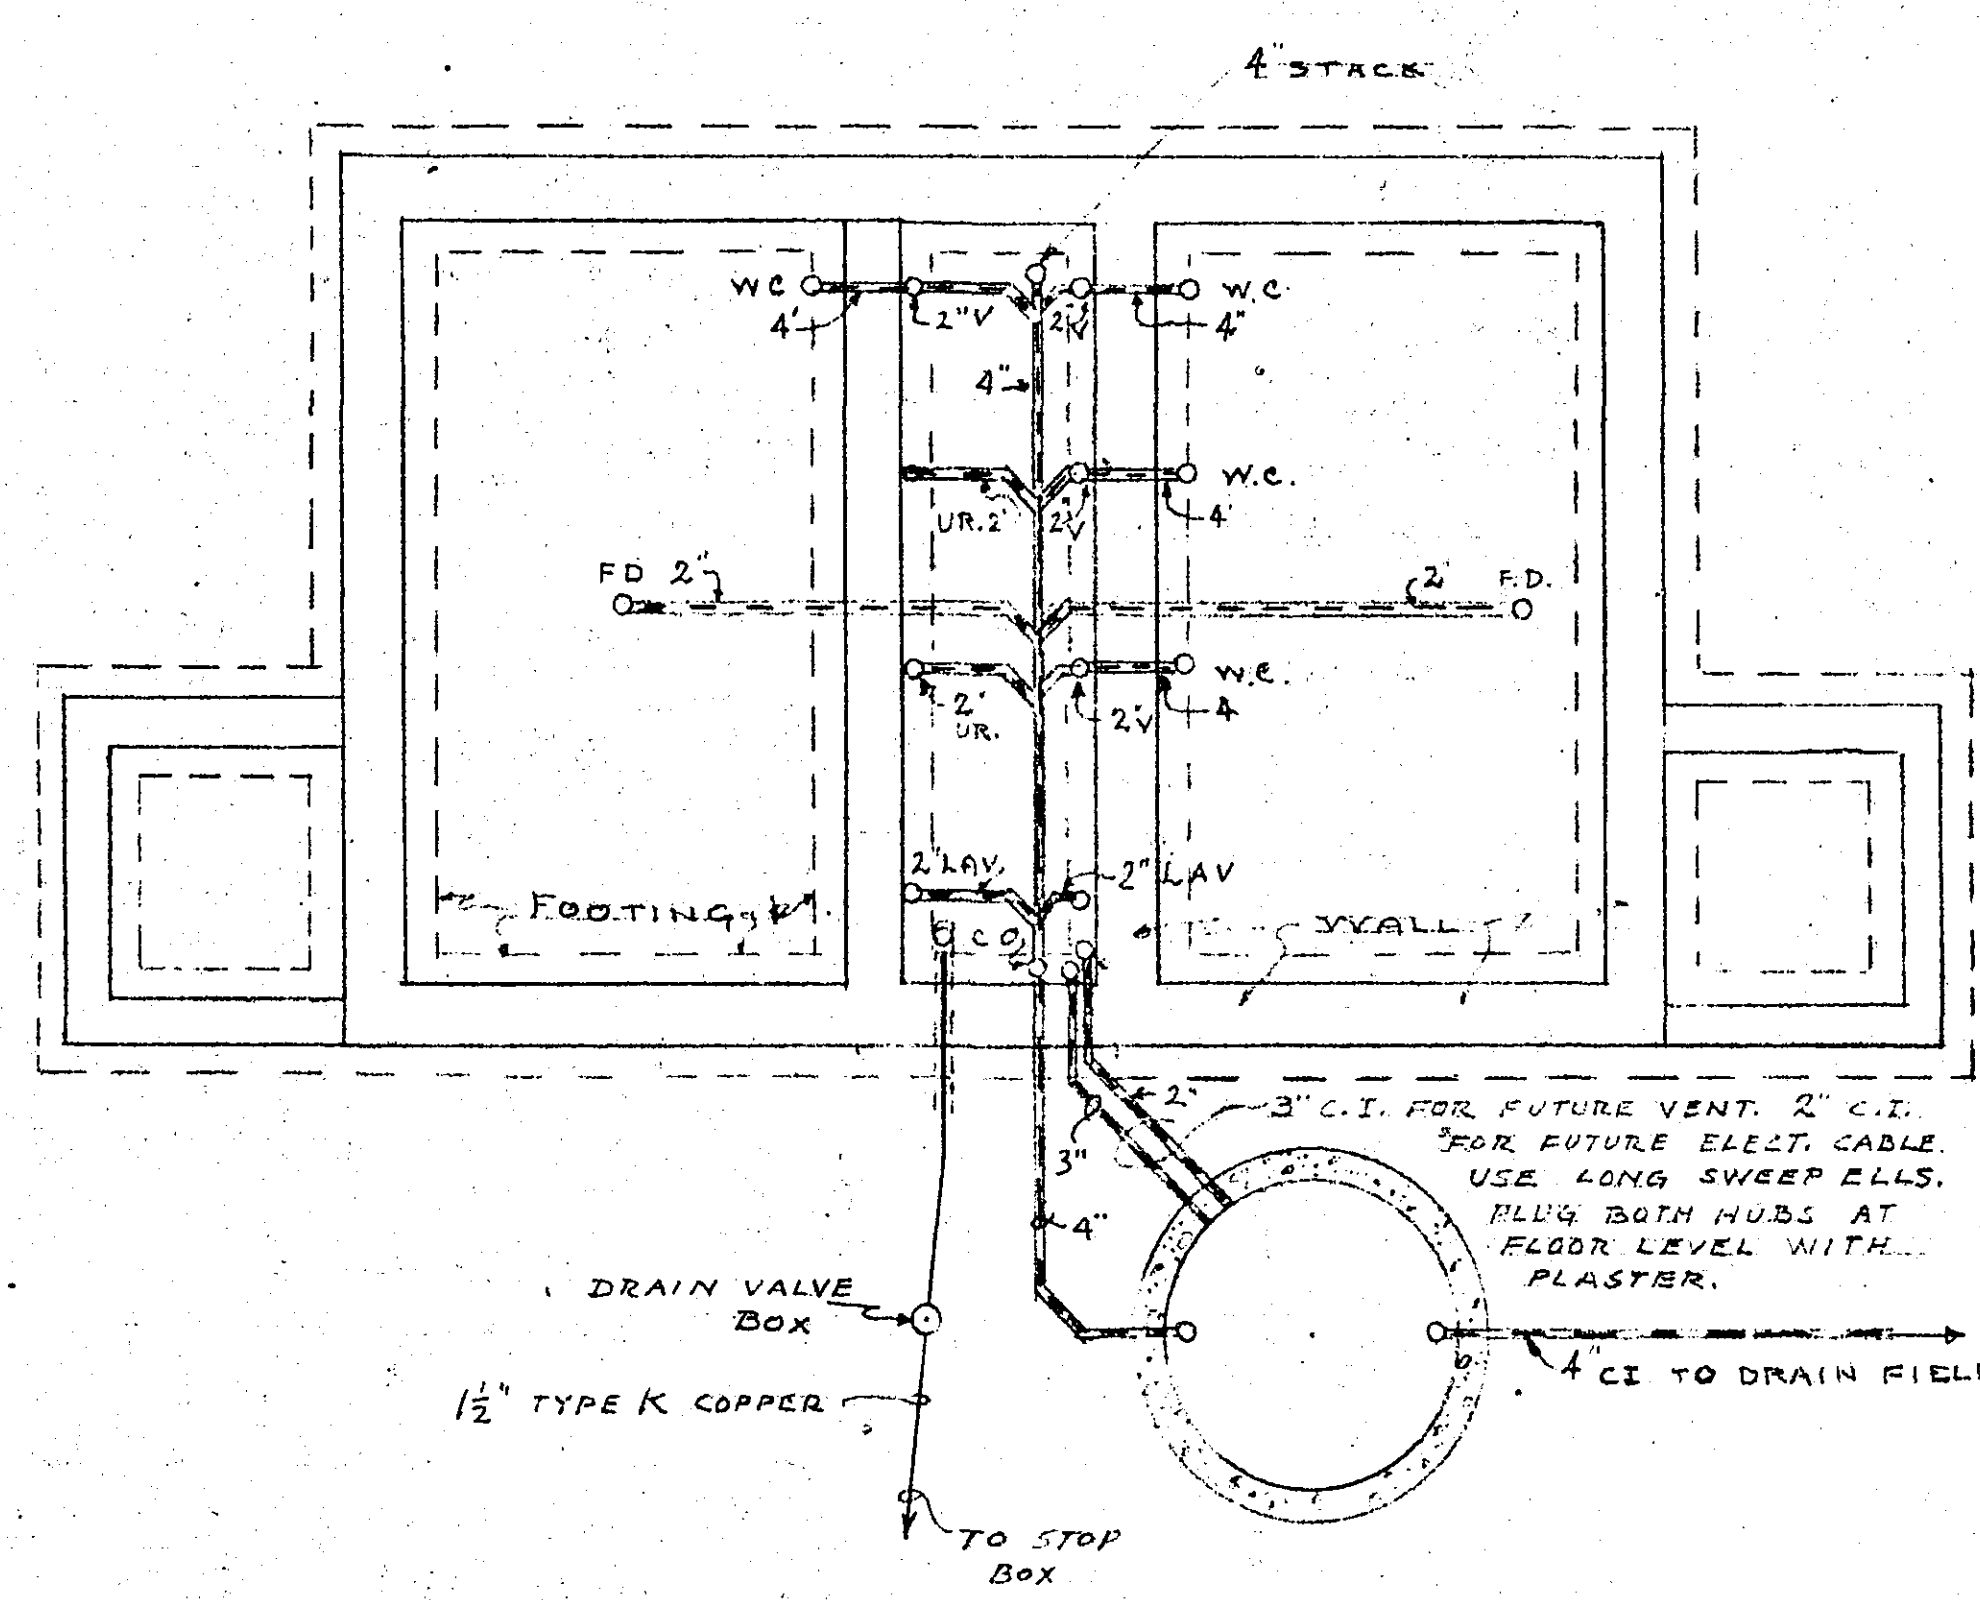

UNDER GROUND PLUMBING PLAN
SCALE 1/4"=1'-0"

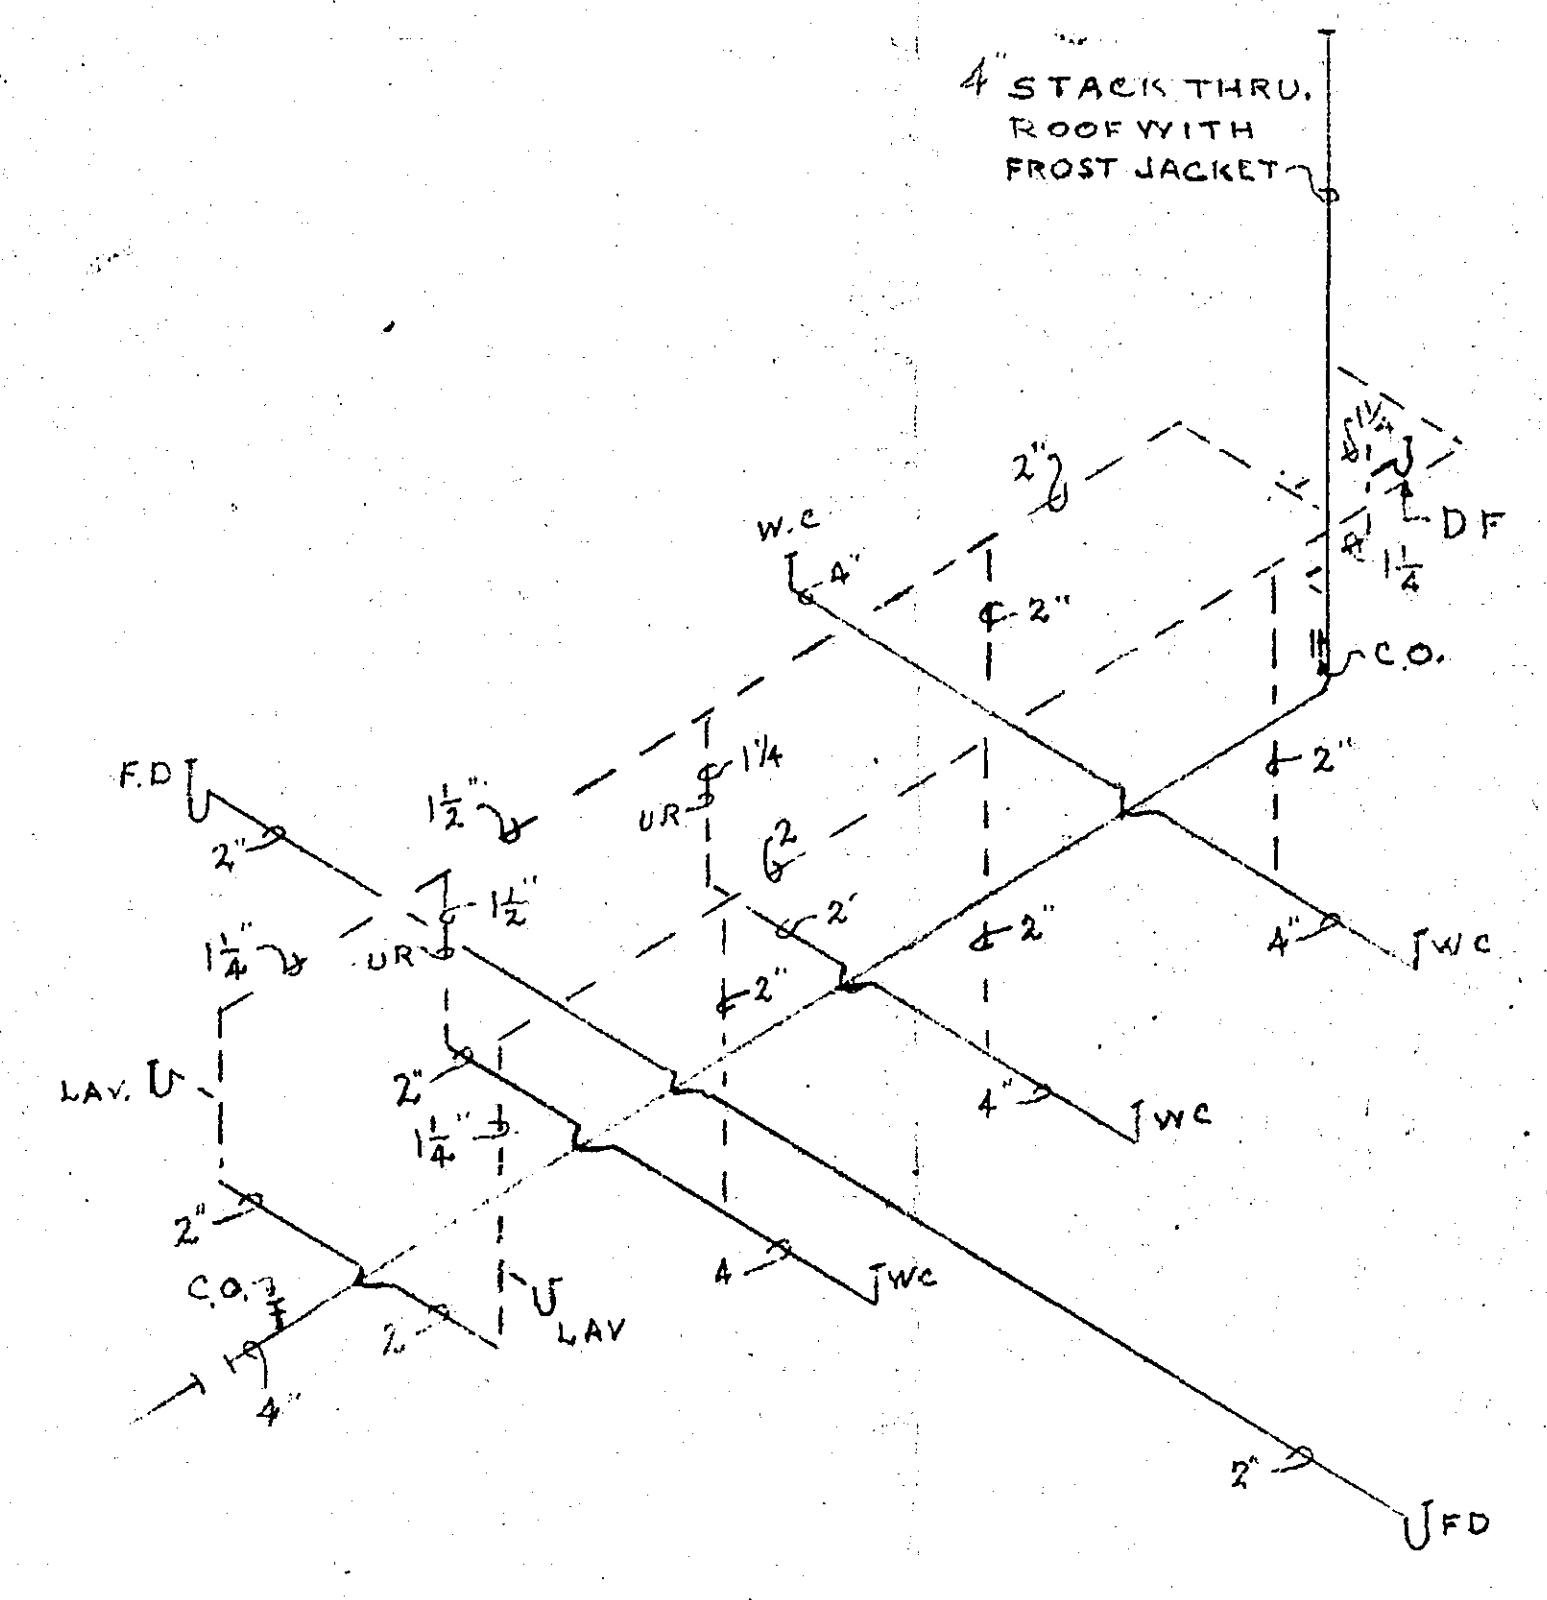

WASTE & VENT PIPING DIAGRAM
NO SCALE

NOTE
CONTRACTOR SHALL VERIFY ALL DIMENSION AND CONDITION ON JOB BEFORE PLACING BID.

I hereby certify that this plan, specifications, or report was prepared by me or under my direct supervision and that I am duly registered professional engineer under the laws of the State of Minnesota.
Date 11/20/62 Rtg No. 4460

BELLAIRES BEACH WHITE BEAR LAKE RAMSEY COUNTY MINN. CITY OF ST. PAUL		JOB NO. 1735M
DATE 11-26-62	REVISIONS	APPR. BY FRANK LESS
DEPT. OF DEPT. OF PARKS, PLAYGRDS. & PUB. BLDGS.		CITY ADMPT
SHEET 2		
SHEETS 1		